

M2

PROJECT NO. 10-110


DATE: 10/1/52

DESIGNED BY: J. CLARENCE FELICIANO, AIA

CHECKED BY: J. SCHUYLER L. JEFFRIES, AIA & ASSOCIATES

SCALE: 1/8" = 1'-0"

CITY-COUNTY OFFICE BUILDING ADDITION
TO THE PETALUMA CITY HALL
PETALUMA, CALIFORNIA
J. CLARENCE FELICIANO, AIA - SCHUYLER L. JEFFRIES, AIA & ASSOCIATES - ARCHITECTS - PLANNERS
 4015 MONTECITO AVENUE
 SAN FRANCISCO, CALIFORNIA 94104
 (415) 398-4832

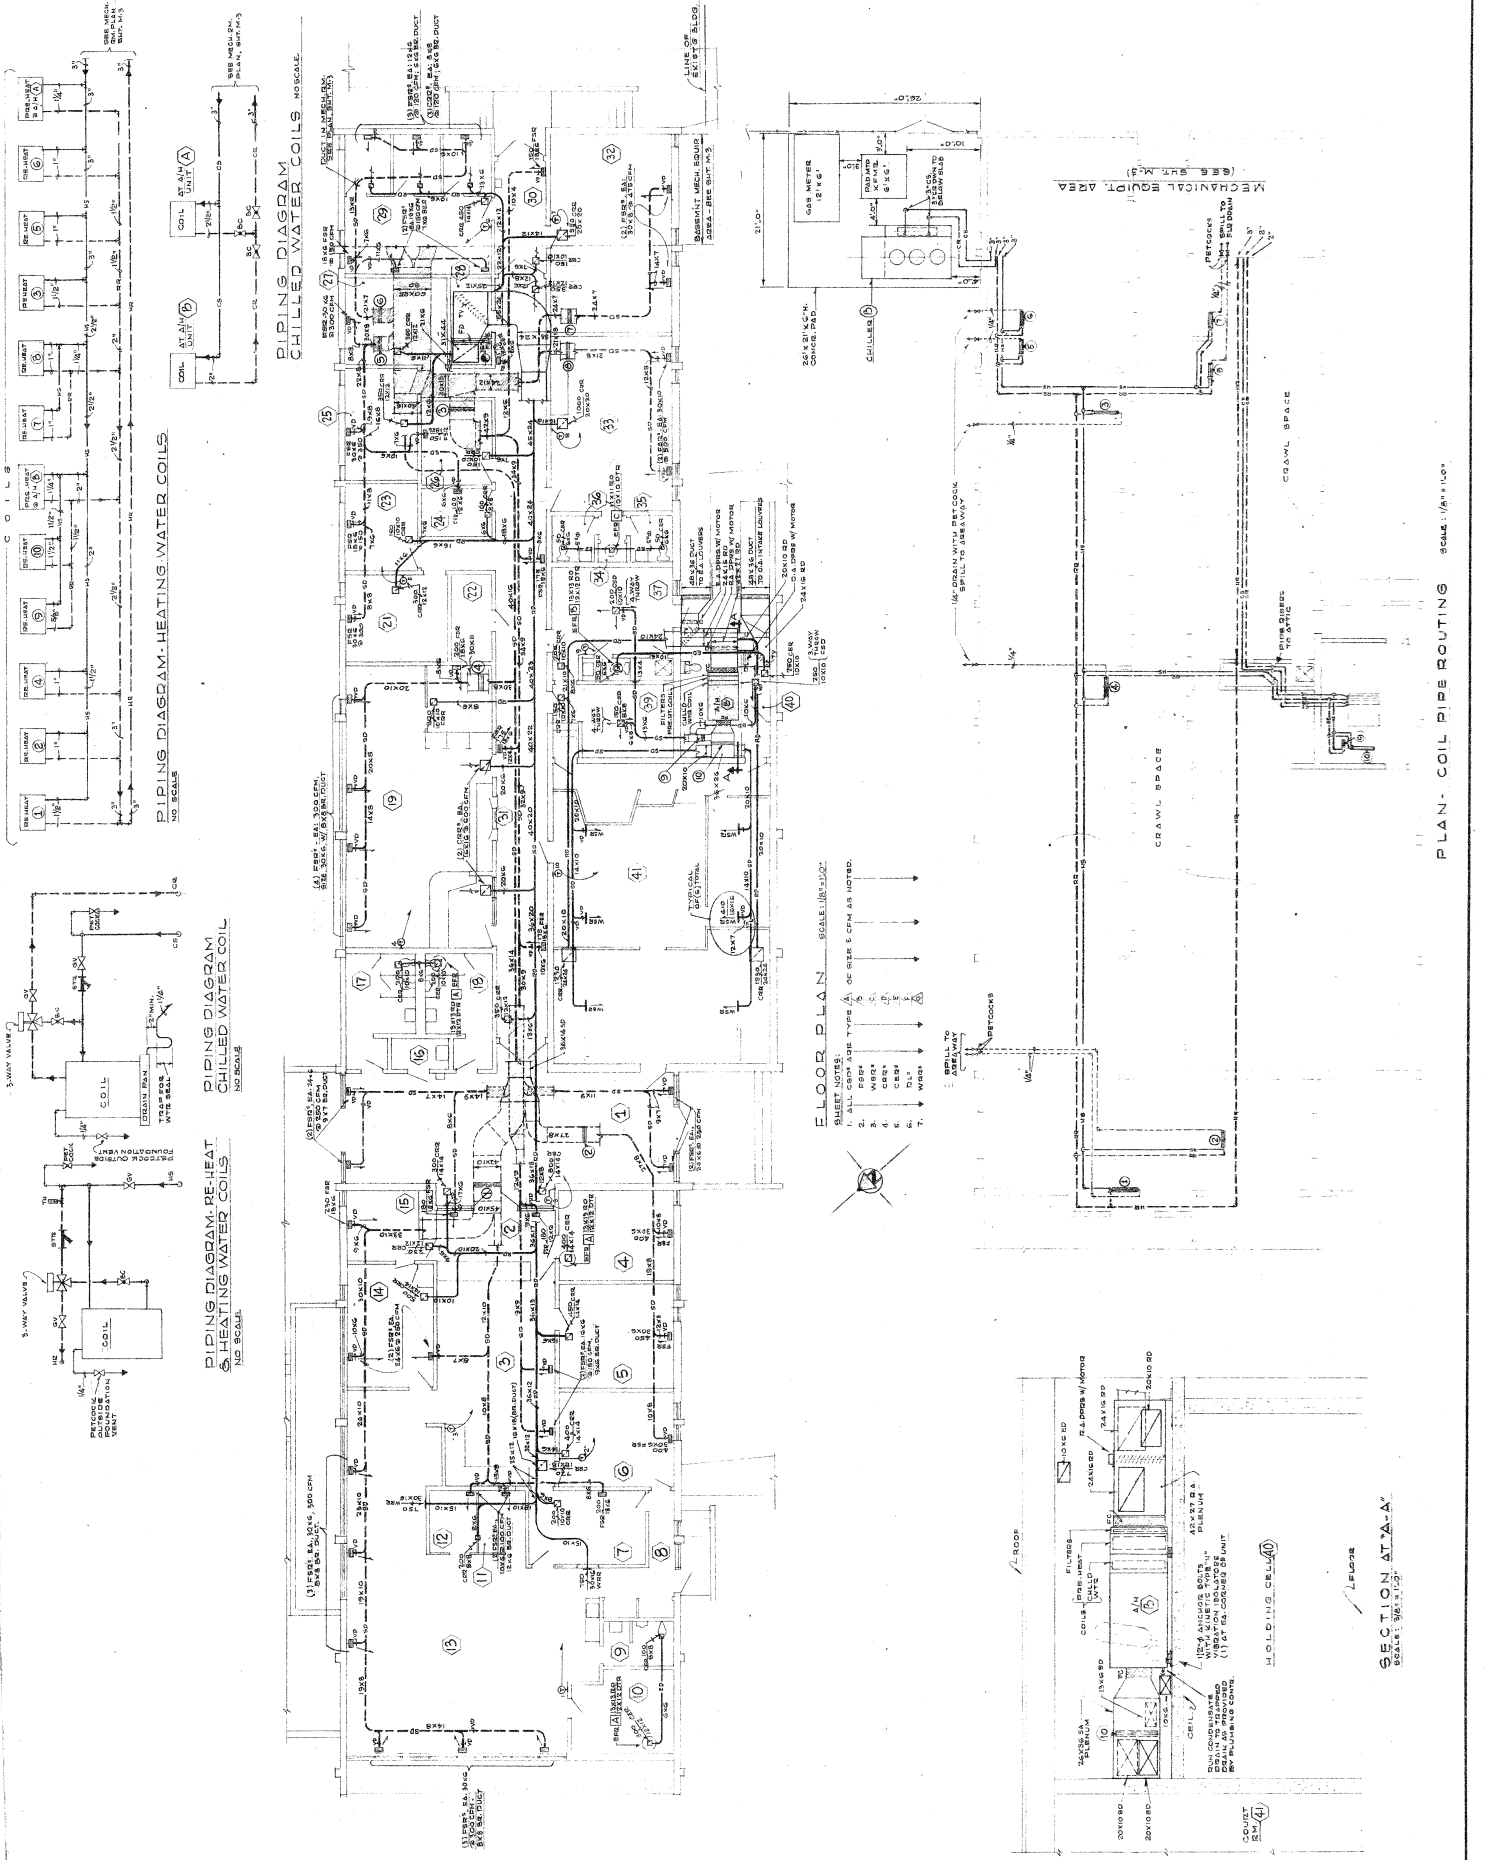


PIPING DIAGRAM - HEATING WATER COILS
 NO SCALE

PIPING DIAGRAM - RE-HEAT & HEATING WATER COILS
 NO SCALE

PIPING DIAGRAM - CHILLED WATER COILS
 NO SCALE

- FLOOR PLAN - SCALE: 1/8" = 1'-0"**
- 1. ALL REFR. AIR TYPE A OR B SEE 6 CPM AS NOTED.
 - 2. W.R.K.
 - 3. W.R.K.
 - 4. W.R.K.
 - 5. W.R.K.
 - 6. W.R.K.
 - 7. W.R.K.

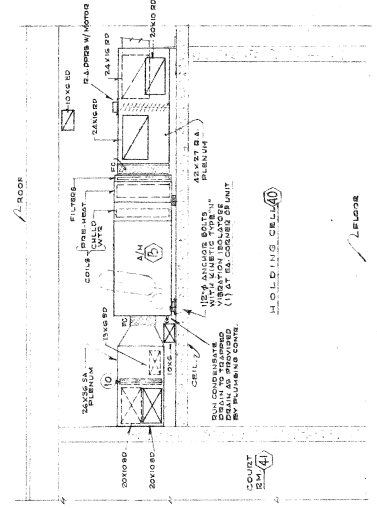

PLAN - COIL PIPE ROUTING SCALE: 1/8" = 1'-0"