
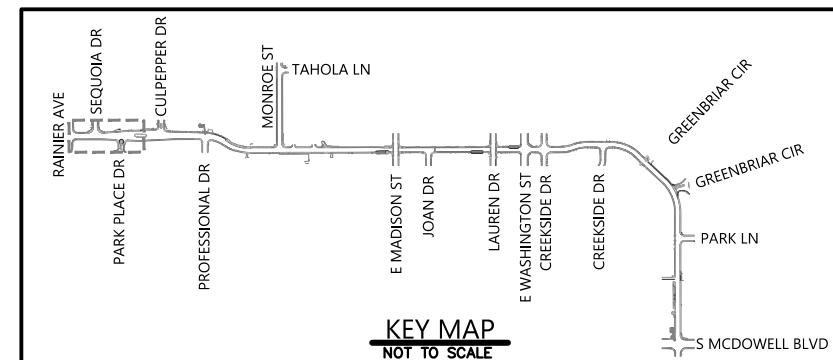
 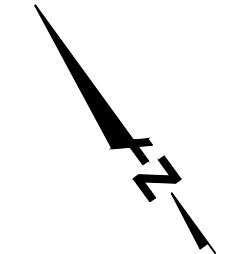


**KEYNOTES:**

- ⑦ SAWCUT AND REMOVE EXISTING CONCRETE FLATWORK AND/OR ASPHALT AND CURB AND GUTTER.
- ⑧ REMOVE EXISTING STRIPING.



**KEY MAP**  
NOT TO SCALE

**BKF ENGINEERS**  
200 4th STREET  
SUITE 300  
SANTA ROSA, CA 95401  
(707) 583-8500  
www.bkf.com


PROJECT NO.  
C16102248

**CITY OF PETALUMA**  
PUBLIC WORKS & UTILITIES  
202 N. McDowell Blvd., PETALUMA, CALIFORNIA, 94954  
PH. 707-778-4546 FAX. 707-778-4508

**MARIA DRIVE - STREET REHABILITATION  
RAINIER AVE TO S MCDOWELL BLVD  
DEMOLITION PLAN  
STA 10+00 TO STA 15+75**

SHEET  
**DM-1**  
18 OF 83

Plot Sep 26, 2023 at 4:03pm  
220332\_01\_DM.dwg  
COPYRIGHT © 2022 BKF ENGINEERS



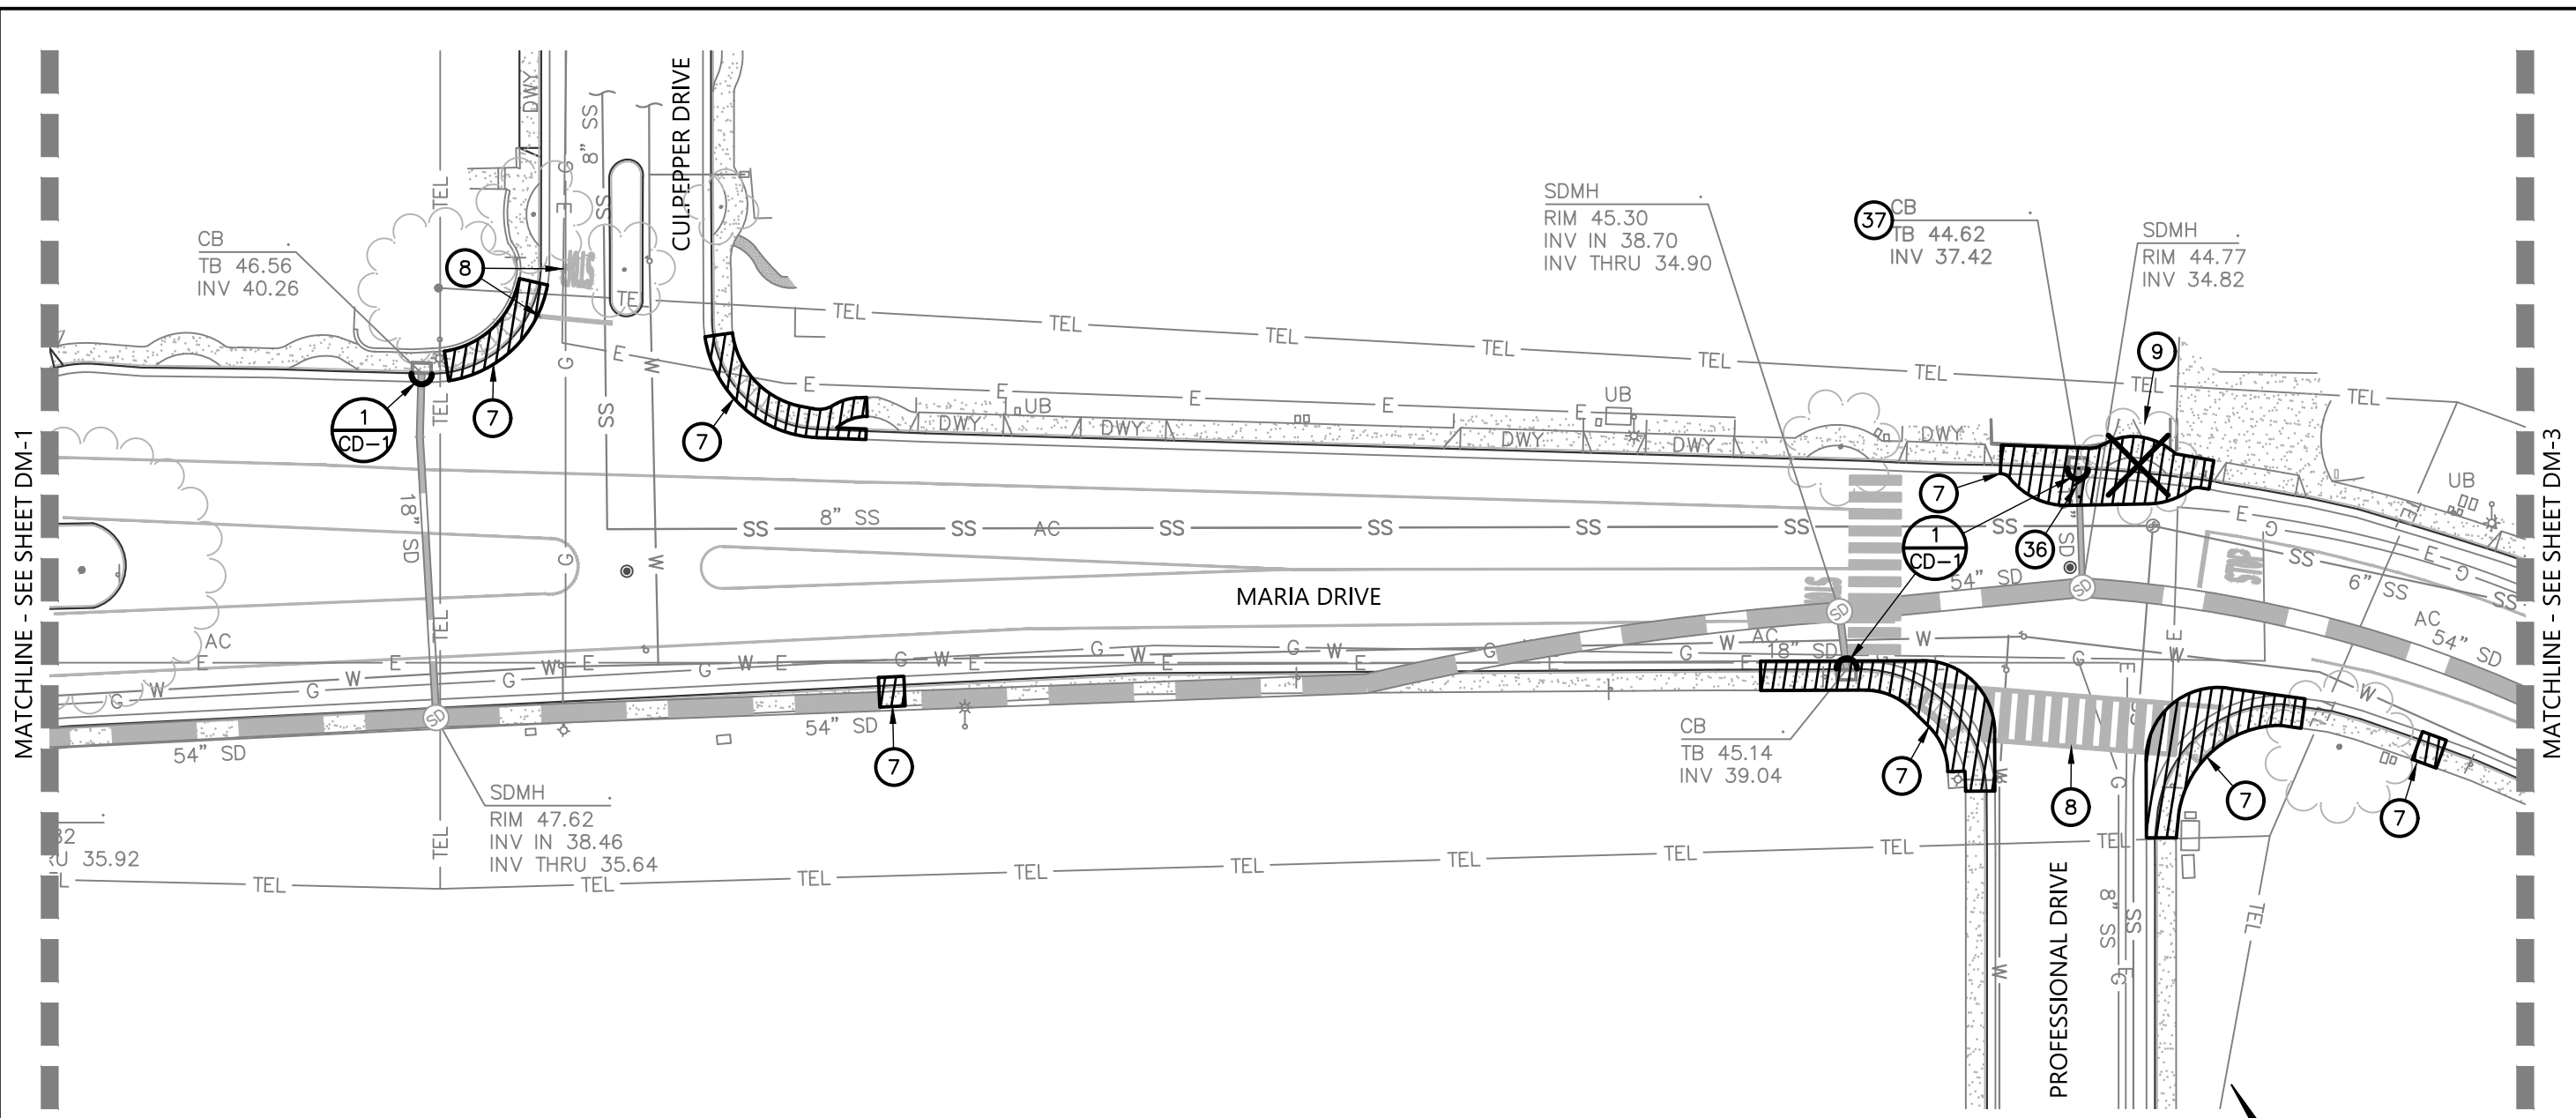


MATCHLINE - SEE SHEET DM-1

MATCHLINE - SEE SHEET DM-3

**KEYNOTES:**

 - ⑦ SAWCUT AND REMOVE EXISTING CONCRETE FLATWORK AND/OR ASPHALT AND CURB AND GUTTER.
- ⑧ REMOVE EXISTING STRIPING.
- ⑨ REMOVE EXISTING TREE.
- ③⑥ REMOVE EXISTING STORM DRAIN TO FACILITATE THE PROPOSED IMPROVEMENTS AND DISPOSE OF UNUSED MATERIAL IN ACCORDANCE WITH LOCAL REGULATIONS.
- ③⑦ REMOVE EXISTING CATCH BASIN TO FACILITATE THE PROPOSED IMPROVEMENTS AND DISPOSE OF UNUSED MATERIAL IN ACCORDANCE WITH LOCAL REGULATIONS.

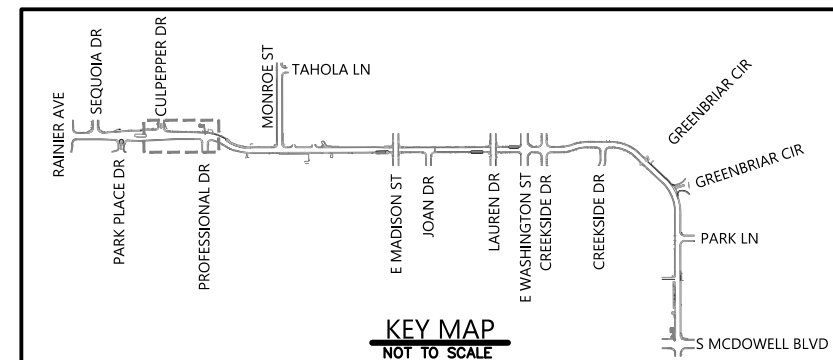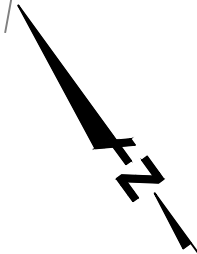

**KEY MAP**  
NOT TO SCALE

**BKF ENGINEERS**  
200 4th STREET  
SUITE 300  
SANTA ROSA, CA 95401  
(707) 583-8500  
www.bkf.com

PROJECT NO.  
C16102248


**CITY OF PETALUMA**  
PUBLIC WORKS & UTILITIES  
202 N. McDowell Blvd., PETALUMA, CALIFORNIA, 94954  
PH. 707-778-4546 FAX. 707-778-4508



**MARIA DRIVE - STREET REHABILITATION**  
RAINIER AVE TO S MCDOWELL BLVD  
DEMOLITION PLAN  
STA 15+75 TO STA 21+50




SHEET  
**DM-2**  
19 OF 83

Plot Sep 26, 2023 at 4:03pm  
220332\_01\_DM.dwg  
COPYRIGHT © 2022 BKF ENGINEERS

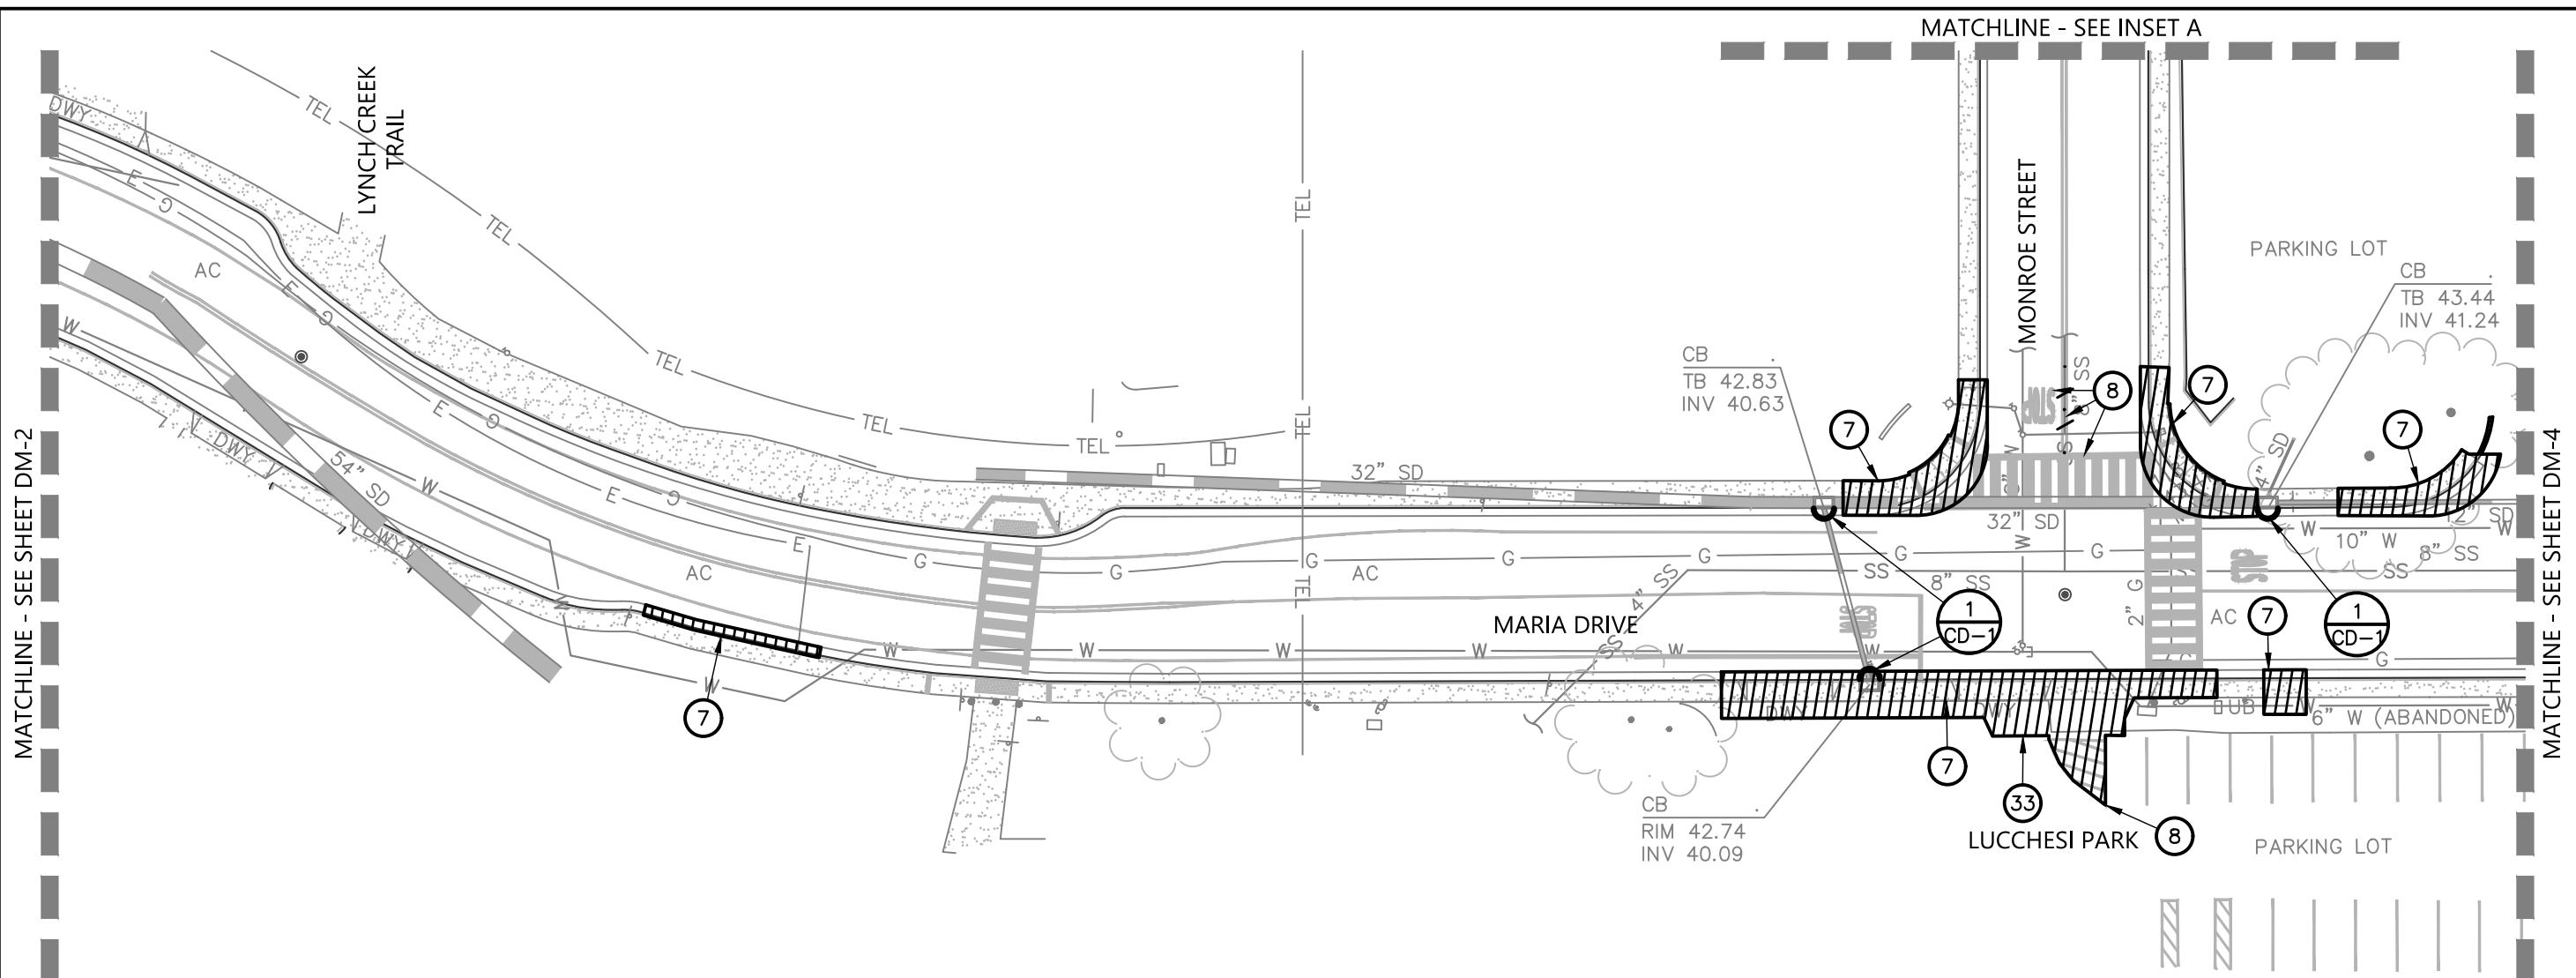


**KEYNOTES:**

- ⑦ SAWCUT AND REMOVE EXISTING CONCRETE FLATWORK AND/OR ASPHALT AND CURB AND GUTTER.
- ⑧ REMOVE EXISTING STRIPING.
- ③③ SAWCUT AND REMOVE PORTIONS OF EXISTING ASPHALT TO FACILITATE INSTALLATION OF PROPOSED IMPROVEMENTS.

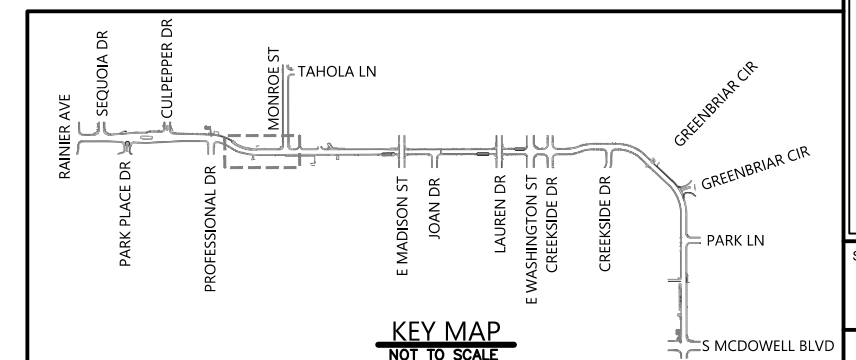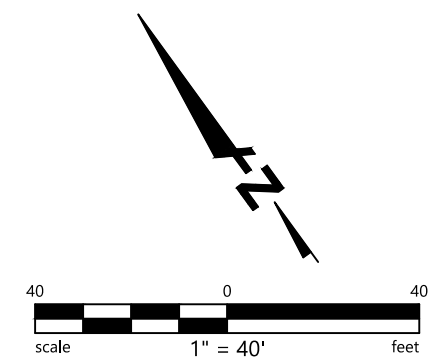
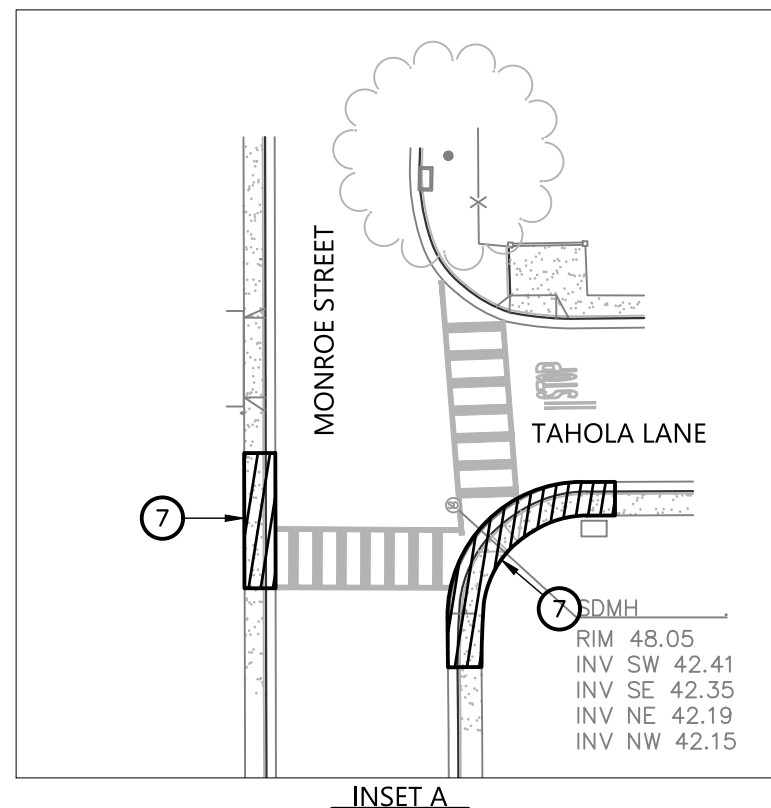


Plot Sep 26, 2023 at 4:03pm  
220332\_01\_DM.dwg  
COPYRIGHT © 2022 BKF ENGINEERS

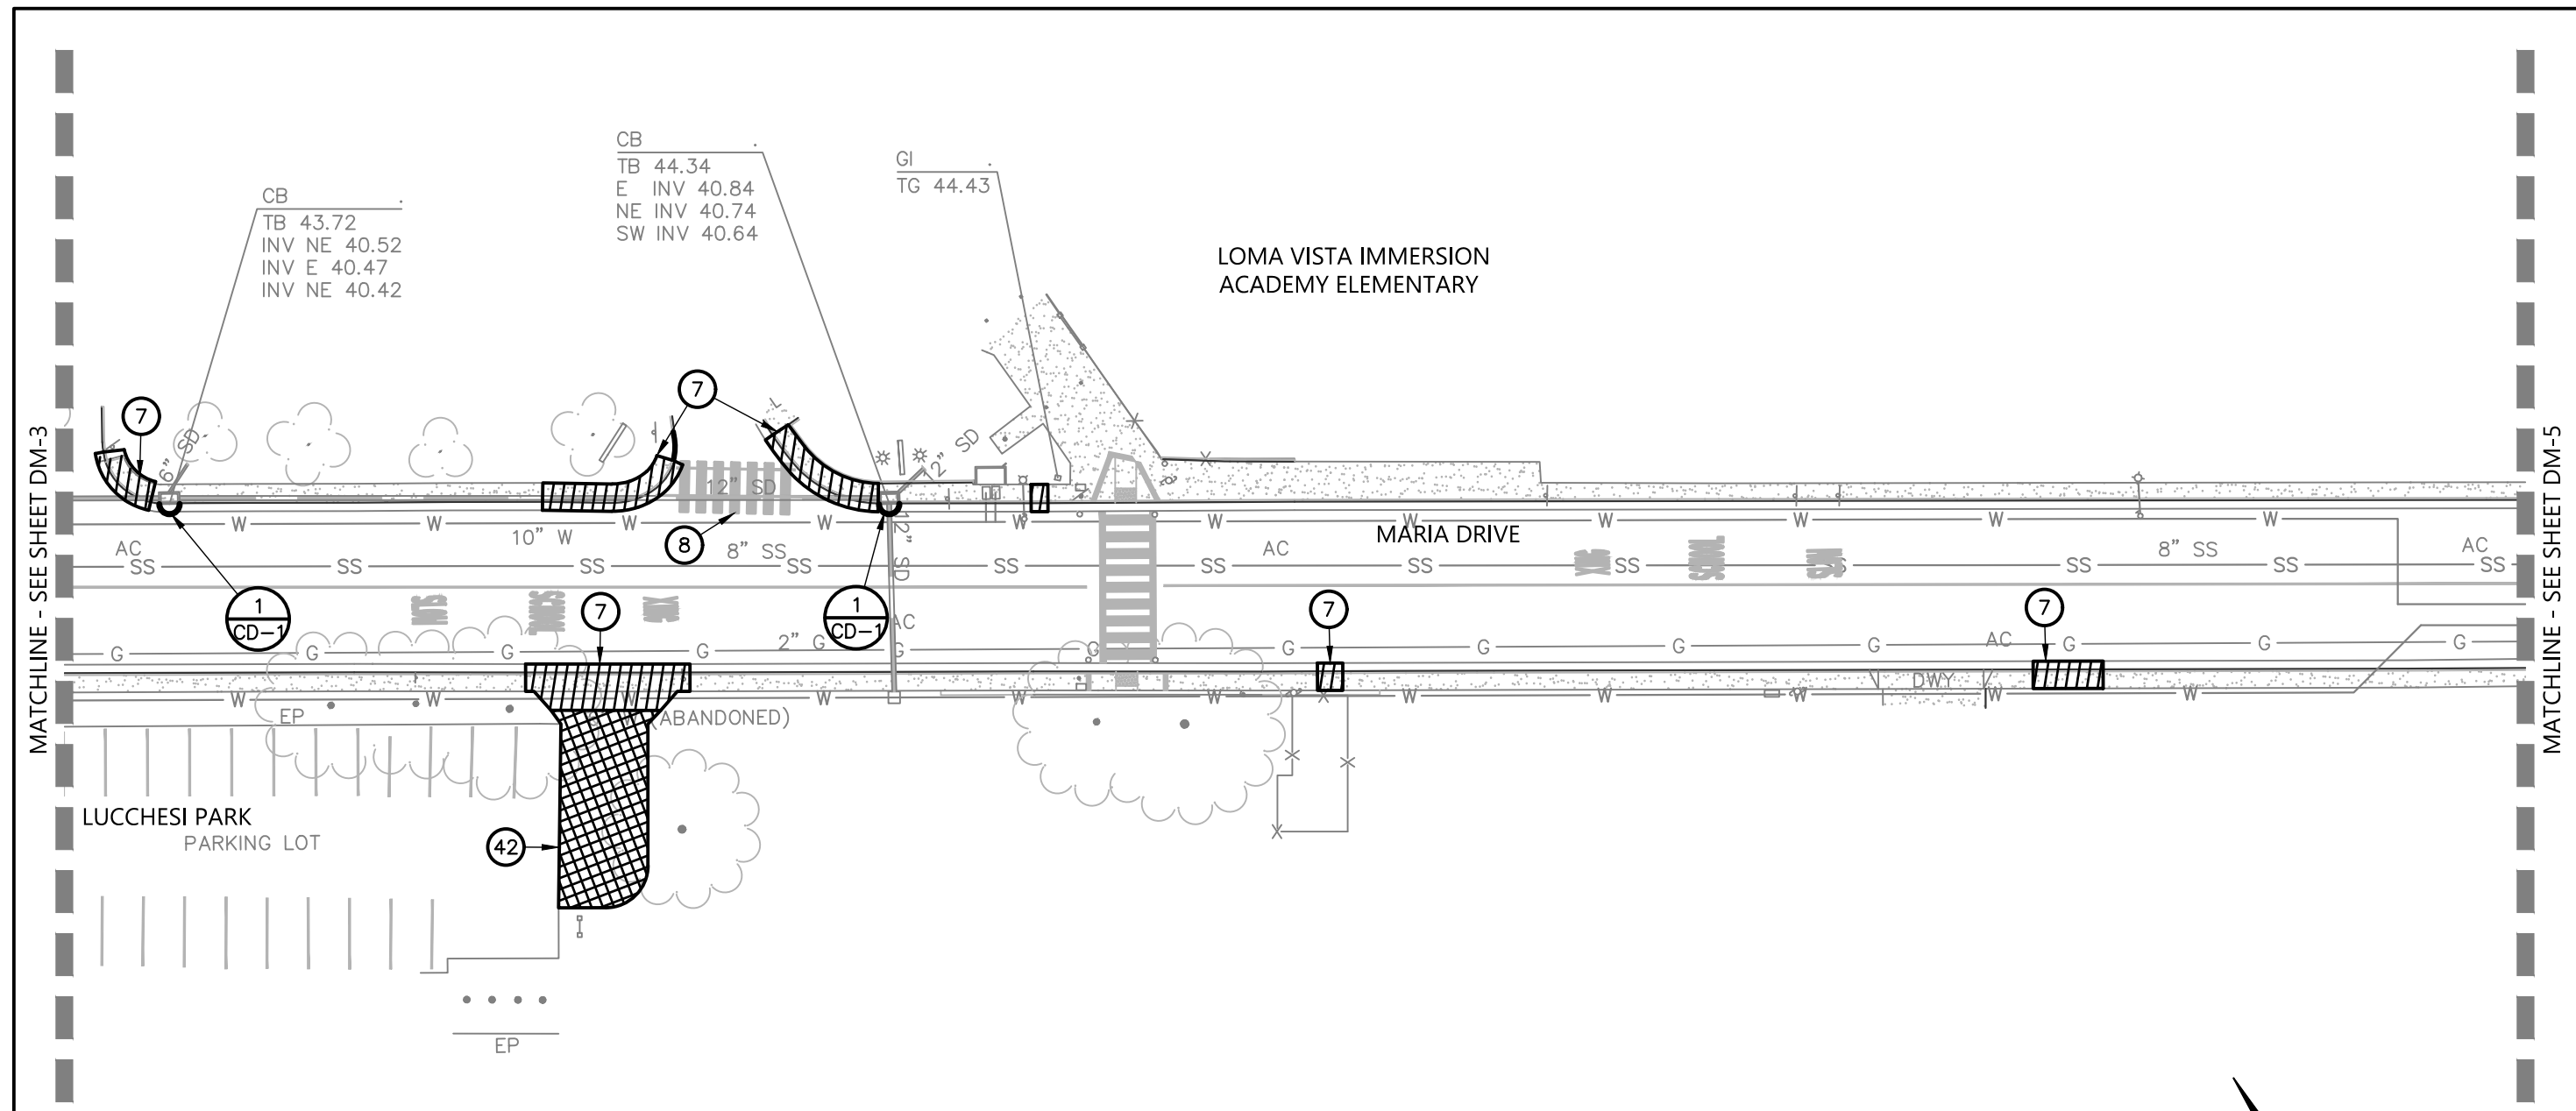

**KEYNOTES:**


- ⑦ SAWCUT AND REMOVE EXISTING CONCRETE FLATWORK AND/OR ASPHALT AND CURB AND GUTTER.
- ⑧ REMOVE EXISTING STRIPING.
- ④② REMOVE AND DISPOSE OF SOIL MATERIALS TO A DEPTH OF 6-INCHES TO FACILITATE THE PROPOSED IMPROVEMENTS.

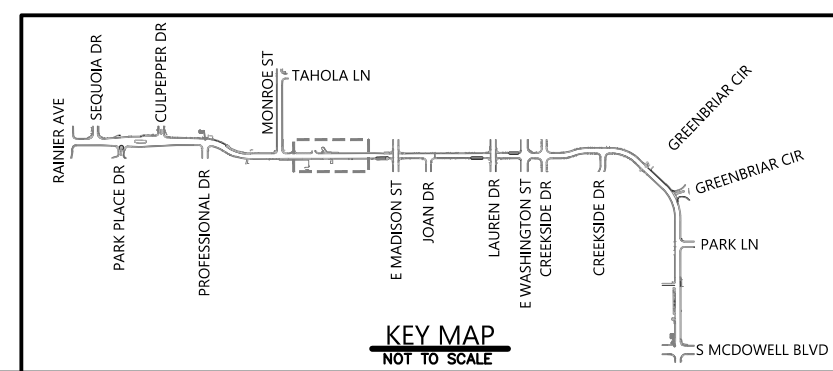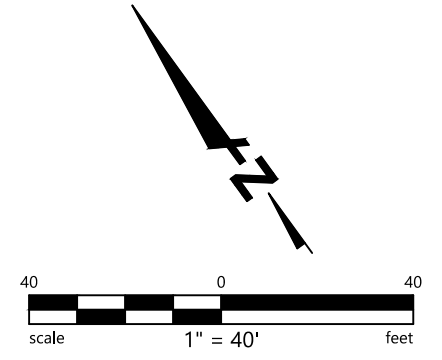

220332\_04\_DM.dwg  
 2023.09.26, 2023, at 4:03pm  
 COPYRIGHT © 2022, BKF ENGINEERS



MATCHLINE - SEE SHEET DM-4

MATCHLINE - SEE SHEET DM-6

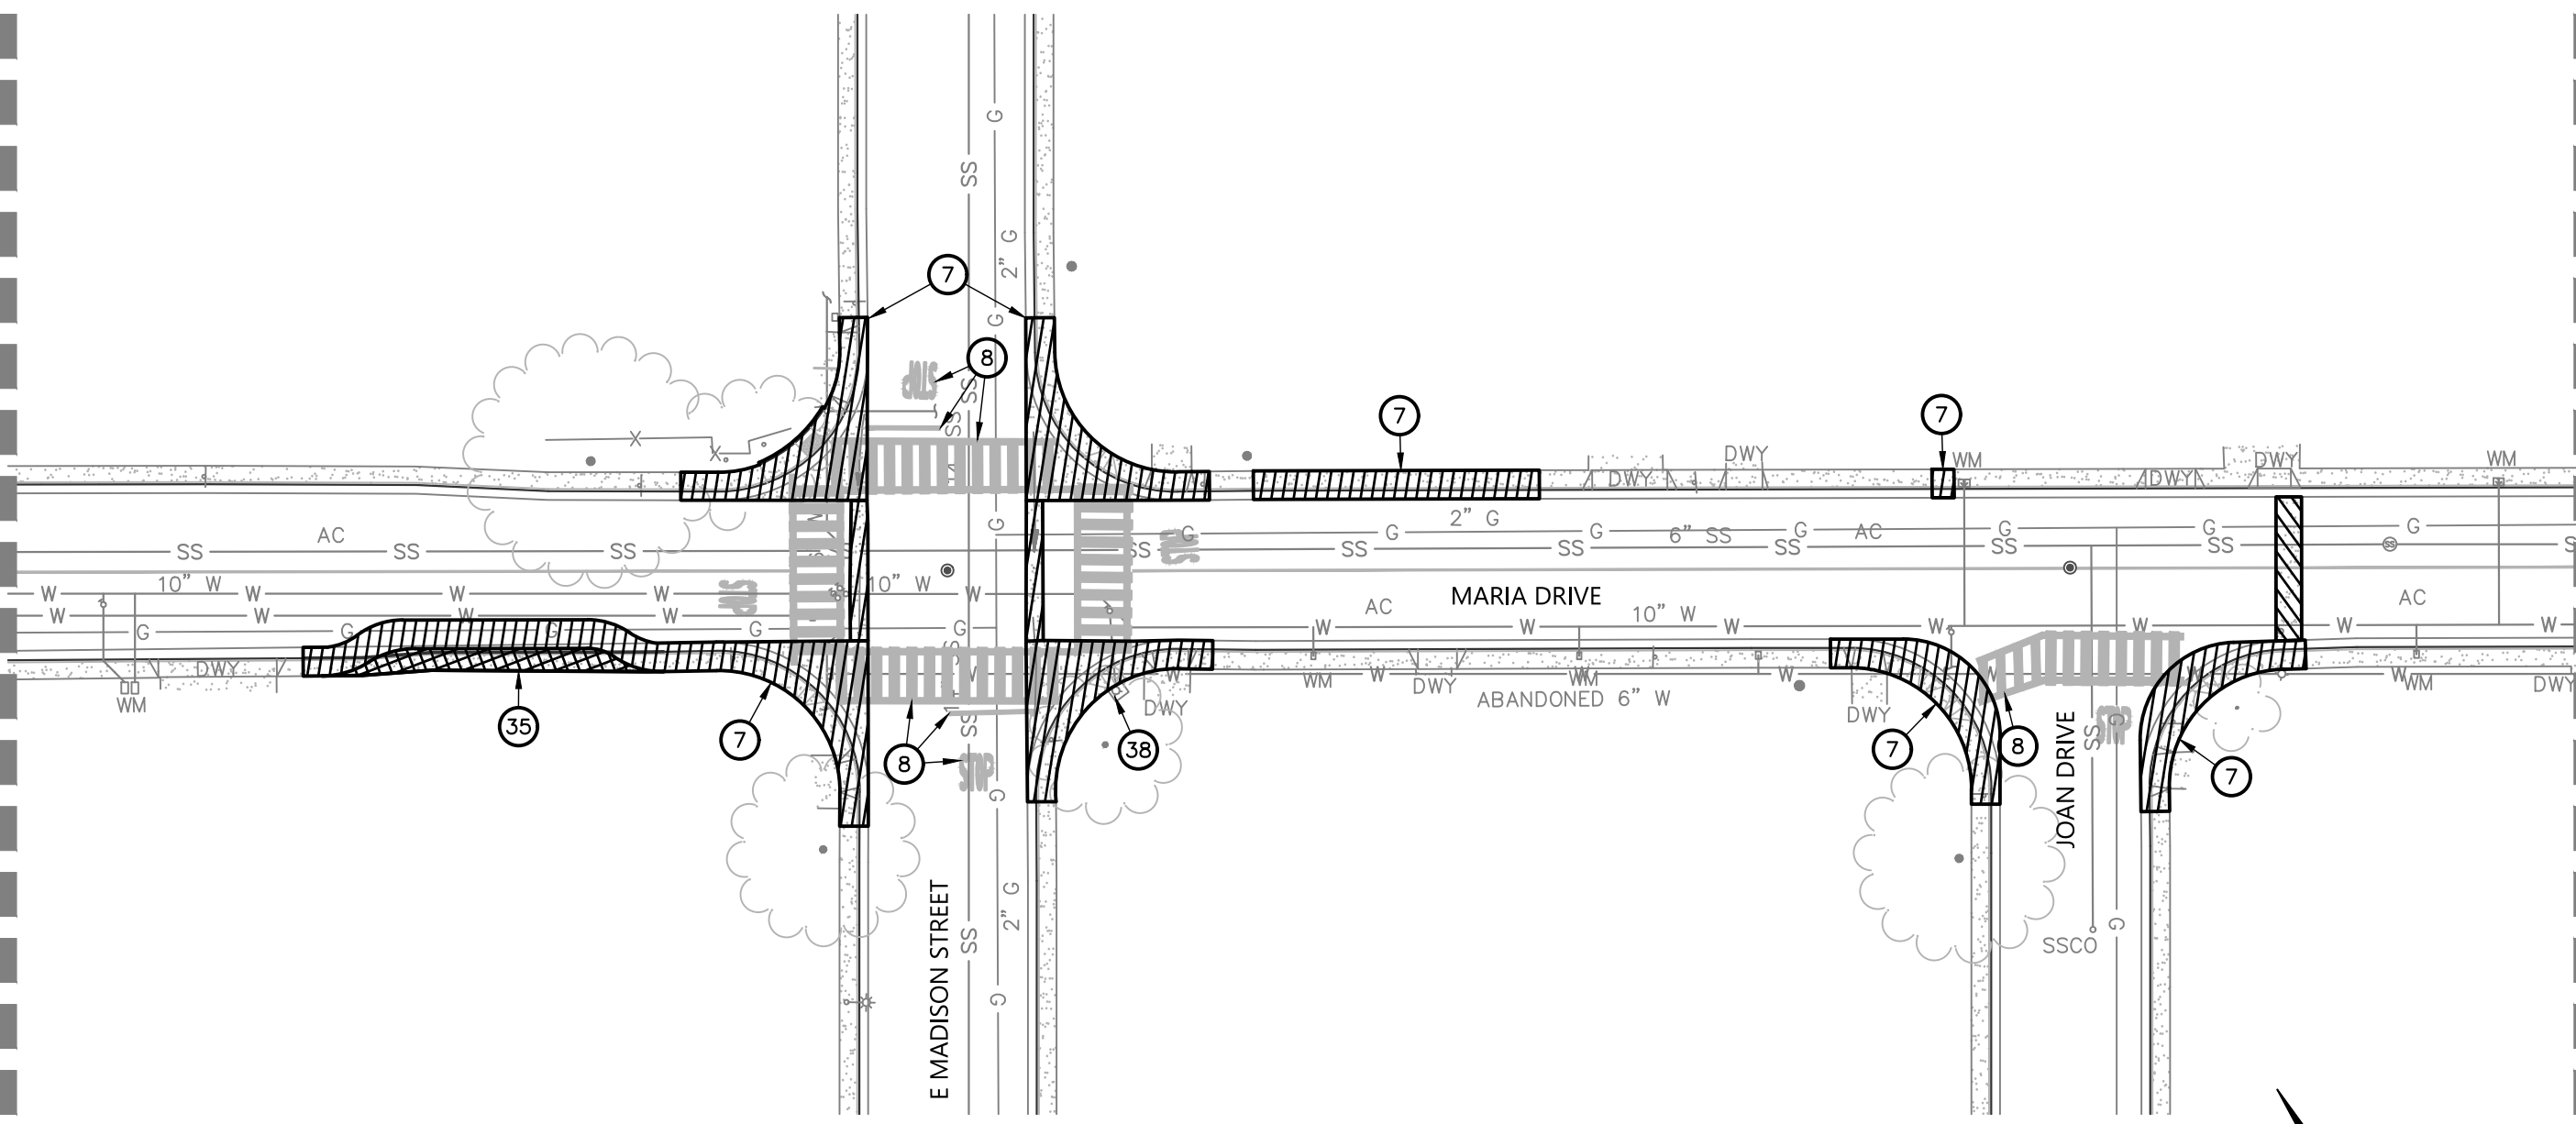

**KEYNOTES:**

- ⑦ SAWCUT AND REMOVE EXISTING CONCRETE FLATWORK AND/OR ASPHALT AND CURB AND GUTTER.
- ⑧ REMOVE EXISTING STRIPING.
- ③⑤ SAWCUT AND REMOVE EXISTING CONCRETE FLATWORK, BASE, AND SUBGRADE TO A DEPTH OF 36-IN TO FACILITATE PROPOSED TREE PLANTING.
- ③⑥ REMOVE EXISTING STORM DRAIN TO FACILITATE THE PROPOSED IMPROVEMENTS AND DISPOSE OF UNUSED MATERIAL IN ACCORDANCE WITH LOCAL REGULATIONS.
- ③⑧ REMOVE EXISTING FIRE HYDRANT TO FACILITATE THE PROPOSED IMPROVEMENTS AND DISPOSE OF UNUSED MATERIAL IN ACCORDANCE WITH LOCAL REGULATIONS.

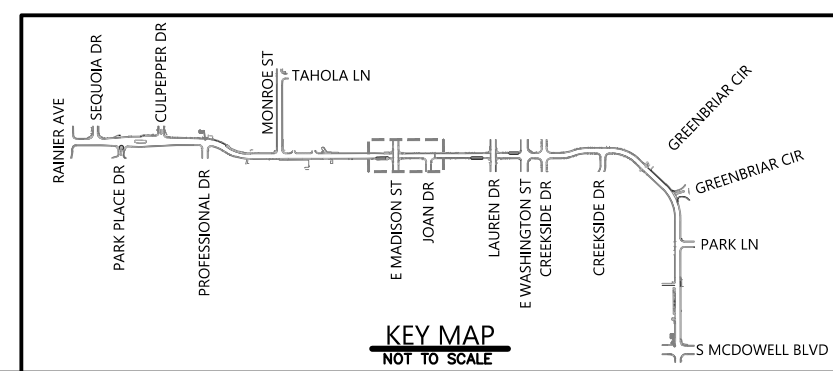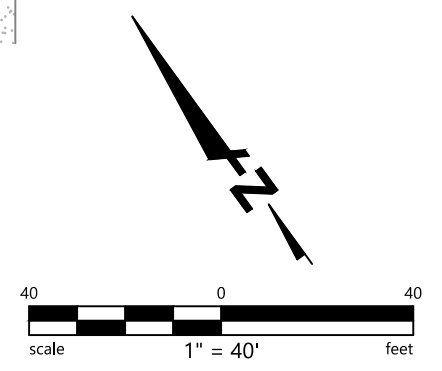

PROJECT NO. C16102248



**CITY OF PETALUMA**  
 PUBLIC WORKS & UTILITIES  
 202 N. McDowell Blvd., PETALUMA, CALIFORNIA, 94954  
 PH. 707-778-4546 FAX. 707-778-4508




**MARIA DRIVE - STREET REHABILITATION**  
**RAINIER AVE TO S MCDOWELL BLVD**  
 DEMOLITION PLAN  
 STA 33+50 TO STA 39+25

SHEET **DM-5**  
 22 OF 83

BID SET


MATCHLINE - SEE SHEET DM-5

MATCHLINE - SEE SHEET DM-7

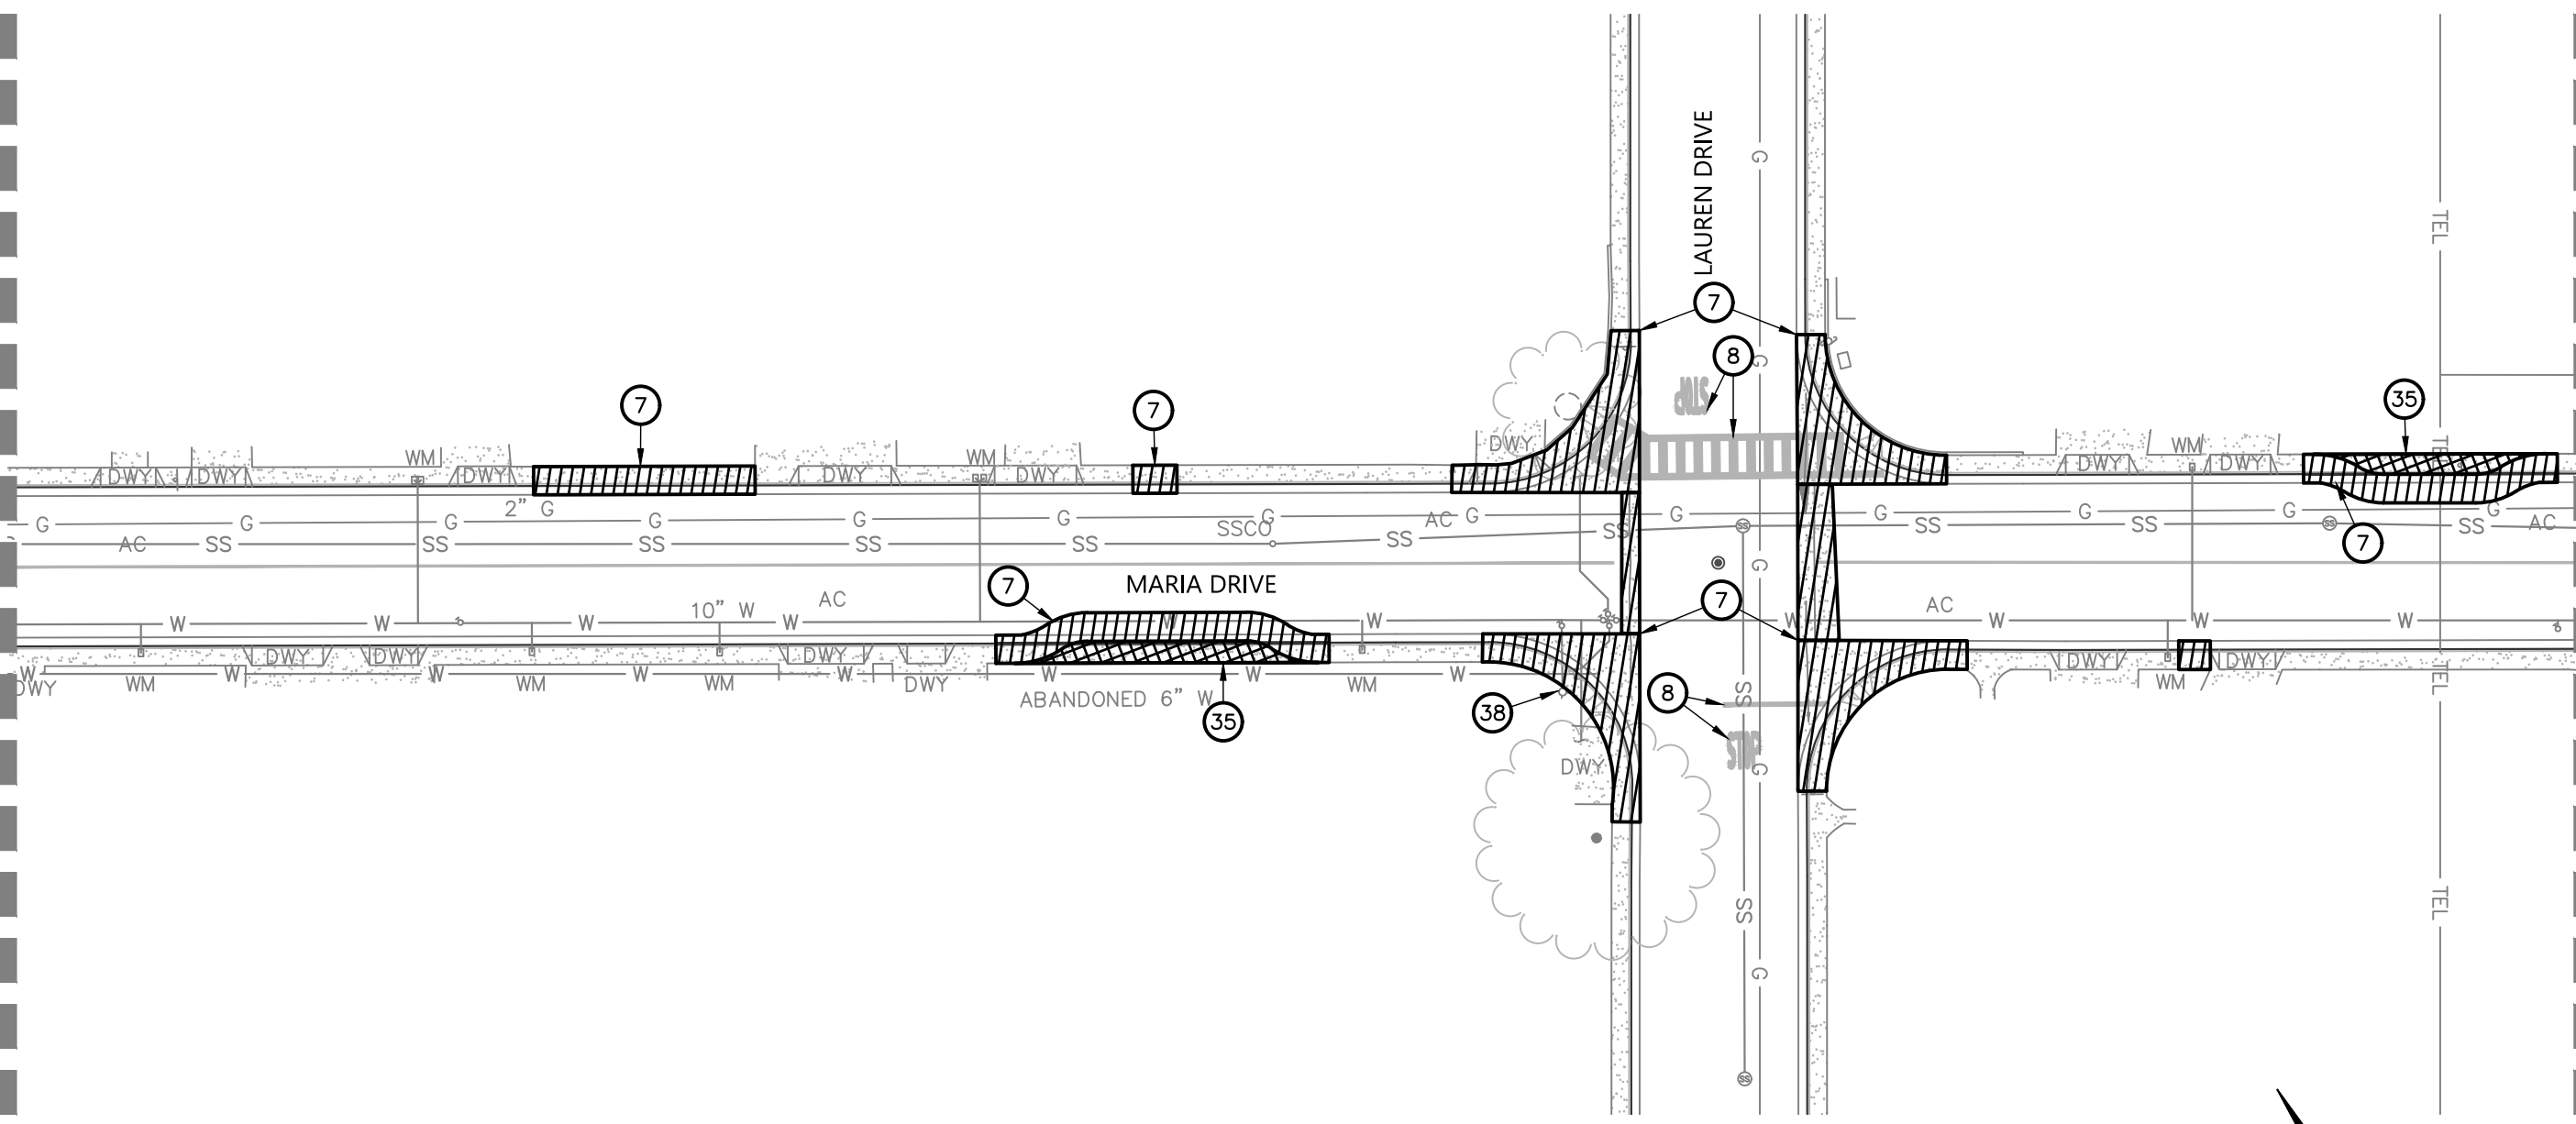


**KEYNOTES:**

- ⑦ SAWCUT AND REMOVE EXISTING CONCRETE FLATWORK AND/OR ASPHALT AND CURB AND GUTTER.
- ⑧ REMOVE EXISTING STRIPING.
- ③⑤ SAWCUT AND REMOVE EXISTING CONCRETE FLATWORK, BASE, AND SUBGRADE TO A DEPTH OF 36-IN TO FACILITATE PROPOSED TREE PLANTING.
- ③⑧ REMOVE EXISTING FIRE HYDRANT TO FACILITATE THE PROPOSED IMPROVEMENTS AND DISPOSE OF UNUSED MATERIAL IN ACCORDANCE WITH LOCAL REGULATIONS.

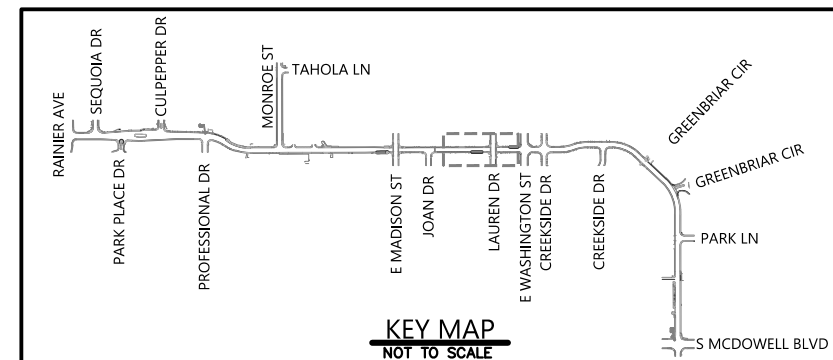

PROJECT NO.  
C16102248

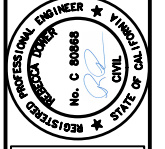


**CITY OF PETALUMA**  
PUBLIC WORKS & UTILITIES  
202 N. McDowell Blvd., PETALUMA, CALIFORNIA, 94954  
PH. 707-778-4546 FAX. 707-778-4508



**MARIA DRIVE - STREET REHABILITATION**  
RAINIER AVE TO S MCDOWELL BLVD  
DEMOLITION PLAN  
STA 39+25 TO STA 45+50



SHEET  
**DM-6**  
23 OF 83

Plot Sep 26, 2023 at 4:59pm  
220332\_01\_DM.dwg  
COPYRIGHT © 2022 BKF ENGINEERS

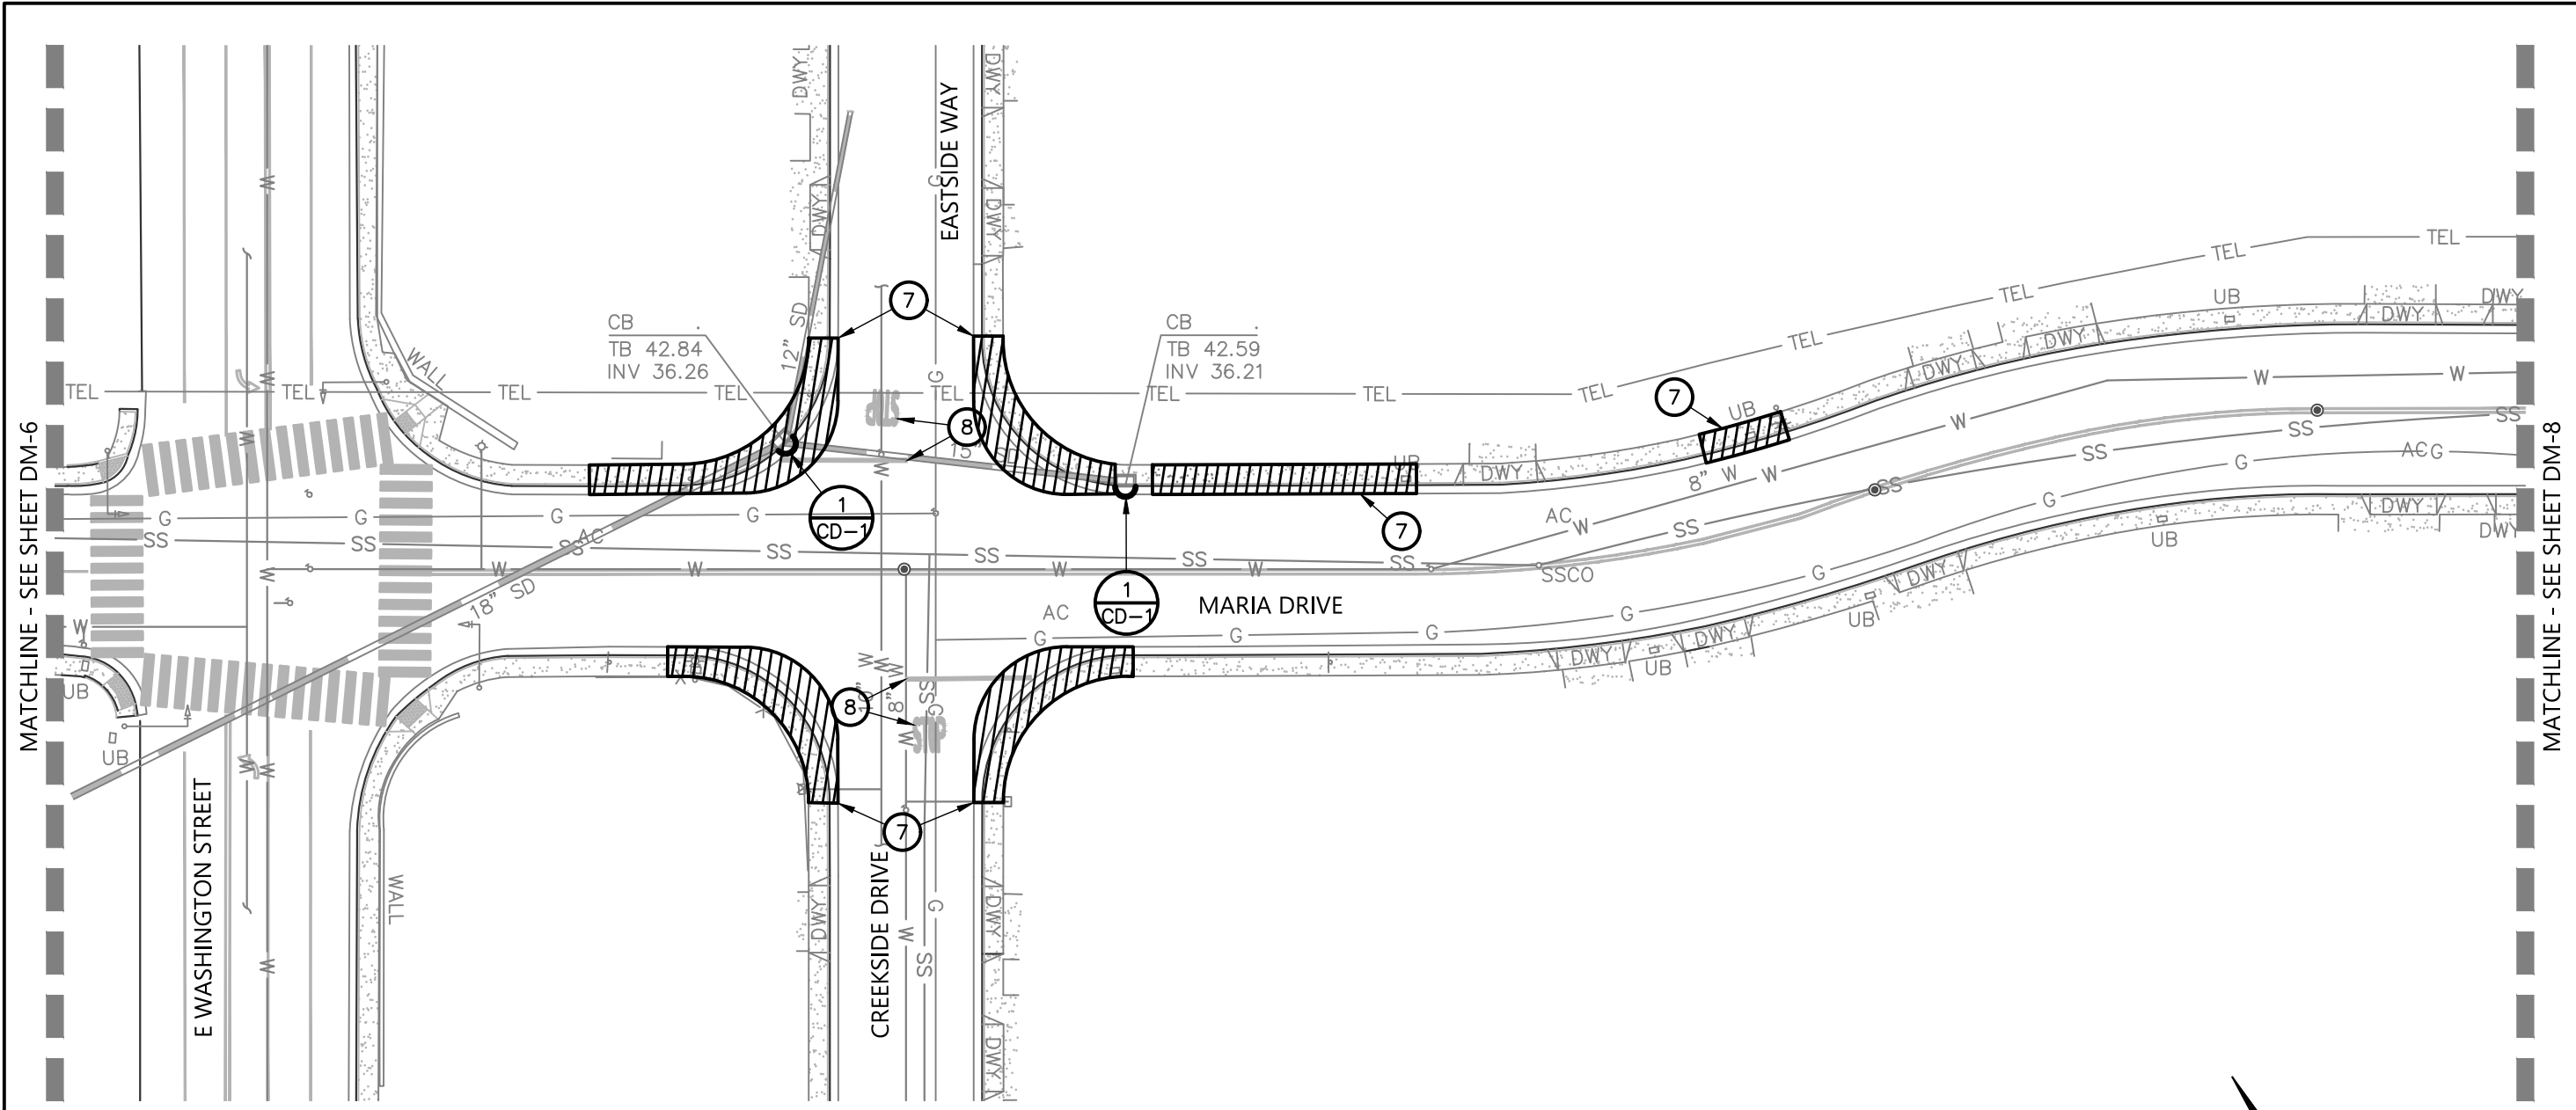


**KEYNOTES:**

- ⑦ SAWCUT AND REMOVE EXISTING CONCRETE FLATWORK AND/OR ASPHALT AND CURB AND GUTTER.
- ⑧ REMOVE EXISTING STRIPING.

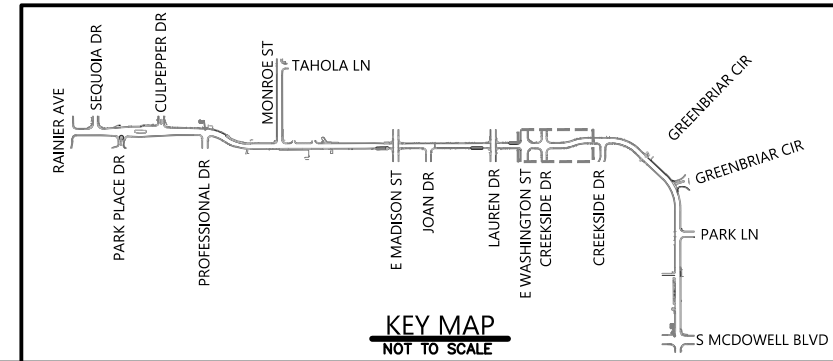
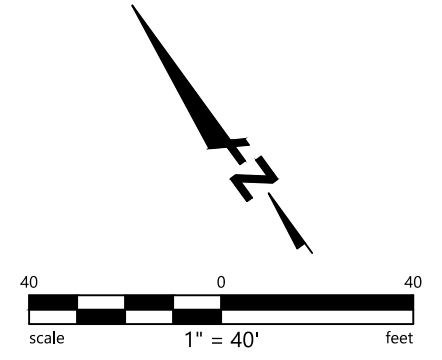


220332\_01\_DM.dwg  
COPYRIGHT © 2022 BKF ENGINEERS

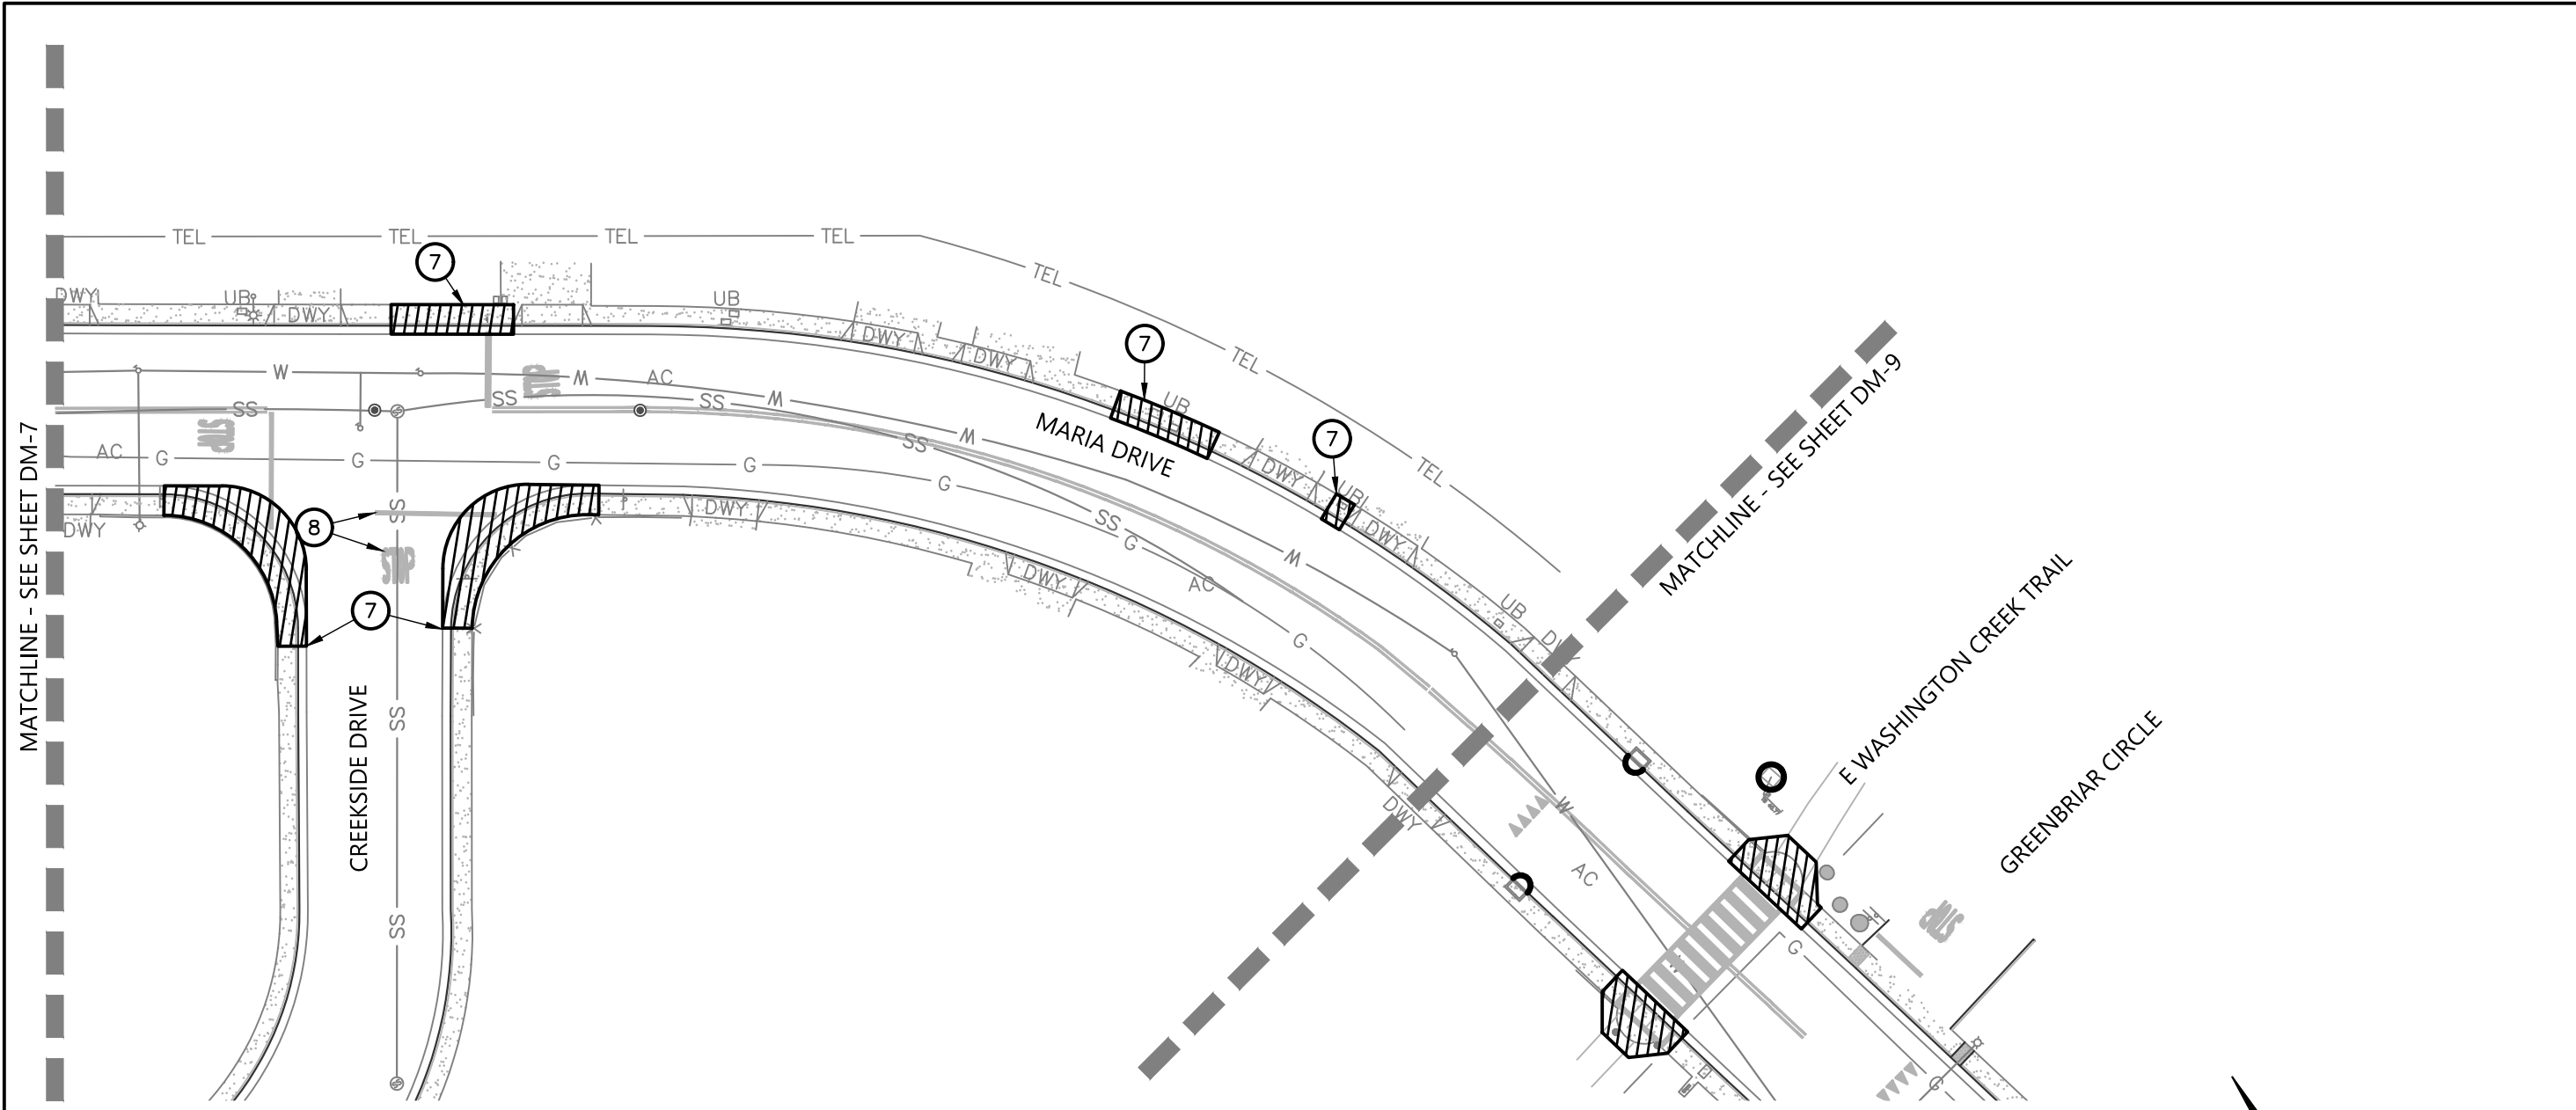


**KEYNOTES:**

- ⑦ SAWCUT AND REMOVE EXISTING CONCRETE FLATWORK AND/OR ASPHALT AND CURB AND GUTTER.
- ⑧ REMOVE EXISTING STRIPING.

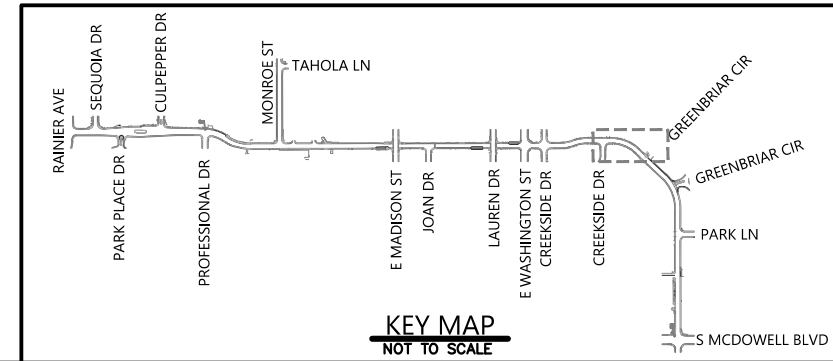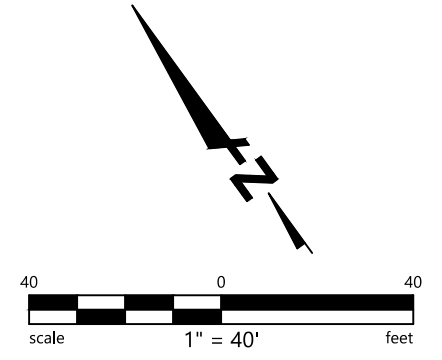




Plot Date: 20/10/2023 at 4:59pm  
 220332\_01\_DM.dwg  
 COPYRIGHT © 2022 BKF ENGINEERS



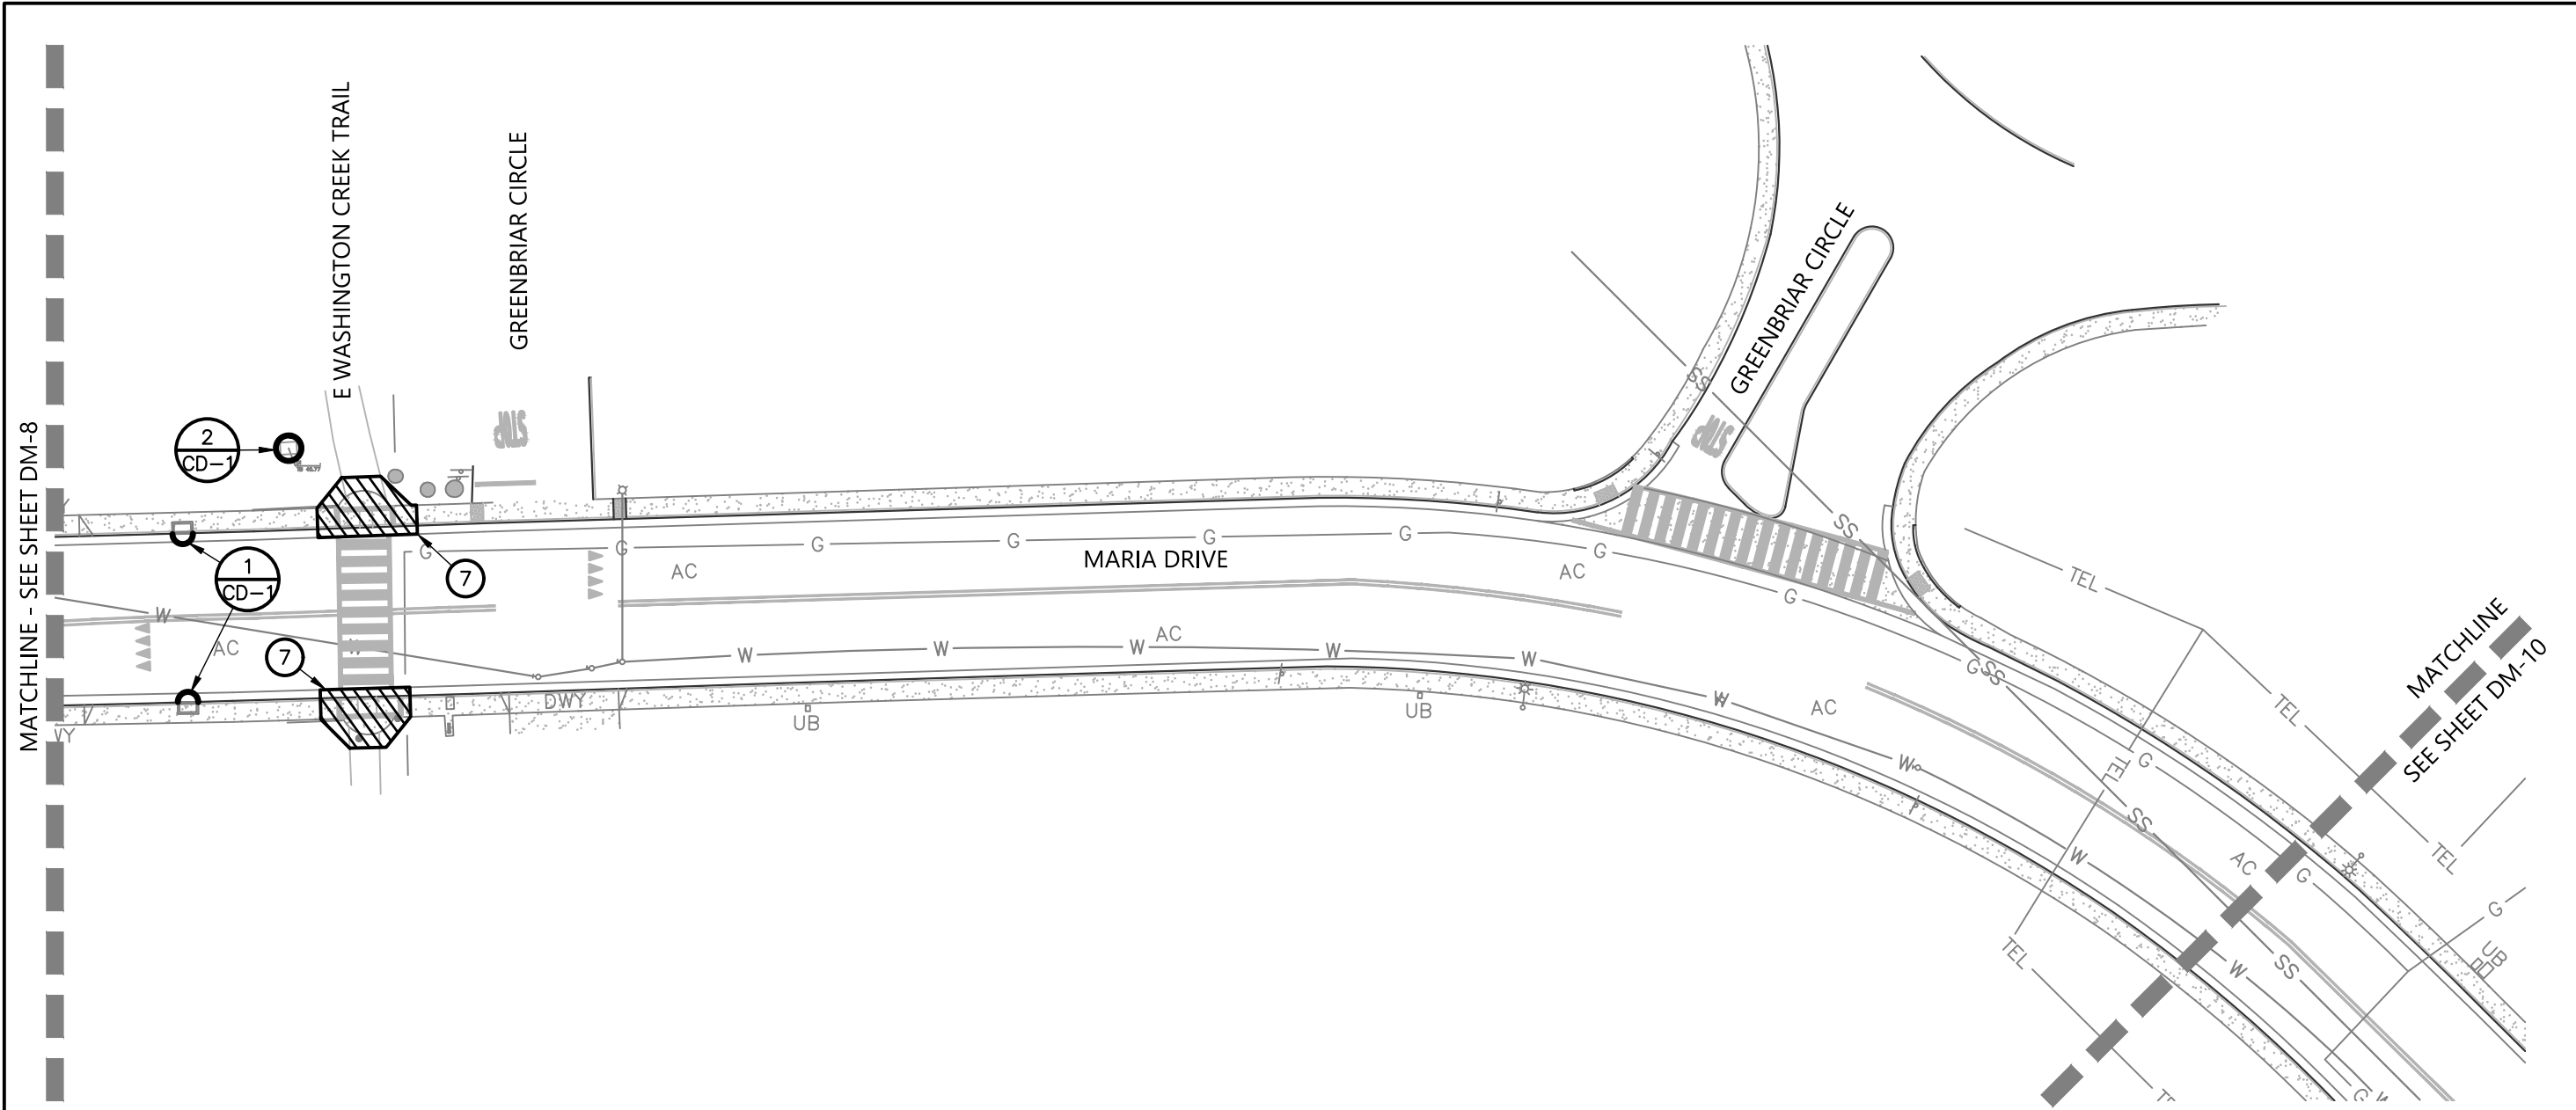

**KEYNOTES:**

- ⑦ SAWCUT AND REMOVE EXISTING CONCRETE FLATWORK AND/OR ASPHALT AND CURB AND GUTTER.

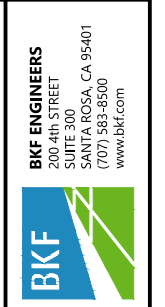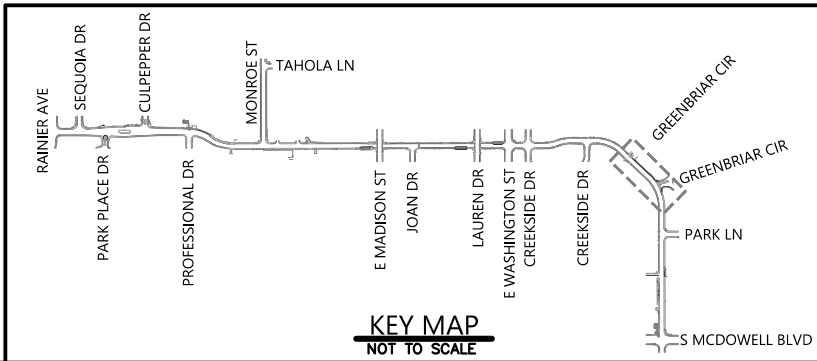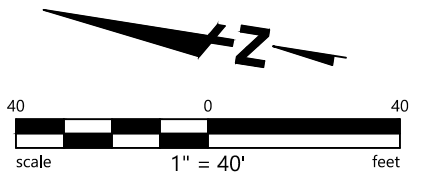

PROJECT NO.  
C16102248



**CITY OF PETALUMA**  
PUBLIC WORKS & UTILITIES  
202 N. McDowell Blvd., PETALUMA, CALIFORNIA, 94954  
PH. 707-778-4546 FAX. 707-778-4508




**MARIA DRIVE - STREET REHABILITATION  
RAINIER AVE TO S MCDOWELL BLVD  
DEMOLITION PLAN  
STA 54+75 TO STA 60+00**

SHEET  
**DM-9**  
26 OF 83



BID SET

Plot Date: 2/20/2023 at 4:59pm  
220332\_01\_DM.dwg  
COPYRIGHT © 2022 BKF ENGINEERS

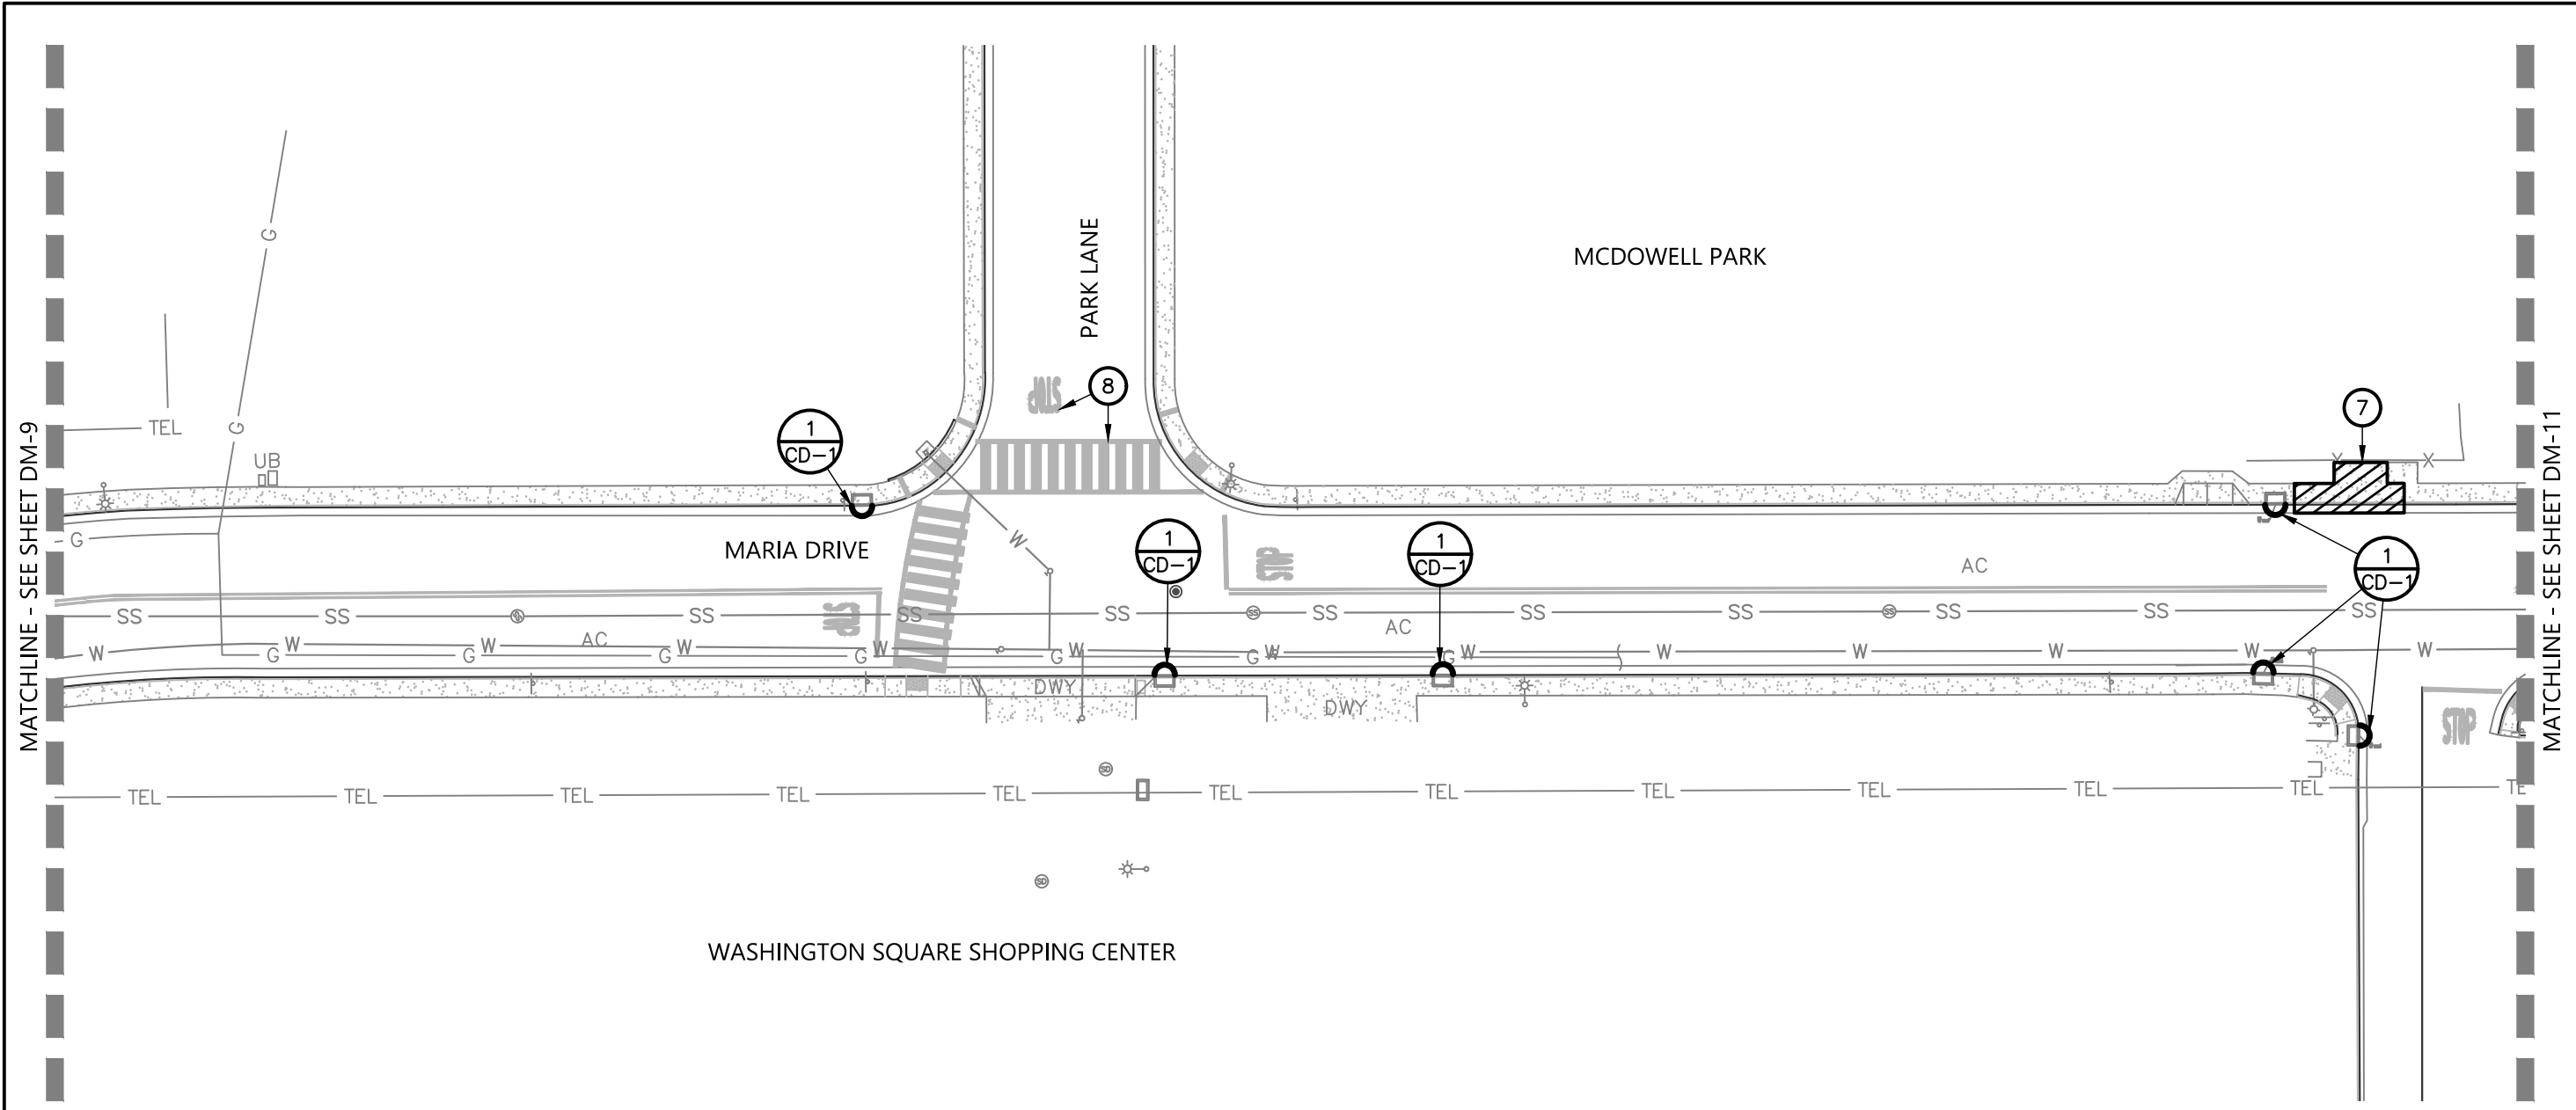

**KEYNOTES:**

- ⑦ SAWCUT AND REMOVE EXISTING CONCRETE FLATWORK AND ASPHALT AND CURB AND GUTTER.
- ⑧ REMOVE EXISTING STRIPING.

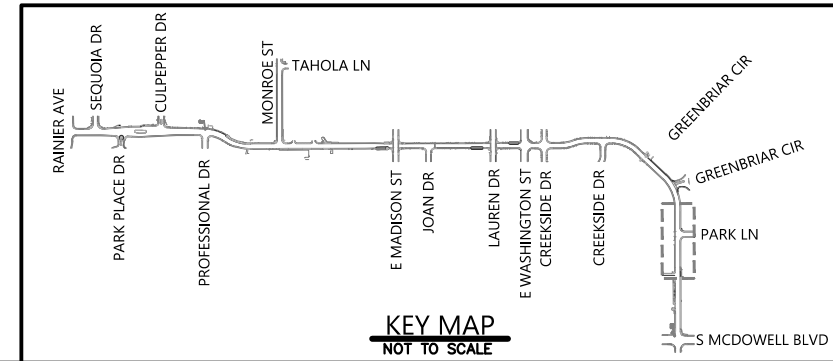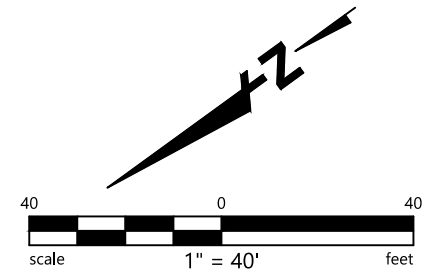

**BKF ENGINEERS**  
200 4th STREET  
SUITE 300  
SANTA ROSA, CA 95401  
(707) 583-8500  
www.bkf.com

PROJECT NO.  
C16102248


**CITY OF PETALUMA**  
PUBLIC WORKS & UTILITIES  
202 N. McDowell Blvd., PETALUMA, CALIFORNIA, 94954  
PH. 707-778-4546 FAX. 707-778-4508

**MARIA DRIVE - STREET REHABILITATION  
RAINIER AVE TO S MCDOWELL BLVD  
DEMOLITION PLAN  
STA 60+00 TO STA 66+00**

SHEET  
**DM-10**  
27 OF 83



BID SET

220332\_01\_DM.dwg  
COPYRIGHT © 2022 BKF ENGINEERS

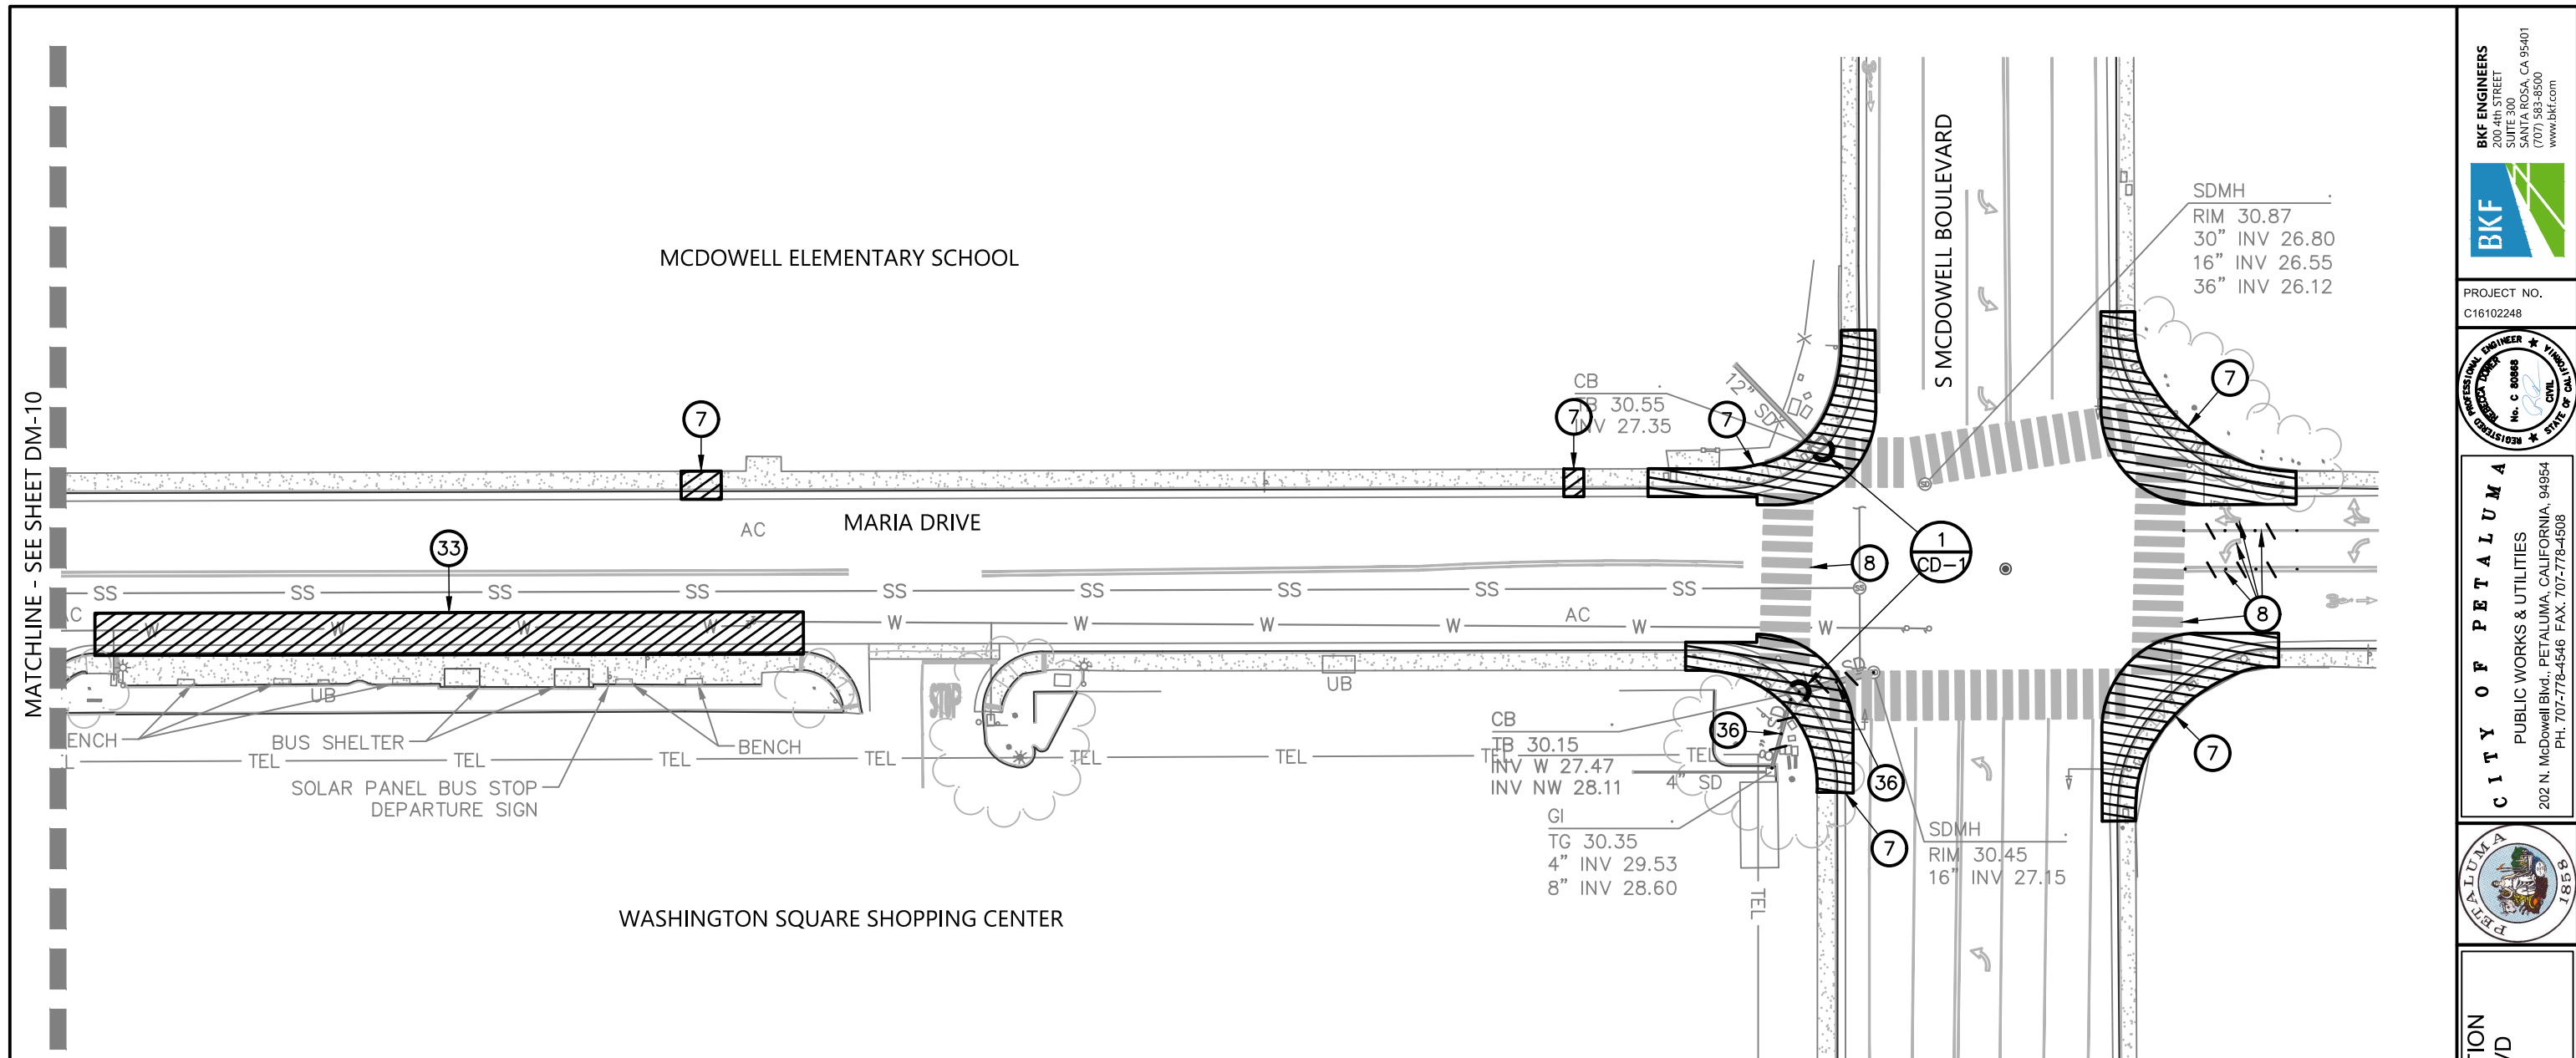

**KEYNOTES:**

- ⑦ SAWCUT AND REMOVE EXISTING CONCRETE FLATWORK AND/OR ASPHALT AND CURB AND GUTTER.
- ⑧ REMOVE EXISTING STRIPING.
- ③③ SAWCUT AND REMOVE PORTIONS OF EXISTING ASPHALT TO FACILITATE INSTALLATION OF PROPOSED IMPROVEMENTS.
- ③⑥ REMOVE EXISTING STORM DRAIN TO FACILITATE THE PROPOSED IMPROVEMENTS AND DISPOSE OF UNUSED MATERIAL IN ACCORDANCE WITH LOCAL REGULATIONS.

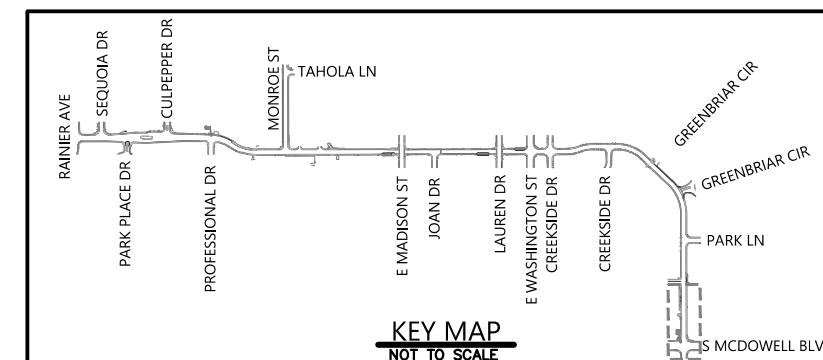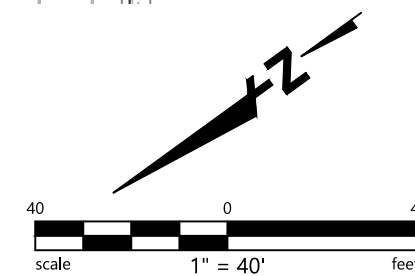


**KEY MAP**  
NOT TO SCALE

**BKF ENGINEERS**  
200 4th STREET  
SUITE 300  
SANTA ROSA, CA 95401  
(707) 583-8500  
www.bkf.com



PROJECT NO.  
C16102248

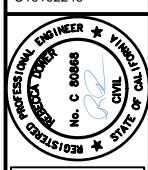

**CITY OF PETALUMA**  
PUBLIC WORKS & UTILITIES  
202 N. McDowell Blvd., PETALUMA, CALIFORNIA, 94954  
PH. 707-778-4546 FAX. 707-778-4508




**MARIA DRIVE - STREET REHABILITATION  
RAINIER AVE TO S MCDOWELL BLVD  
DEMOLITION PLAN  
STA 66+00 TO STA 71+75**

SHEET


**DM-11**

28 OF 83

Plot Date: 06/20/2023 at 4:50pm  
220332\_01\_DM.dwg  
COPYRIGHT © 2022 BKF ENGINEERS

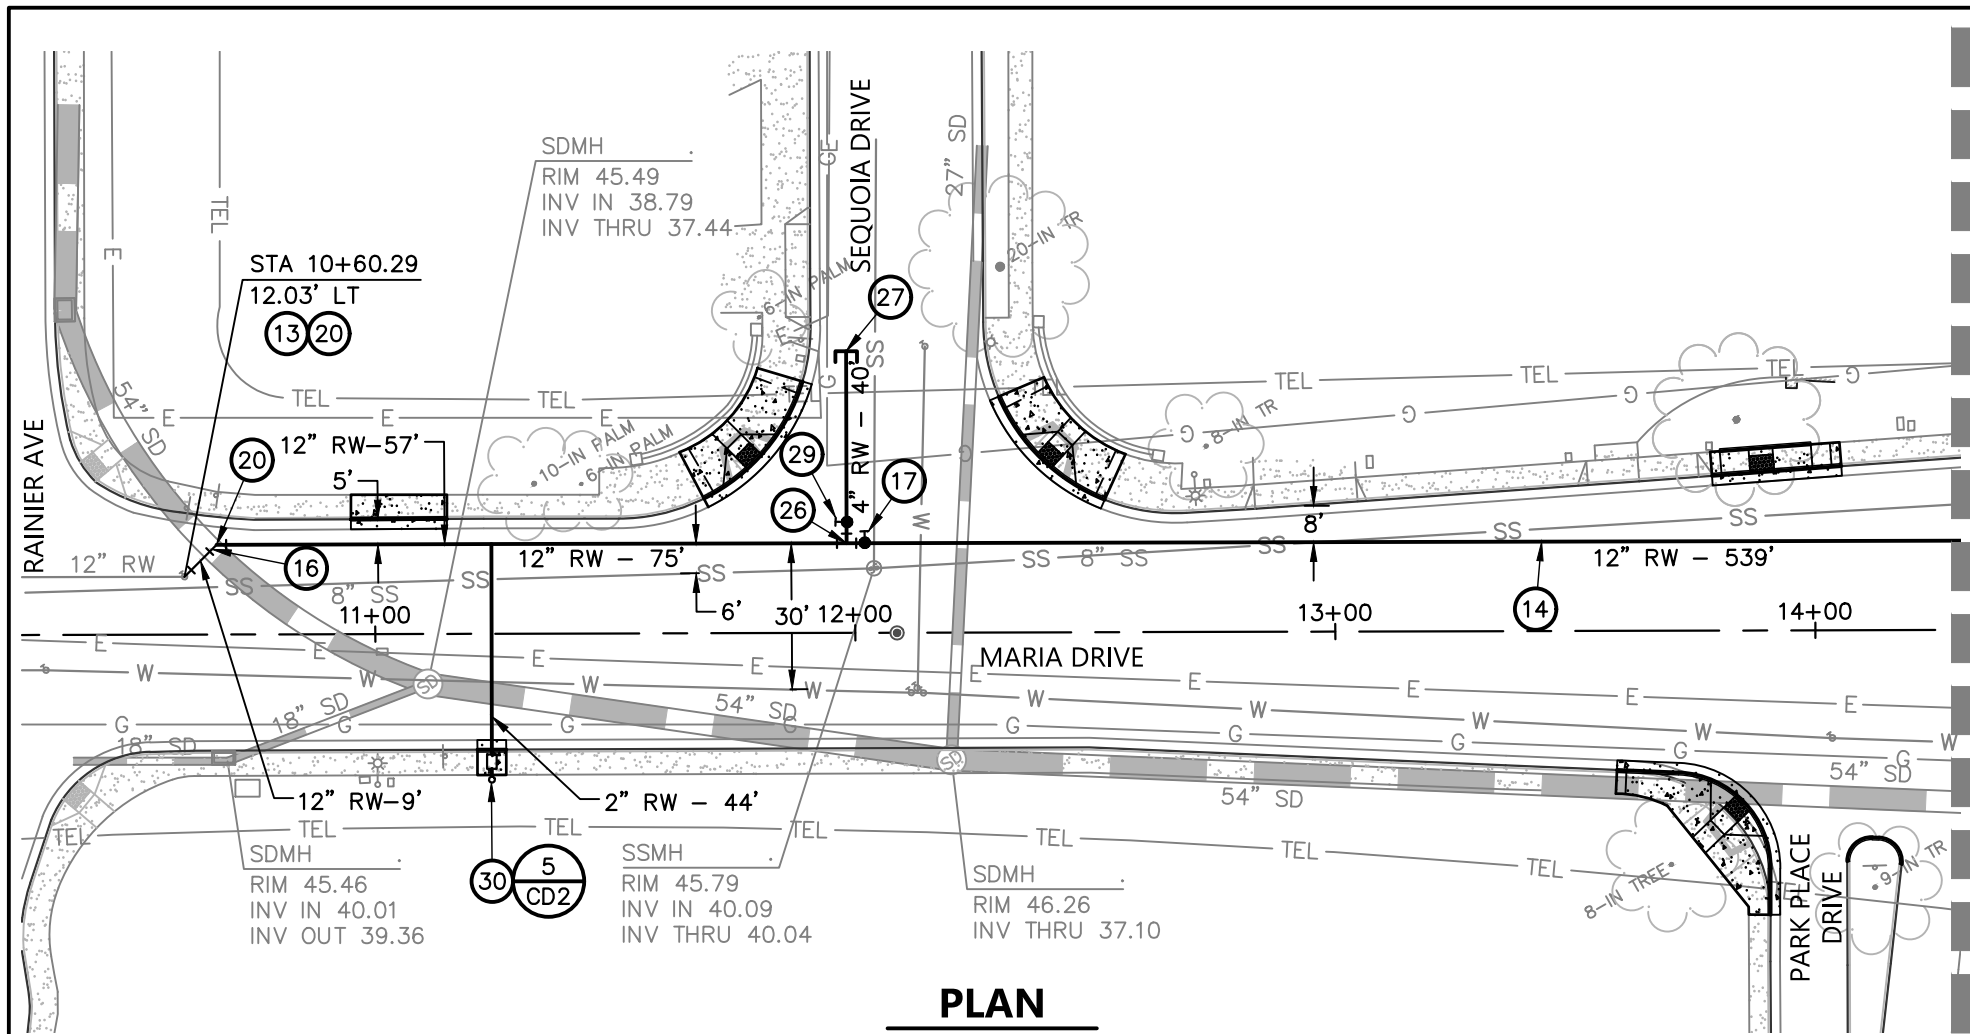



**PLAN**  
 STA 10+35 TO STA 14+30  
 SCALE: 1"=40'

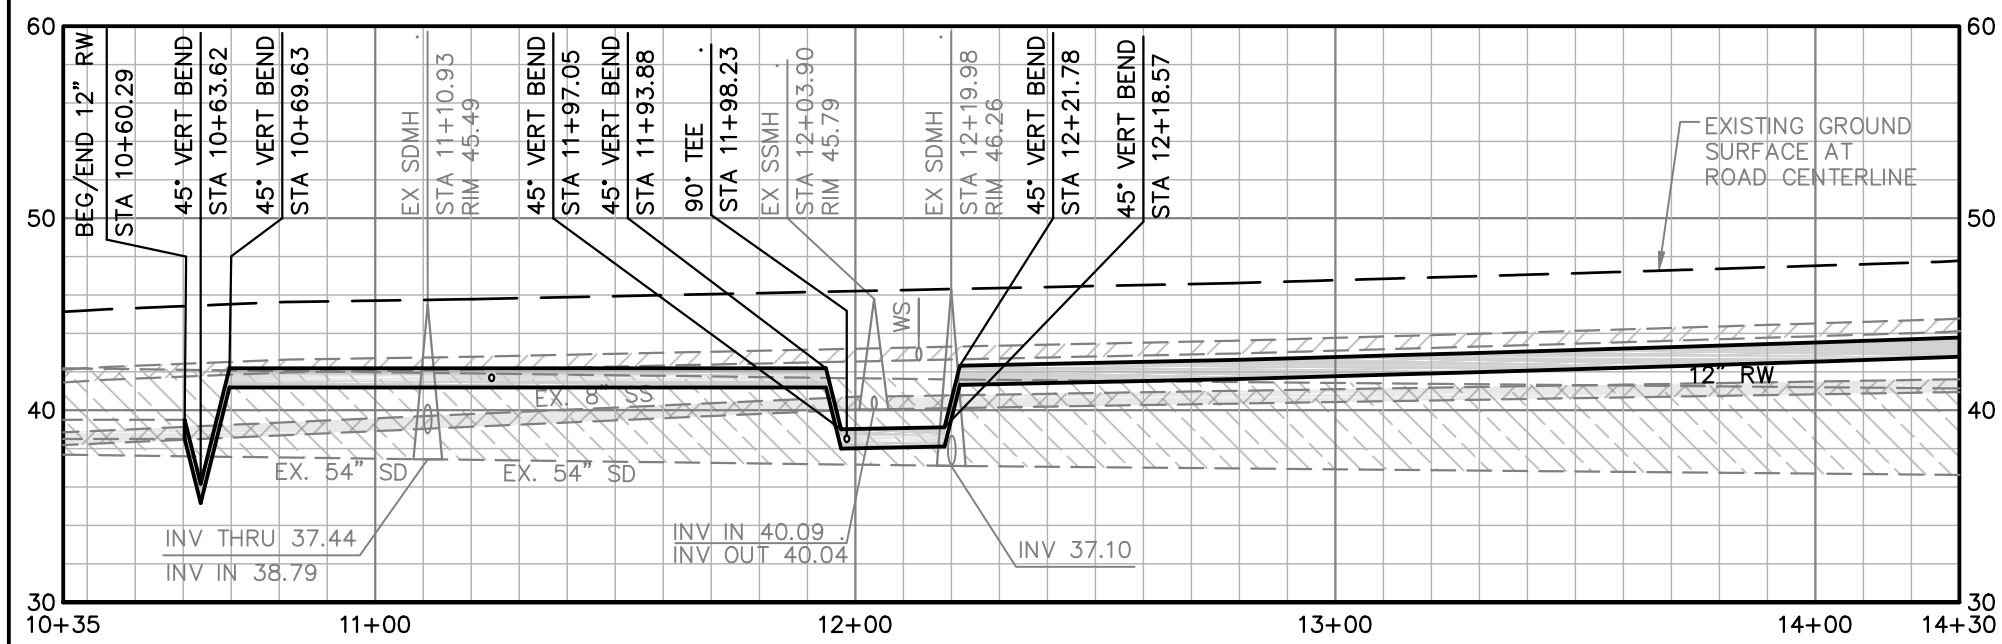

**PROFILE**  
 STA 10+35 TO STA 14+30  
 SCALE: H: 1"=40'; V: 1"=10'

**KEYNOTES:**


- 13 REMOVE EXISTING BLIND FLANGE AND CONNECT NEW RECYCLED WATER MAIN WITH A MECHANICAL JOINT.
- 14 INSTALL C905 PVC (PURPLE PIPE). MINIMUM DEPTH OF COVER 42-INCHES, IN A RECYCLED WATER UTILITY TRENCH IN ACCORDANCE WITH CITY OF PETALUMA STDS. 219.1 - 219.3. MAINTAIN MINIMUM 12-INCH VERTICAL CLEARANCE BETWEEN EXISTING UTILITIES AND RECYCLED WATER MAIN.
- 16 INSTALL WATER MAIN LOWERING IN ACCORDANCE WITH CITY OF PETALUMA STD. 855.01 IF RECYCLED WATER IN CONFLICT WITH EXISTING UTILITIES.
- 17 INSTALL 12-INCH GATE VALVE IN ACCORDANCE WITH CITY OF PETALUMA STD. 877.01.
- 20 INSTALL 12-INCH, 45 DEGREE ELBOW.
- 26 INSTALL 12x4x12-INCH TEE.
- 27 INSTALL 4-INCH BLIND FLANGE.
- 29 4-INCH GATE VALVE IN ACCORDANCE WITH CITY OF PETALUMA STD. 877.01.
- 30 INSTALL NEW 2" SERVICE FROM RECYCLED WATER MAIN IN ACCORDANCE WITH CITY OF PETALUMA STD 865.

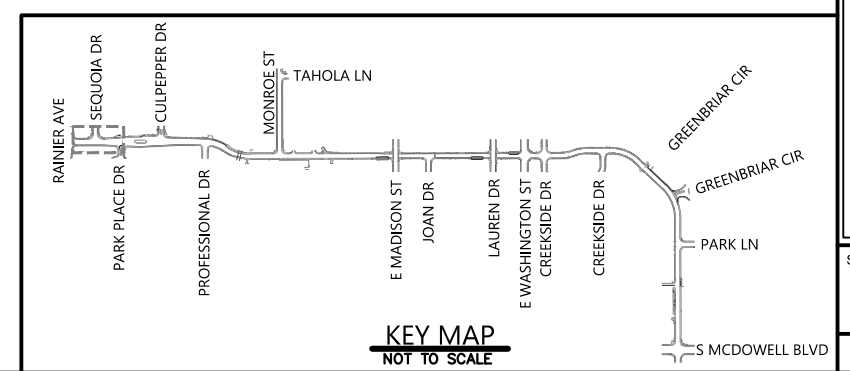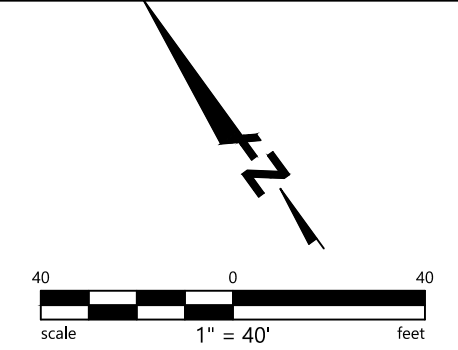

**KEY MAP**  
 NOT TO SCALE



PROJECT NO.  
 C16102248

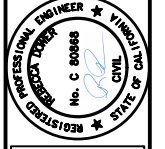


**CITY OF PETALUMA**  
 PUBLIC WORKS & UTILITIES  
 202 N. McDowell Blvd., PETALUMA, CALIFORNIA, 94954  
 PH. 707-778-4546 FAX. 707-778-4508






MARIA DRIVE - STREET REHABILITATION  
 RAINIER AVE TO S MCDOWELL BLVD  
 UTILITY PLAN AND PROFILE  
 STA 10+35 TO STA 14+30

SHEET  
**UT-1**  
 29 OF 83

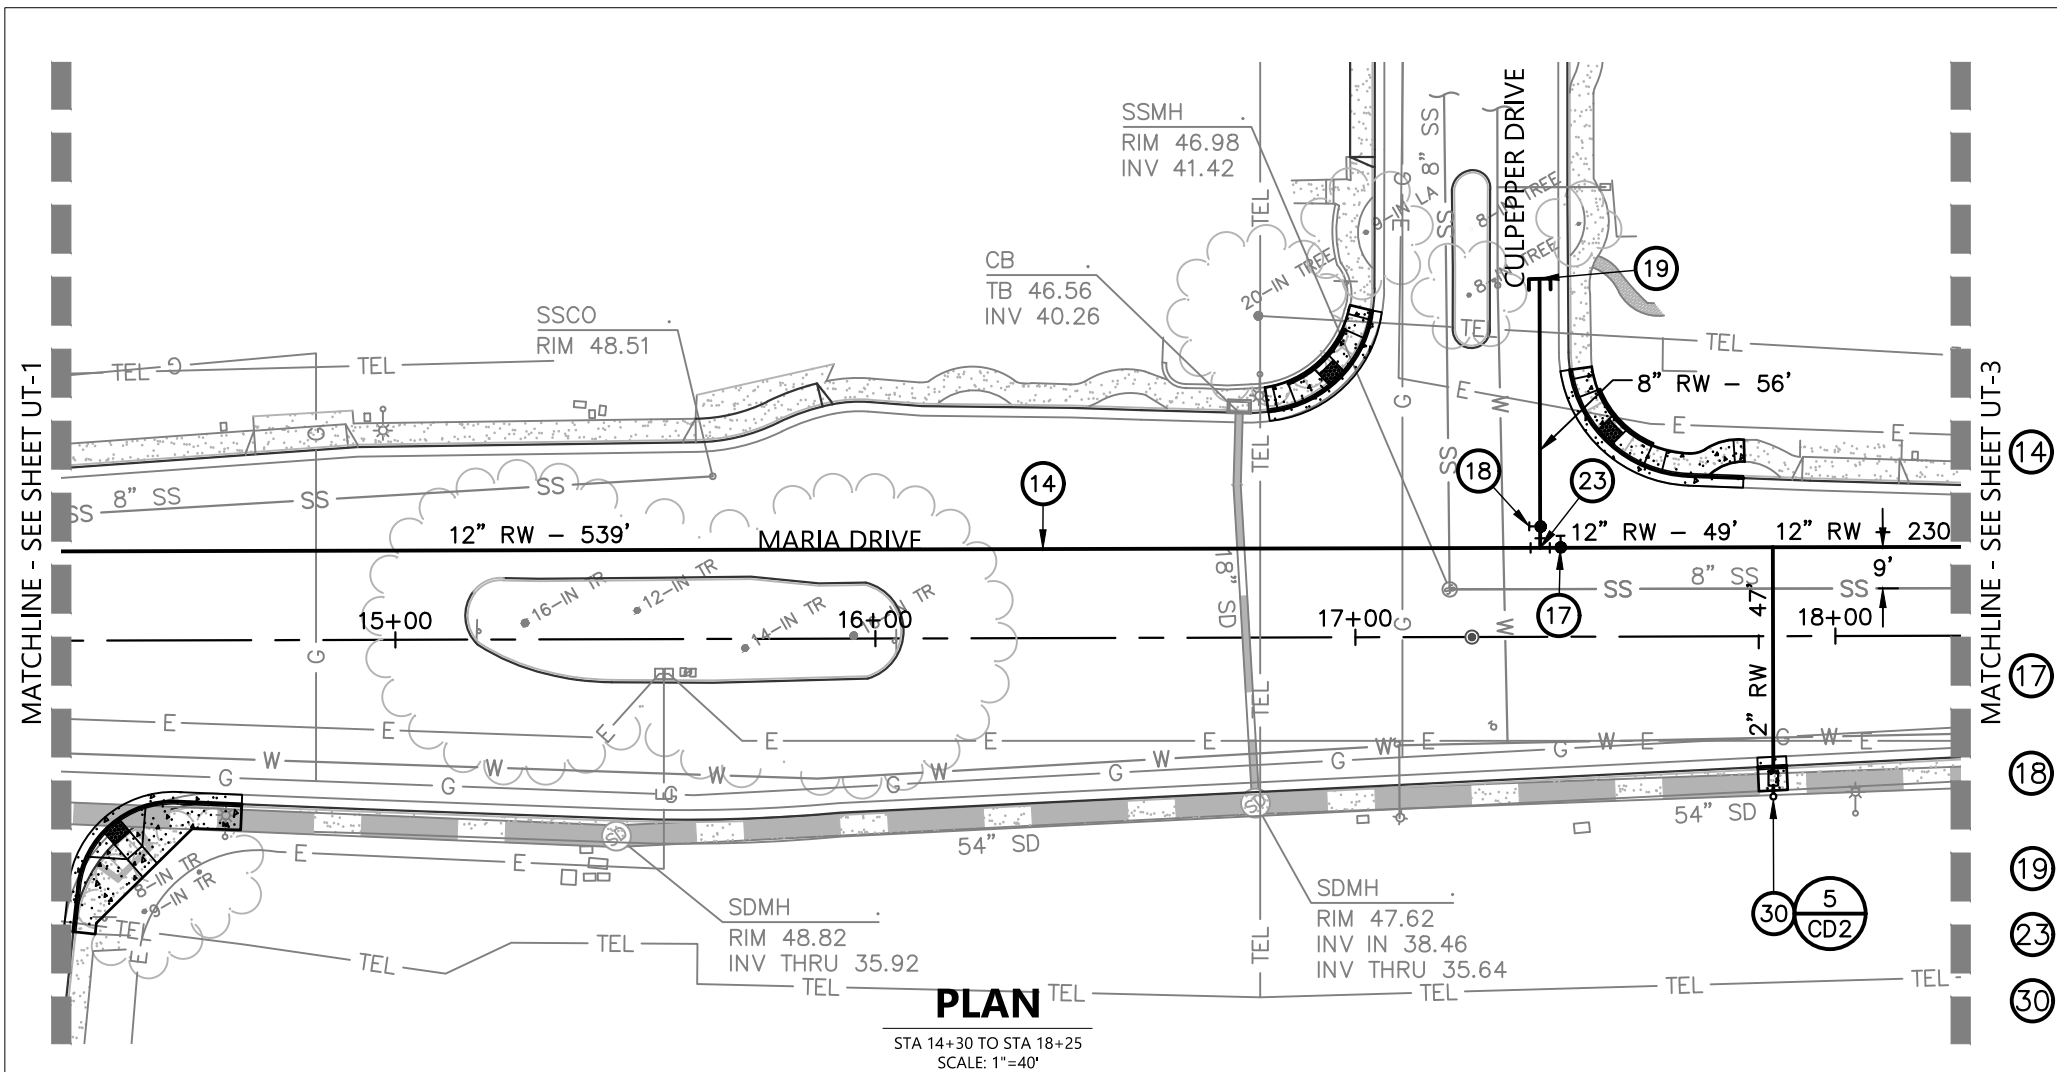

**KEYNOTES:**

- 14 INSTALL C905 PVC (PURPLE PIPE). MINIMUM DEPTH OF COVER 42-INCHES, IN A RECYCLED WATER UTILITY TRENCH IN ACCORDANCE WITH CITY OF PETALUMA STDS. 219.1 - 219.3. MAINTAIN MINIMUM 12-INCH VERTICAL CLEARANCE BETWEEN EXISTING UTILITIES AND RECYCLED WATER MAIN.
- 17 INSTALL 12-INCH GATE VALVE IN ACCORDANCE WITH CITY OF PETALUMA STD. 877.01.
- 18 INSTALL 8-INCH GATE VALVE IN ACCORDANCE WITH CITY OF PETALUMA STD. 877.01.
- 19 INSTALL 8-INCH BLIND FLANGE.
- 23 INSTALL 12x8x12-INCH TEE.
- 30 INSTALL NEW 2" SERVICE FROM RECYCLED WATER MAIN IN ACCORDANCE WITH CITY OF PETALUMA STD 865.

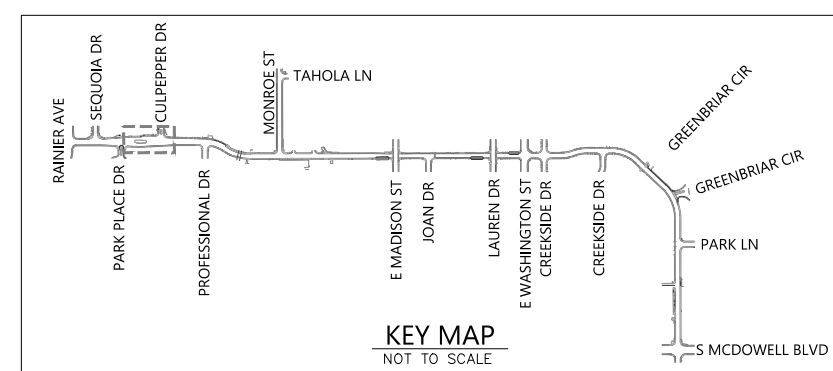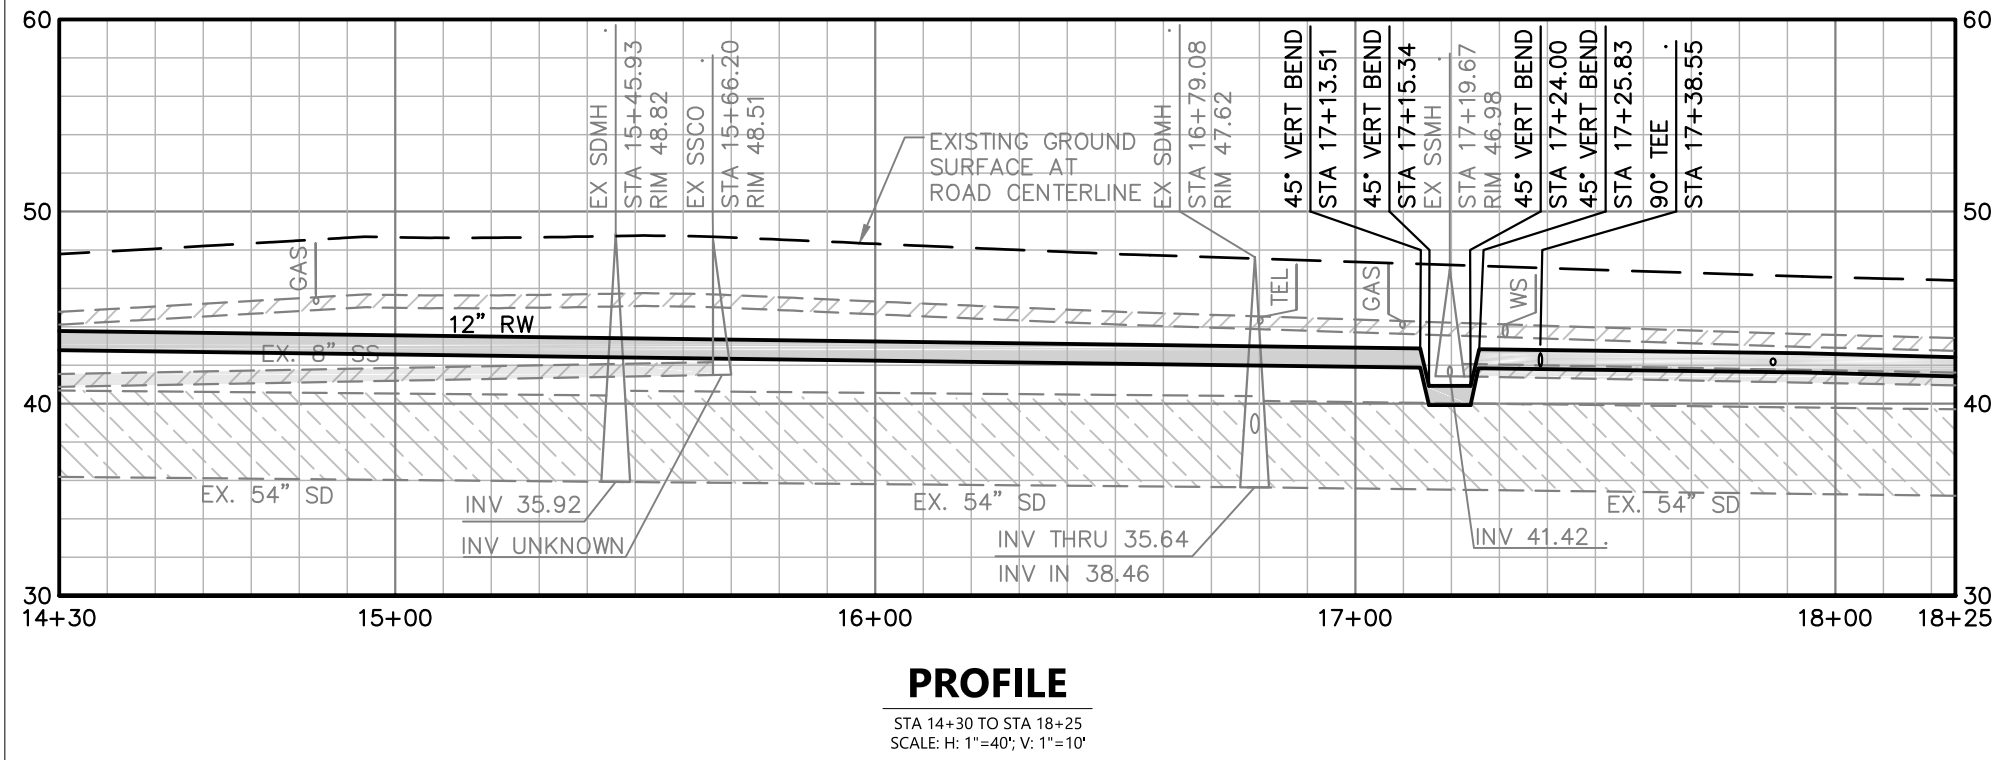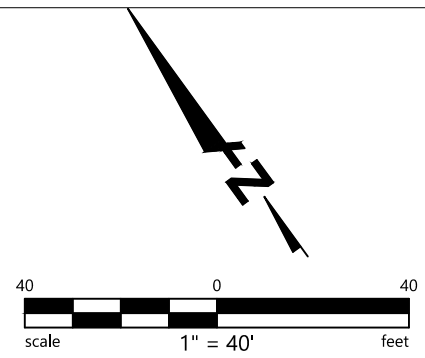

**MARIA DRIVE - STREET REHABILITATION**  
**RAINIER AVE TO S MCDOWELL BLVD**  
**UTILITY PLAN AND PROFILE**  
**STA 14+30 TO STA 18+25**



SHEET  
**UT-2**  
30 OF 83

BID SET

**BKF ENGINEERS**  
200 4TH STREET  
SUITE 300  
SANTA ROSA, CA 95401  
(707) 583-8500  
www.bkf.com


PROJECT NO.  
C16102248

**CITY OF PETALUMA**  
PUBLIC WORKS & UTILITIES  
202 N. McDowell Blvd., PETALUMA, CALIFORNIA, 94954  
PH. 707-778-4546 FAX. 707-778-4508

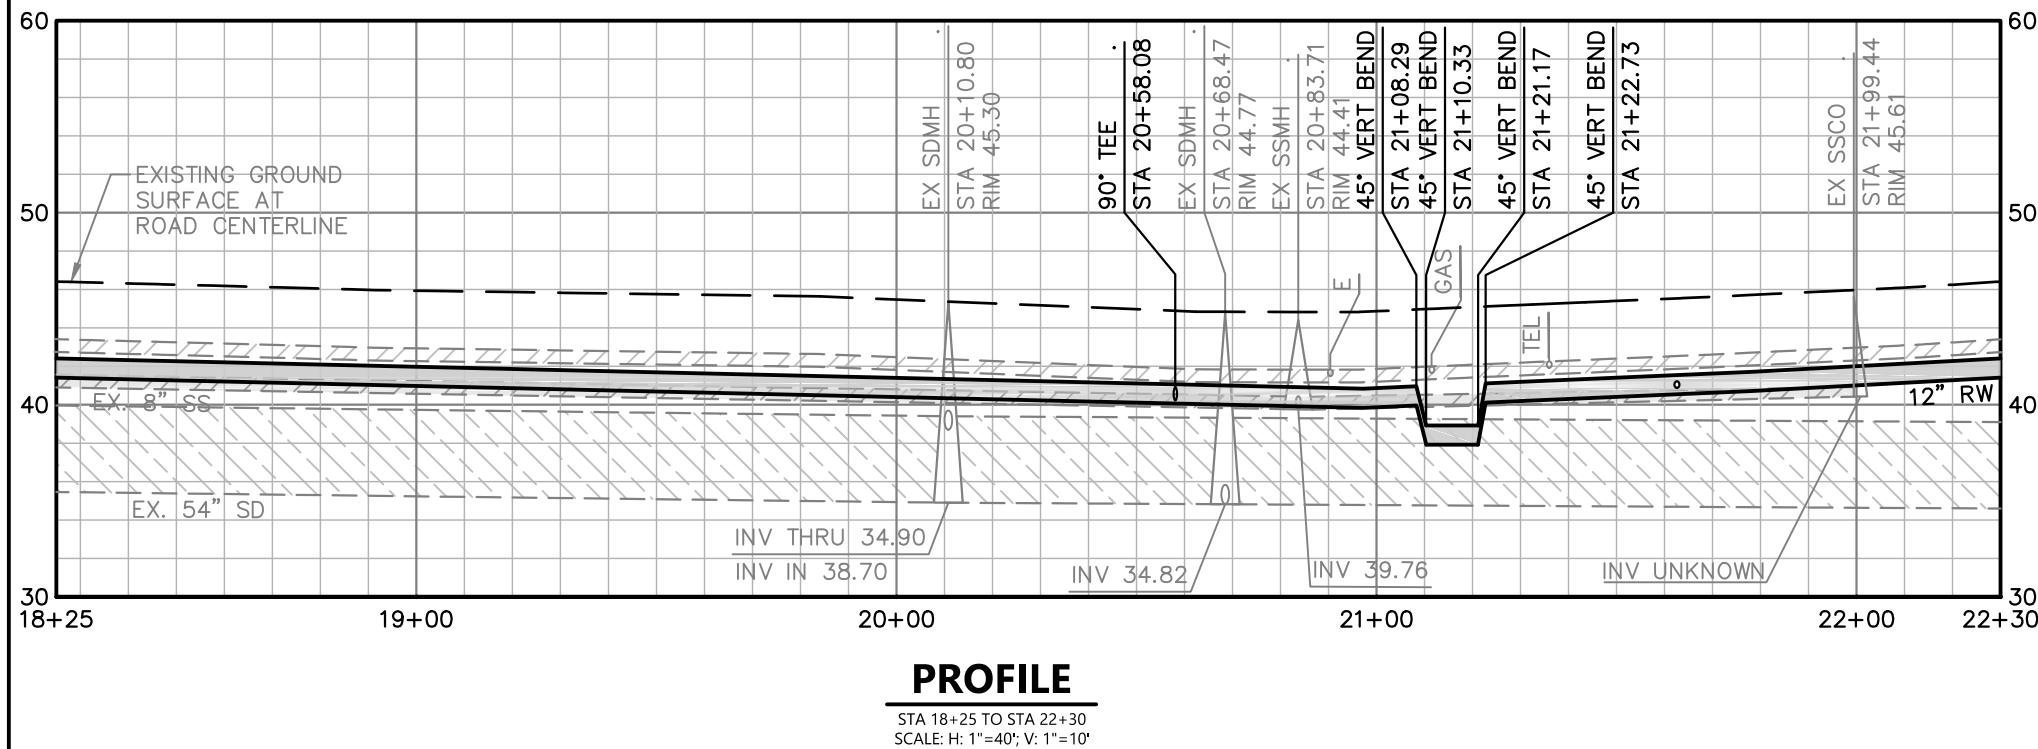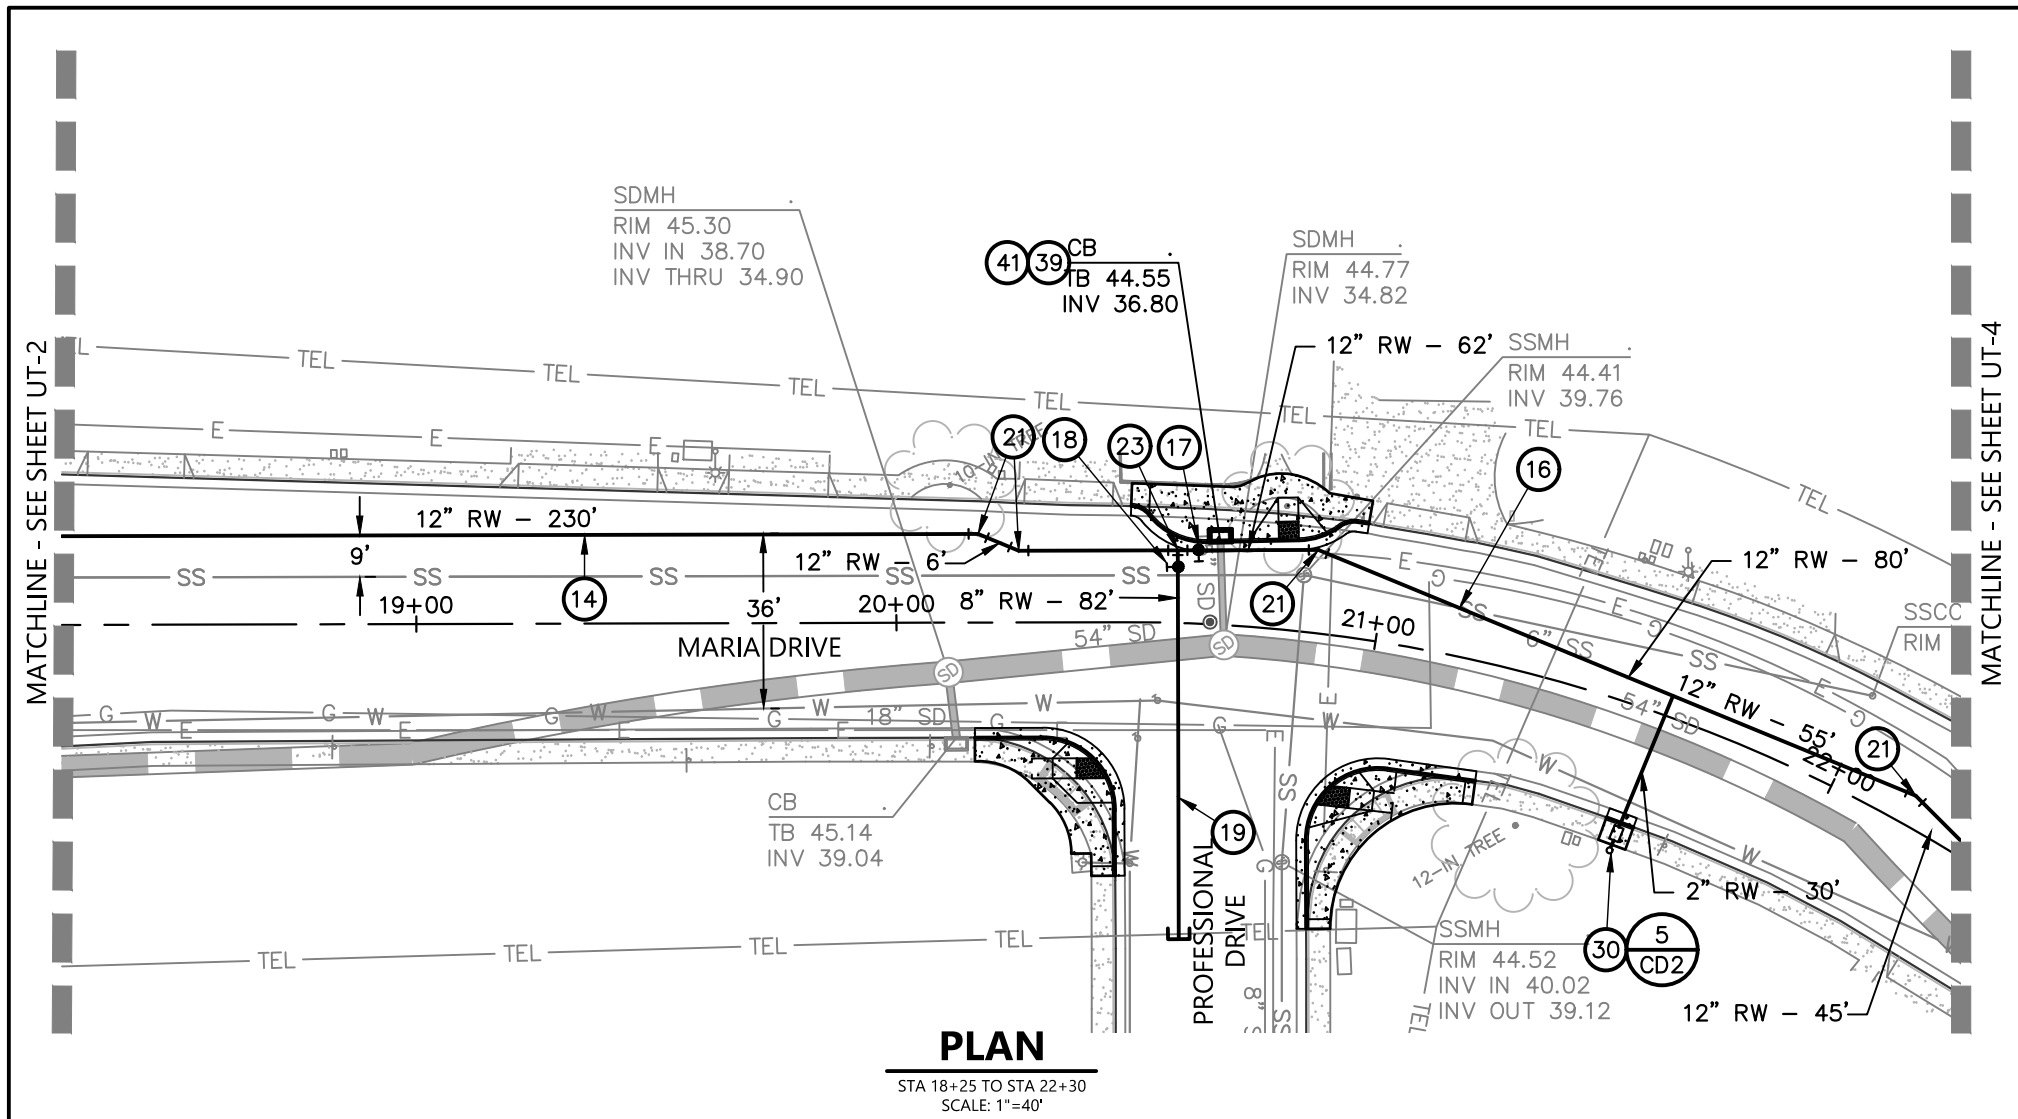



**KEYNOTES:**

 - 14 INSTALL C905 PVC (PURPLE PIPE). MINIMUM DEPTH OF COVER 42-INCHES, IN A RECYCLED WATER UTILITY TRENCH IN ACCORDANCE WITH CITY OF PETALUMA STDS. 219.1 - 219.3. MAINTAIN MINIMUM 12-INCH VERTICAL CLEARANCE BETWEEN EXISTING UTILITIES AND RECYCLED WATER MAIN.
- 16 INSTALL WATER MAIN LOWERING IN ACCORDANCE WITH CITY OF PETALUMA STD. 855.01 IF RECYCLED WATER IN CONFLICT WITH EXISTING UTILITIES.
- 17 INSTALL 12-INCH GATE VALVE IN ACCORDANCE WITH CITY OF PETALUMA STD. 877.01.
- 18 INSTALL 8-INCH GATE VALVE IN ACCORDANCE WITH CITY OF PETALUMA STD. 877.01.
- 19 INSTALL 8-INCH BLIND FLANGE.
- 21 INSTALL 12-INCH, 22.5 DEGREE ELBOW.
- 23 INSTALL 12x8x12-INCH TEE.
- 30 INSTALL NEW 2" SERVICE FROM RECYCLED WATER MAIN IN ACCORDANCE WITH CITY OF PETALUMA STD 865.
- 39 CONNECT TO EXISTING UTILITY IN A MANNER WHICH PROVIDES A PERMANENT WATER TIGHT SEAL.
- 41 TYPE "B" STORM DRAIN CATCH BASIN IN ACCORDANCE WITH CITY OF PETALUMA STD. 408.1. CAST IN PLACE OVER EXISTING STORM DRAIN PIPE.




**KEY MAP**  
NOT TO SCALE

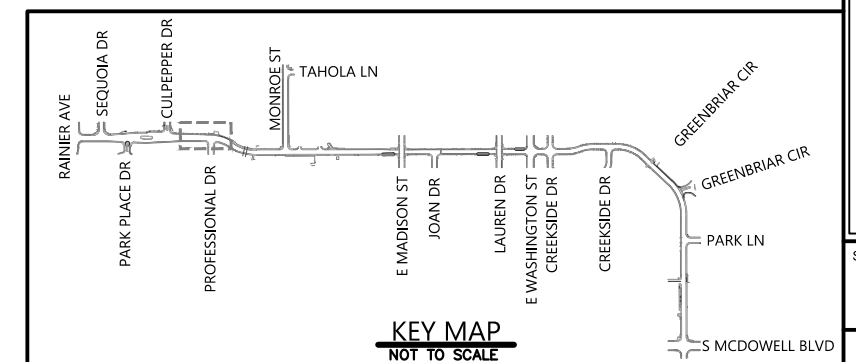

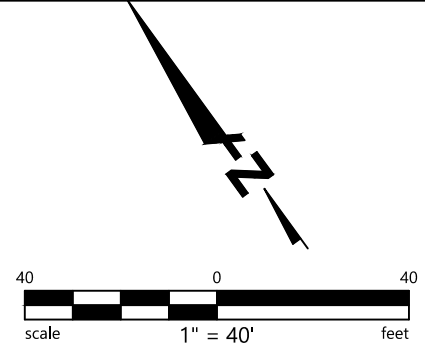


**KEYNOTES:**

- ⑭ INSTALL C905 PVC (PURPLE PIPE). MINIMUM DEPTH OF COVER 42-INCHES, IN A RECYCLED WATER UTILITY TRENCH IN ACCORDANCE WITH CITY OF PETALUMA STDS. 219.1 - 219.3. MAINTAIN MINIMUM 12-INCH VERTICAL CLEARANCE BETWEEN EXISTING UTILITIES AND RECYCLED WATER MAIN.
- ⑳ INSTALL 12-INCH, 45 DEGREE ELBOW.
- ㉑ INSTALL 12-INCH, 22.5 DEGREE ELBOW.
- ㉒ INSTALL 12-INCH, 11.25 DEGREE ELBOW.
- ④⑤ INSTALL DUCTILE IRON PIPE ENCASED WITHIN CONTROLLED DENSITY FILL. MAINTAIN MINIMUM 12-INCH VERTICAL CLEARANCE BETWEEN EXISTING UTILITIES AND RECYCLED WATER MAIN.

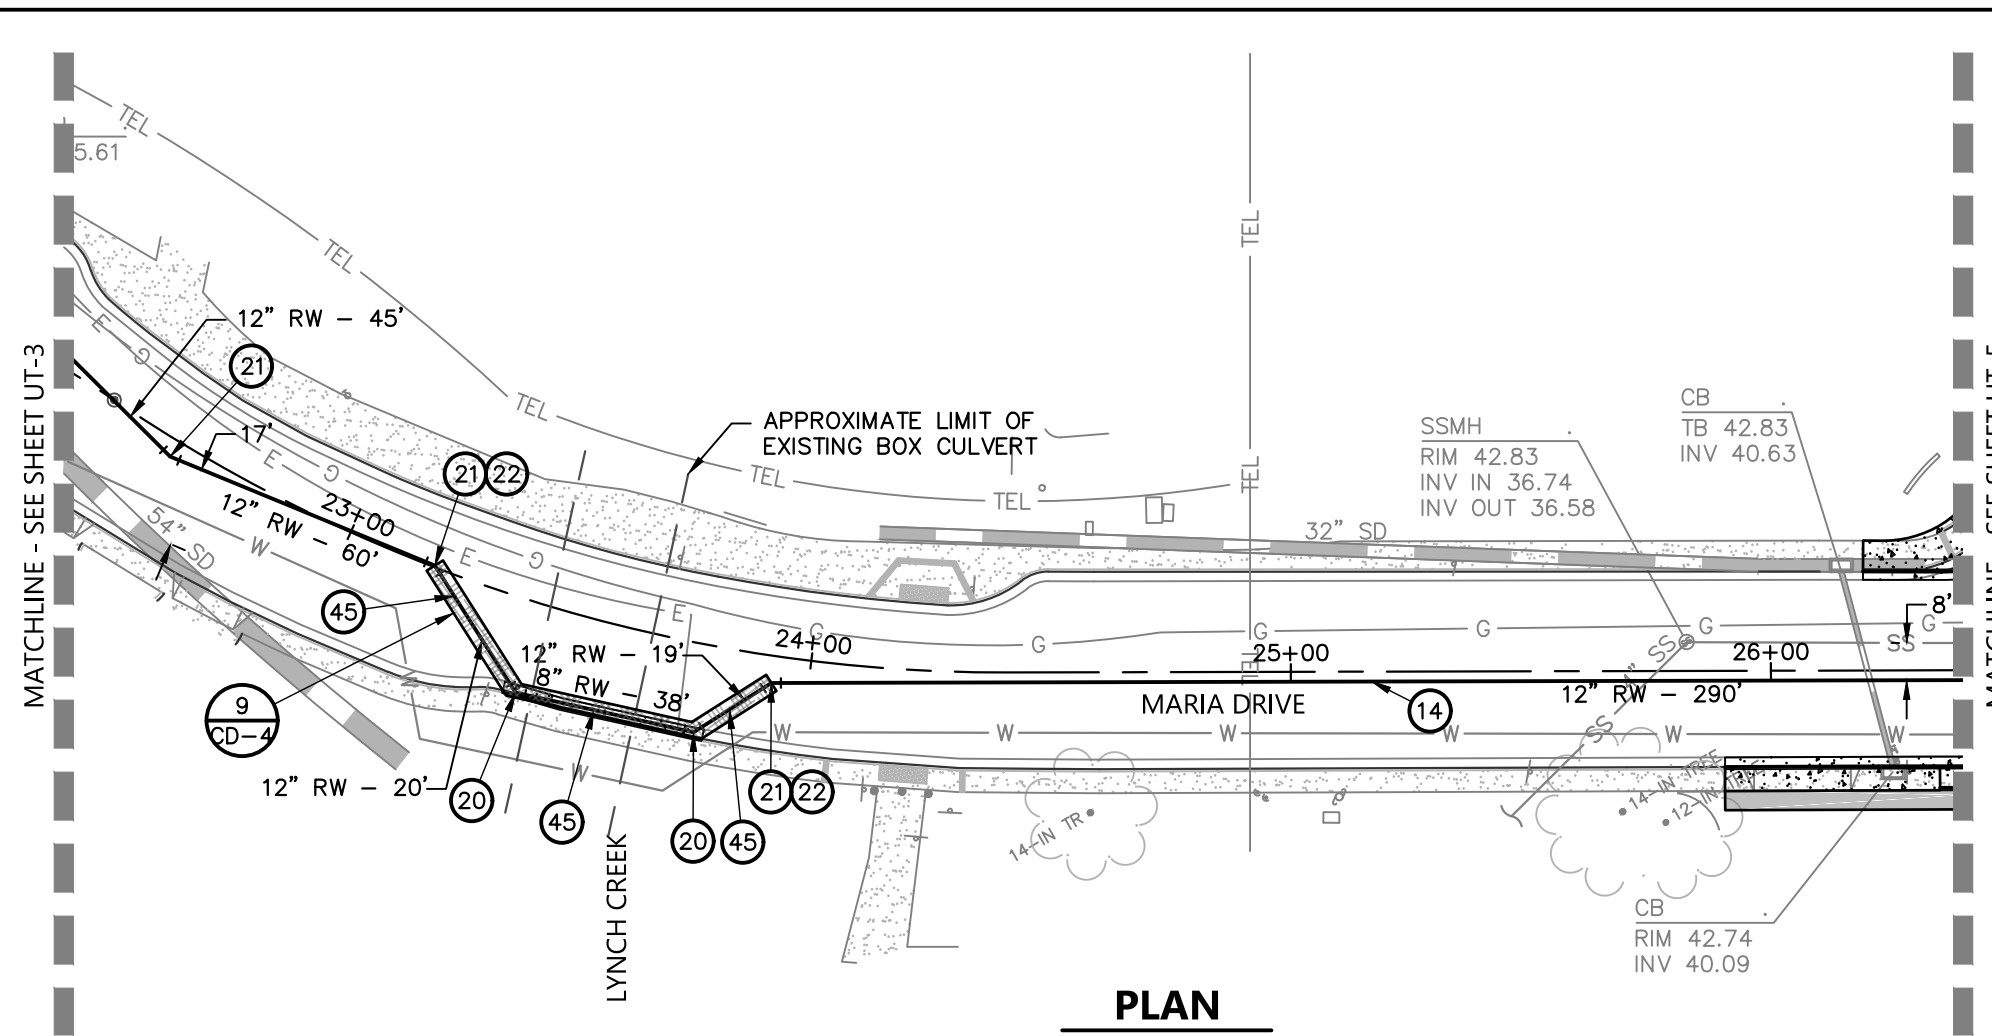


**PLAN**

STA 22+30 TO STA 26+40  
SCALE: 1"=40'


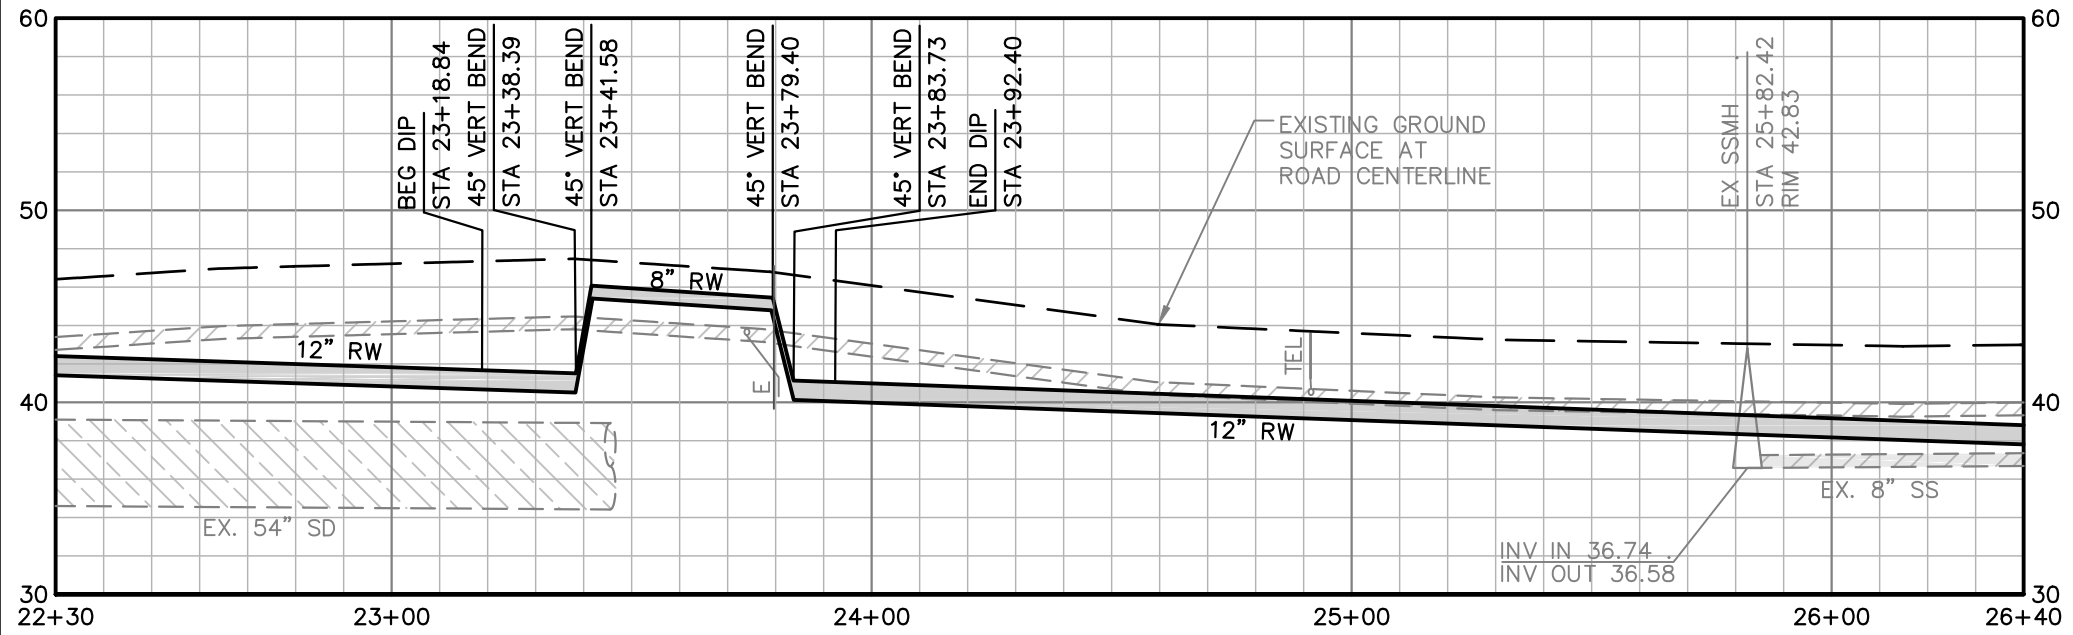


**PROFILE**

STA 22+30 TO STA 26+40  
SCALE: H: 1"=40'; V: 1"=10'


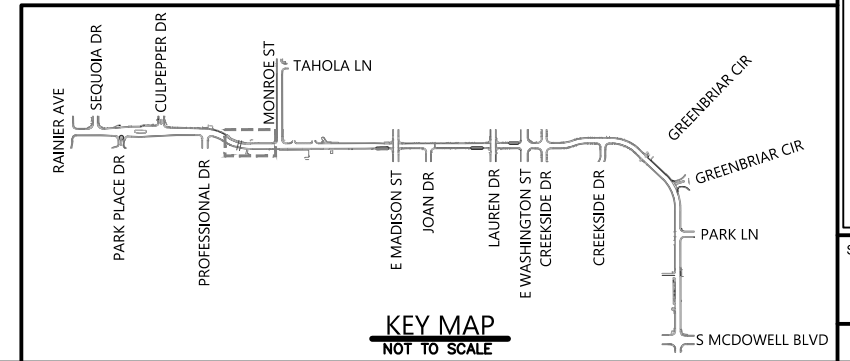


**KEY MAP**  
NOT TO SCALE

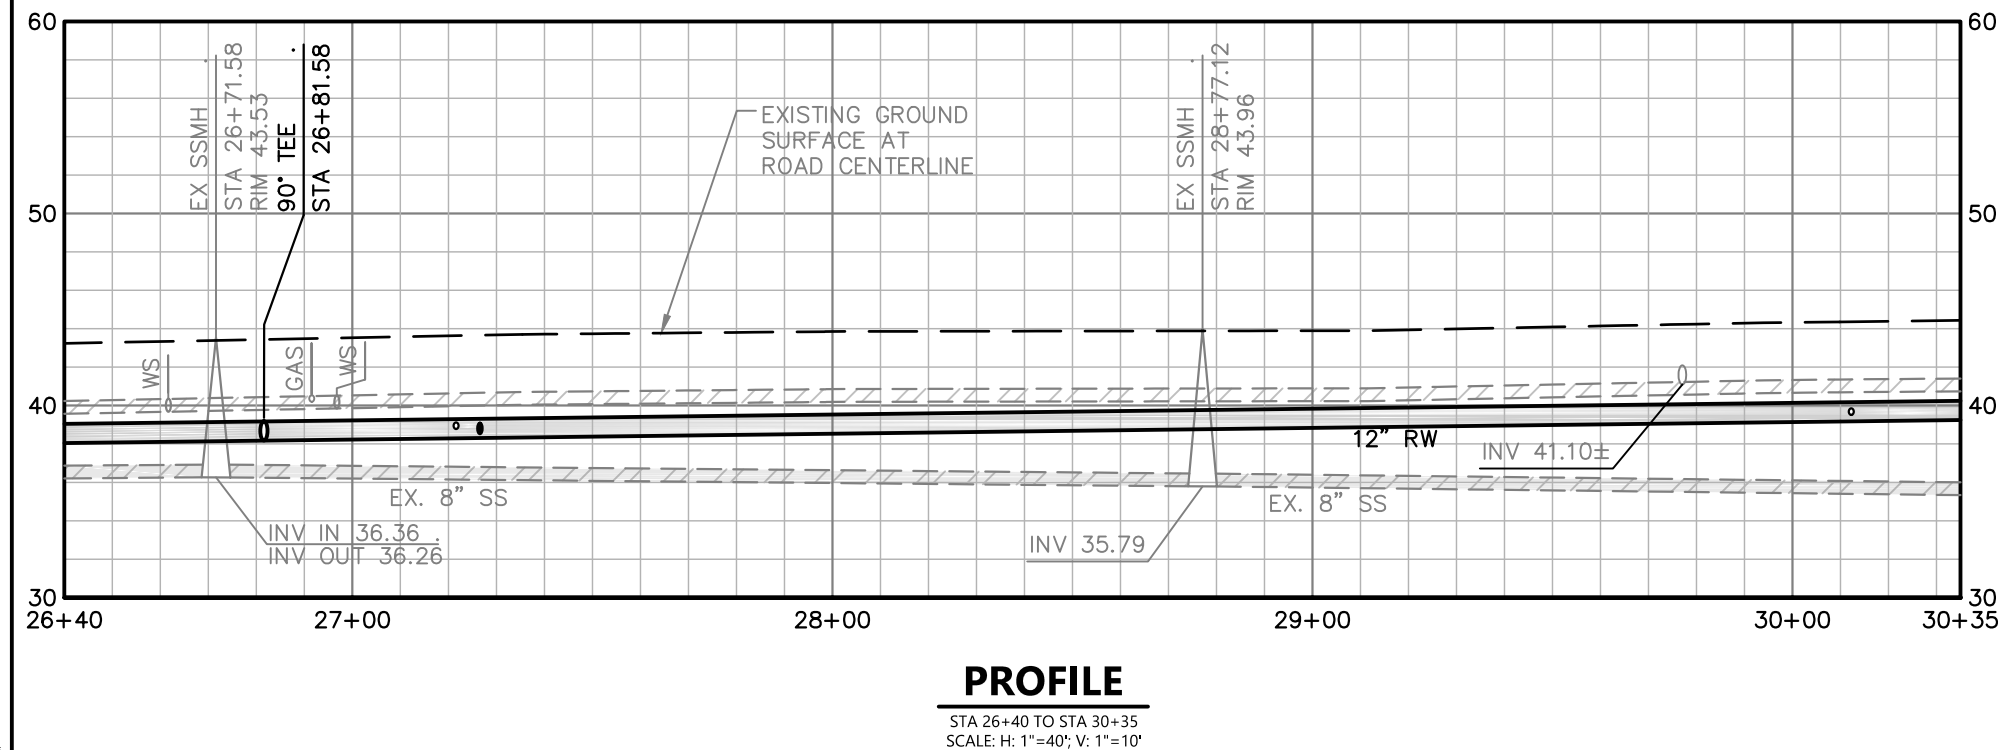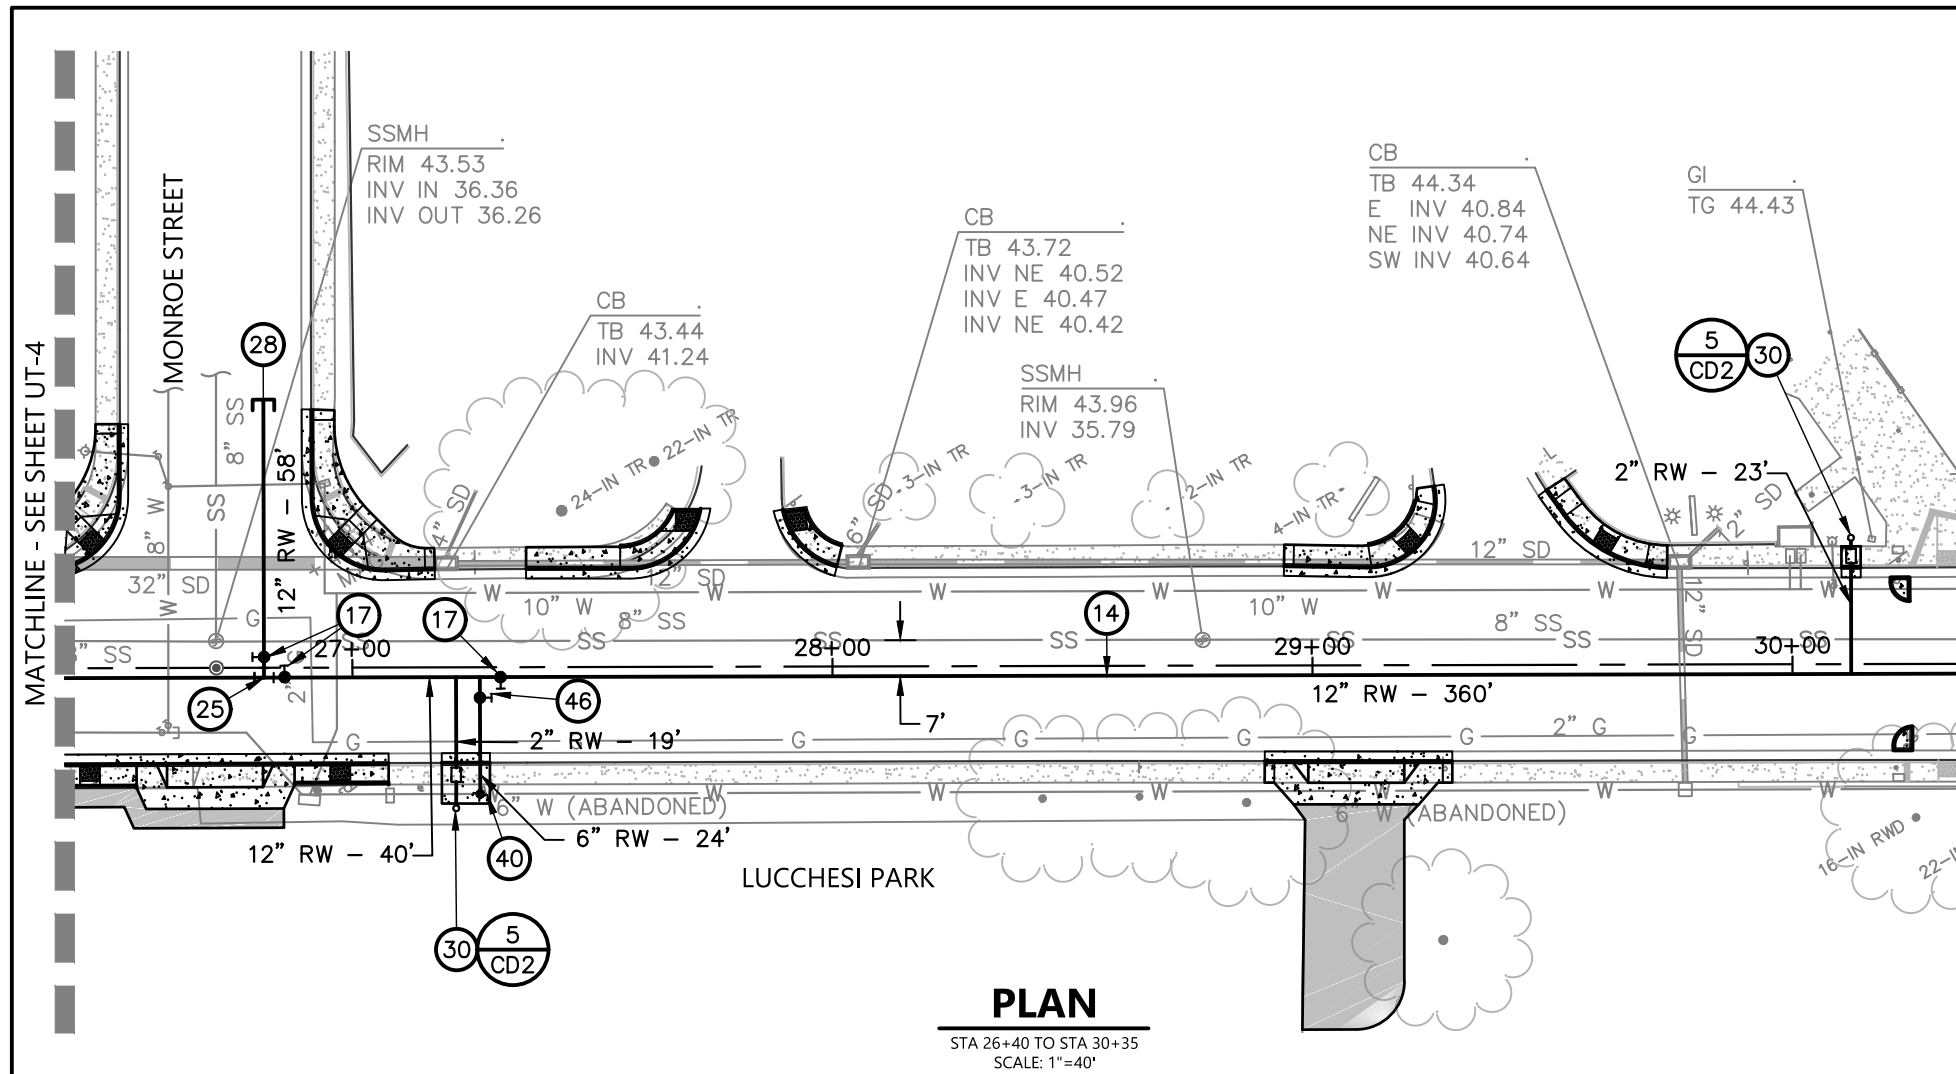

**KEYNOTES:**

 - ⑭ INSTALL C905 PVC (PURPLE PIPE). MINIMUM DEPTH OF COVER 42-INCHES, IN A RECYCLED WATER UTILITY TRENCH IN ACCORDANCE WITH CITY OF PETALUMA STDS. 219.1 - 219.3. MAINTAIN MINIMUM 12-INCH VERTICAL CLEARANCE BETWEEN EXISTING UTILITIES AND RECYCLED WATER MAIN.
- ⑰ INSTALL 12-INCH GATE VALVE IN ACCORDANCE WITH CITY OF PETALUMA STD. 877.01.
- ⑽ INSTALL 12x12x12-INCH TEE.
- ⑲ INSTALL 12-INCH BLIND FLANGE.
- ⑳ INSTALL NEW 2" SERVICE FROM RECYCLED WATER MAIN IN ACCORDANCE WITH CITY OF PETALUMA STD 865.
- ㉑ INSTALL FIRE HYDRANT IN ACCORDANCE WITH CITY OF PETALUMA STD. 857.01.

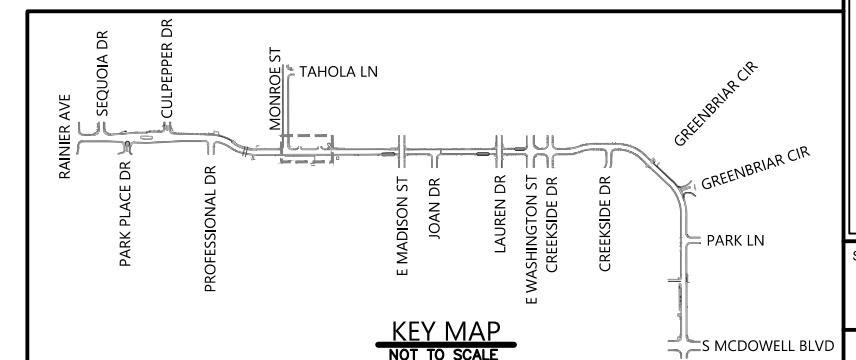

**BKF ENGINEERS**  
 200 4th STREET  
 SUITE 300  
 SANTA ROSA, CA 95401  
 (707) 583-8500  
 www.bkf.com



PROJECT NO.  
 C16102248



**CITY OF PETALUMA**  
 PUBLIC WORKS & UTILITIES  
 202 N. McDowell Blvd., PETALUMA, CALIFORNIA, 94954  
 PH. 707-778-4546 FAX. 707-778-4508






**MARIA DRIVE - STREET REHABILITATION**  
 RAINIER AVE TO S MCDOWELL BLVD  
 UTILITY PLAN AND PROFILE  
 STA 26+40 TO STA 30+35

SHEET

**UT-5**


33 OF 83




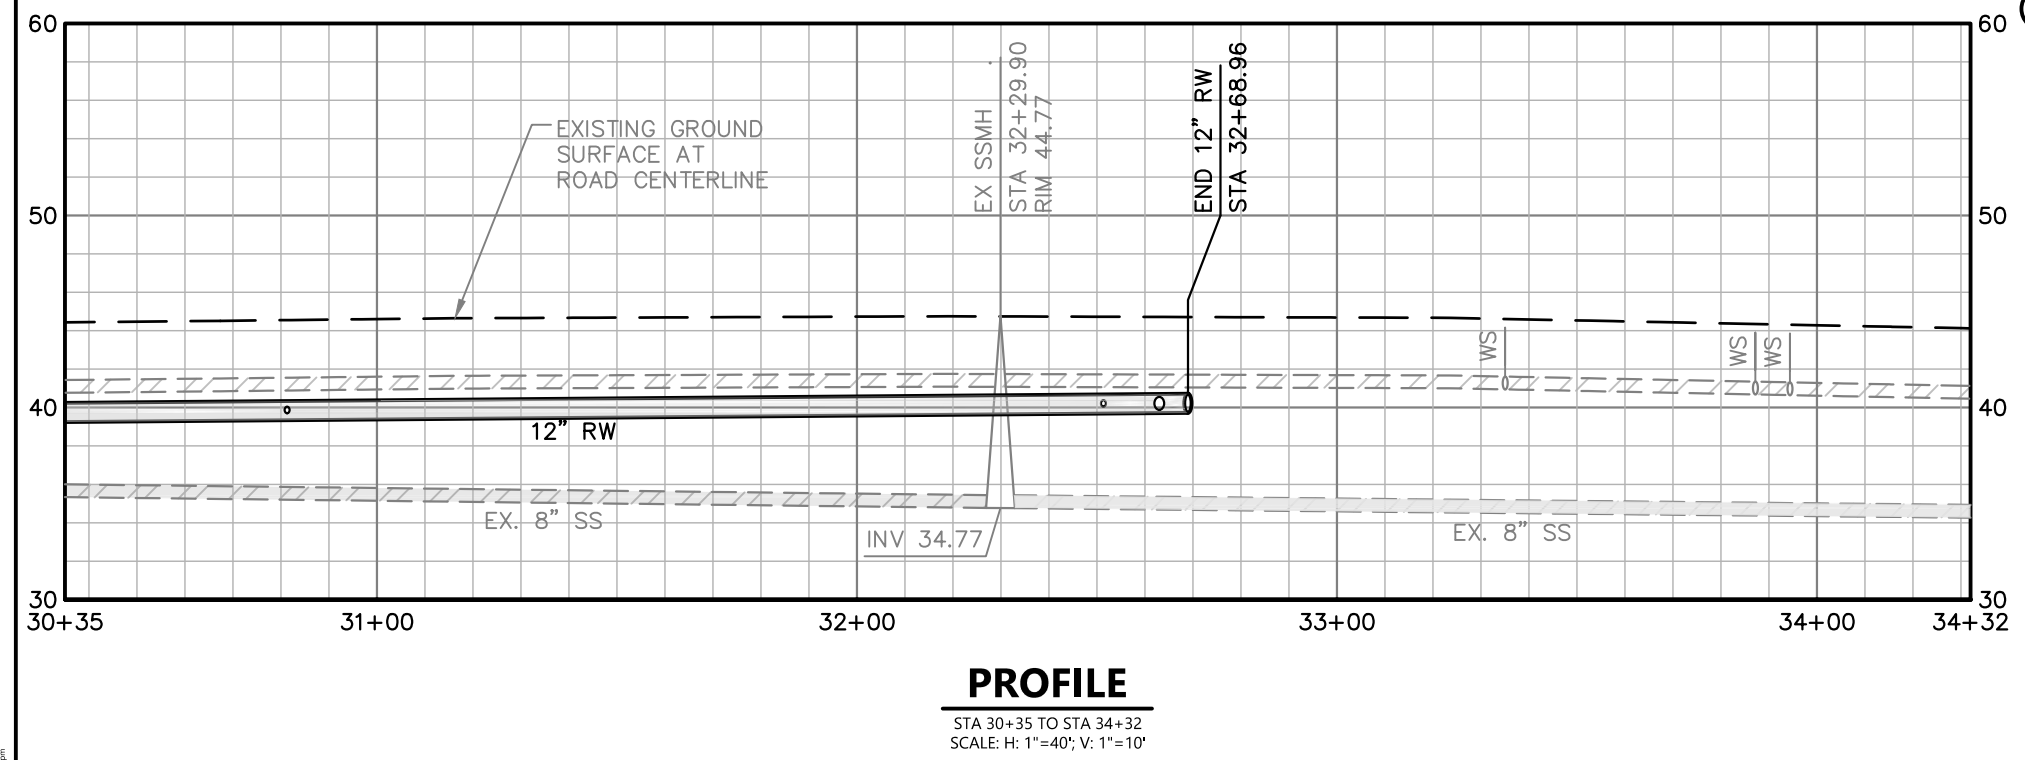
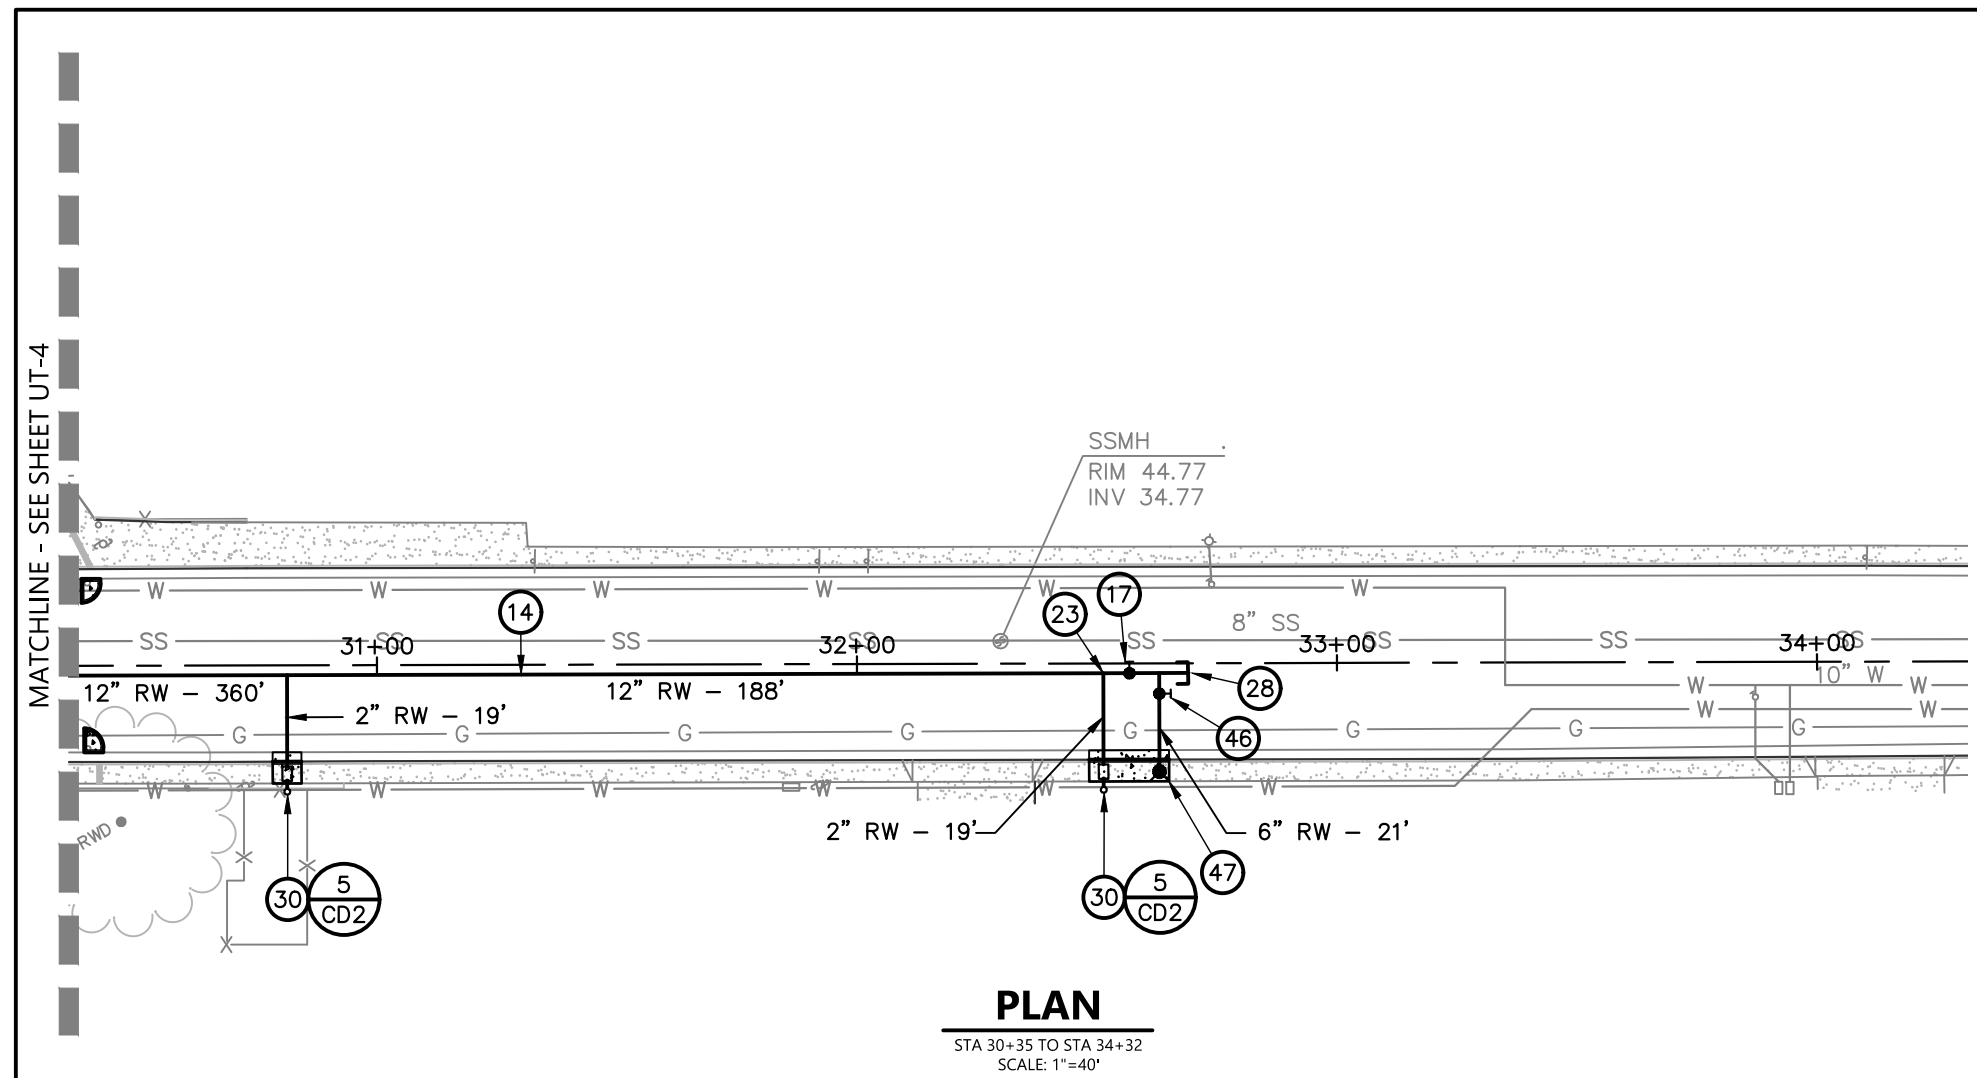
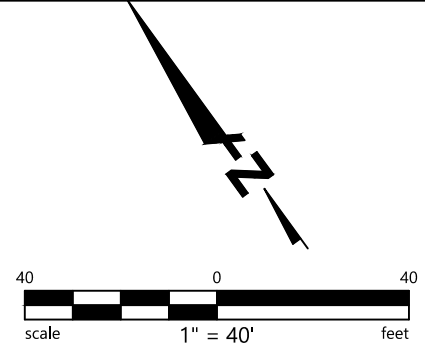


**KEYNOTES:**

- ⑭ INSTALL C905 PVC (PURPLE PIPE). MINIMUM DEPTH OF COVER 42-INCHES, IN A RECYCLED WATER UTILITY TRENCH IN ACCORDANCE WITH CITY OF PETALUMA STDS. 219.1 - 219.3. MAINTAIN MINIMUM 12-INCH VERTICAL CLEARANCE BETWEEN EXISTING UTILITIES AND RECYCLED WATER MAIN.
- ⑰ INSTALL 12-INCH GATE VALVE IN ACCORDANCE WITH CITY OF PETALUMA STD. 877.01.
- ⑳ INSTALL 12x8x12-INCH TEE.
- ㉘ INSTALL 12-INCH BLIND FLANGE.
- ㉚ INSTALL NEW 2" SERVICE FROM RECYCLED WATER MAIN IN ACCORDANCE WITH CITY OF PETALUMA STD 865.
- ④⑥ INSTALL 6-INCH GATE VALVE IN ACCORDANCE WITH CITY OF PETALUMA STD. 877.01.
- ④⑦ INSTALL 6-INCH BLOWOFF IN ACCORDANCE WITH CITY OF PETALUMA STD. 858.01 AND 858.02.

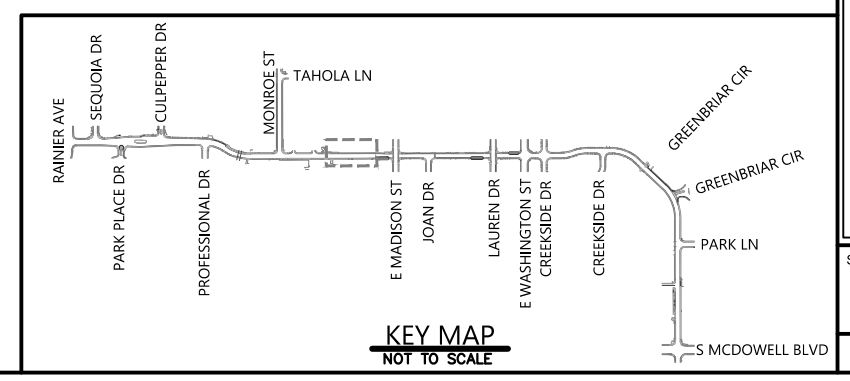


 Plot Sep 26, 2023 at 4:00pm  
 220332\_06\_UT.dwg  
 COPYRIGHT © 2022 BKF ENGINEERS

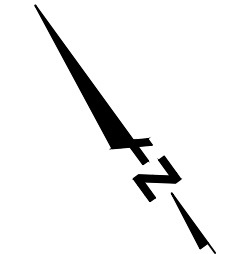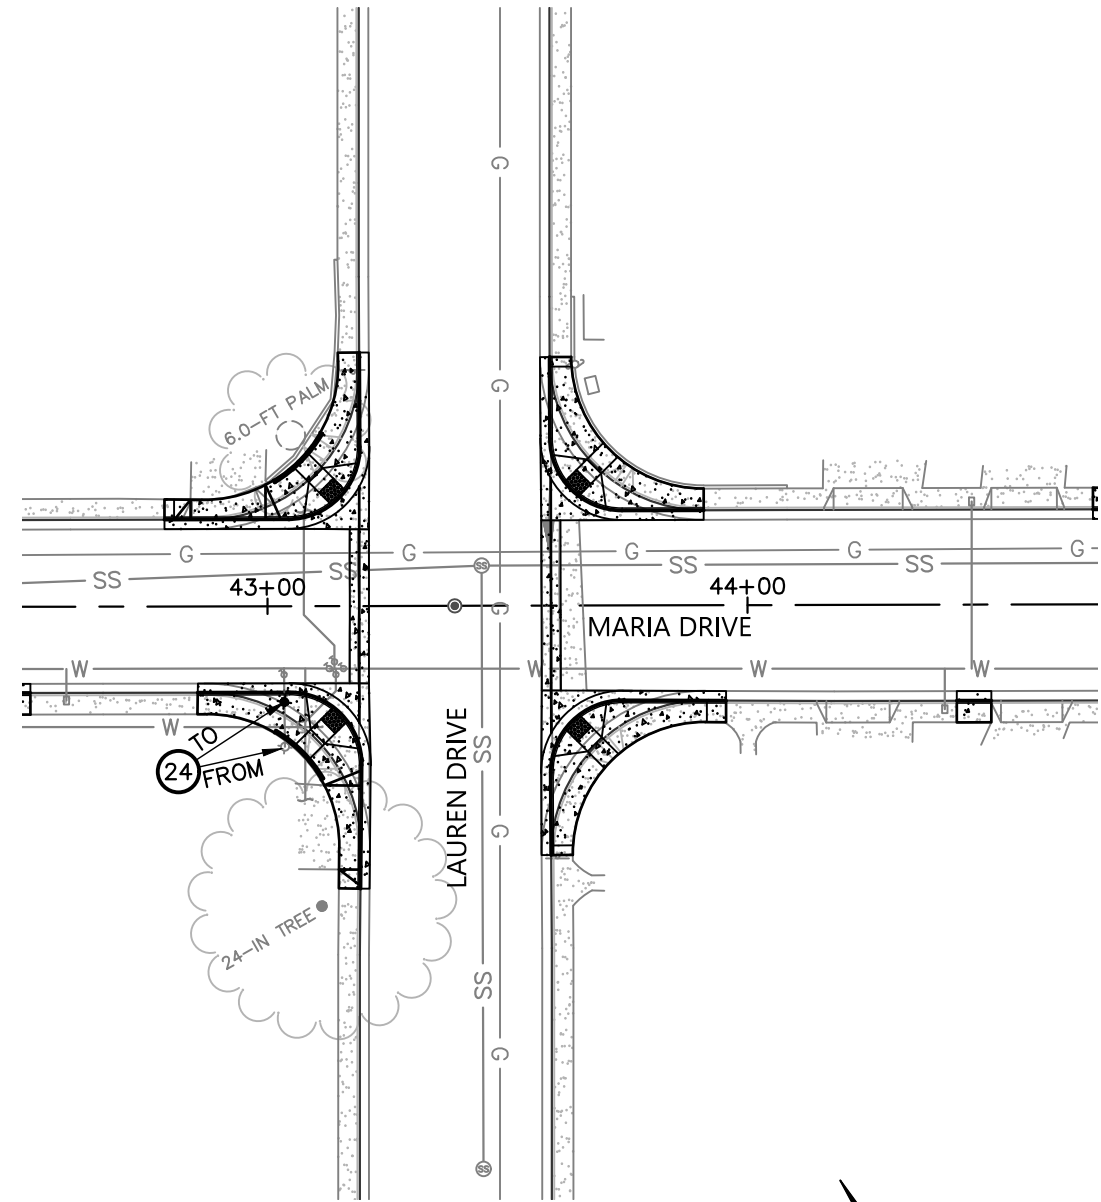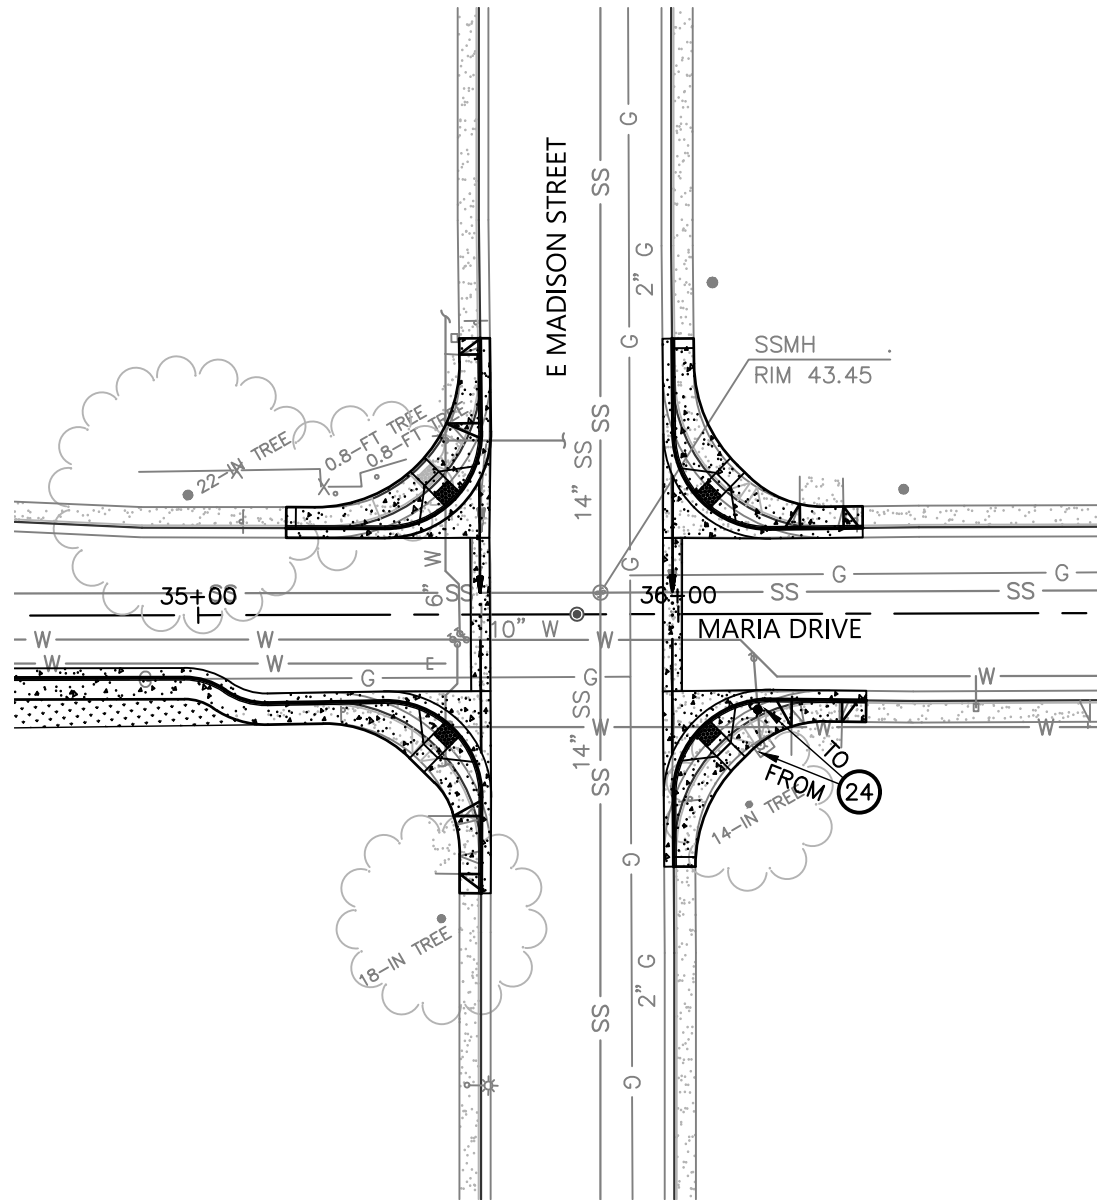

**KEYNOTES:**

- ②4 RELOCATE EXISTING FIRE HYDRANT IN ACCORDANCE WITH CITY OF PETALUMA STD. 857.01.

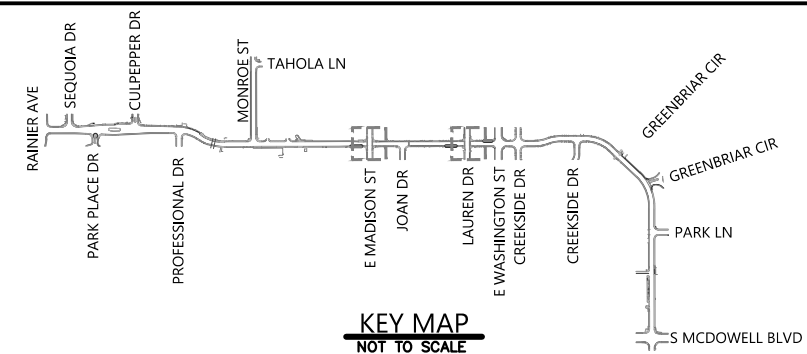

MARIA DRIVE - STREET REHABILITATION  
 RAINIER AVE TO S MCDOWELL BLVD  
 UTILITY PLAN STA 34+50 TO STA 36+75  
 AND STA 42+50 TO STA 44+75

SHEET

**UT-7**





35 OF 83

BID SET

**BKF ENGINEERS**  
 200 4th STREET  
 SUITE 300  
 SANTA ROSA, CA 95401  
 (707) 583-8500  
 www.bkf.com

PROJECT NO.  
 C16102248


**CITY OF PETALUMA**  
 PUBLIC WORKS & UTILITIES  
 202 N. McDowell Blvd., PETALUMA, CALIFORNIA, 94954  
 PH. 707-778-4546 FAX. 707-778-4508

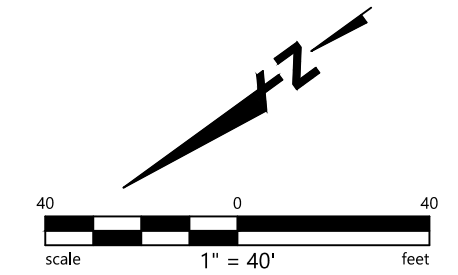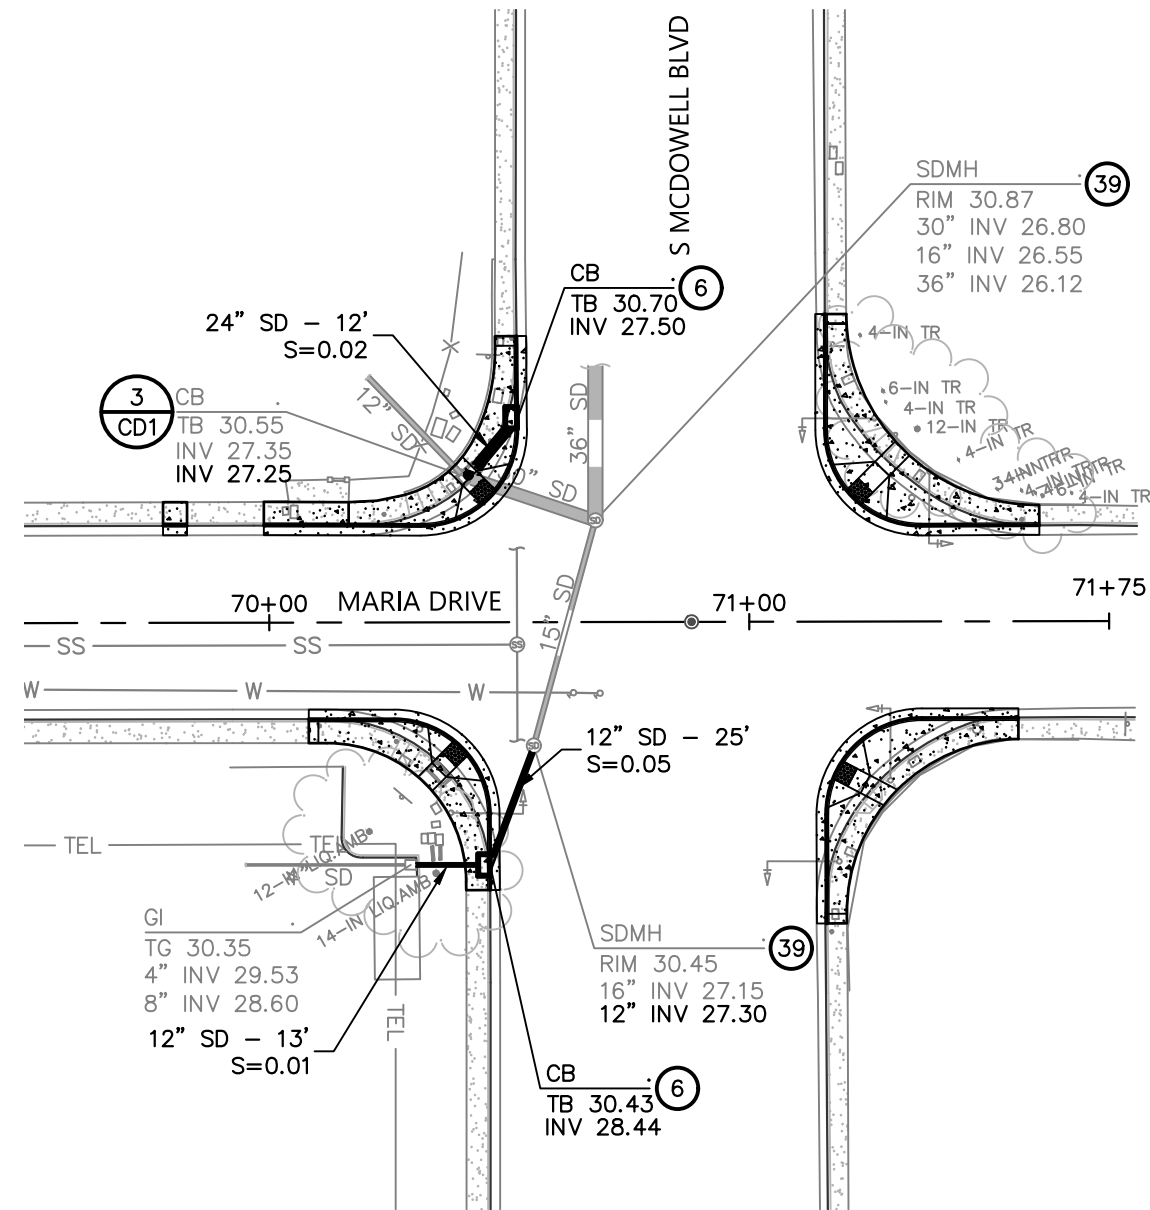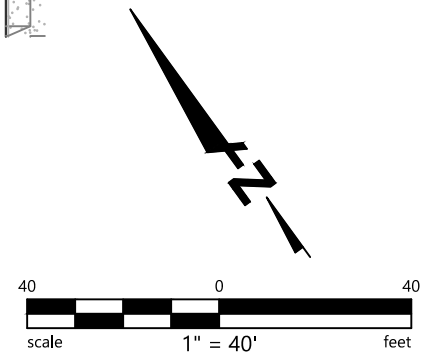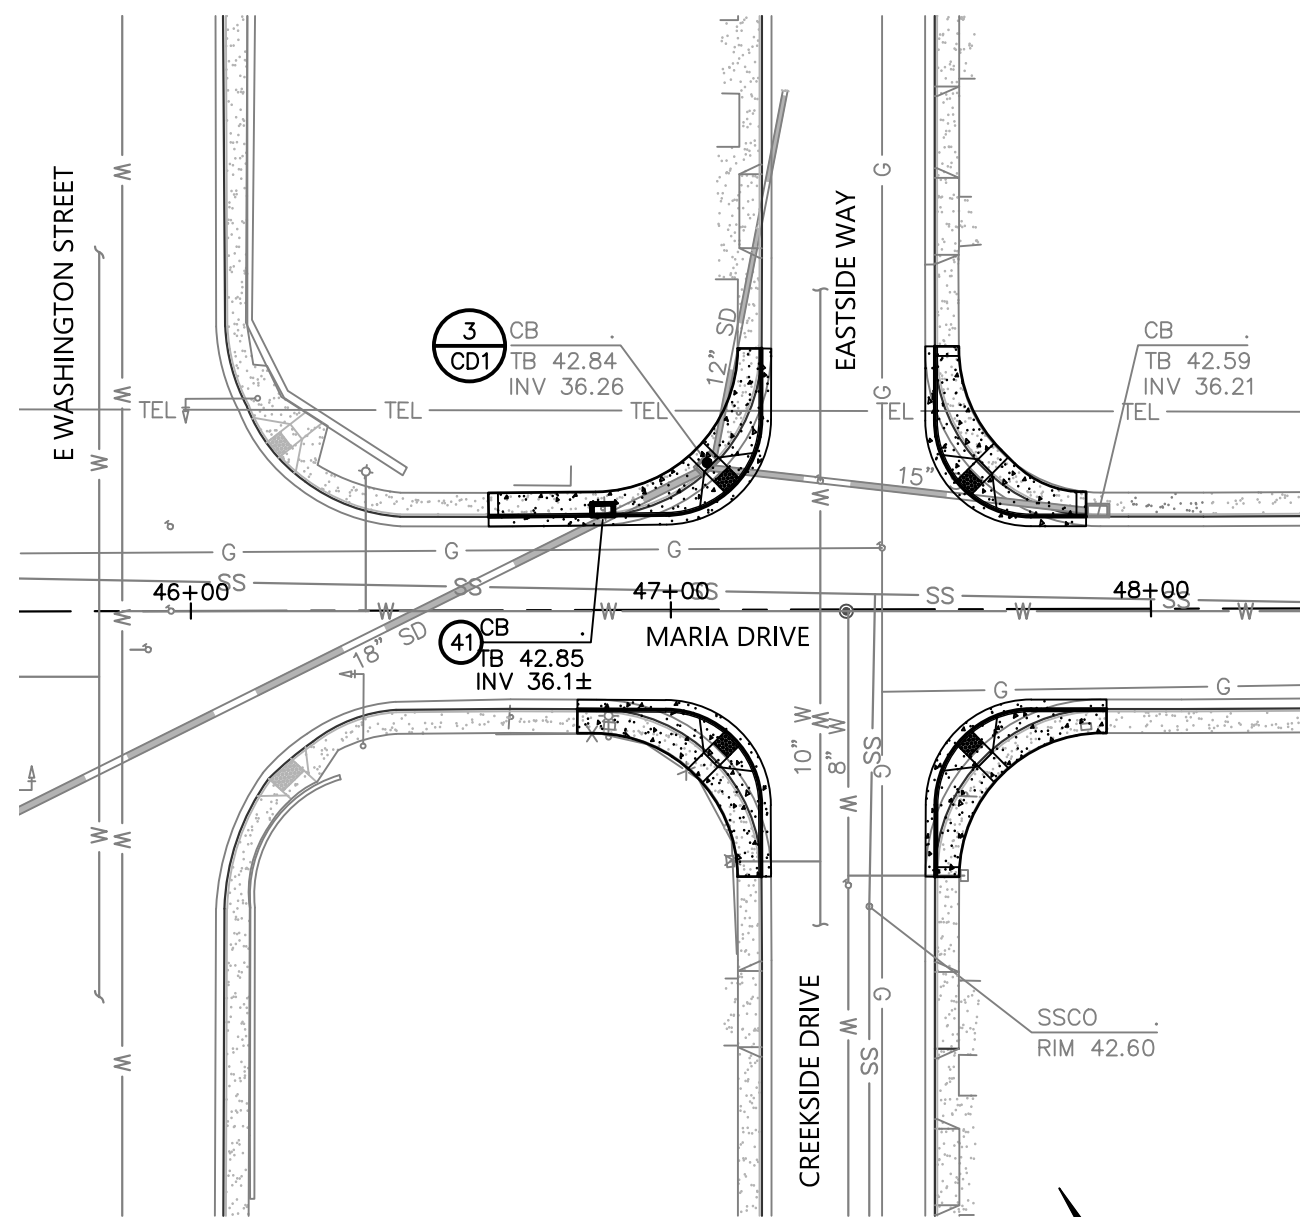

**KEYNOTES:**

- ⑥ TYPE "B" STORM DRAIN CATCH BASIN IN ACCORDANCE WITH CITY OF PETALUMA STD. 408.1.
- ③⑨ CONNECT TO EXISTING UTILITY IN A MANNER WHICH PROVIDES A PERMANENT WATER TIGHT SEAL.

- ④① TYPE "B" STORM DRAIN CATCH BASIN IN ACCORDANCE WITH CITY OF PETALUMA STD. 408.1. CAST IN PLACE OVER EXISTING STORM DRAIN PIPE.

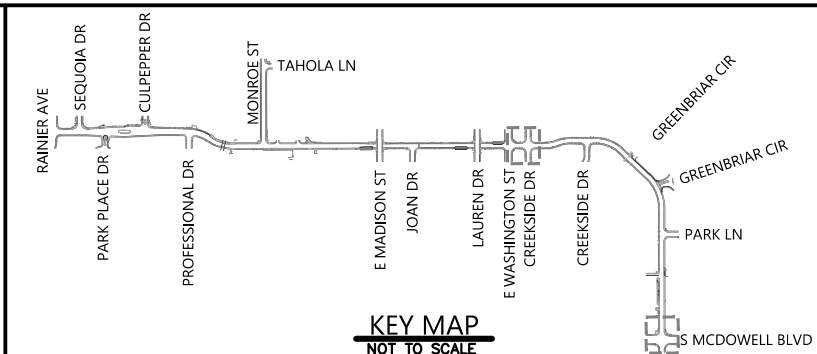

**KEY MAP**  
NOT TO SCALE

MARIA DRIVE - STREET REHABILITATION  
RAINIER AVE TO S MCDOWELL BLVD  
UTILITY PLAN STA 45+50 TO STA 48+25  
AND STA 69+50 TO 71+75


SHEET

**UT-8**

36 OF 83



PROJECT NO.  
C16102248

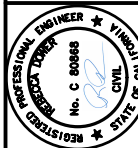

**CITY OF PETALUMA**  
PUBLIC WORKS & UTILITIES  
202 N. McDowell Blvd., PETALUMA, CALIFORNIA, 94954  
PH. 707-778-4546 FAX. 707-778-4508

