


A PORTION OF SECTION 24, TOWNSHIP 21 NORTH, RANGE 02 EAST, W.M.

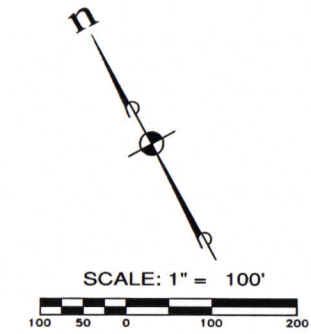

LEGEND

- WATER
- SANITARY
- FORCE MAIN
- STORM
- DRY UTILITIES:
POWER, GAS, TELE/COMM, CATV, STREET LIGHT



REVISIONS		
NO.	DESCRIPTION/DATE	BY

ESM CONSULTING ENGINEERS, LLC

39915 1st Way South #200
Federal Way, WA 98003

www.esmcivil.com

Civil Engineering
Public Works

EDRILL
ELLENBURG
(206) 836-4113
(206) 412-6114
(206) 842-2608

Land Planning
Landscape Architecture

POINT RUSTON, LLC

POINT RUSTON

PRELIMINARY UTILITY PLAN

CITY OF TACOMA


WASHINGTON

JOB NO.:	1278-002-006
DWG. NAME:	EN-44
DESIGNED BY:	ELP
DRAWN BY:	EAP
CHECKED BY:	
DATE:	2008-06-04
DATE OF PRINT:	


A PORTION OF SECTION 24, TOWNSHIP 21 NORTH, RANGE 02 EAST, W.M.

SEE SHEET 3 OF 5

SCALE: 1" = 50'

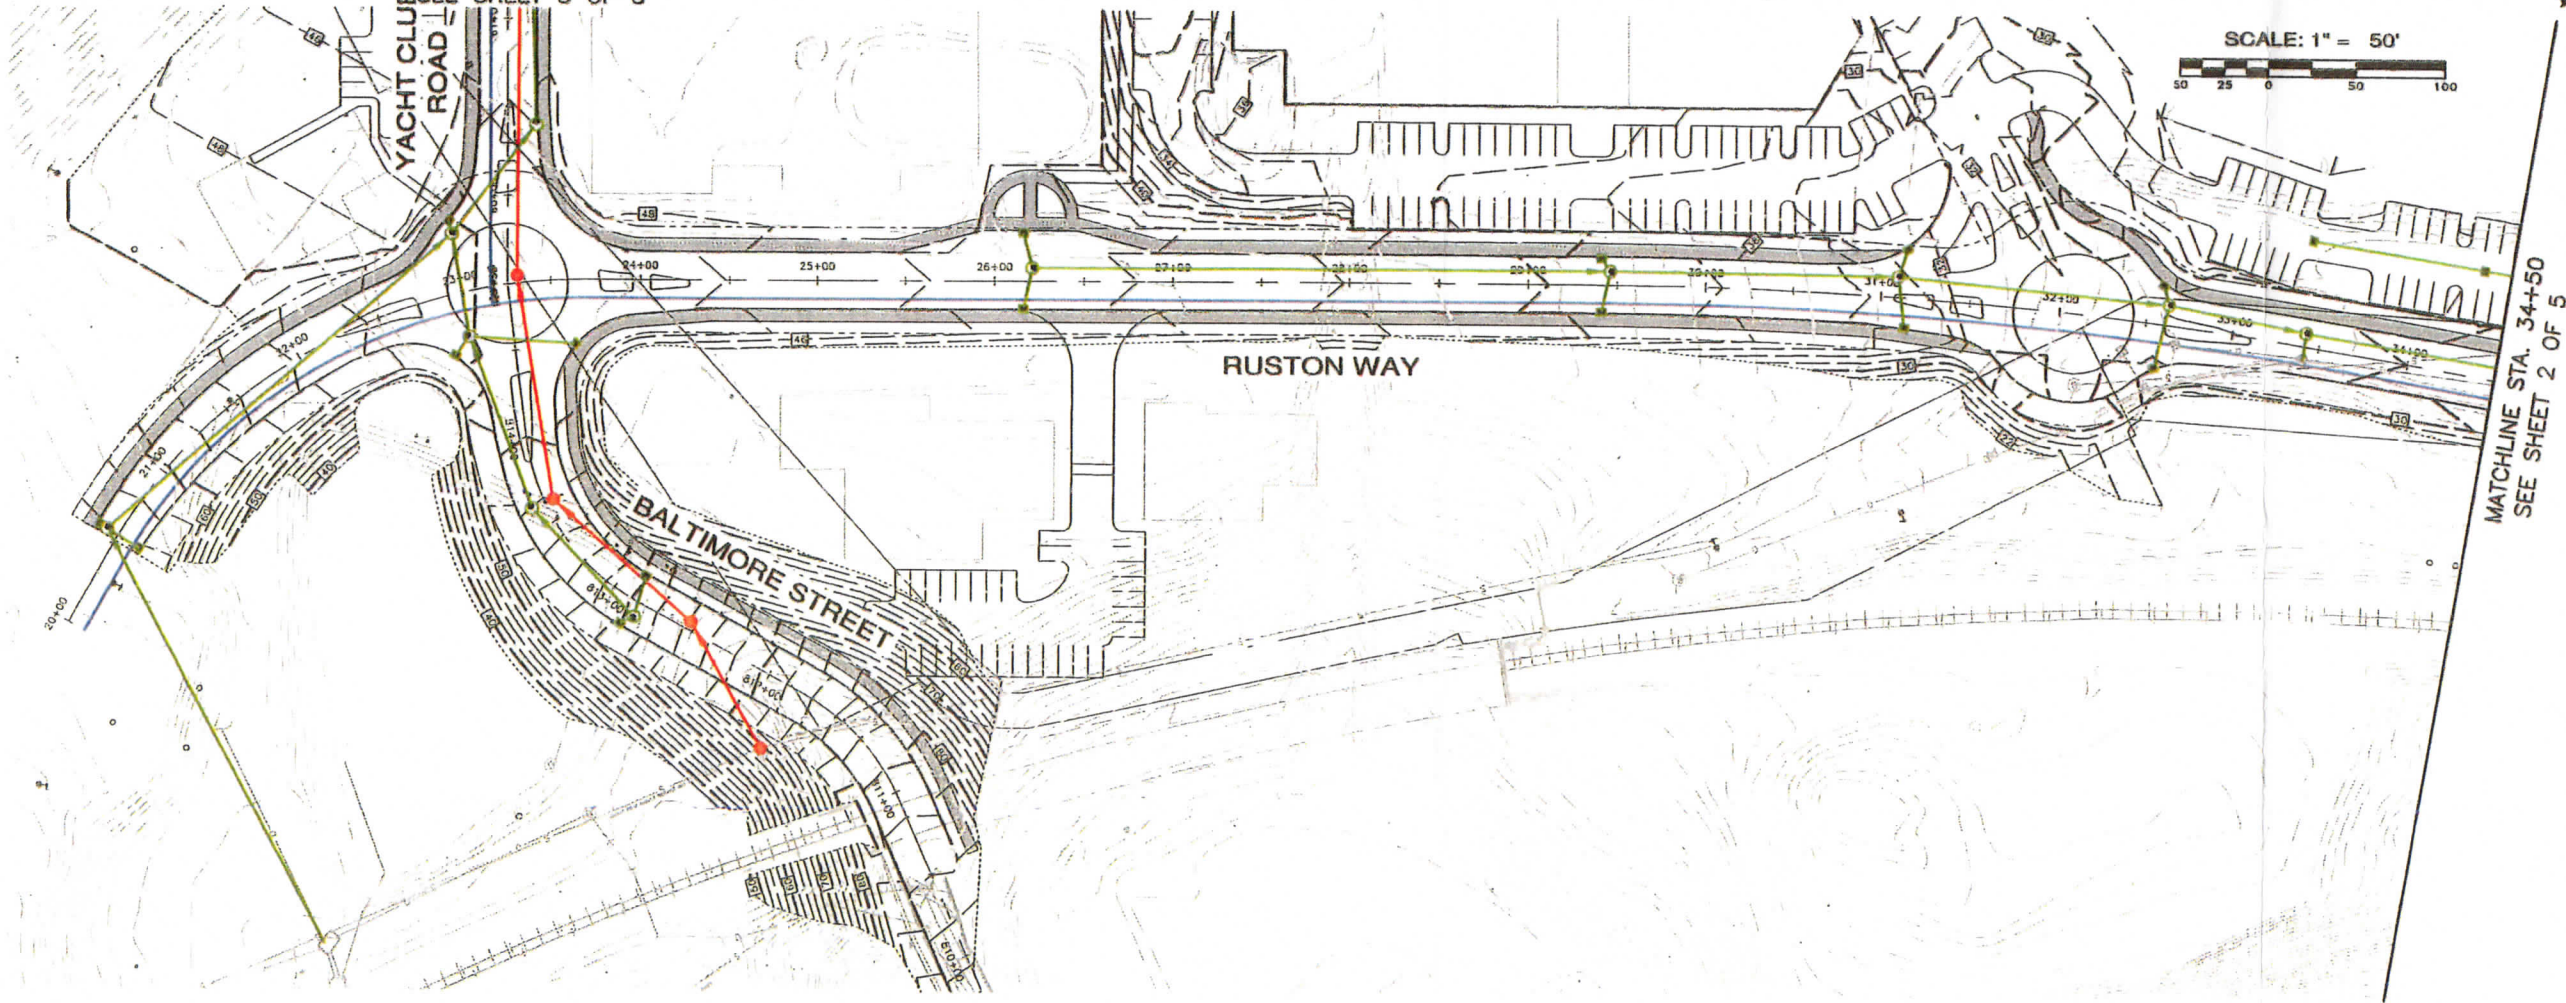

MATCHLINE STA. 34+50
SEE SHEET 2 OF 5

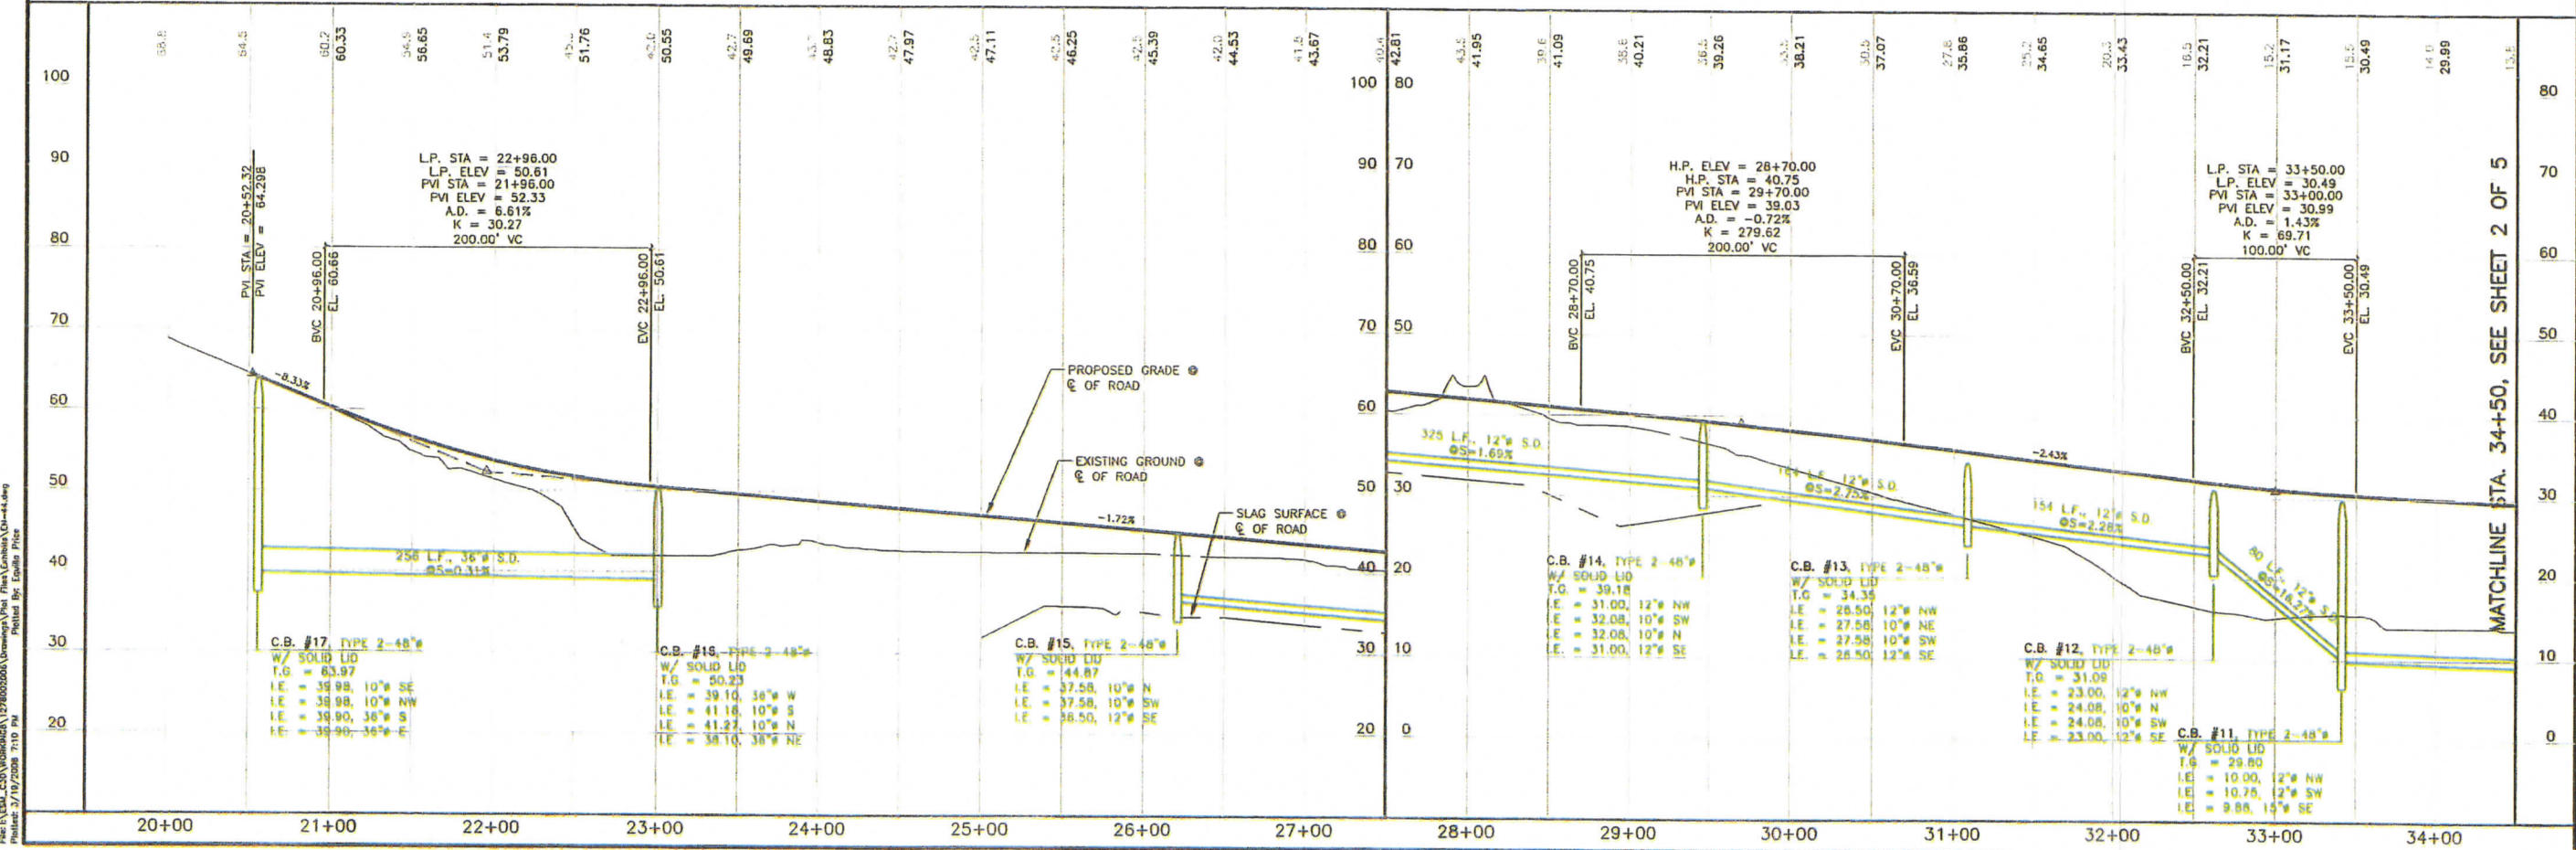

REVISIONS		
NO.	DESCRIPTION/DATE	BY

ESM CONSULTING ENGINEERS, LLC
 33915 1st Way South #200
 Federal Way, WA 98003
 (206) 835-9113
 (206) 835-9114
 (206) 835-9115
 www.esmcivil.com


Land Surveying
 Project Management
 Land Planning
 Landscape Architecture

POINT RUSTON, LLC
POINT RUSTON
 PRELIMINARY UTILITY PLAN AND PROFILE
 CITY OF TACOMA
 WASHINGTON


JOB NO.: 1278-002-008
 DWG. NAME: EN-44
 DESIGNED BY: ELP
 DRAWN BY: EAP
 CHECKED BY:
 DATE: 2008-03-17
 DATE OF PRINT:

Attachment 9


A PORTION OF SECTION 24, TOWNSHIP 21 NORTH, RANGE 02 EAST, W.M.

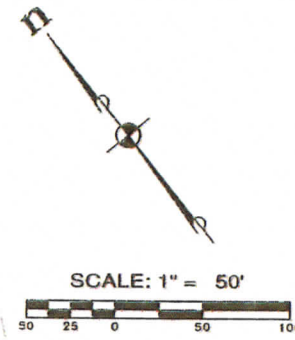

MATCHLINE STA. 34+50, SEE SHEET 1 OF 5

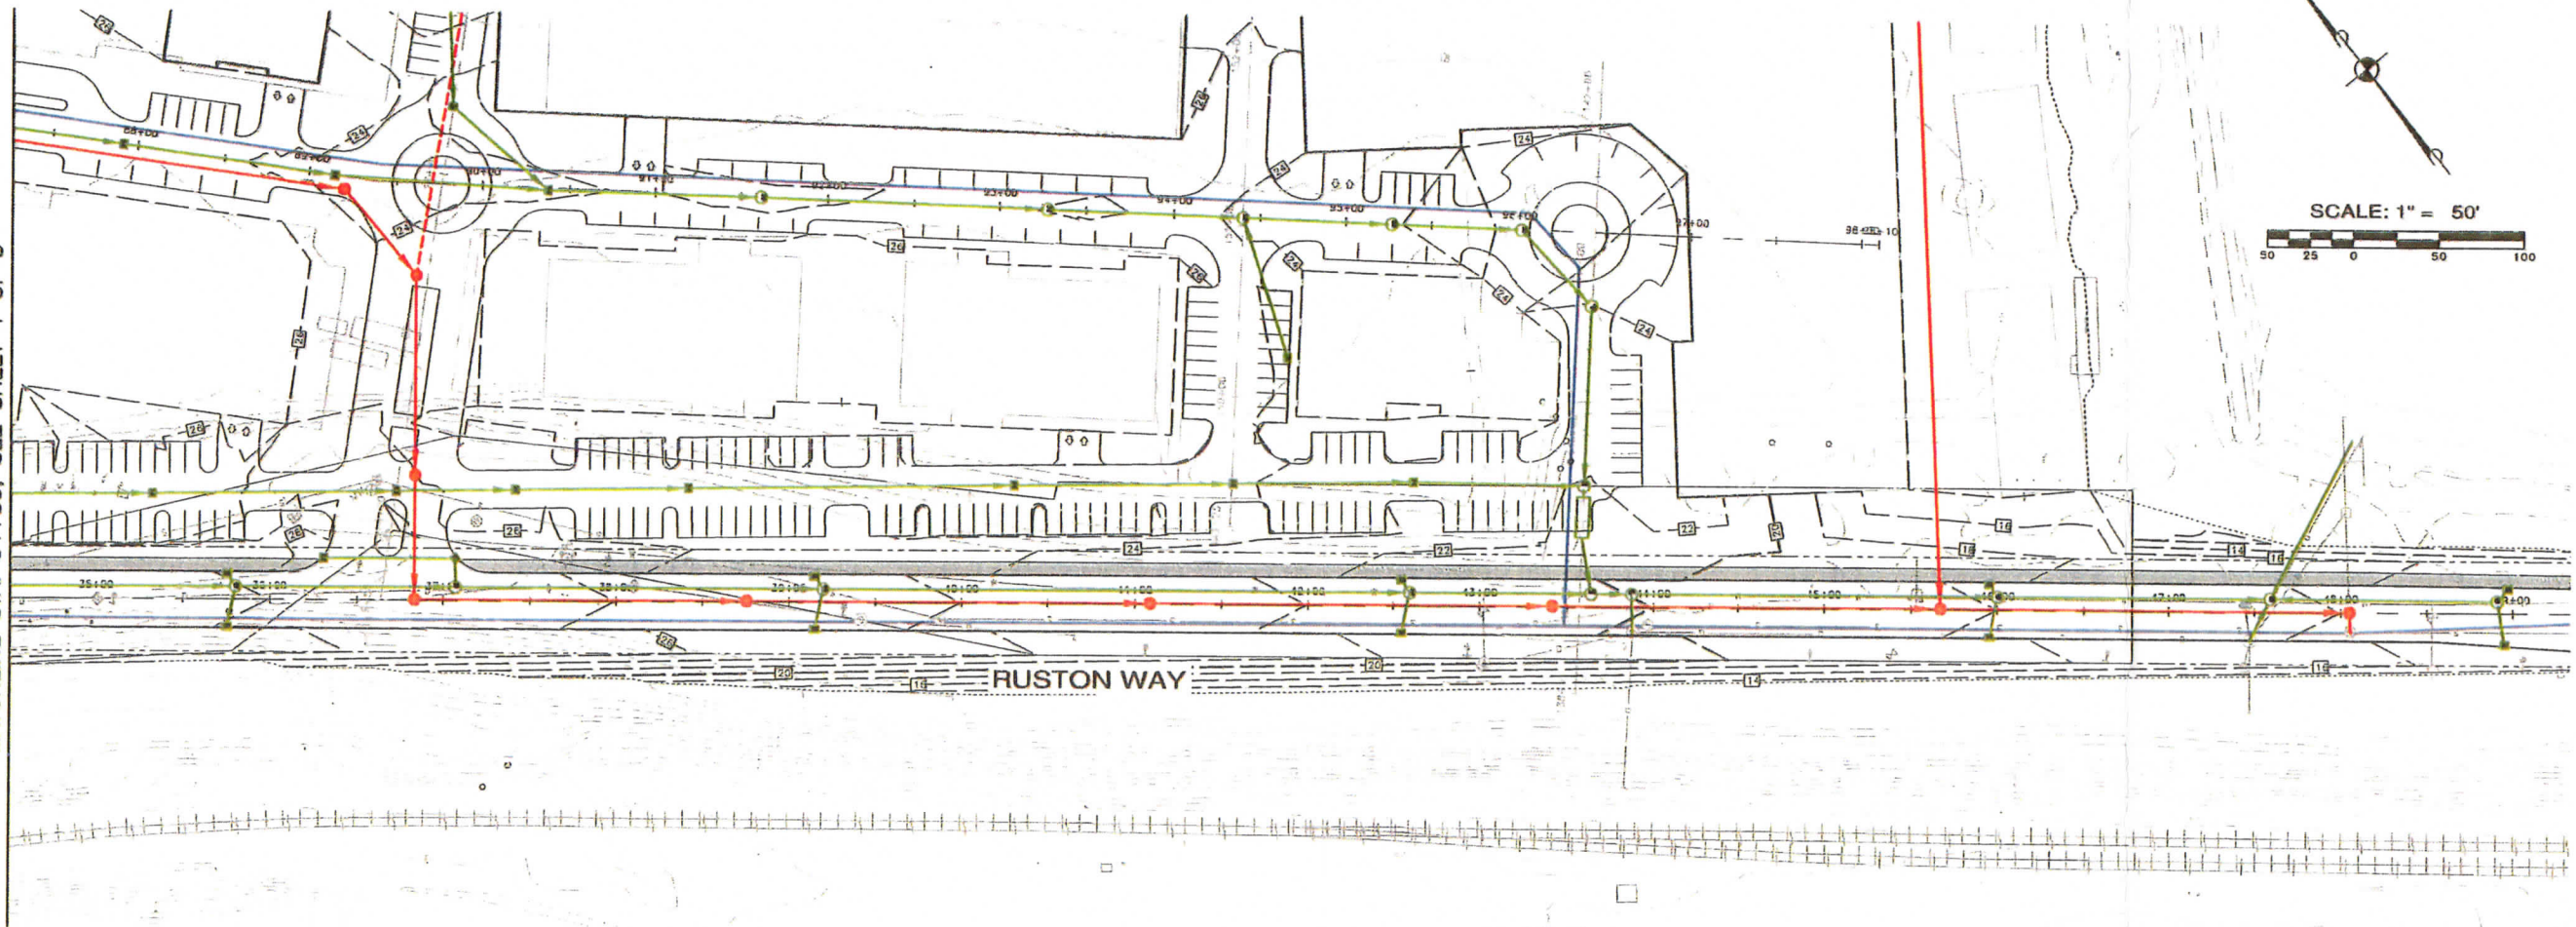

MATCHLINE STA. 34+50, SEE SHEET 1 OF 5

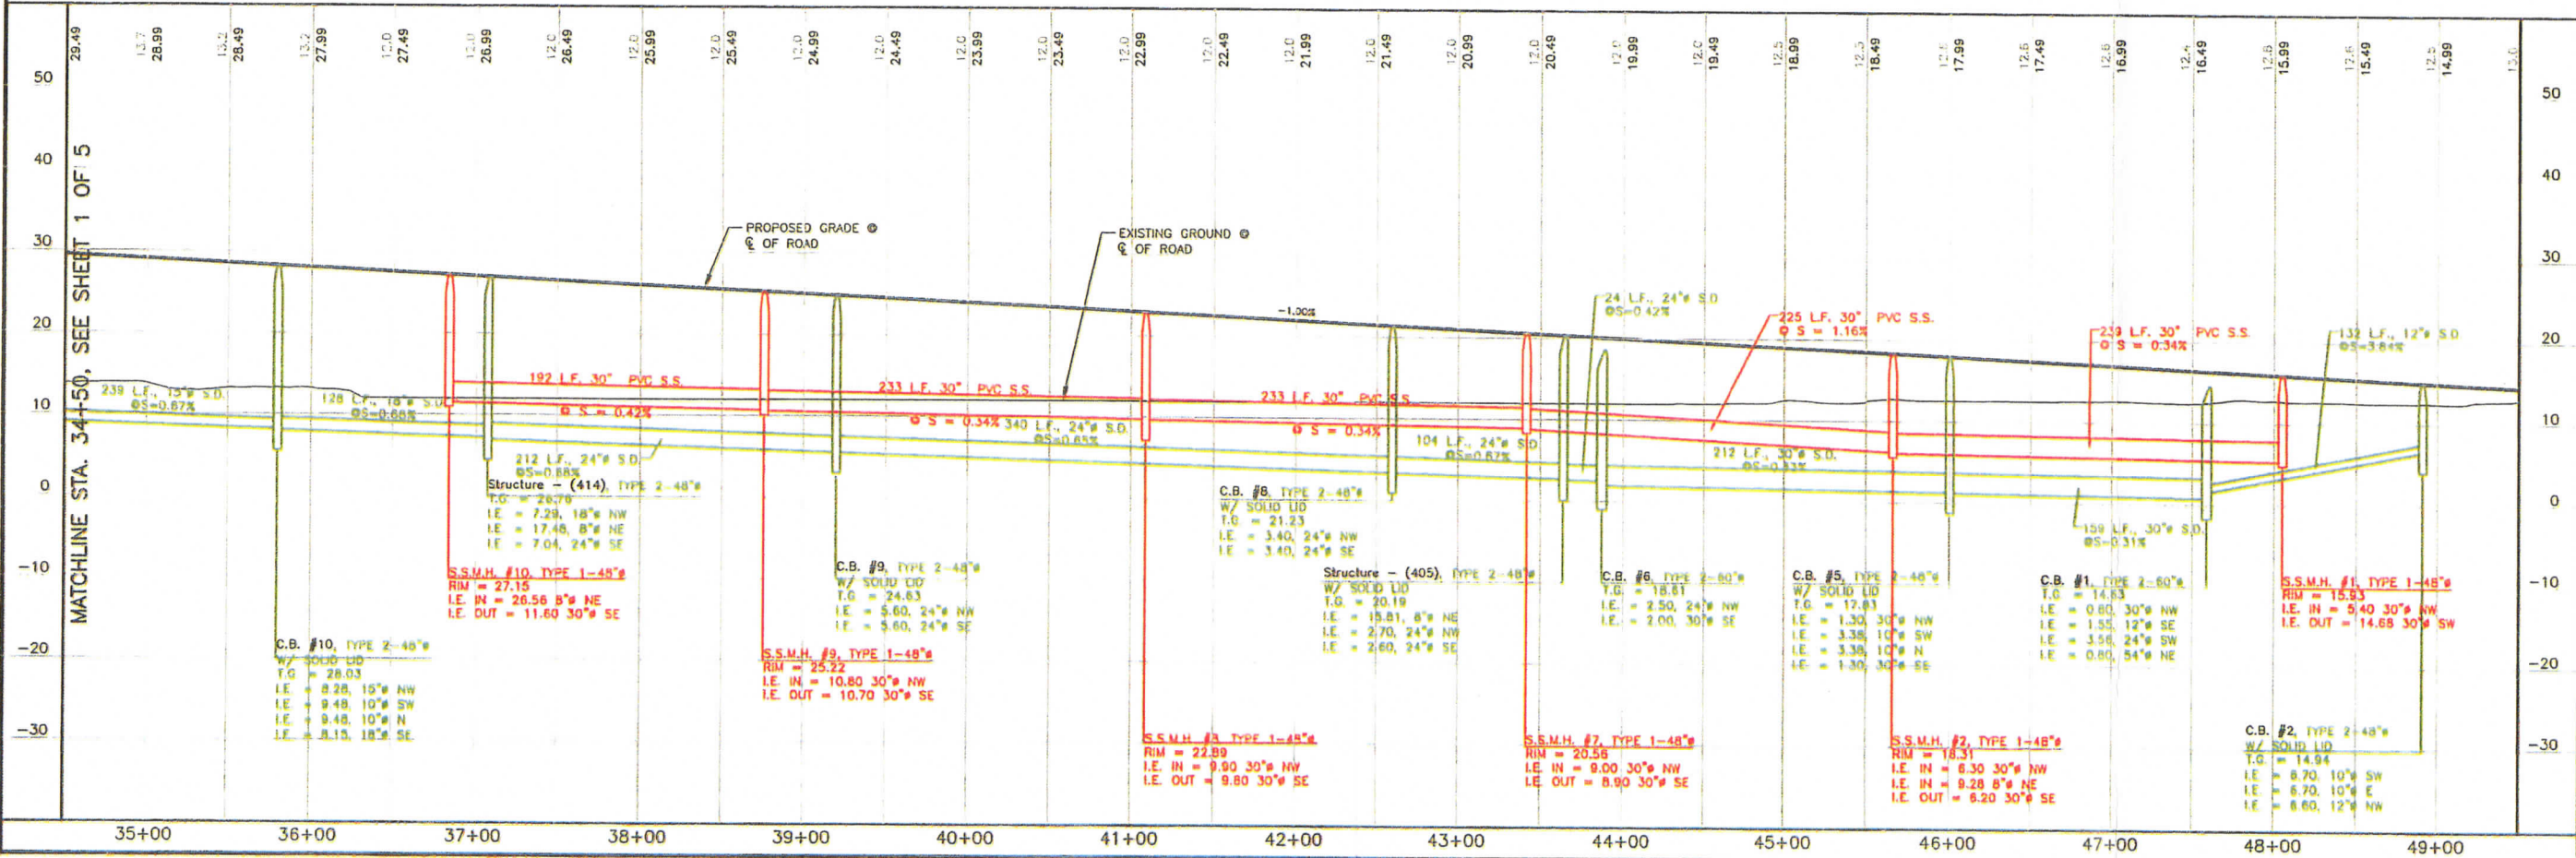



REVISIONS		
NO.	DESCRIPTION/DATE	BY

ESM CONSULTING ENGINEERS, LLC
 33915 1st Way South #200
 Federal Way, WA 98003
 (206) 838-8113
 (206) 838-8114
 (206) 838-8115
 (206) 838-8200

POINT RUSTON, LLC
 POINT RUSTON
 PRELIMINARY UTILITY PLAN AND PROFILE
 CITY OF TACOMA
 WASHINGTON

JOB NO.: 1278-002-008
 DWG. NAME: EN-44
 DESIGNED BY: ELP
 DRAWN BY: ELP
 CHECKED BY:
 DATE: 2008-03-17
 DATE OF PRINT:

A PORTION OF SECTION 24, TOWNSHIP 21 NORTH, RANGE 02 EAST, W.M.

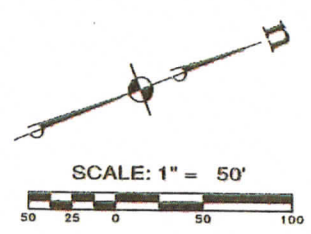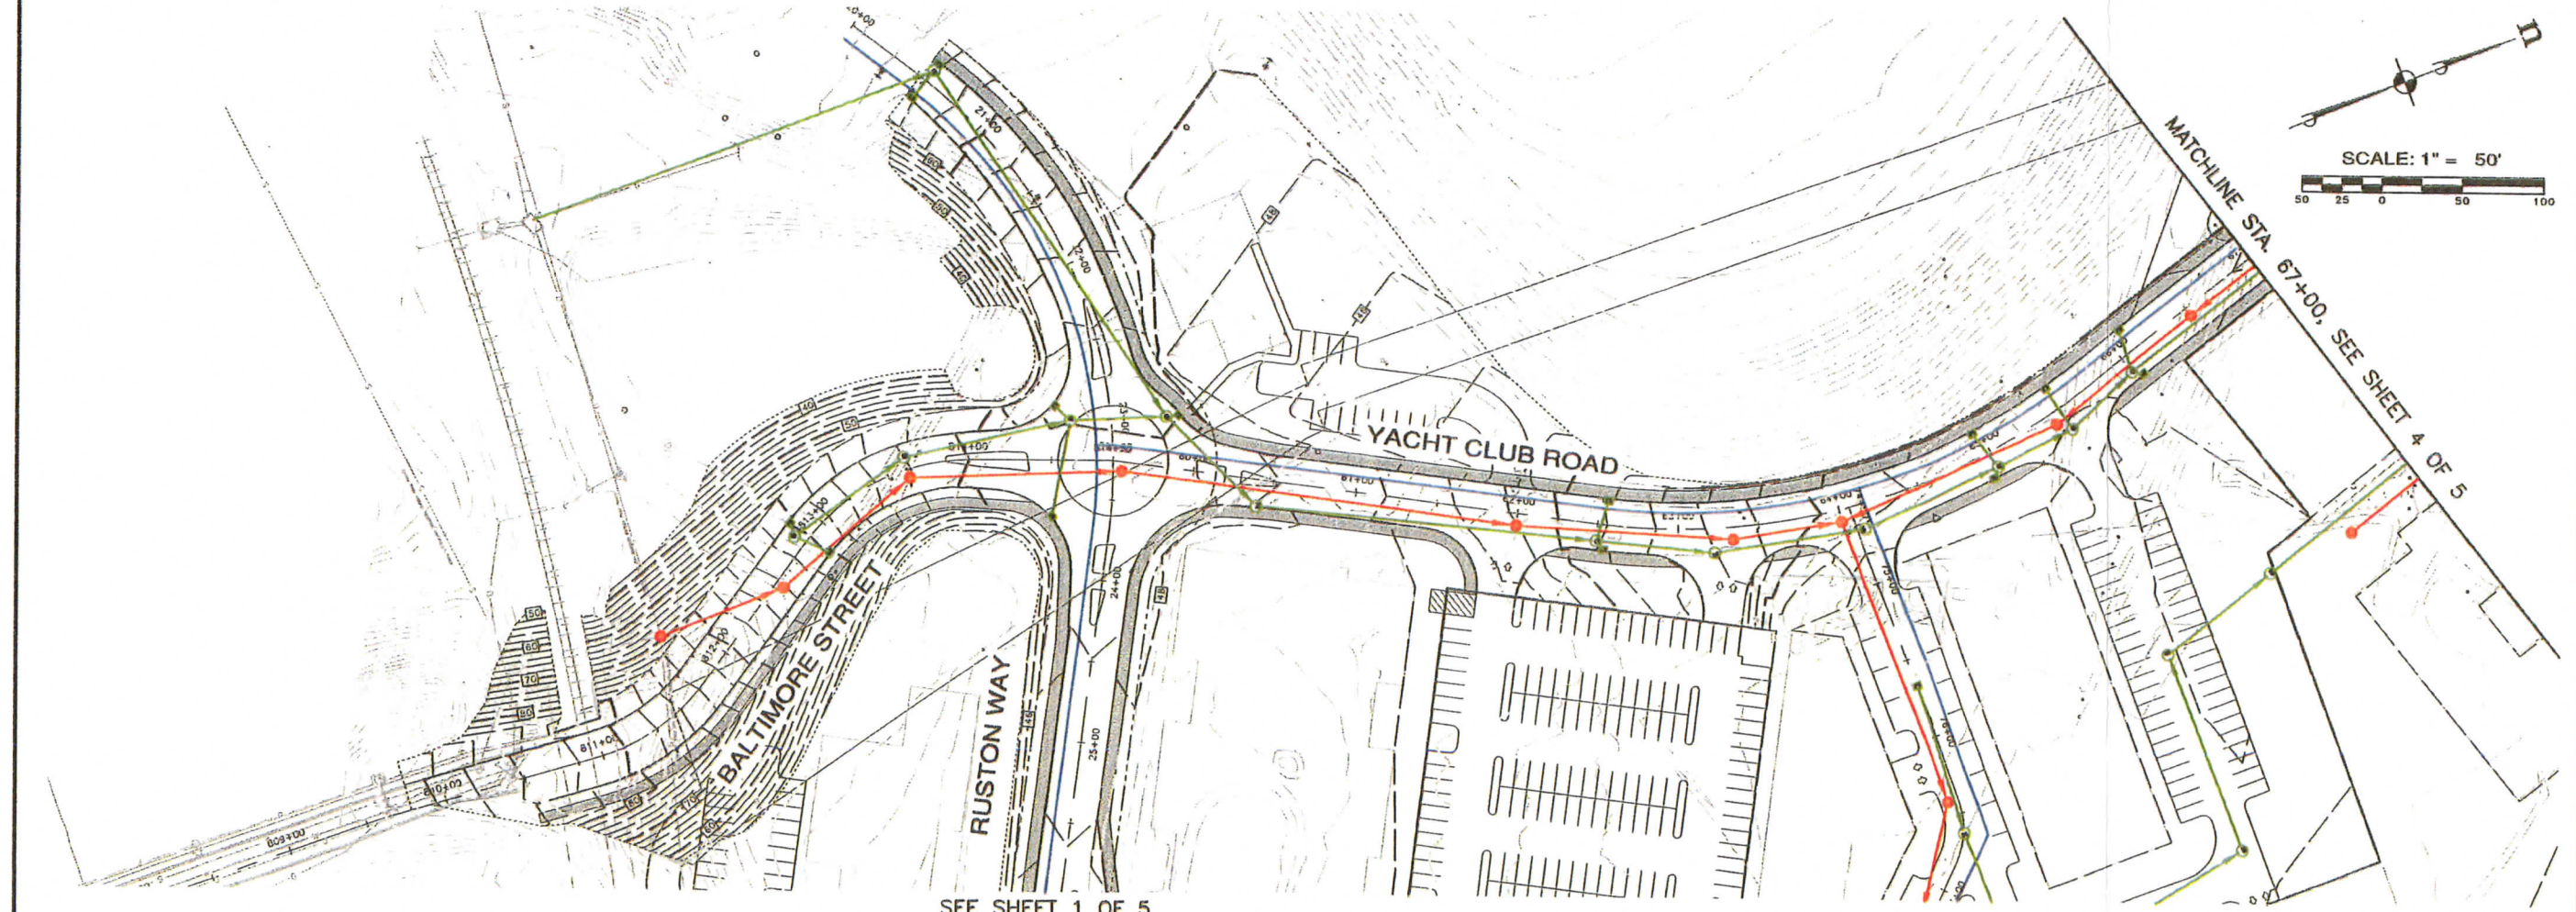


BALTIMORE STREET

SEE SHEET 1 OF 5

YACHT CLUB ROAD

MATCHLINE STA. 67+00, SEE SHEET 4 OF 5

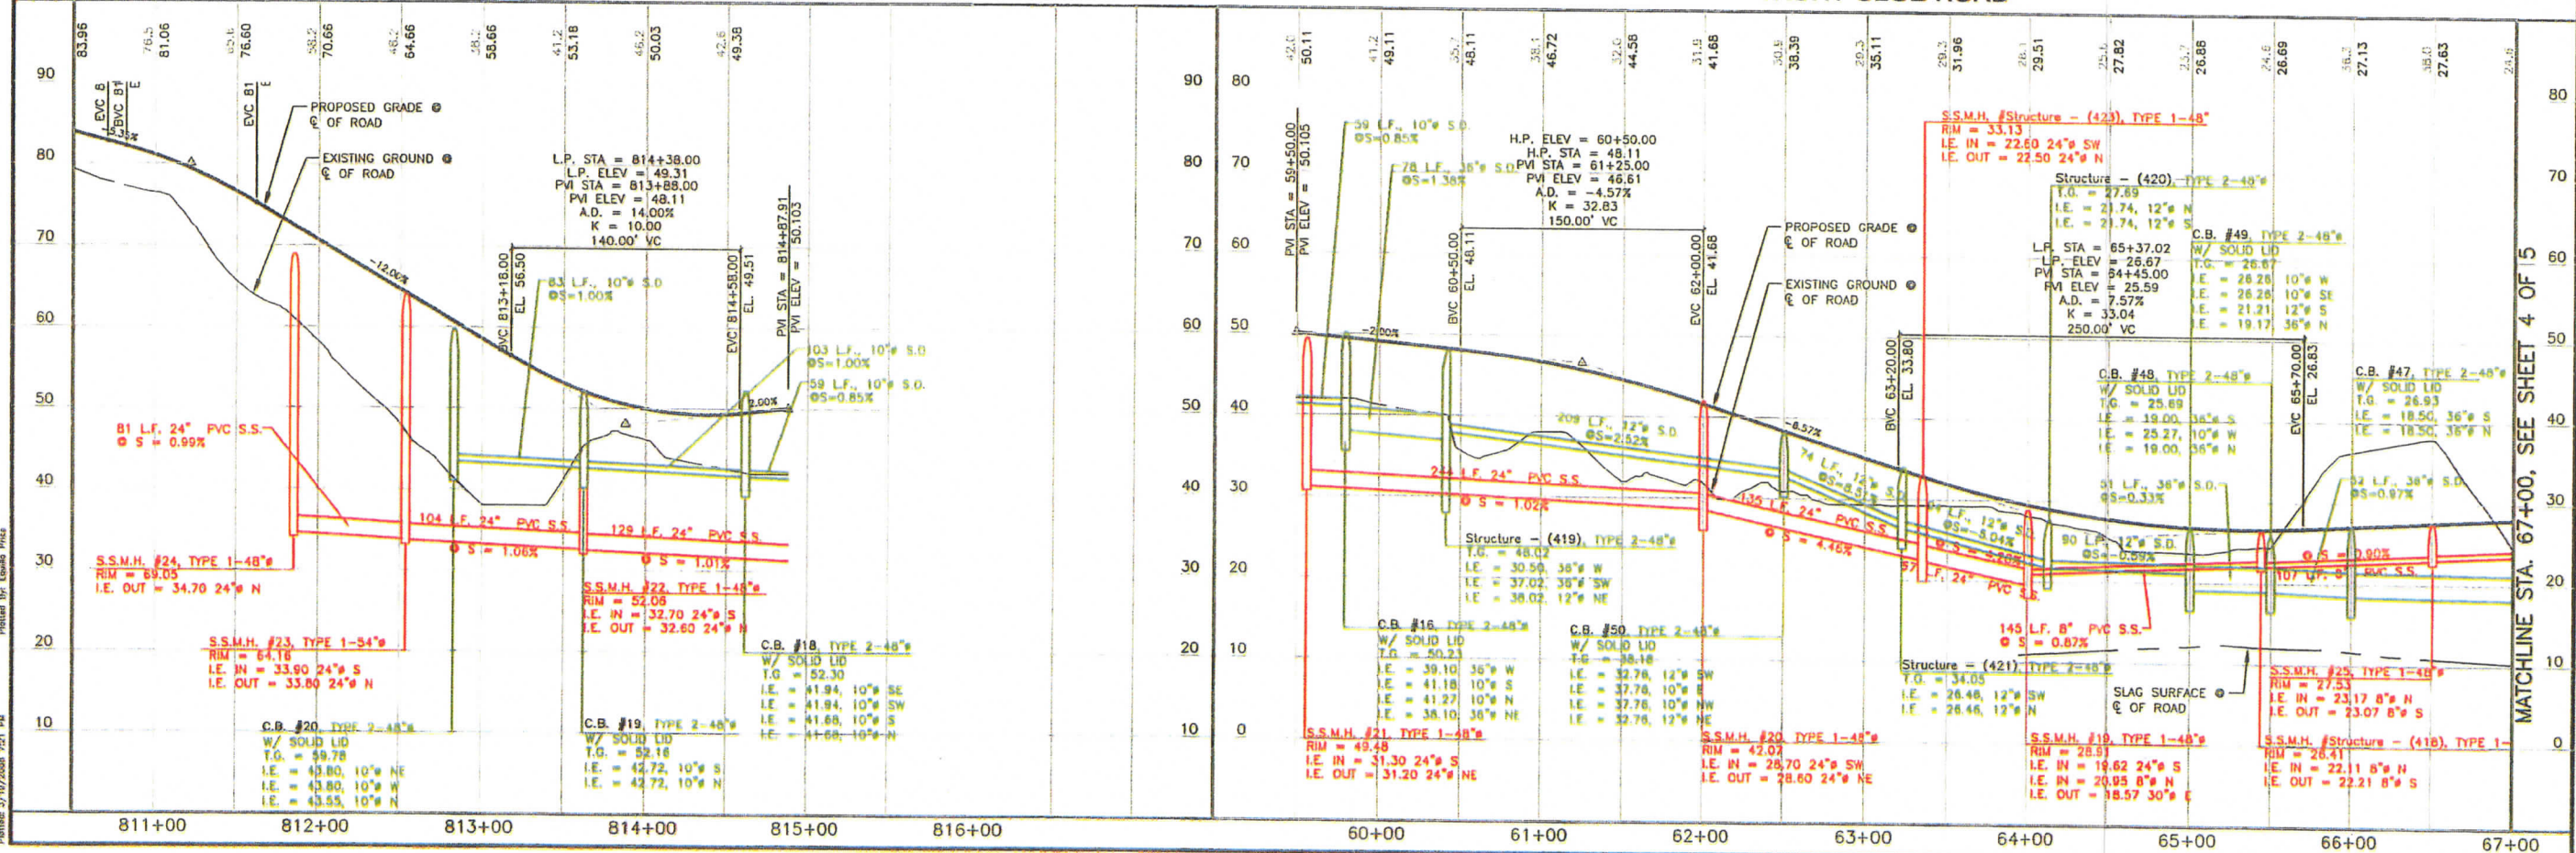

REVISIONS		
NO.	DESCRIPTION/DATE	BY

CONSULTING ENGINEERS, LLC
33915 1st Way South #200
Federal Way, WA 98003
www.esmcivil.com
Civil Engineering
Public Works

FEDERAL WAY
253 035-0113
035-0114
035-0115
035-0116
035-1000

POINT RUSTON, LLC

WASHINGTON

POINT RUSTON

PRELIMINARY UTILITY PLAN AND PROFILE

CITY OF TACOMA

DATE: 2008-03-17

DESIGNED BY: ELP

DRAWN BY: EAP

CHECKED BY:




JOB NO.: 1278-002-008

DWG. NAME: EM-44

DATE OF PRINT:



3 OF 5 SHEETS

A PORTION OF SECTION 24, TOWNSHIP 21 NORTH, RANGE 02 EAST, W.M.

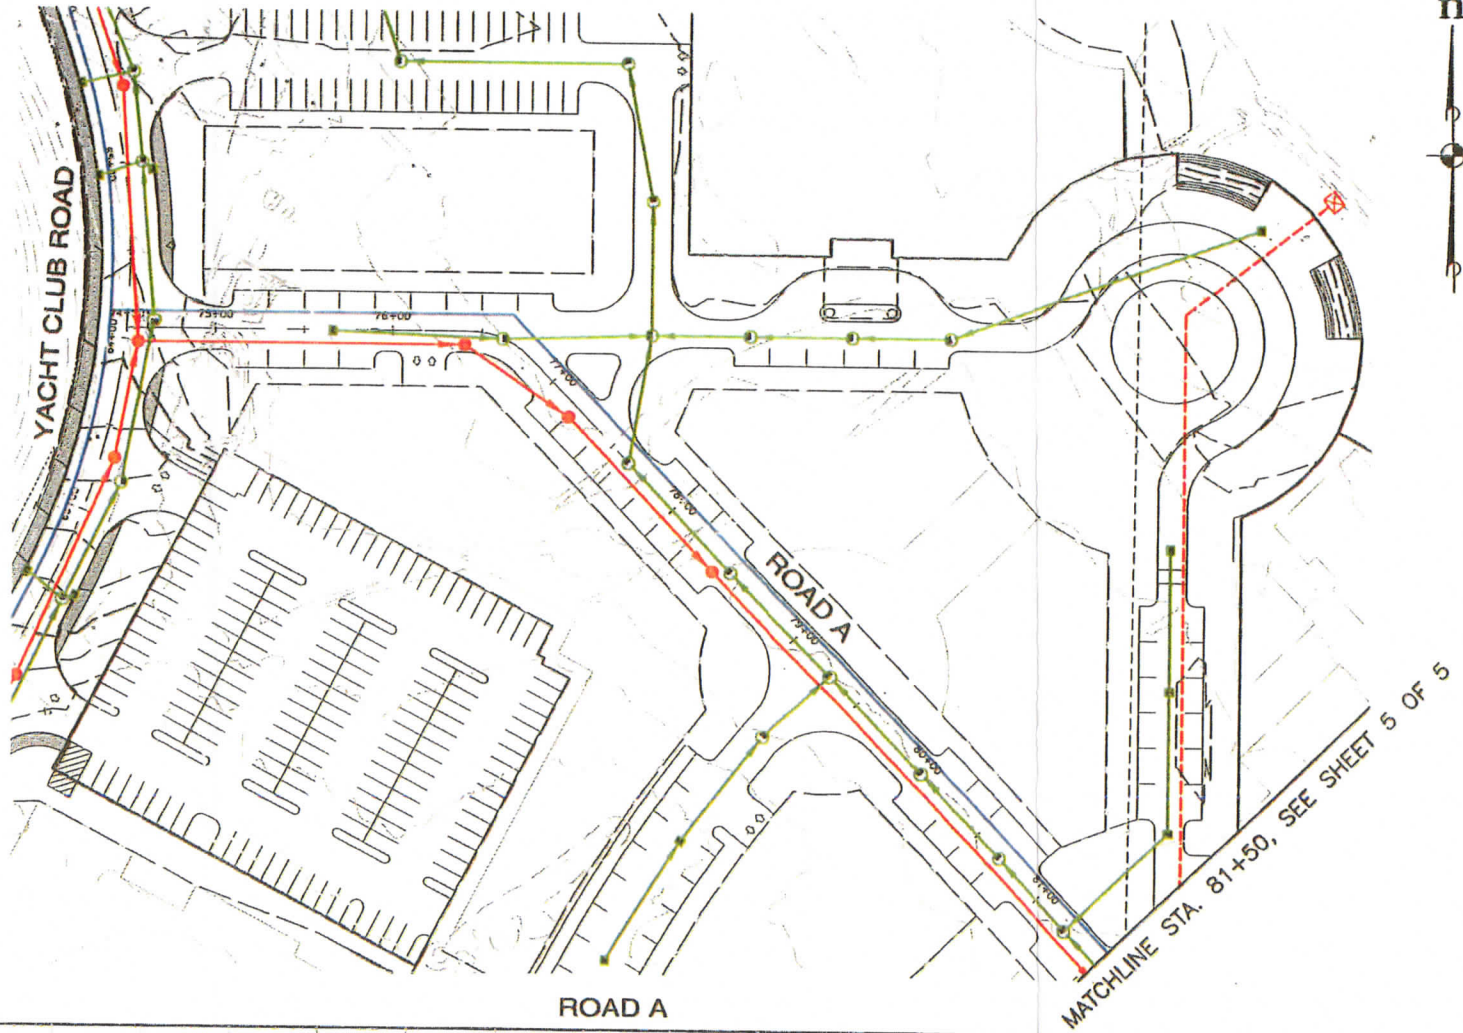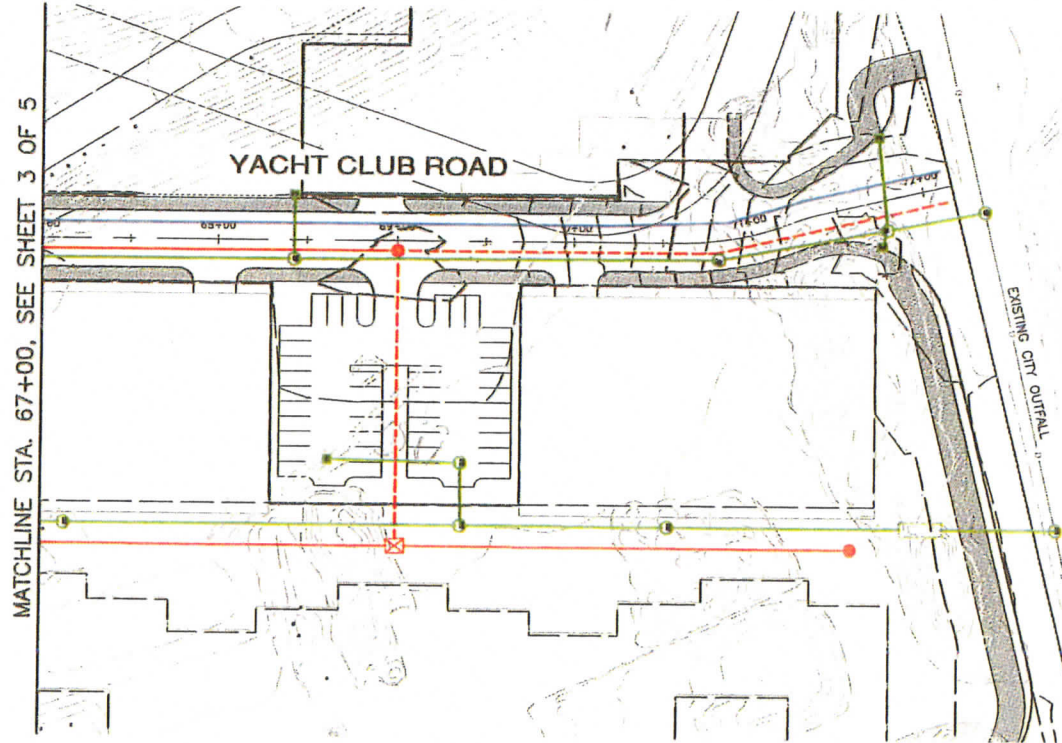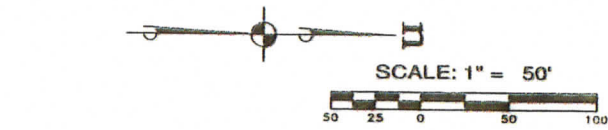

YACHT CLUB ROAD

ROAD A

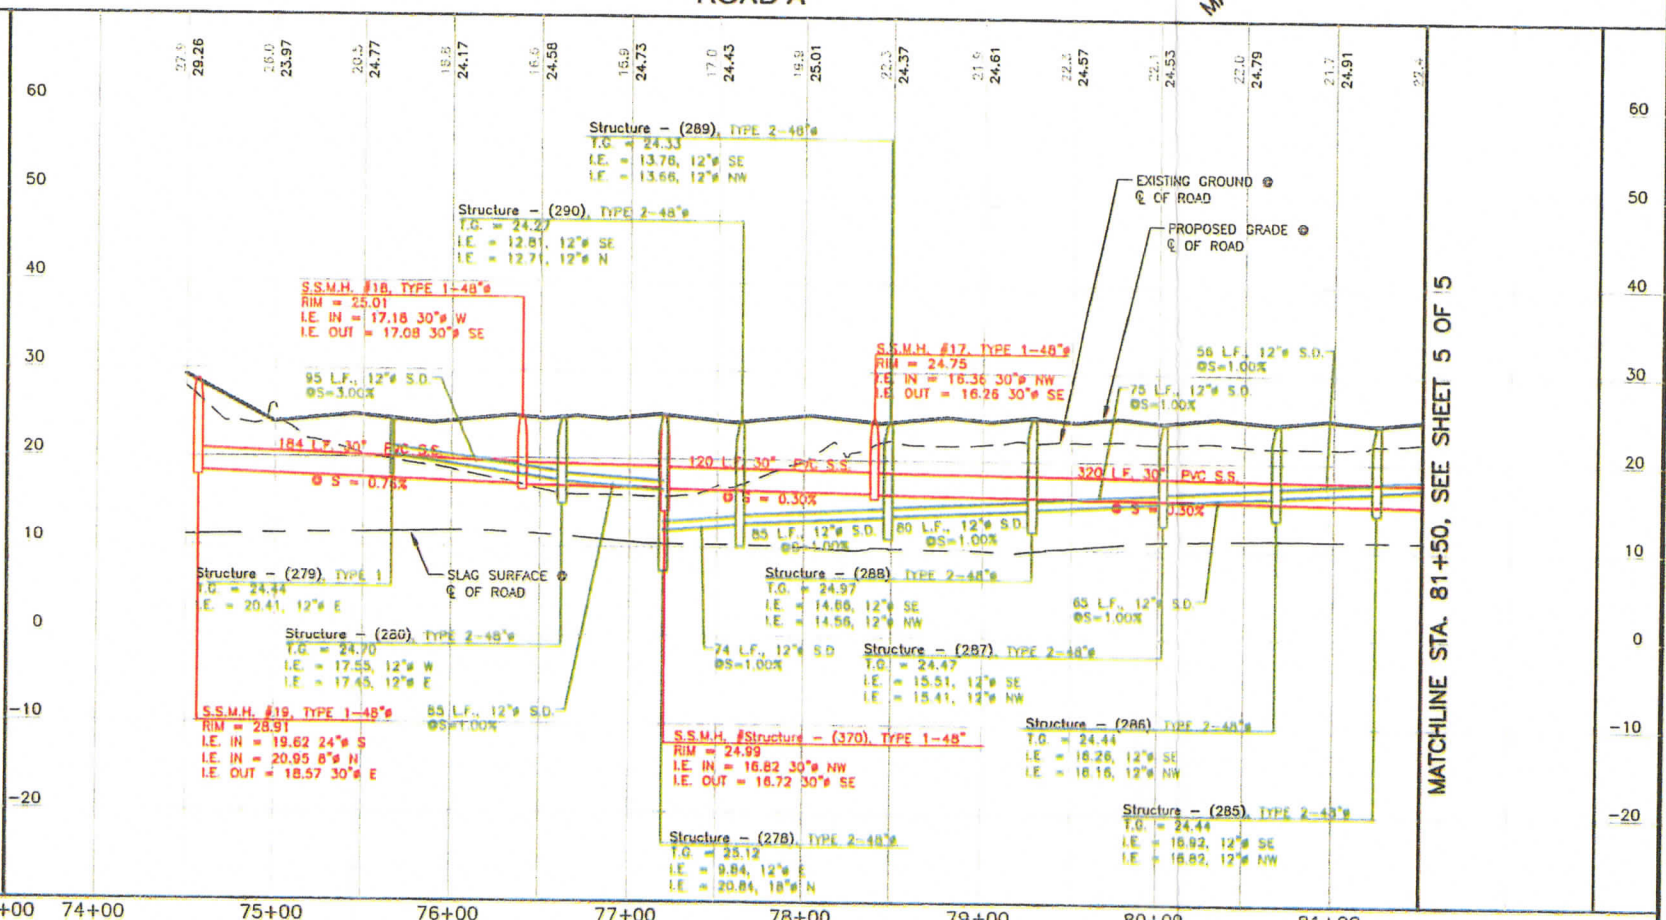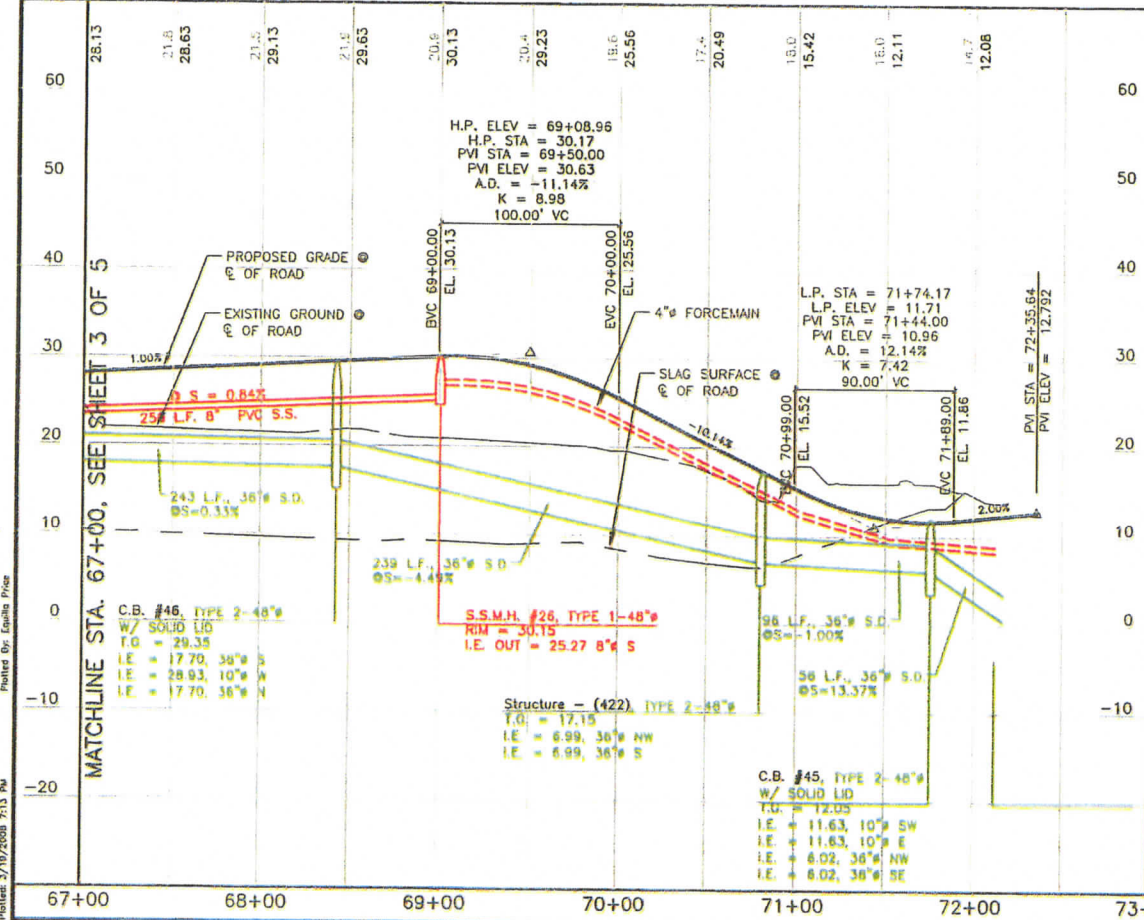

REVISIONS			
NO.	DESCRIPTION/DATE	BY	DATE

POINT RUSTON, LLC

POINT RUSTON

PRELIMINARY UTILITY PLAN AND PROFILE

CITY OF TACOMA

WASHINGTON

JOB NO.: 1278-002-008

DRG. NAME: EN-44

DESIGNED BY: ELP

DRAWN BY: EAP

CHECKED BY:

DATE: 2008-03-12

DATE OF PRINT:

ESM CONSULTING ENGINEERS, LLC

33915 1st Way South #200
Federal Way, WA 98003

 

WWW.ESMCIVIL.COM

Civil Engineering
Public Works


Land Surveying
Project Management

Land Planning
Landscape Architecture

MATCHLINE STA. 81+50, SEE SHEET 4 OF 5

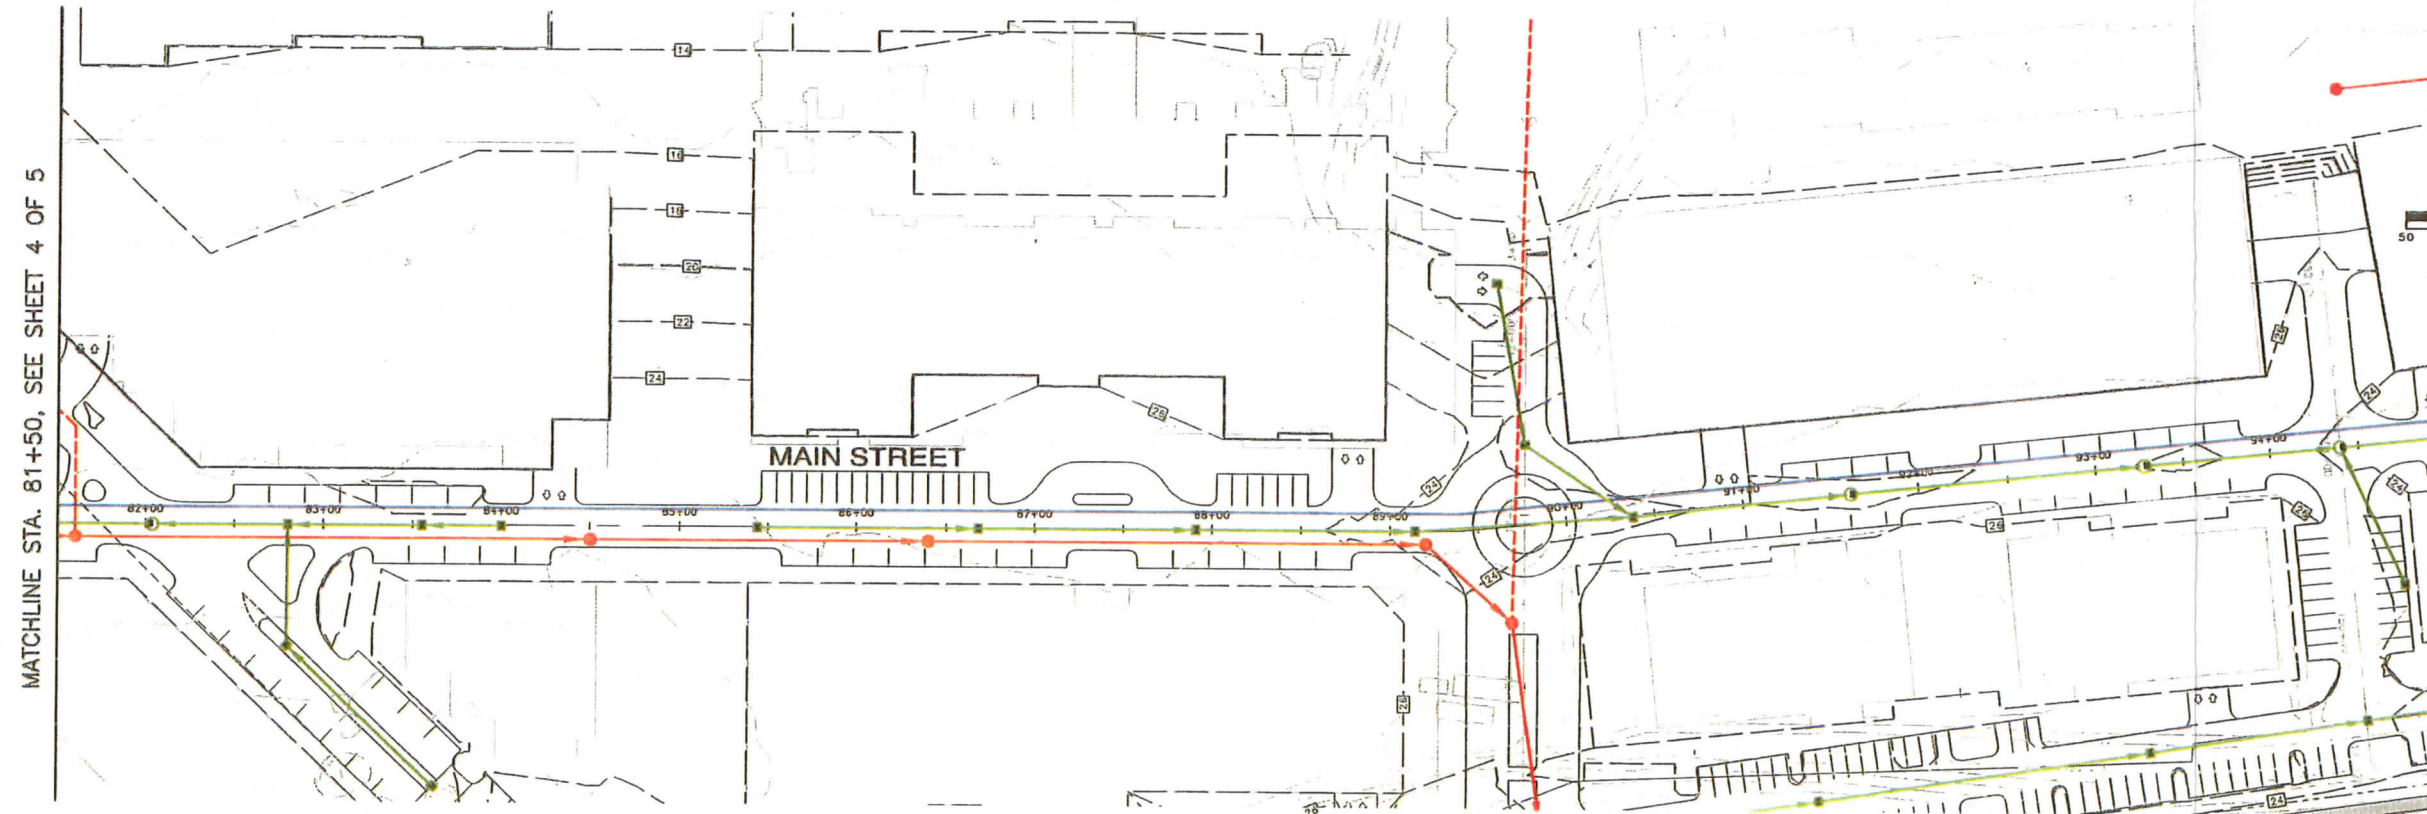

MATCHLINE STA. 81+50, SEE SHEET 4 OF 5

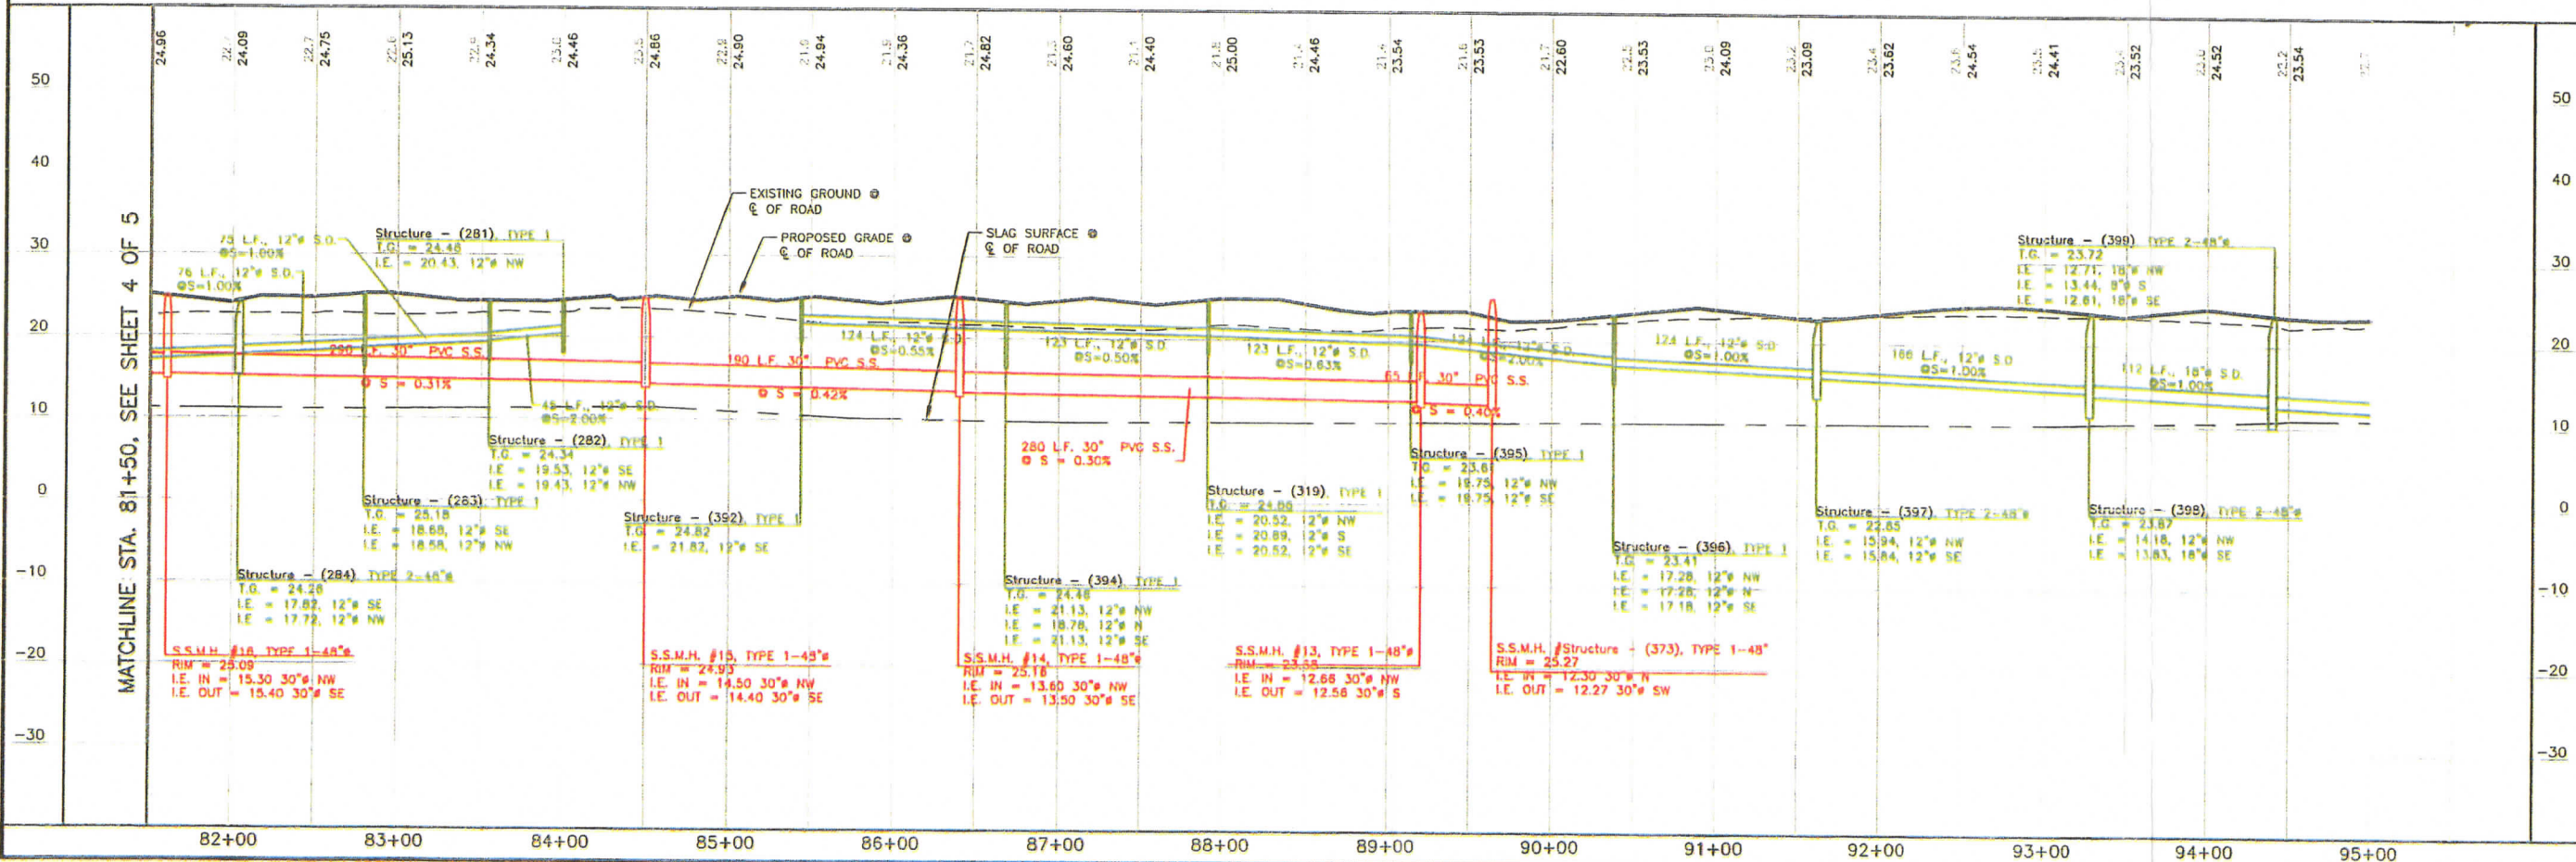

REVISIONS			
NO.	DESCRIPTION/DATE	BY	CHK

ESM CONSULTING ENGINEERS, LLC
 33015 1st Way South #200
 Federal Way, WA 98003
 WWW.ESMCIVIL.COM

POINT RUSTON, LLC
 33015 1st Way South #200
 Federal Way, WA 98003
 WWW.ESMCIVIL.COM

WASHINGTON
 Civil Engineering
 Land Surveying
 Project Management
 Landscape Architecture

POINT RUSTON, LLC
POINT RUSTON
 PRELIMINARY UTILITY PLAN AND PROFILE

JOB NO.:	1278-002-008
DWG. NAME:	EN-44
DESIGNED BY:	ELP
DRAWN BY:	EAP
CHECKED BY:	
DATE:	2008-03-17
DATE OF PRINT:	