


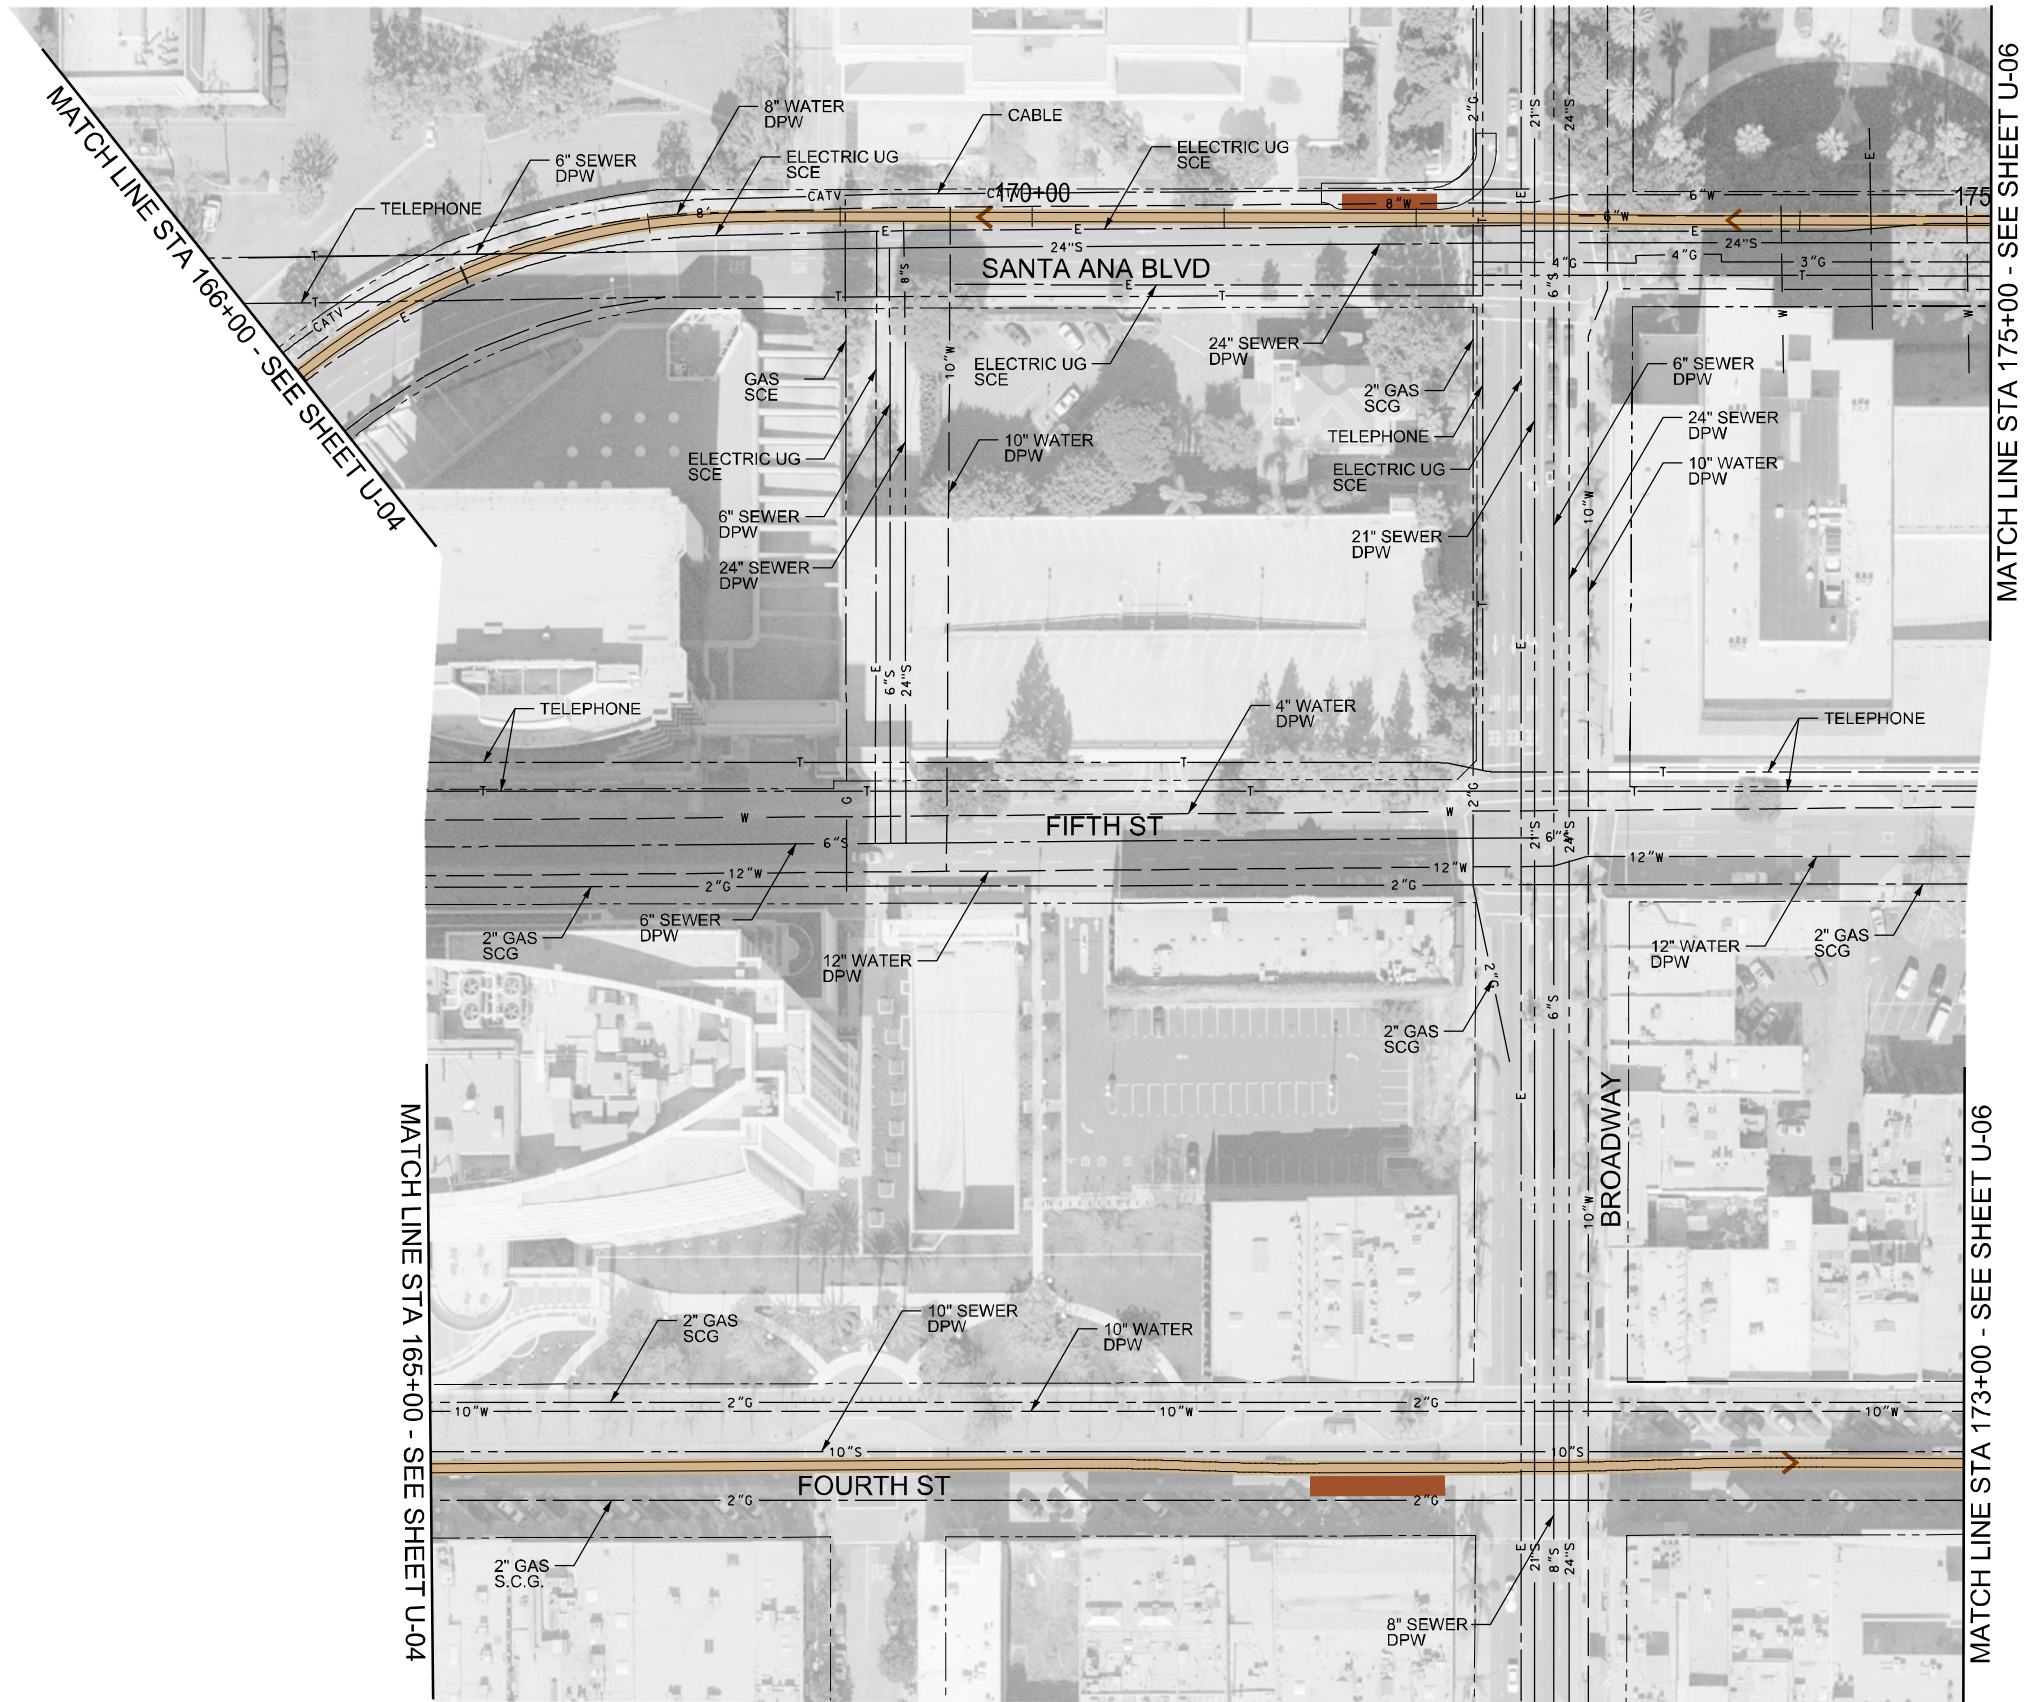

LEGEND	
---	W
---	S
---	G
---	E
---	CATV
---	CABLE
---	TELEPHONE
---	TRACK

WATER
SEWER
GAS
ELECTRICAL
CABLE
TELEPHONE
TRACK

ABBREVIATIONS

SCE SOUTHERN CALIFORNIA EDISON
DPW DEPARTMENT OF PUBLIC WORK
SCG SOUTHERN CALIFORNIA GAS

C CORDOBA CORPORATION
2677 NORTH MAIN STREET, SUITE 240
SANTA ANA, CA 92705
714.558.6024 PH - 714.558.8467 FAX



**SANTA ANA AND GARDEN GROVE
FIXED GUIDEWAY CORRIDOR**
EXISTING UTILITY PLANS
DOWNTOWN SEGMENT - ALT 1
STA 165+00 EB TO STA 173+00 EB

DRAWING NO.
U - 05
SHEET NO.
SCALE
HOR: 1"=100'



LEGEND	
---	W
---	S
---	G
---	E
---	CATV
---	T
---	TRACK

---	WATER
---	SEWER
---	GAS
---	ELECTRICAL
---	CABLE
---	TELEPHONE
---	TRACK

ABBREVIATIONS	
SCE	SOUTHERN CALIFORNIA EDISON
DPW	DEPARTMENT OF PUBLIC WORK
SCG	SOUTHERN CALIFORNIA GAS




CORDOBA CORPORATION
2677 NORTH MAIN STREET, SUITE 240
SANTA ANA, CA 92705
714.558.6024 PH - 714.558.8467 FAX



**SANTA ANA AND GARDEN GROVE
FIXED GUIDEWAY CORRIDOR**
EXISTING UTILITY PLANS
DOWNTOWN SEGMENT - ALT 1
STA 173+00 EB TO STA 182+00 EB

DRAWING NO.	U - 06
SHEET NO.	
SCALE	HOR: 1"=100'

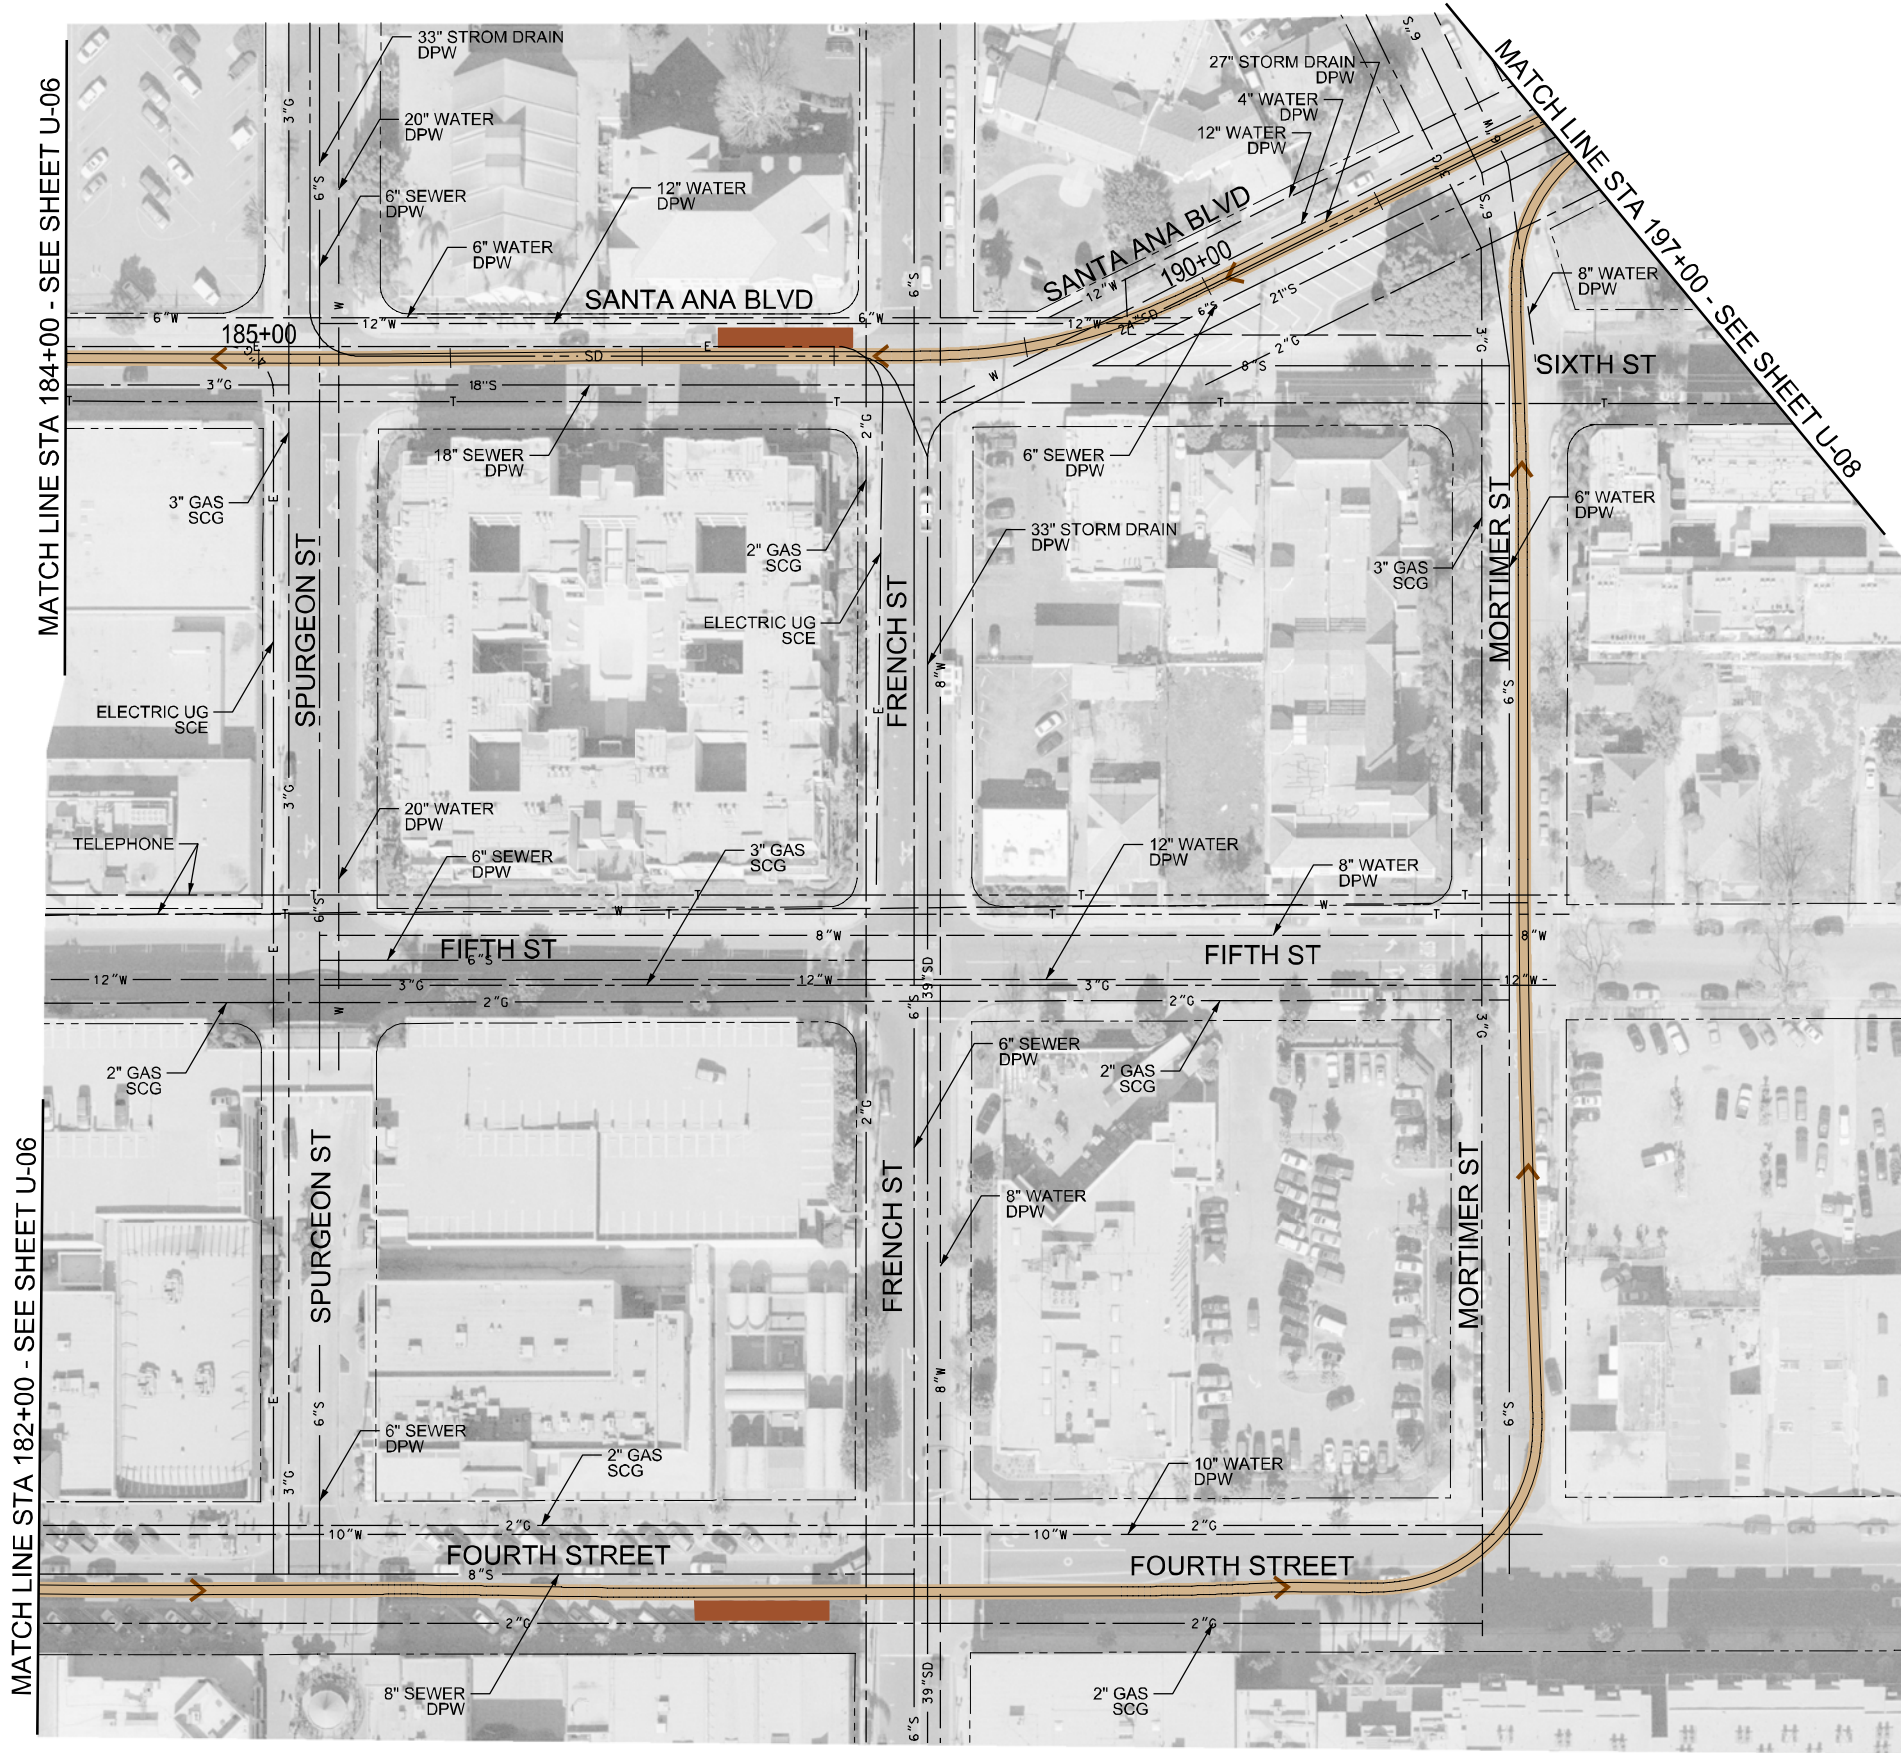

LEGEND	
---	W
---	S
---	G
---	E
---	CATV
---	T
---	WATER
---	SEWER
---	GAS
---	ELECTRICAL
---	CABLE
---	TELEPHONE
---	TRACK

ABBREVIATIONS	
SCE	SOUTHERN CALIFORNIA EDISON
DPW	DEPARTMENT OF PUBLIC WORK
SCG	SOUTHERN CALIFORNIA GAS





CORDOBA CORPORATION
2677 NORTH MAIN STREET, SUITE 240
SANTA ANA, CA 92705
714.558.6024 PH - 714.558.8467 FAX



**SANTA ANA AND GARDEN GROVE
FIXED GUIDEWAY CORRIDOR**
EXISTING UTILITY PLANS
DOWNTOWN SEGMENT - ALT 1
STA 182+00 EB TO STA 197+00 EB

DRAWING NO.	U - 07
SHEET NO.	
SCALE	HOR: 1"=100'

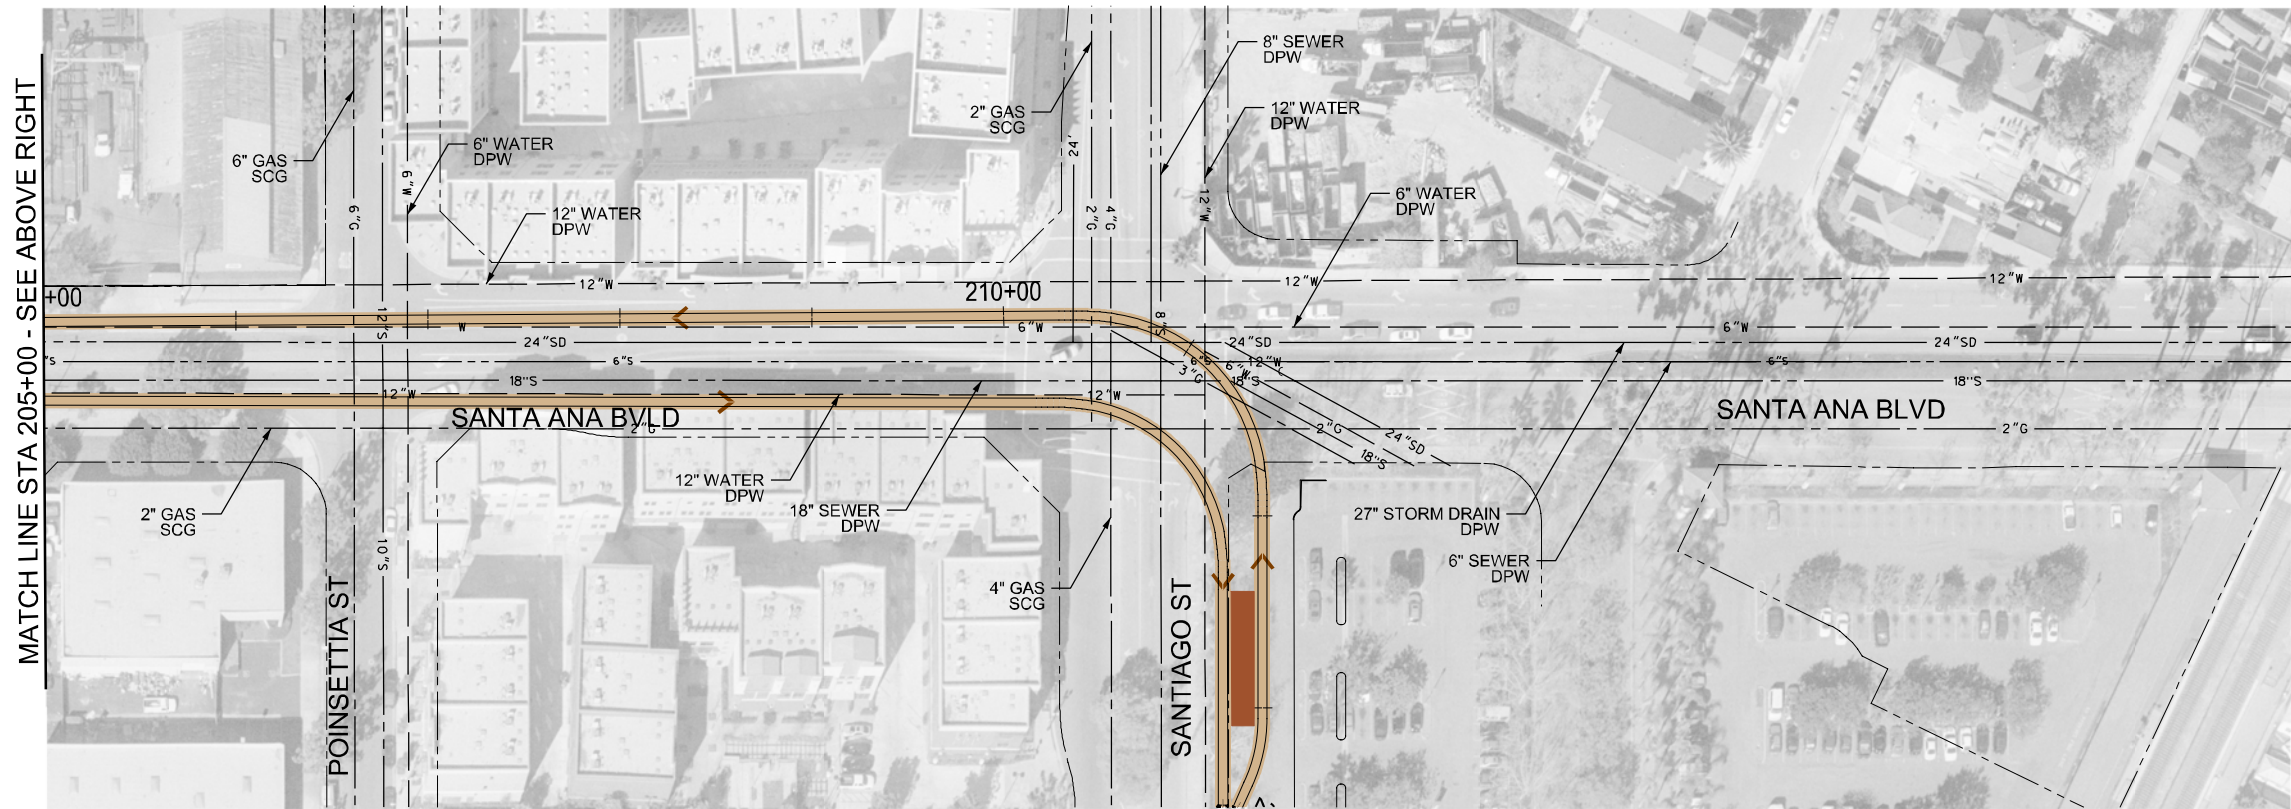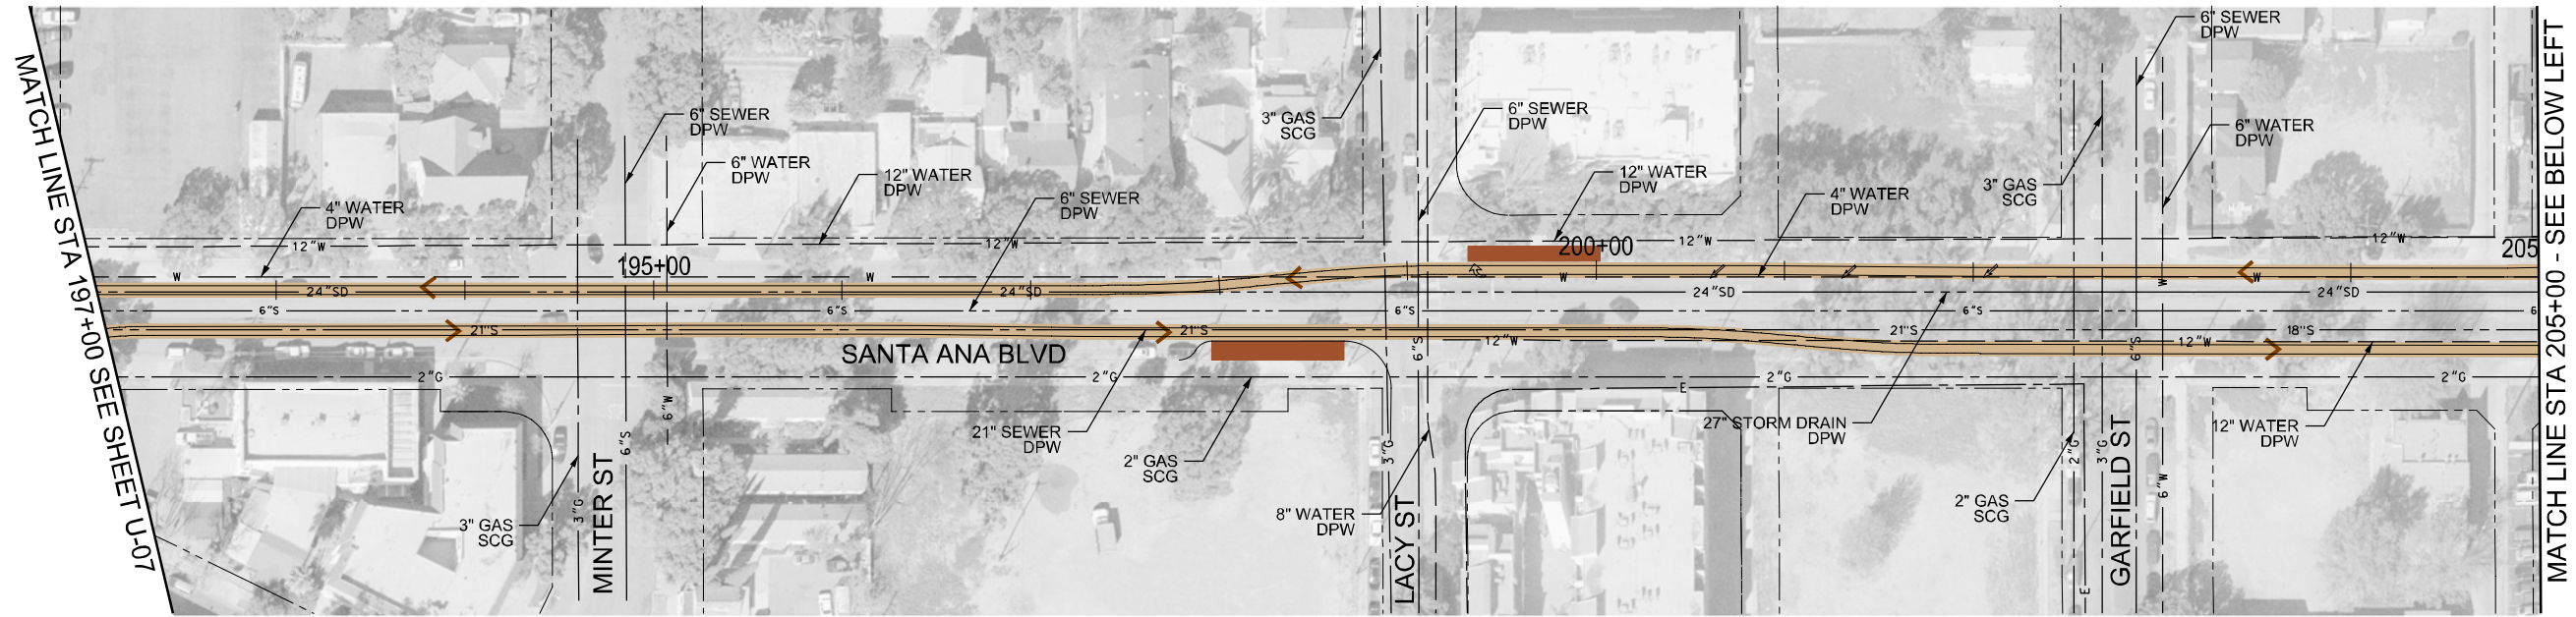

LEGEND	
---	W
---	S
---	G
---	E
---	CATV
---	T
---	TRACK

WATER
SEWER
GAS
ELECTRICAL
CABLE
TELEPHONE
TRACK

ABBREVIATIONS	
SCE	SOUTHERN CALIFORNIA EDISON
DPW	DEPARTMENT OF PUBLIC WORK
SCG	SOUTHERN CALIFORNIA GAS



CORDOBA CORPORATION
2677 NORTH MAIN STREET, SUITE 240
SANTA ANA, CA 92705
714.558.6024 PH - 714.558.8467 FAX



**SANTA ANA AND GARDEN GROVE
FIXED GUIDEWAY CORRIDOR**
EXISTING UTILITY PLANS
DOWNTOWN SEGMENT - ALT 1
STA 197+00 EB TO STA 216+85.76 EB

DRAWING NO.	U - 08
SHEET NO.	
SCALE	HOR: 1"=100'

This aerial view shows the utility layout for Santa Ana Blvd. The main thoroughfare, Santa Ana Blvd, runs horizontally across the center. It intersects with Flower St on the left and Parton St on the right. Civic Center Plaza is located to the east of Parton St. The utility layout includes various pipes and conduits: 12" Water DPW, 16" Water DPW, 24" Storm Drain DPW, 10" Water DPW, 10" Sewer DPW, 2" Gas SCG, Cable, CATV, and Electric UG SCE. Stationing markers are placed along Santa Ana Blvd at 150+00, 155+00, and 160+00. A match line at the right edge indicates the layout continues on Sheet U-10.

This aerial photograph shows the utility layout for Santa Ana Blvd. The main road is highlighted in orange with stationing markers at 150+00, 155+00, and 160+00. Key streets shown include Flower St, Parton St, and Civic Center Plaza. Utility lines are labeled with their respective sizes and types: 12" and 16" water DPW, 24" storm drain DPW, 10" water DPW, 10" sewer DPW, 2" gas SCG, 15" sewer DPW, 2" gas SCG, and electric UG SCE. Other labels include CATV, CABLE, and TELEPHONE. A match line on the right indicates the layout continues on sheet U-10 starting at station 160+00. A north arrow is located in the top right corner.

This aerial view shows the utility layout for Santa Ana Blvd. The main road is highlighted in orange with stationing markers at 150+00, 155+00, and 160+00. Key streets shown include Flower St, Parton St, and Civic Center Plaza. Various utility lines are labeled, including 12" Water DPW, 16" Water DPW, 24" Storm Drain DPW, 10" Water DPW, 10" Sewer DPW, 2" Gas SCG, Cable, CATV, and Electric UG SCE. A match line at the right edge indicates the continuation of the plan on sheet U-10 at station 160+00.

DRAWING NO.
U - 09

SHEET NO.

SCALE
HOR: 1"=100'

