

MATCH LINE STA 170+00 - SEE SHEET U-10

MATCH LINE STA 183+00 - SEE SHEET U-12

LEGEND

---	W	---	WATER
---	S	---	SEWER
---	G	---	GAS
---	E	---	ELECTRICAL
---	CATV	---	CABLE
---	T	---	TELEPHONE
---		---	TRACK

ABBREVIATIONS

SCE	SOUTHERN CALIFORNIA EDISON
DPW	DEPARTMENT OF PUBLIC WORK
SCG	SOUTHERN CALIFORNIA GAS

C **CORDOBA CORPORATION**
 2677 NORTH MAIN STREET, SUITE 240
 SANTA ANA, CA 92705
 714.558.6124 PH - 714.558.8467 FAX


OCTA  **GARDEN GROVE**

**SANTA ANA AND GARDEN GROVE
 FIXED GUIDEWAY CORRIDOR**
 EXISTING UTILITY PLANS
 DOWNTOWN SEGMENT - ALT 2
 STA 170+00 EB TO STA 183+00 EB

DRAWING NO.	U - 11
SHEET NO.	
SCALE	HOR: 1"=100'



MATCH LINE STA 198+00 - SEE SHEET U-17

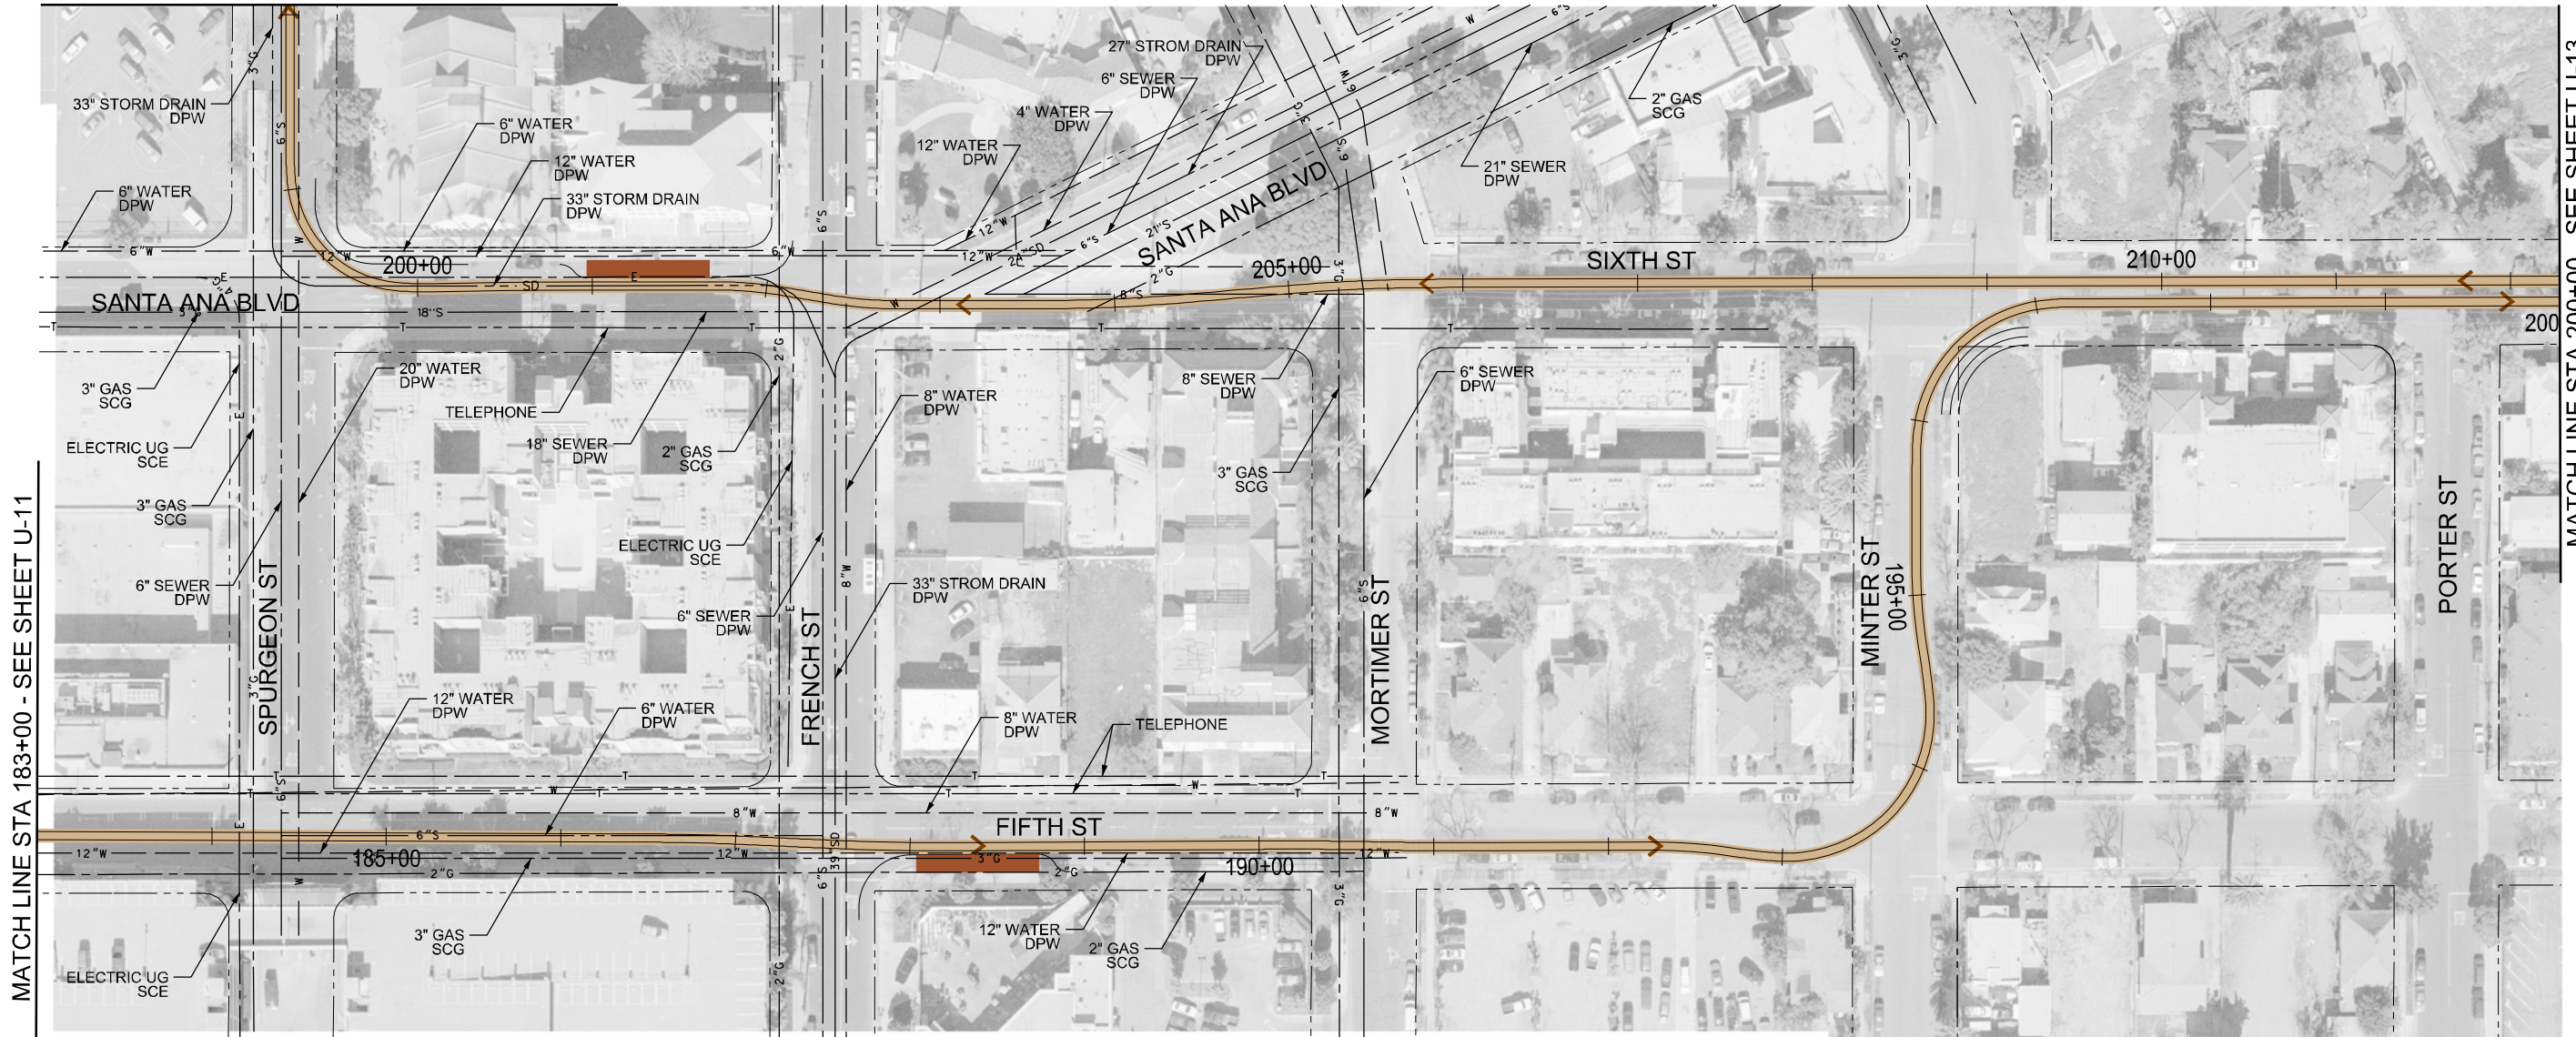

MATCH LINE STA 183+00 - SEE SHEET U-11

MATCH LINE STA 200+00 - SEE SHEET U-13

LEGEND

---	W	---	WATER
---	S	---	SEWER
---	G	---	GAS
---	E	---	ELECTRICAL
---	CATV	---	CABLE
---	T	---	TELEPHONE
---		---	TRACK

ABBREVIATIONS


SCE	SOUTHERN CALIFORNIA EDISON
DPW	DEPARTMENT OF PUBLIC WORK
SCG	SOUTHERN CALIFORNIA GAS

C CORDOBA CORPORATION
 2677 NORTH MAIN STREET, SUITE 240
 SANTA ANA, CA 92705
 714.558.6124 PH - 714.558.8467 FAX



**SANTA ANA AND GARDEN GROVE
 FIXED GUIDEWAY CORRIDOR**
 EXISTING UTILITY PLANS
 DOWNTOWN SEGMENT - ALT 2
 STA 183+00 EB TO STA 200+00 EB

DRAWING NO.	U - 12
SHEET NO.	
SCALE	HOR: 1"=100'

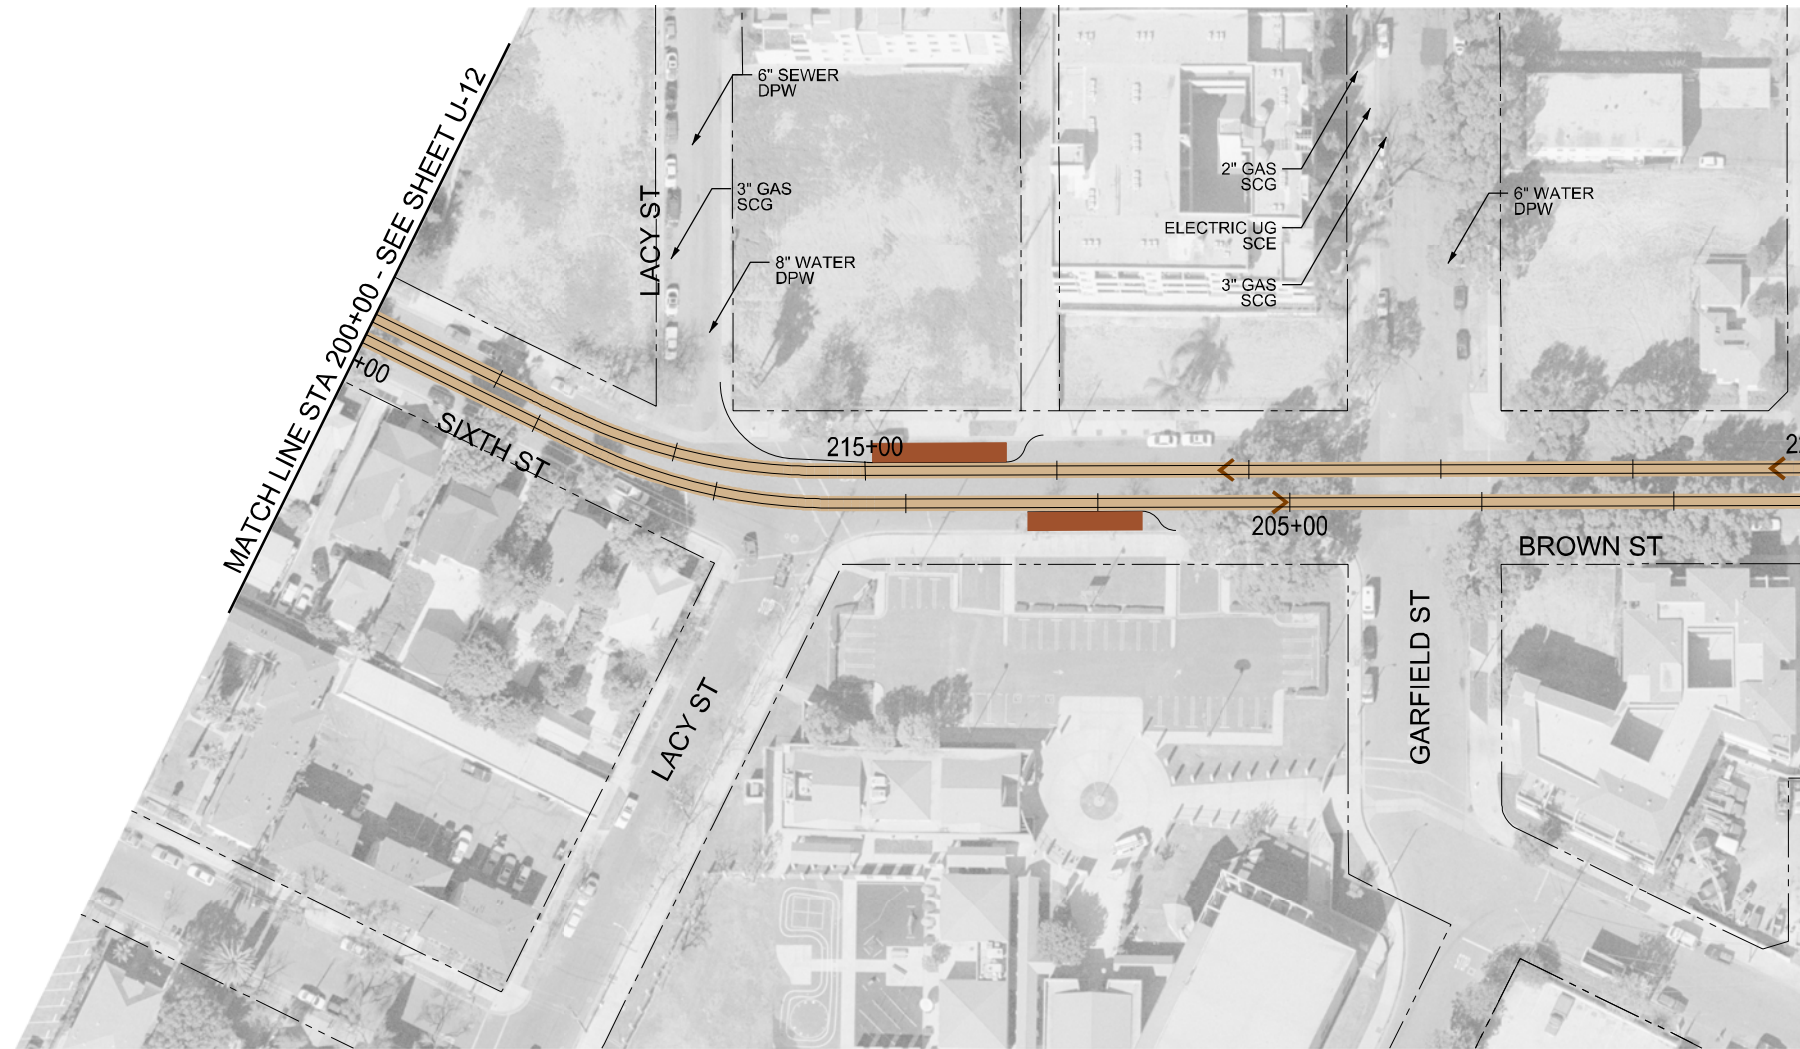

LEGEND

- W — WATER
- S — SEWER
- G — GAS
- E — ELECTRICAL
- CATV — CABLE
- T — TELEPHONE
- TRACK — TRACK



ABBREVIATIONS

- SCE SOUTHERN CALIFORNIA EDISON
- DPW DEPARTMENT OF PUBLIC WORK
- SCG SOUTHERN CALIFORNIA GAS

C CORDOBA CORPORATION
 2677 NORTH MAIN STREET, SUITE 240
 SANTA ANA, CA 92705
 714.558.6124 PH - 714.558.8467 FAX

**SANTA ANA AND GARDEN GROVE
 FIXED GUIDEWAY CORRIDOR**
 EXISTING UTILITY PLANS
 DOWNTOWN SEGMENT - ALT 2
 STA 200+00 EB TO STA 220+00 EB

DRAWING NO.	U - 13
SHEET NO.	
SCALE	HOR: 1"=100'

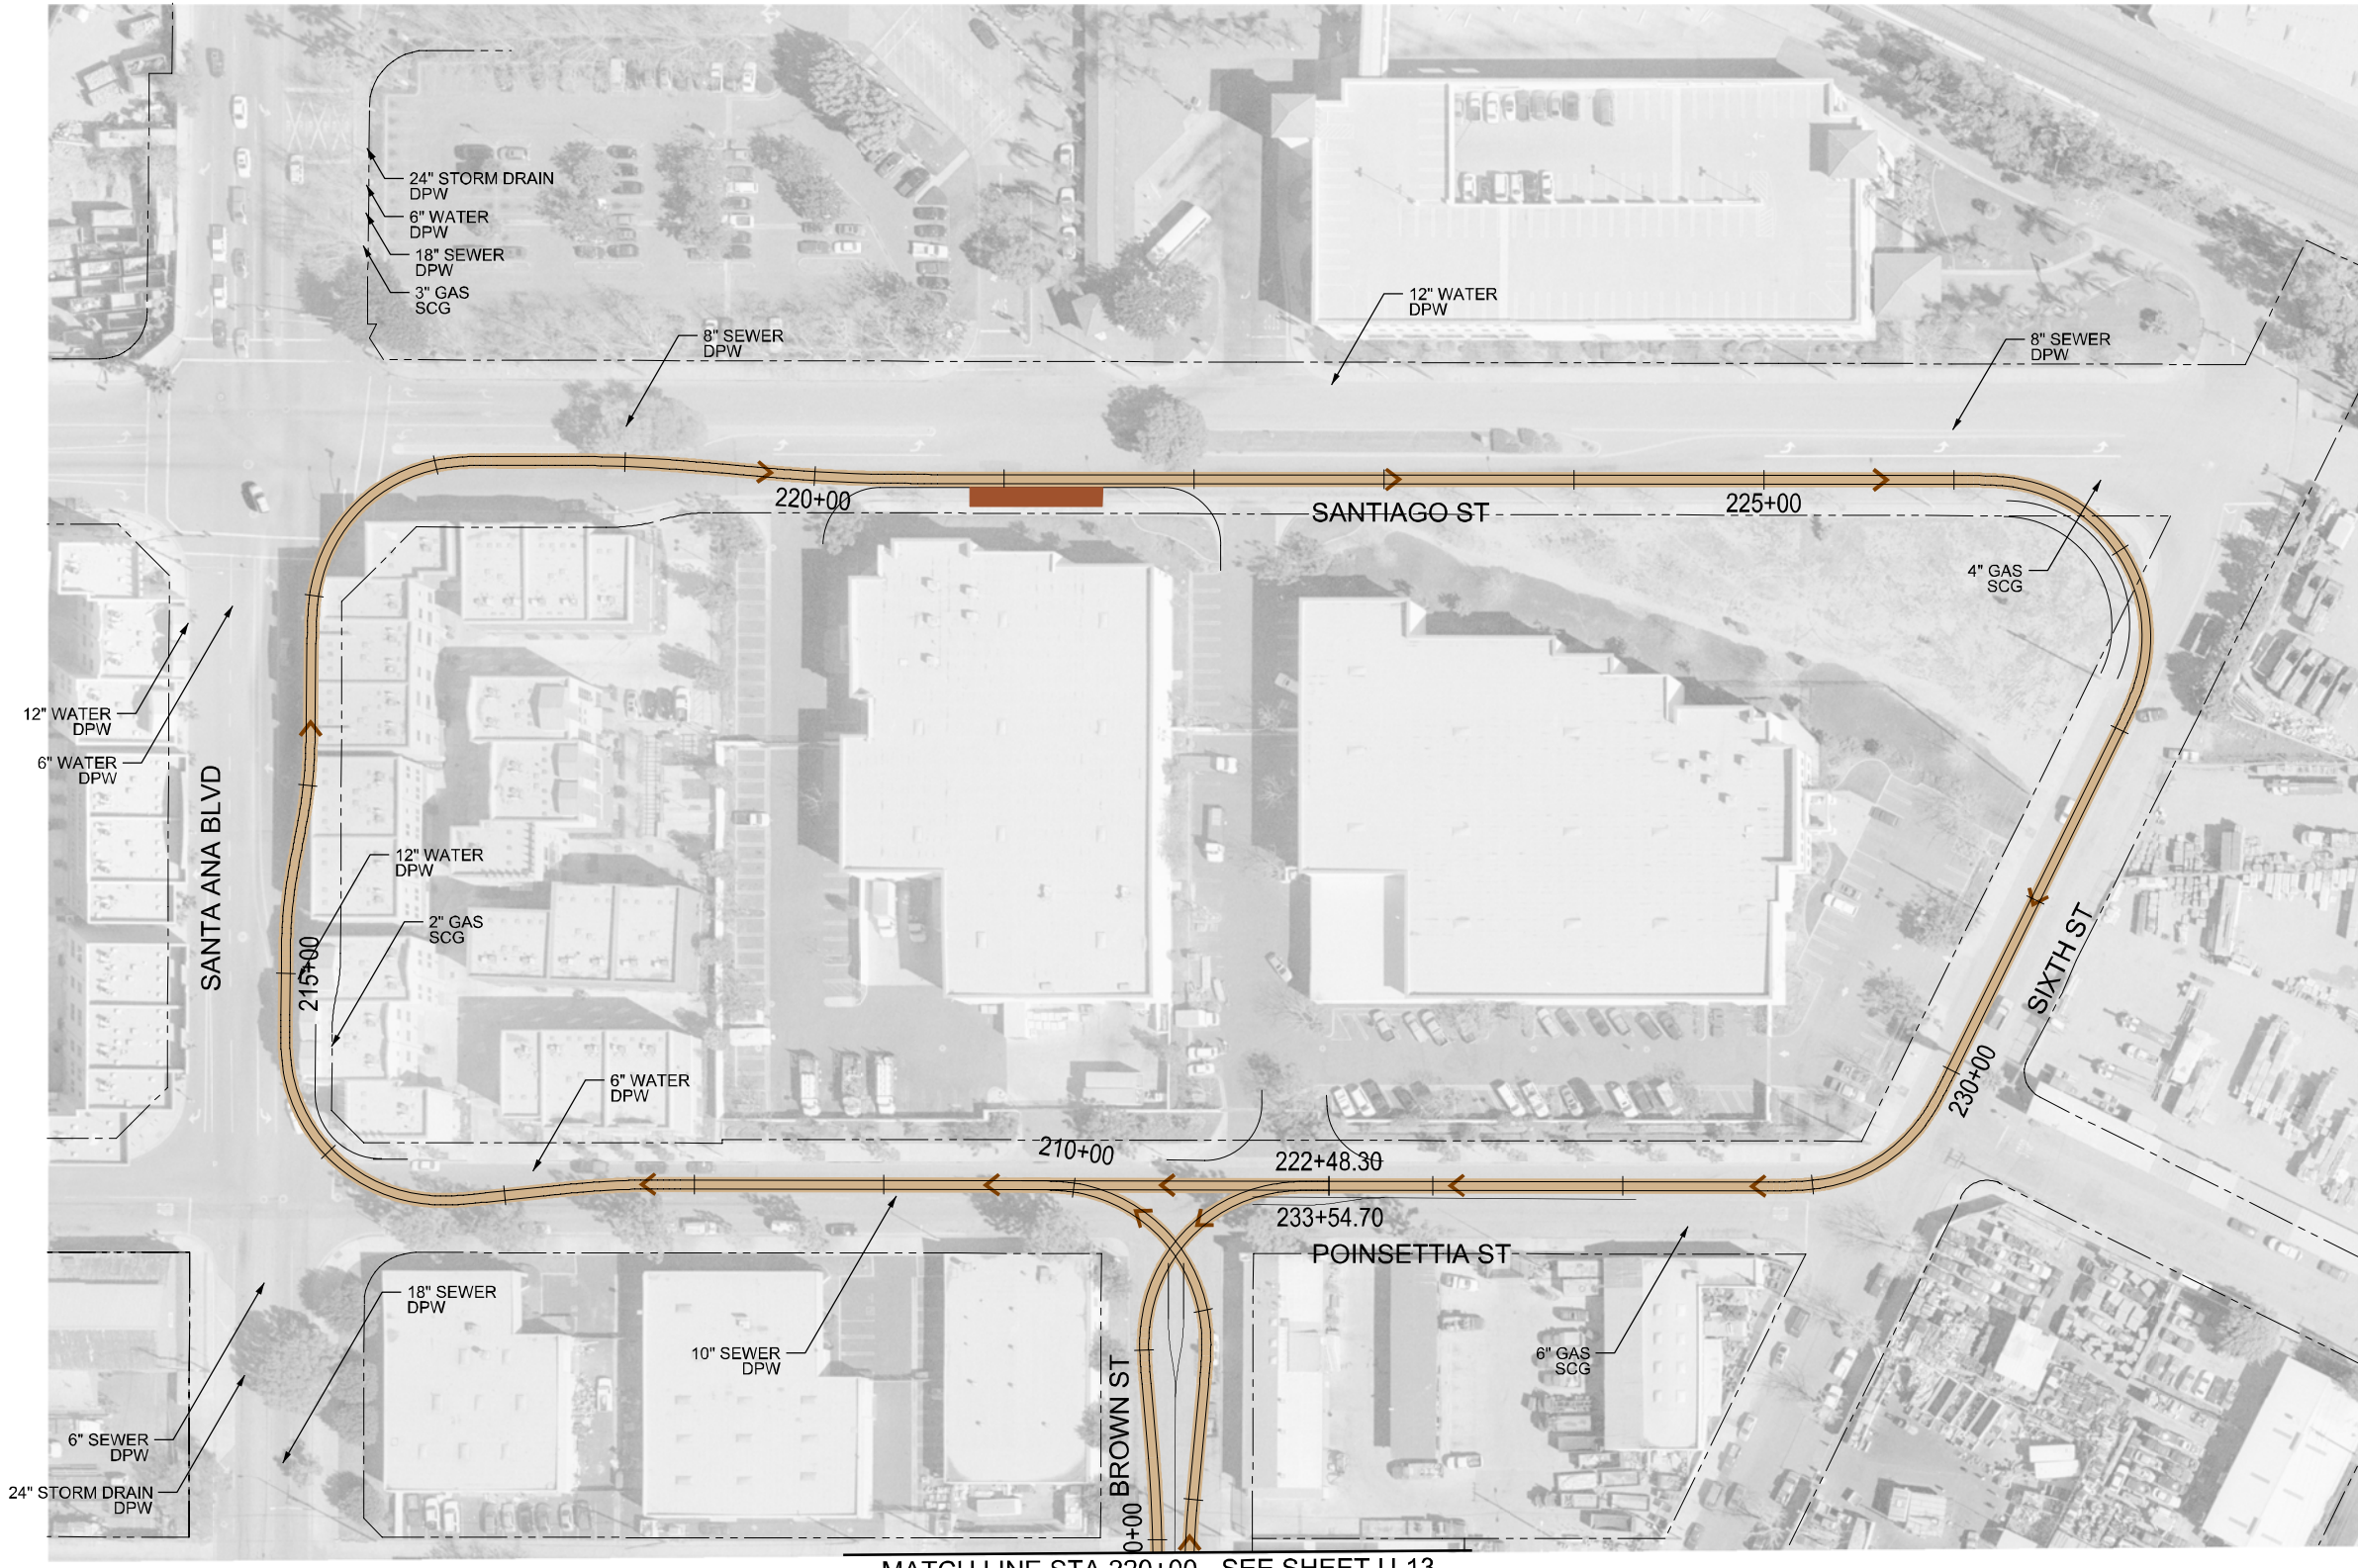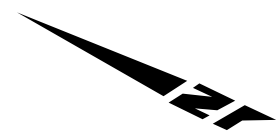

MATCH LINE STA 220+00 - SEE SHEET U-13

LEGEND

---	W	---	WATER
---	S	---	SEWER
---	G	---	GAS
---	E	---	ELECTRICAL
---	CATV	---	CABLE
---	T	---	TELEPHONE
---		---	TRACK

ABBREVIATIONS


SCE	SOUTHERN CALIFORNIA EDISON
DPW	DEPARTMENT OF PUBLIC WORK
SCG	SOUTHERN CALIFORNIA GAS

C **CORDOBA CORPORATION**
 2677 NORTH MAIN STREET, SUITE 240
 SANTA ANA, CA 92705
 714.558.6124 PH - 714.558.8467 FAX

OCTA **Santa Ana Education 1st** **GARDEN GROVE**

**SANTA ANA AND GARDEN GROVE
 FIXED GUIDEWAY CORRIDOR**
 EXISTING UTILITY PLANS
 DOWNTOWN SEGMENT - ALT 2
 STA 220+00 EB TO LOOP

DRAWING NO.	U - 14
SHEET NO.	
SCALE	HOR: 1"=100'

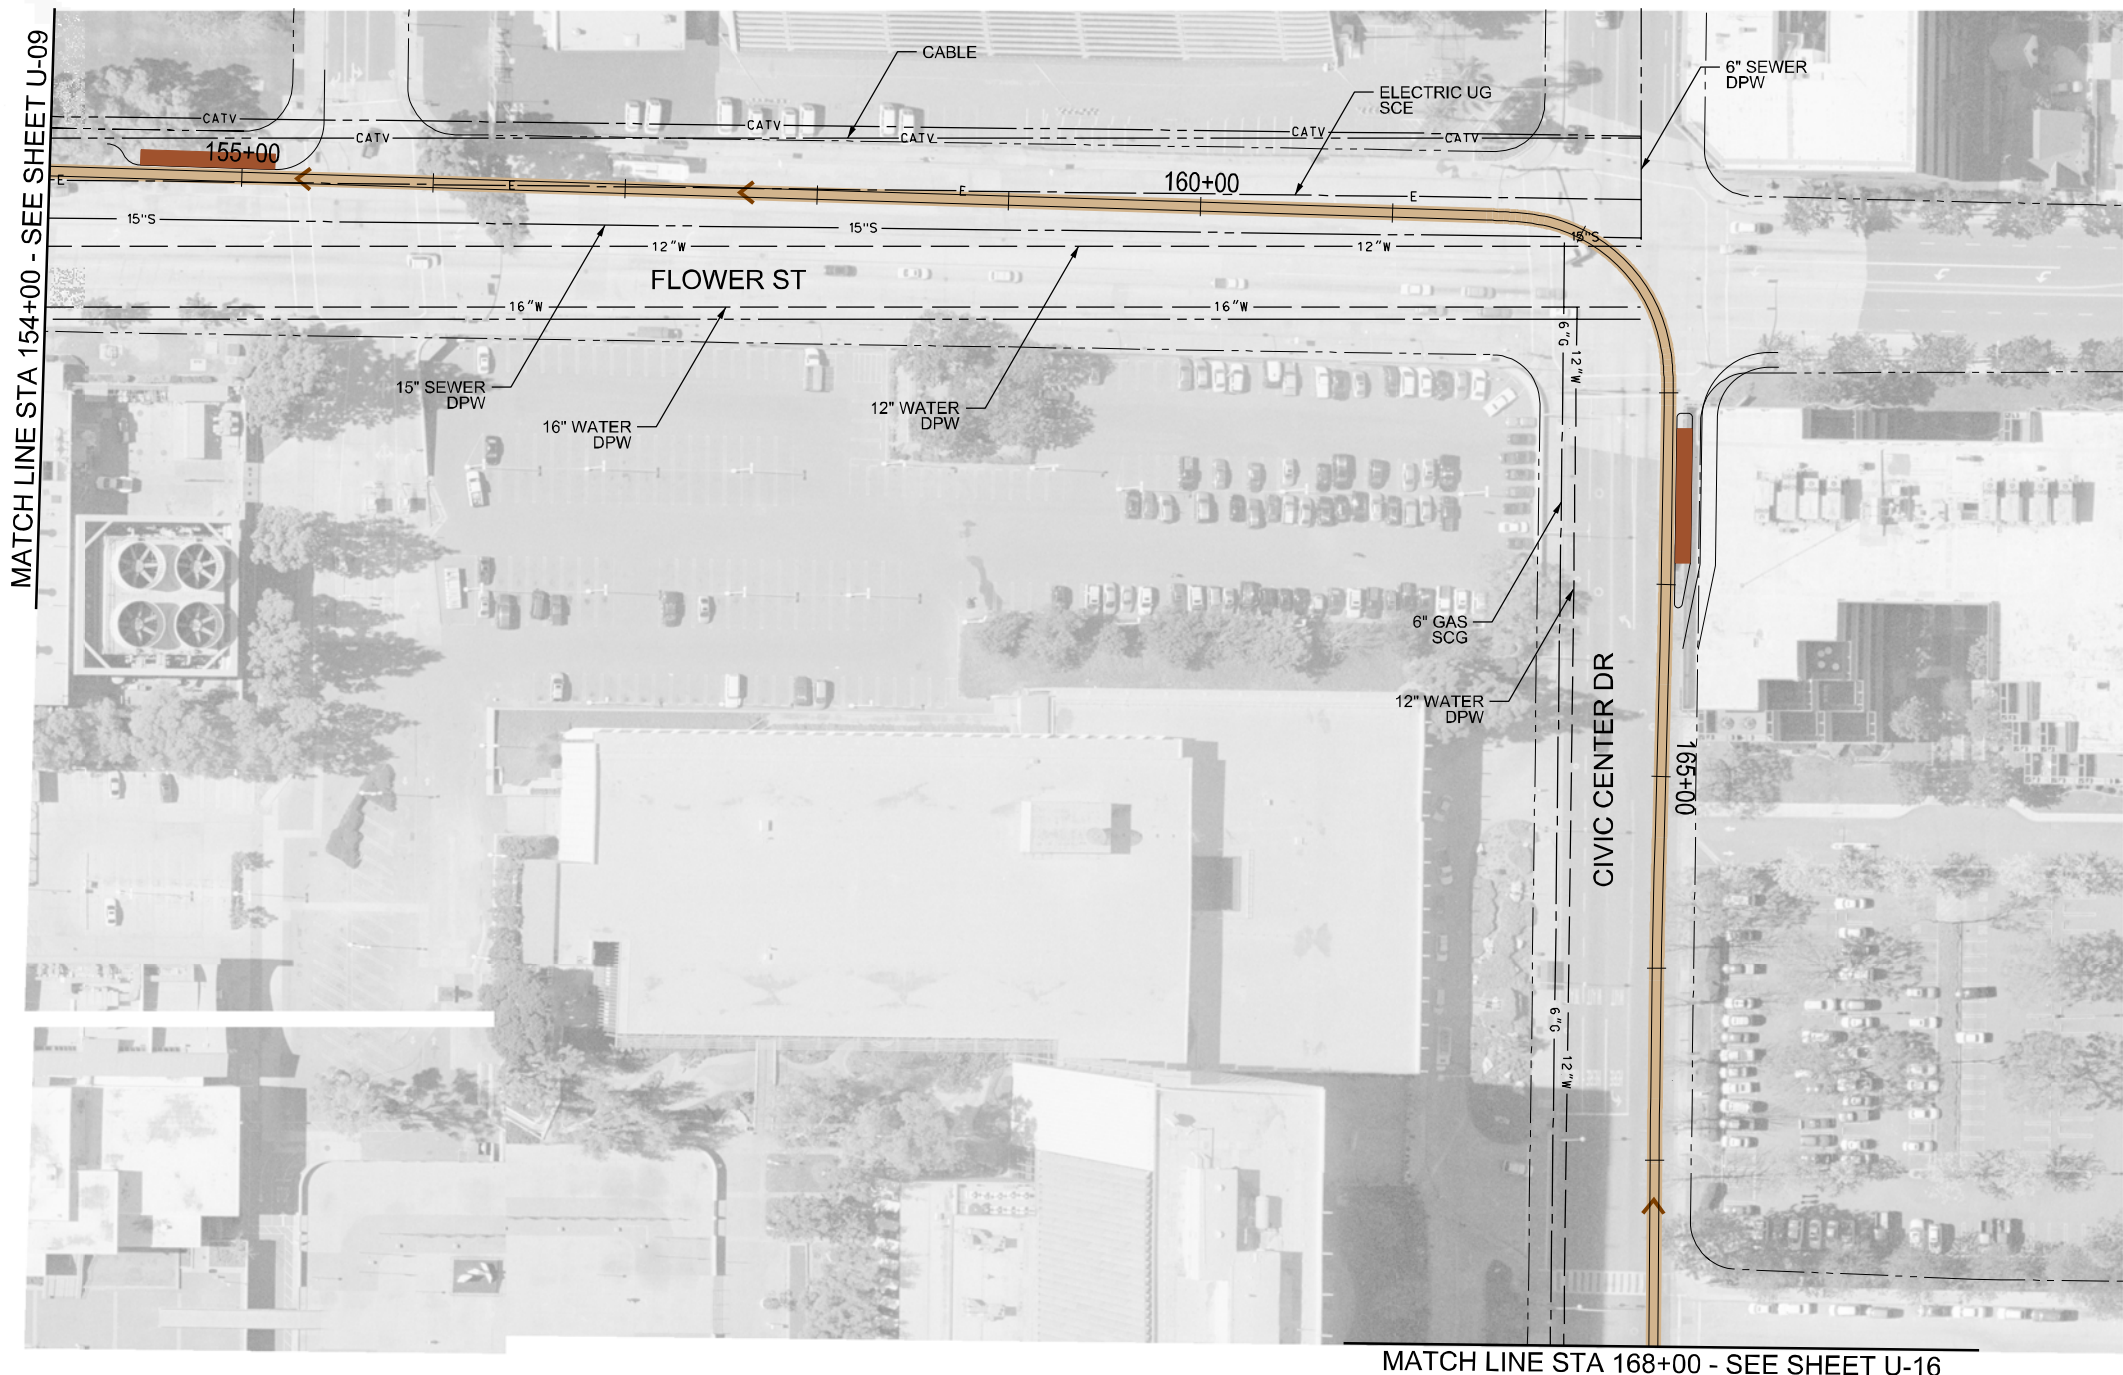

MATCH LINE STA 154+00 - SEE SHEET U-09

MATCH LINE STA 168+00 - SEE SHEET U-16

LEGEND

---	W	---	WATER
---	S	---	SEWER
---	G	---	GAS
---	E	---	ELECTRICAL
---	CATV	---	CABLE
---	T	---	TELEPHONE
---		---	TRACK

ABBREVIATIONS

SCE	SOUTHERN CALIFORNIA EDISON
DPW	DEPARTMENT OF PUBLIC WORK
SCG	SOUTHERN CALIFORNIA GAS

C CORDOBA CORPORATION
 2677 NORTH MAIN STREET, SUITE 240
 SANTA ANA, CA 92705
 714.558.6124 PH - 714.558.8467 FAX

OCTA  **GARDEN GROVE**

**SANTA ANA AND GARDEN GROVE
 FIXED GUIDEWAY CORRIDOR**
 EXISTING UTILITY PLANS
 DOWNTOWN SEGMENT - ALT 2
 STA 154+00 WB TO STA 168+00 WB

DRAWING NO.	U - 15
SHEET NO.	
SCALE	HOR: 1"=100'



MATCH LINE STA 168+00 - SEE SHEET U-15

MATCH LINE STA 182+00 - SEE SHEET U-17



LEGEND

---	W	---	WATER
---	S	---	SEWER
---	G	---	GAS
---	E	---	ELECTRICAL
---	CATV	---	CABLE
---	T	---	TELEPHONE
---		---	TRACK

ABBREVIATIONS


SCE	SOUTHERN CALIFORNIA EDISON
DPW	DEPARTMENT OF PUBLIC WORK
SCG	SOUTHERN CALIFORNIA GAS

C **CORDOBA CORPORATION**
 2677 NORTH MAIN STREET, SUITE 240
 SANTA ANA, CA 92705
 714.558.6124 PH - 714.558.8467 FAX

OCTA **Santa Ana** **GARDEN GROVE**
 Education 1st

**SANTA ANA AND GARDEN GROVE
 FIXED GUIDEWAY CORRIDOR**
 EXISTING UTILITY PLANS
 DOWNTOWN SEGMENT - ALT 2
 STA 168+00 WB TO STA 182+00 WB

DRAWING NO.	U - 16
SHEET NO.	
SCALE	HOR: 1"=100'

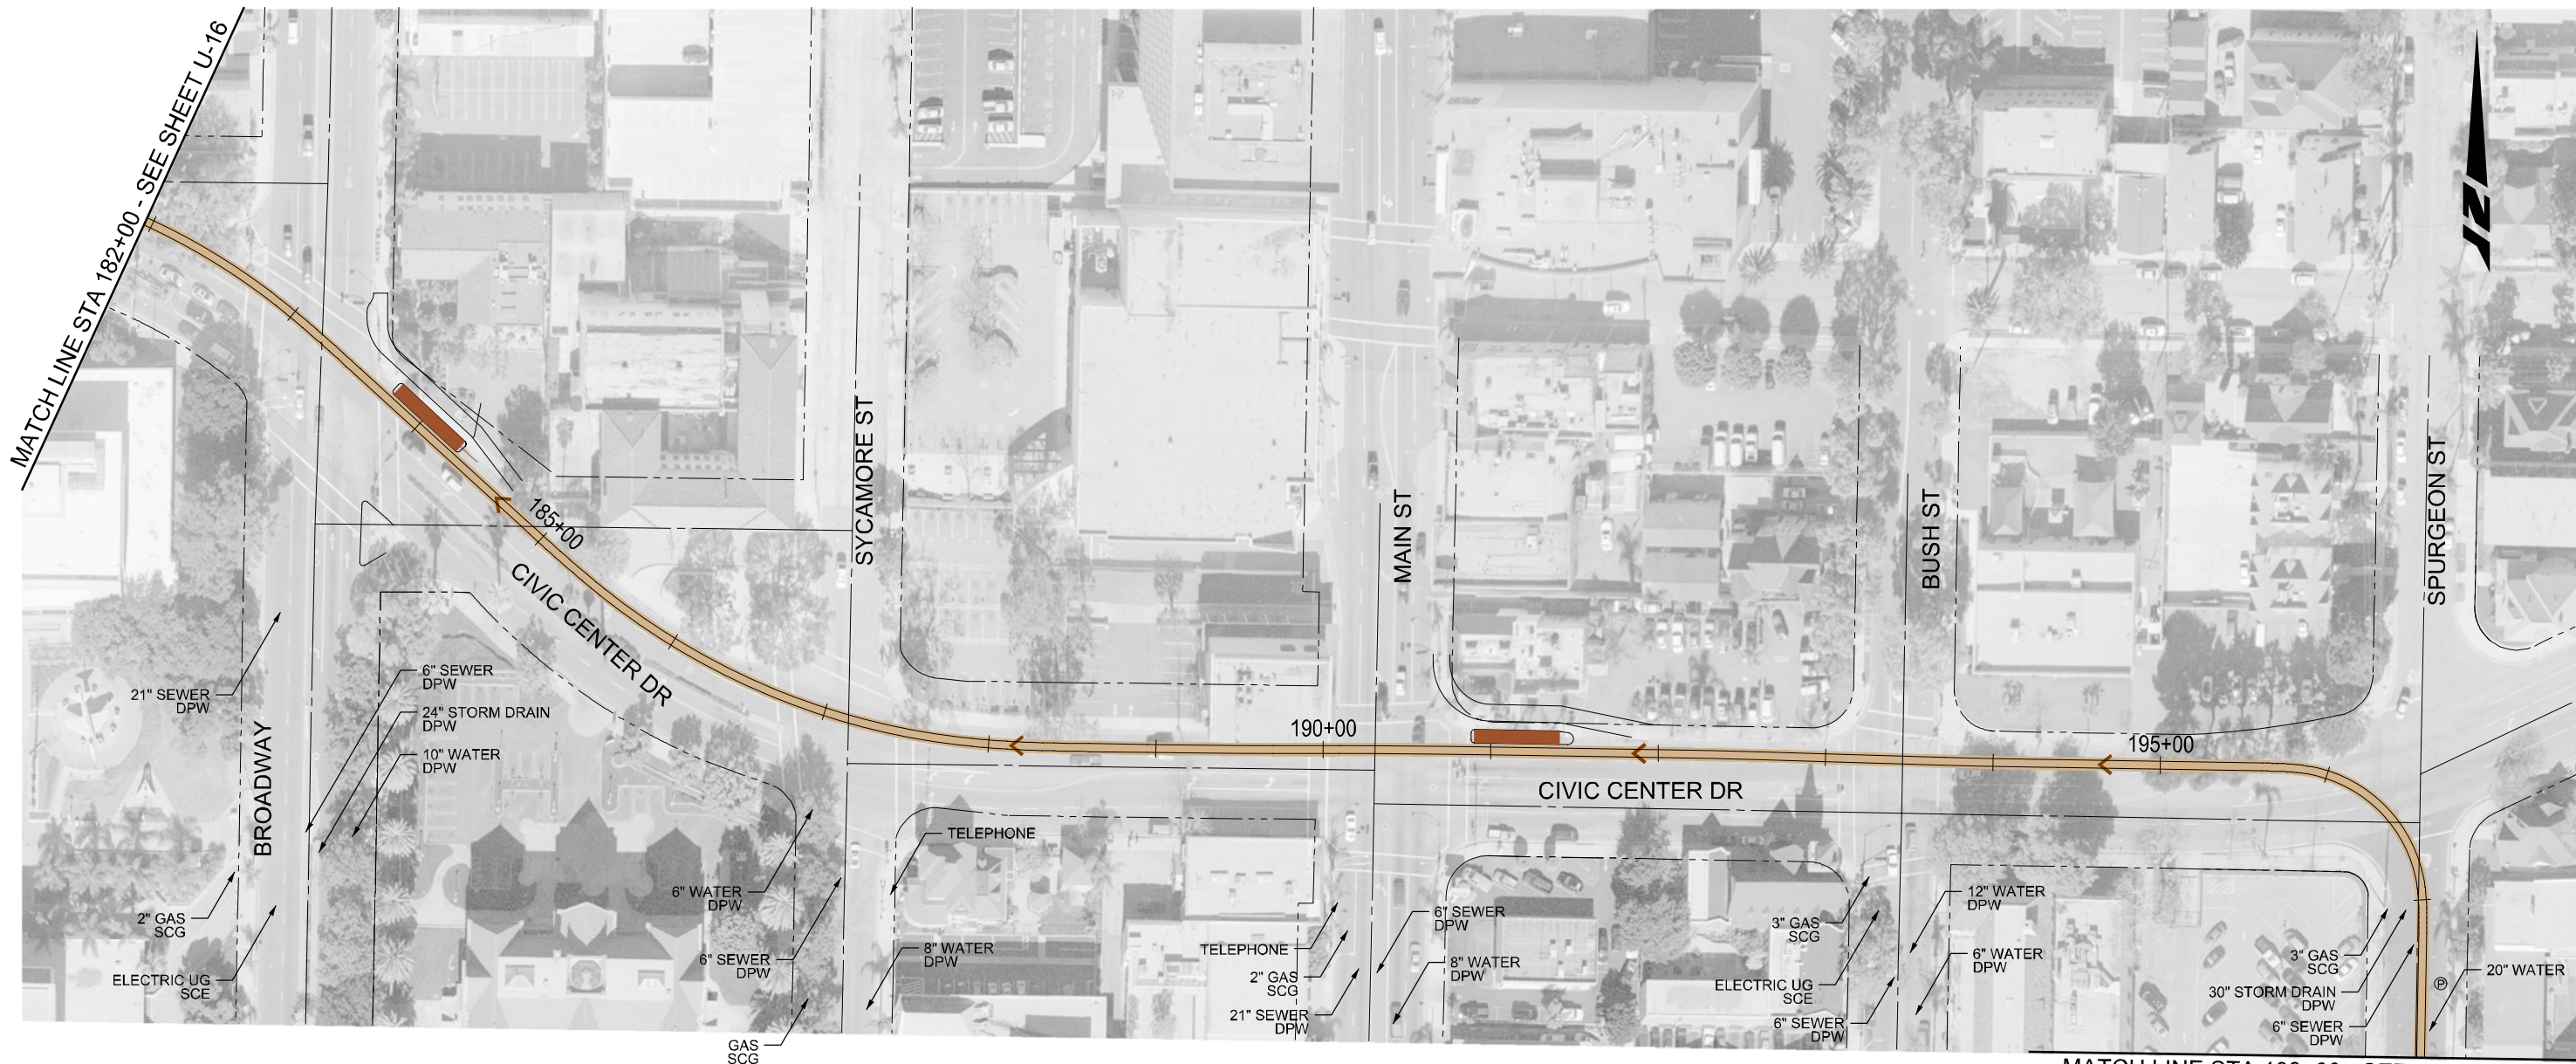

LEGEND

---	W	---	WATER
---	S	---	SEWER
---	G	---	GAS
---	E	---	ELECTRICAL
---	CATV	---	CABLE
---	T	---	TELEPHONE
---		---	TRACK

ABBREVIATIONS

SCE	SOUTHERN CALIFORNIA EDISON
DPW	DEPARTMENT OF PUBLIC WORK
SCG	SOUTHERN CALIFORNIA GAS

C CORDOBA CORPORATION
 2677 NORTH MAIN STREET, SUITE 240
 SANTA ANA, CA 92705
 714.558.6124 PH - 714.558.8467 FAX

OCTA  **G**
GARDEN GROVE

**SANTA ANA AND GARDEN GROVE
 FIXED GUIDEWAY CORRIDOR**
 EXISTING UTILITY PLANS
 DOWNTOWN SEGMENT - ALT 2
 STA 182+00 WB TO STA 198+00 WB

DRAWING NO.	U - 17
SHEET NO.	
SCALE	HOR: 1"=100'

This page left blank intentionally.