


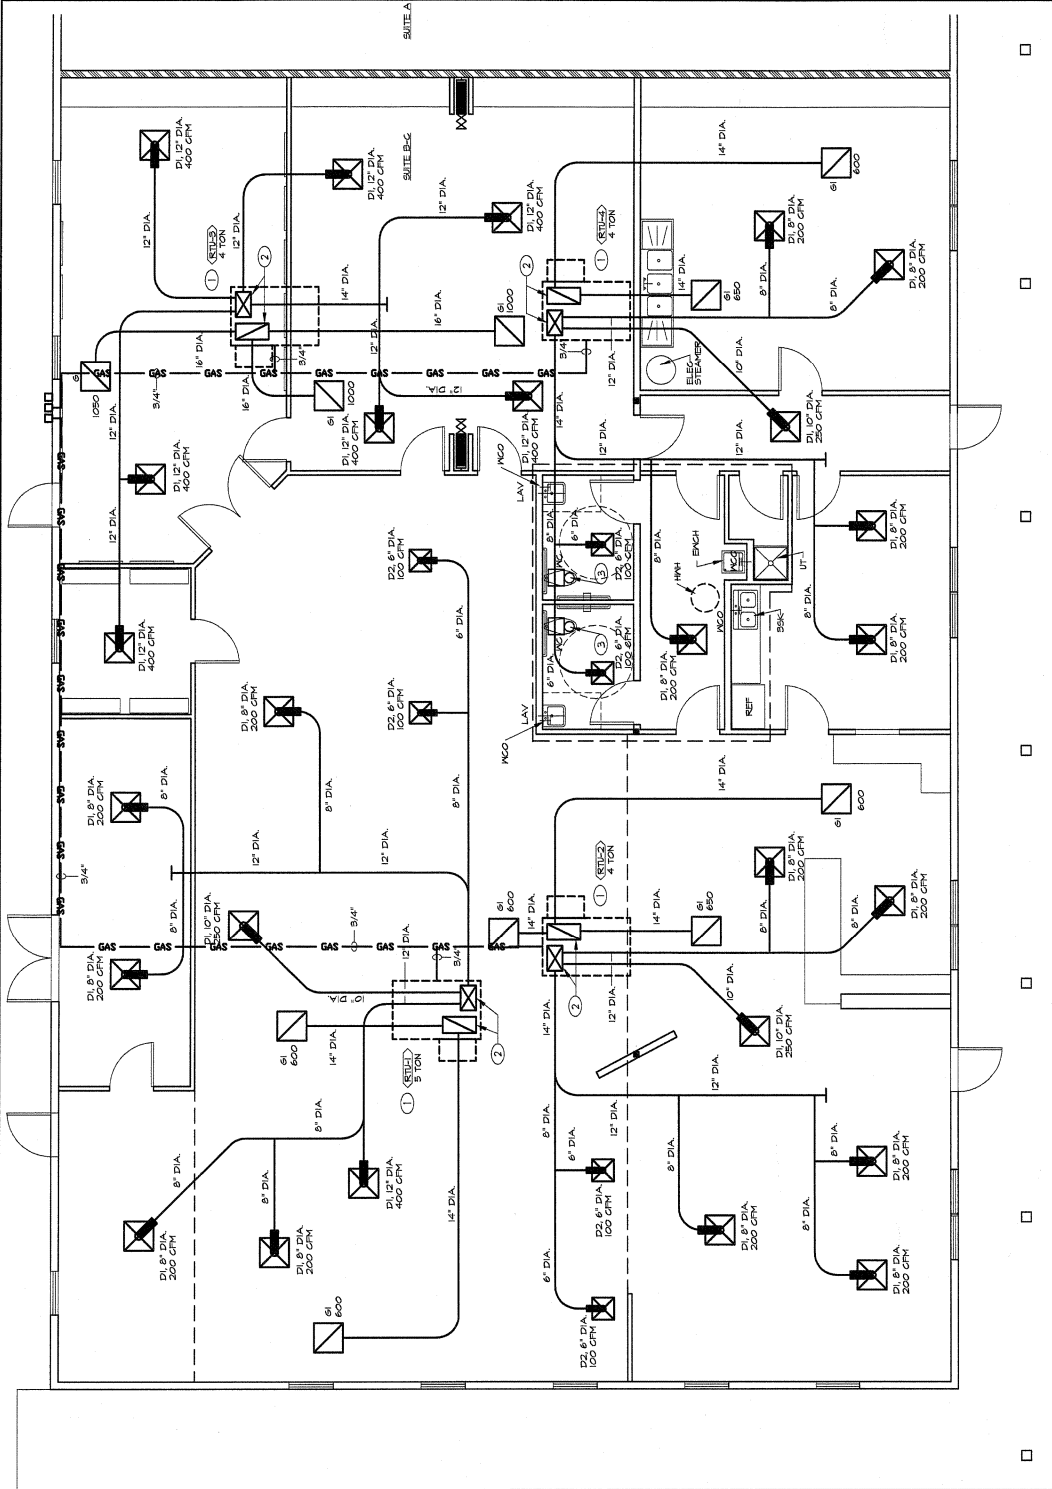

KEYED NOTES

- ① ROOFTOP PACKAGE UNIT ON ROOF. INSTALL PER MANUFACTURER'S REQUIREMENTS.
COORDINATE CURB INSTALLATION WITH ROOF CONTRACTOR.
- ② SUPPLY & RETURN AIR DUCTWORK UP THROUGH ROOF TO UNIT.
- ③ 180 CRI CEILING EXHAUSTERS 108" DIAMETER EXHAUST DUCT THROUGH ROOF TO ROOF CAP.
- ④ EXTEND 1" CUI LINE TO EXISTING MAIN WATERLINE. EXTEND 3/4" CUI CONNECTION TO ALL PLUMBING
FURNISH & REGENERATOR. EXTEND 3/4" HD CONNECTIONS TO LAVATORIES SHOWERS & SINKS.
PROVIDE ISOLATION VALVES.
- ⑤ EXTEND RELIEF LINE TO OUTSIDE AT 12' ABOVE FINISH FLOOR.

MECHANICAL/PLUMBING PLAN



PROPOSED TENANT
SPACE DESIGNATED
SUITE - B AND C



SCALE: 1/4" = 1'-0"