
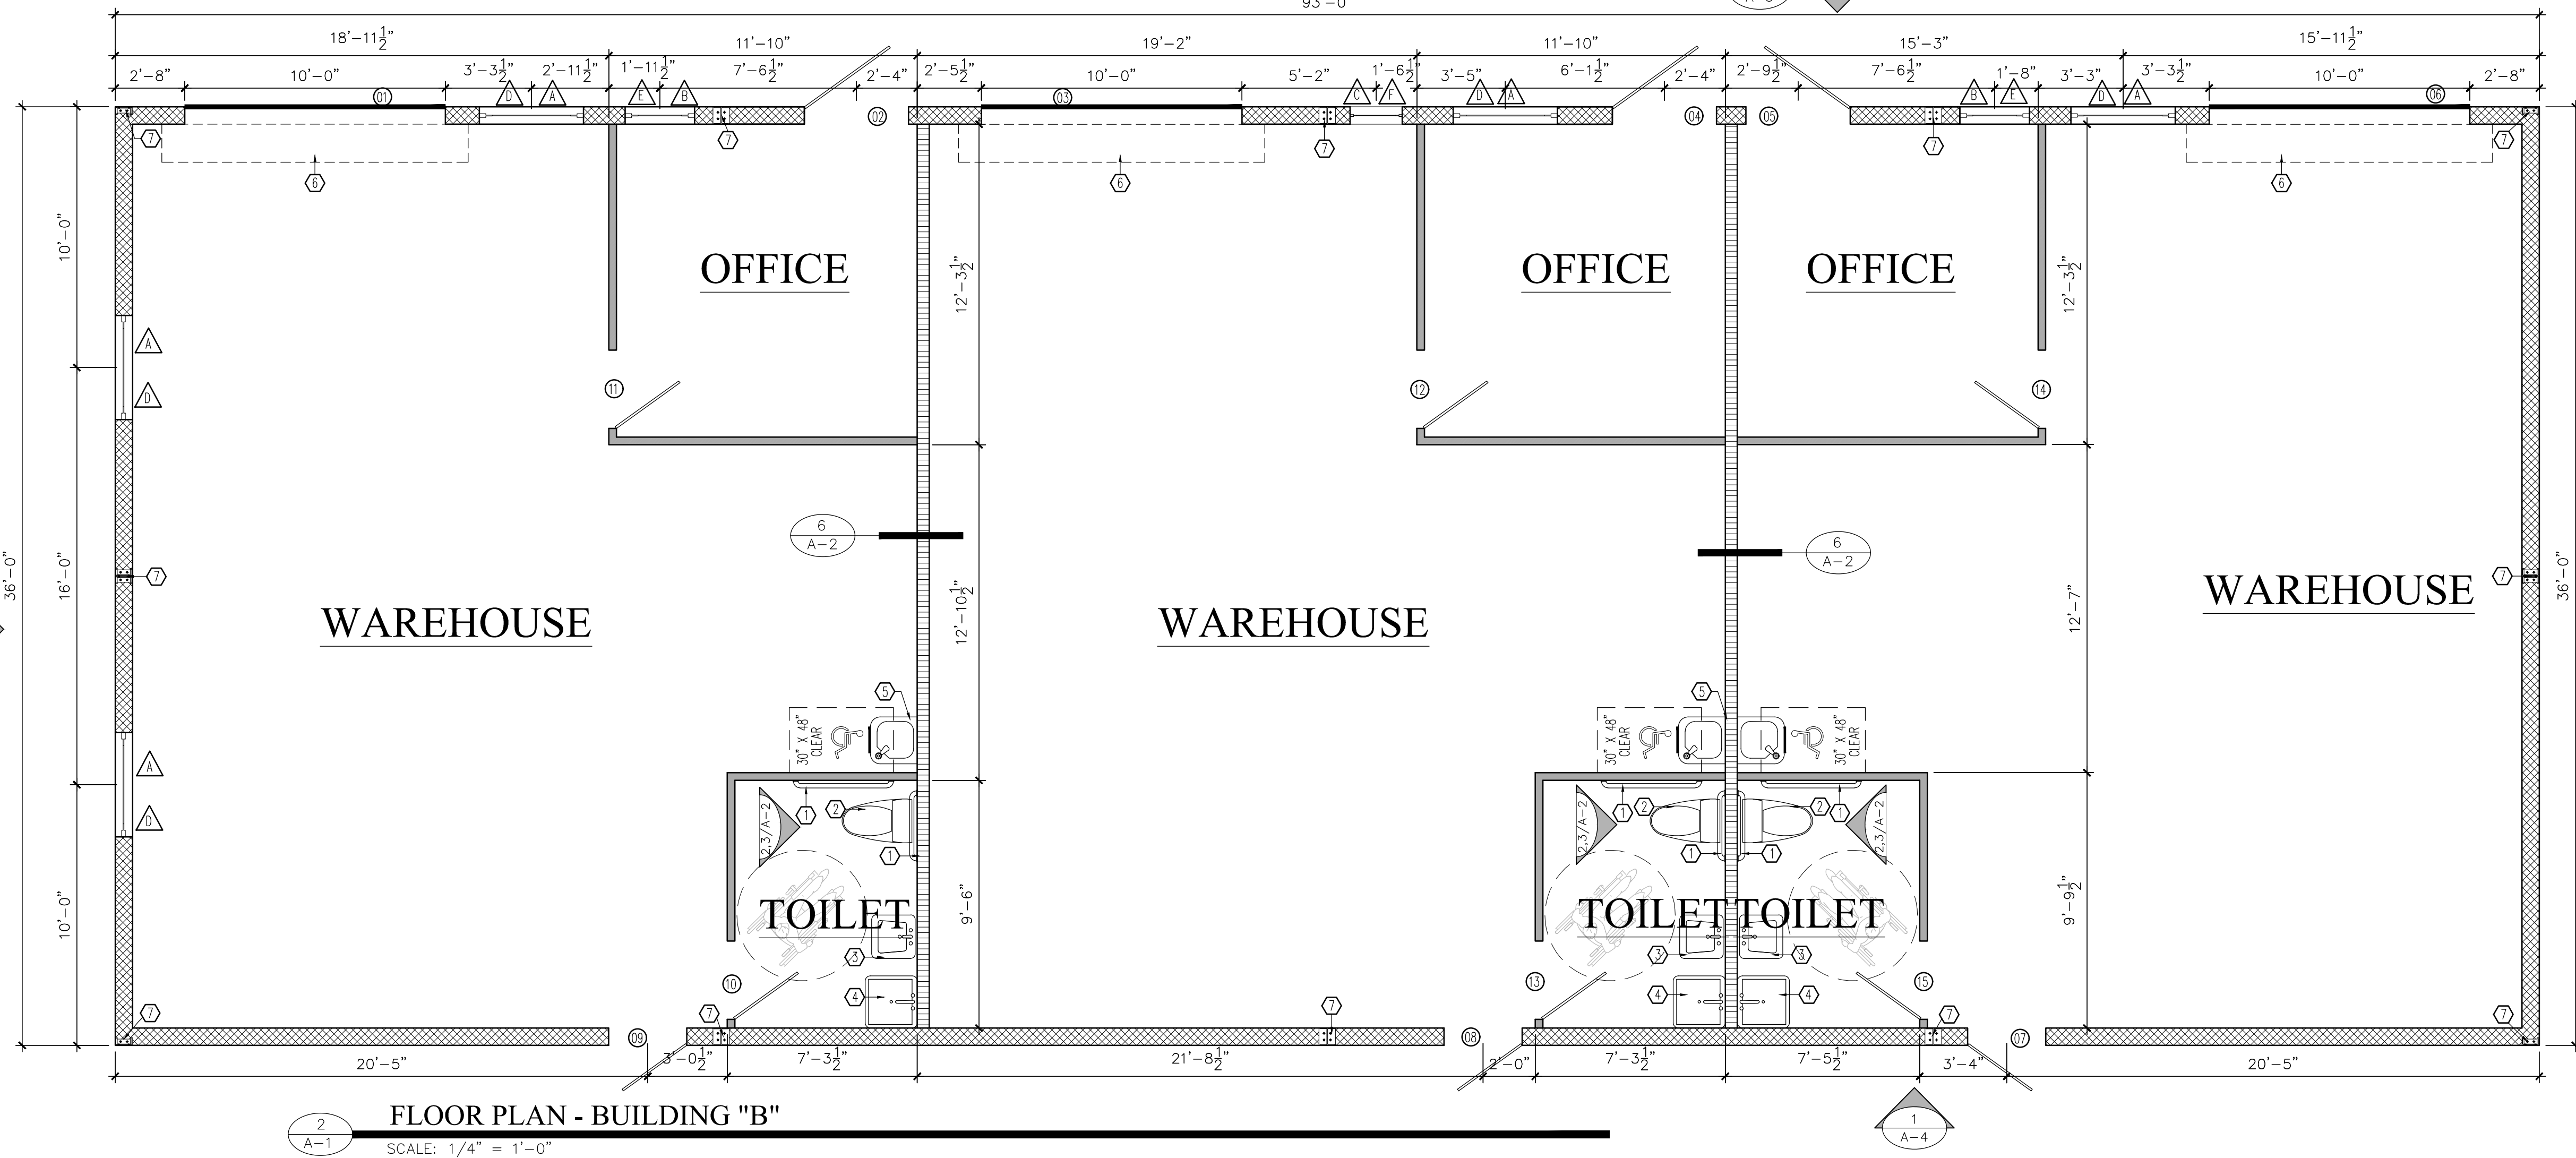


Z:\NAVA-TECH-DWG\VALUED SECURITY\CD's\A-1.dwg [A-1]-8/20/21, 4:44 pm

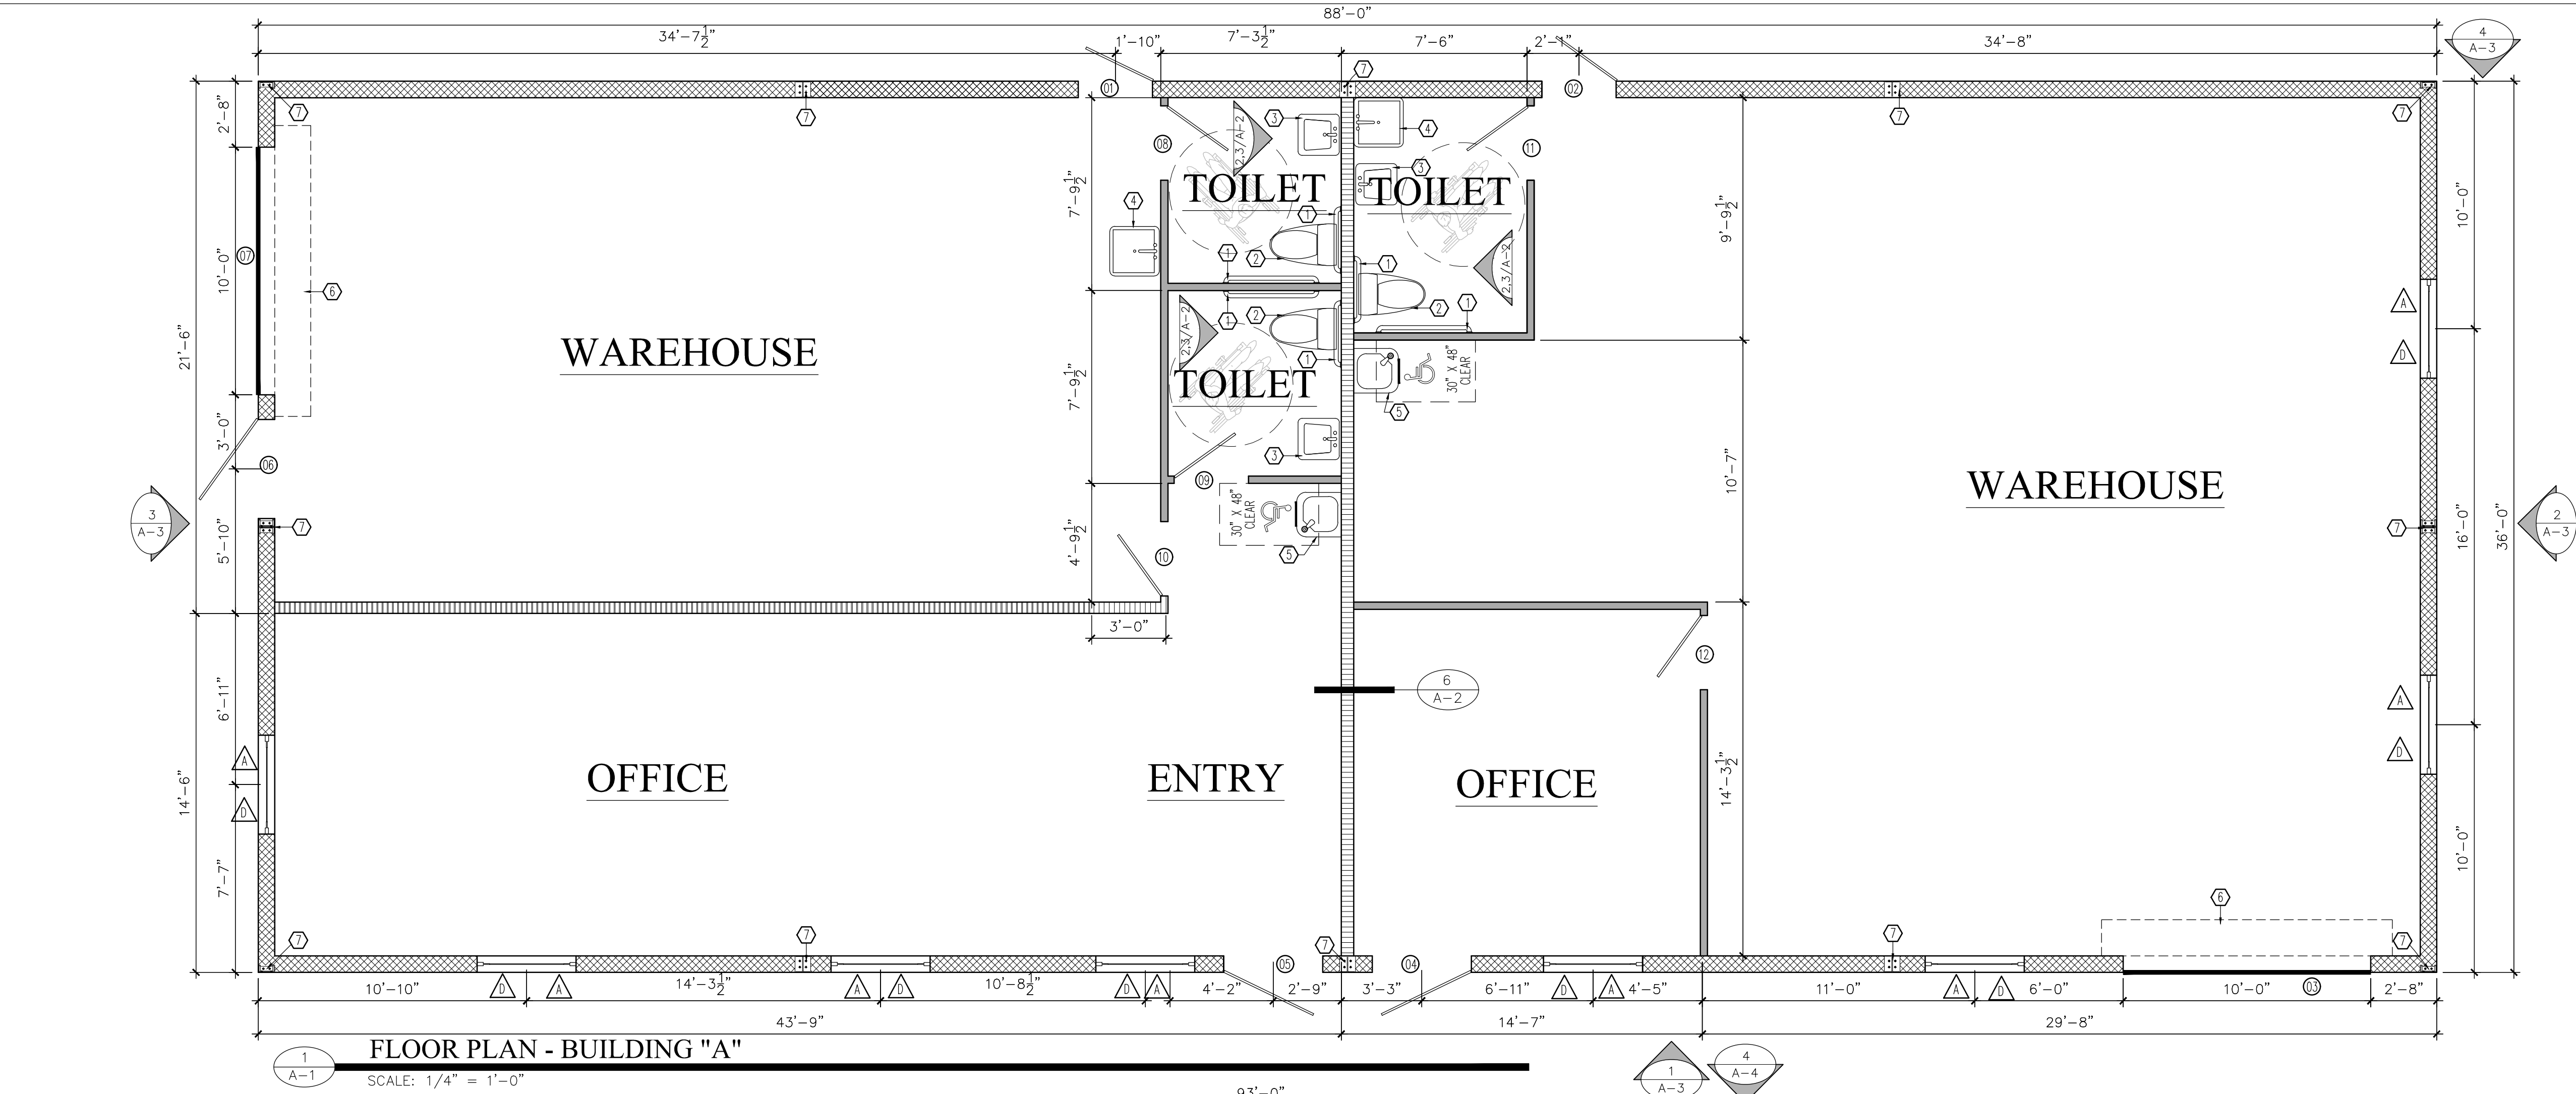

WALL LEGEND

- PRE-FABRICATED BUILDING BY MANUFACTURER.
- 6" STUDS
- 4" STUDS

KEYED NOTES

- A.D.I. GRAB BAR.
- A.D.A. TOILET.
- A.D.A. LAVATORY.
- MOP SINK.
- A.D.A. WATER FOUNTAIN.
- OVERHEAD CEILING DOOR
- PRE-FABRICATED, SEE APPROVED SET OF DRAWINGS PROVIDED BY METAL MANUFACTURING COMPANY.

GENERAL NOTES

- ALL WORK PERFORMED SHALL MEET ALL CODES (LOCAL, STATE OR FEDERAL) PREVAILING FOR SPECIFIC LOCATION, INCLUDING AMERICAN'S WITH DISABILITIES ACT 1990 (ADA 1990).
- ALL ELECTRICAL WORK TO BE PERFORMED IN ACCORDANCE WITH THE ELECTRICAL PLAN AND MUST MEET CURRENT NATIONAL ELECTRICAL CODE, STATE AND LOCAL CODES.
- ALL PLUMBING WORK TO BE PERFORMED TO MEET ALL PREVAILING CODES. PIPING SHALL BE SIZED TO PROVIDE ADEQUATE FLOWS FOR OPERATION OF VARIOUS SANITARY FACILITIES IN ACCORDANCE WITH MANUFACTURER'S SPECIFICATIONS.
- GENERAL CONTRACTOR TO SUPPLY HANDRAILS AS REQUIRED TO MEET OSHA STANDARDS AND ADA REQUIREMENTS.
- GENERAL CONTRACTOR TO SUPPLY EXITS AS REQUIRED BY OSHA WITH PROPER SIGNS, NIGHT LIGHTING AND EMERGENCY LIGHTING.
- THE CONTRACTOR SHALL VERIFY ACTUAL CONDITIONS PRIOR TO BEGINNING CONSTRUCTION. NOTIFY THE ARCHITECT IN WRITING OF ANY DISCREPANCIES BETWEEN DRAWINGS AND ACTUAL CONDITIONS BEFORE PROCEEDING WITH WORK.
- ALL NEW PARTITIONS SHALL ALIGN WITH EDGE OF COLUMNS, WINDOW MULLION CENTERLINE, OR EXISTING PARTITIONS, UNLESS NOTED OTHERWISE.
- ALL ANGLES SHOWN ARE 45° OR 90° UNLESS NOTED OTHERWISE.
- UNDER NO CIRCUMSTANCES SHALL ANY MEASUREMENT BE SCALED FROM THE DRAWINGS. DIMENSIONS NOT INDICATED SHALL BE CLARIFIED BY ARCHITECT PRIOR TO PROCEEDING WITH WORK.
- INSTALL ALL MANUFACTURED ITEMS, MATERIALS, AND EQUIPMENT IN STRICT ACCORDANCE WITH THE MANUFACTURER'S RECOMMENDED SPECIFICATIONS.

REVISIONS	BY:

\\Server\DWG\NAVA-TECH INC LOGO.JPG

1615 S. Solano Dr.
Las Cruces, NM 88001
Office: (505) 341-5060
Fax: (505) 322-6060
Email: csn@nava-tech.com

FLOOR PLAN BUILDING "A" AND "B"

COMMERCIAL BUILDINGS
FOR ALLIED SECURITY
2201 N. MESQUITE STREET

DRAWING BY:
NAVA-TECH
DATE:
01/02/08
SCALE:
AS NOTED
SHEET NO.

A-1