
 



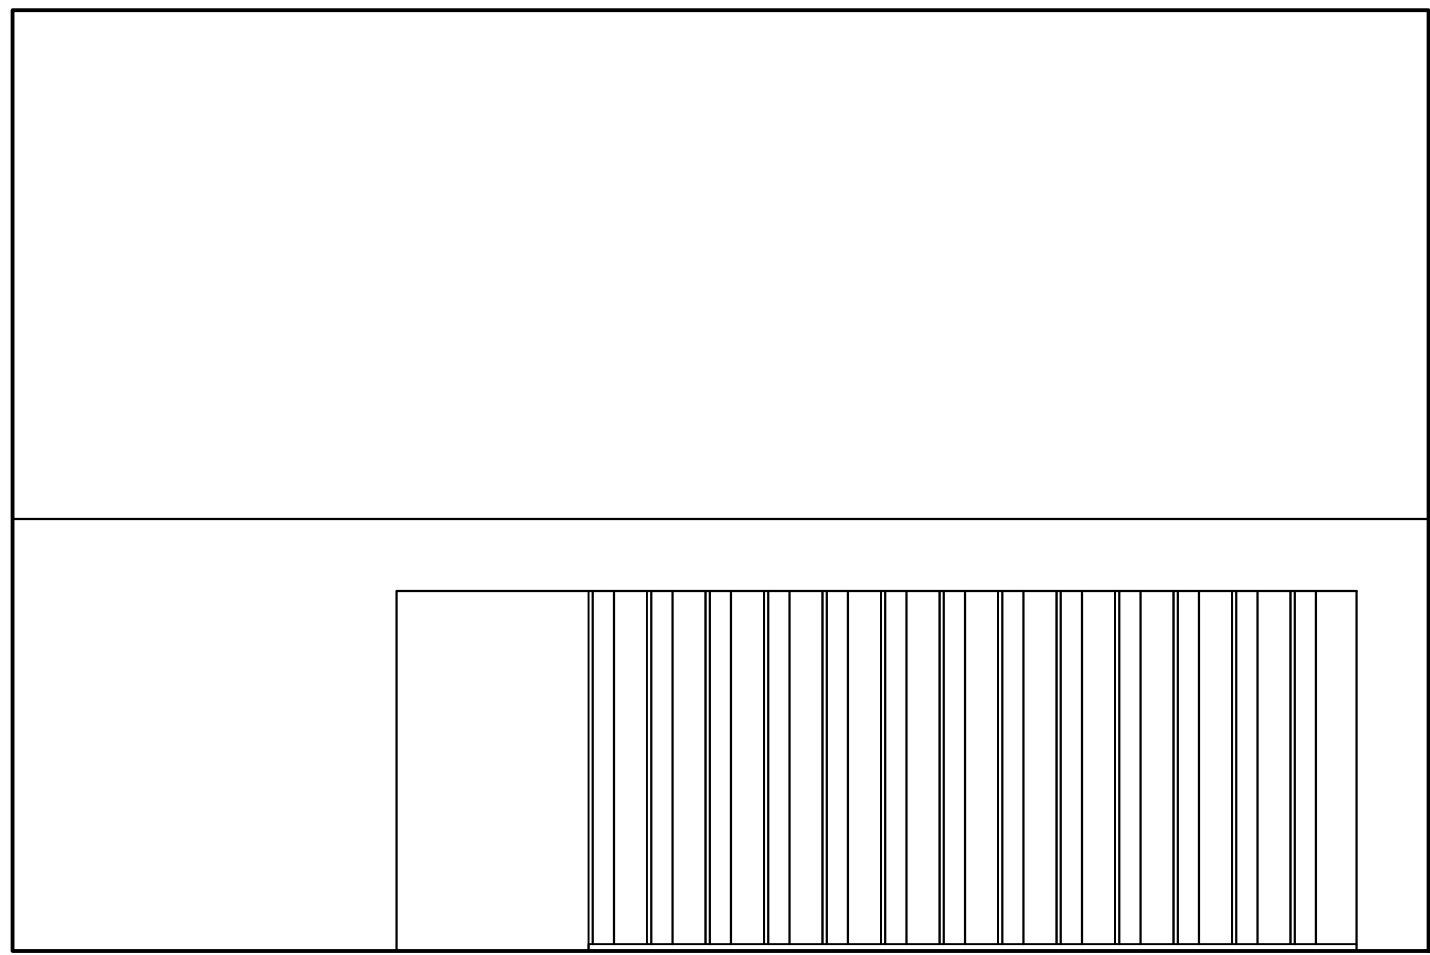


1 INTERIOR ELEVATION
SCALE: 1/4" = 1'-0"




2 INTERIOR ELEVATION
SCALE: 1/4" = 1'-0"

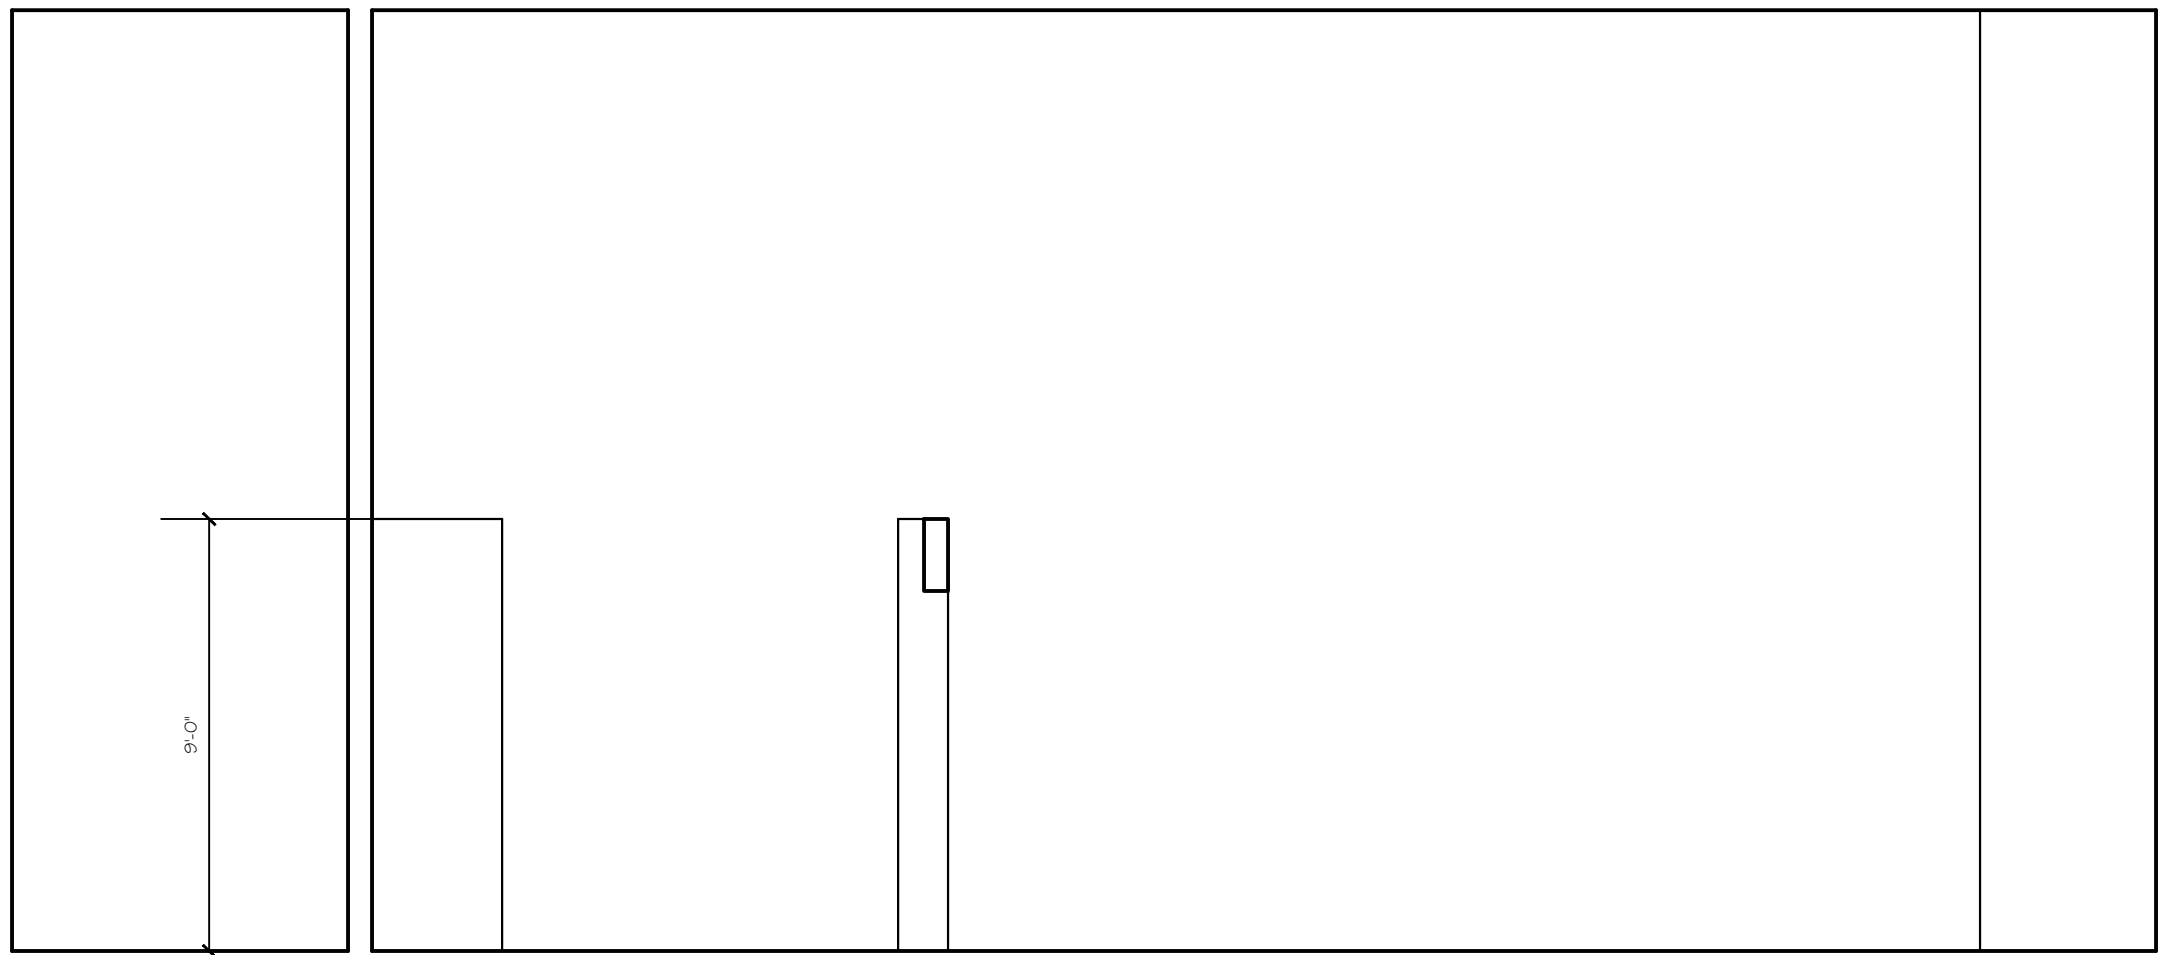


3 INTERIOR ELEVATION
SCALE: 1/4" = 1'-0"

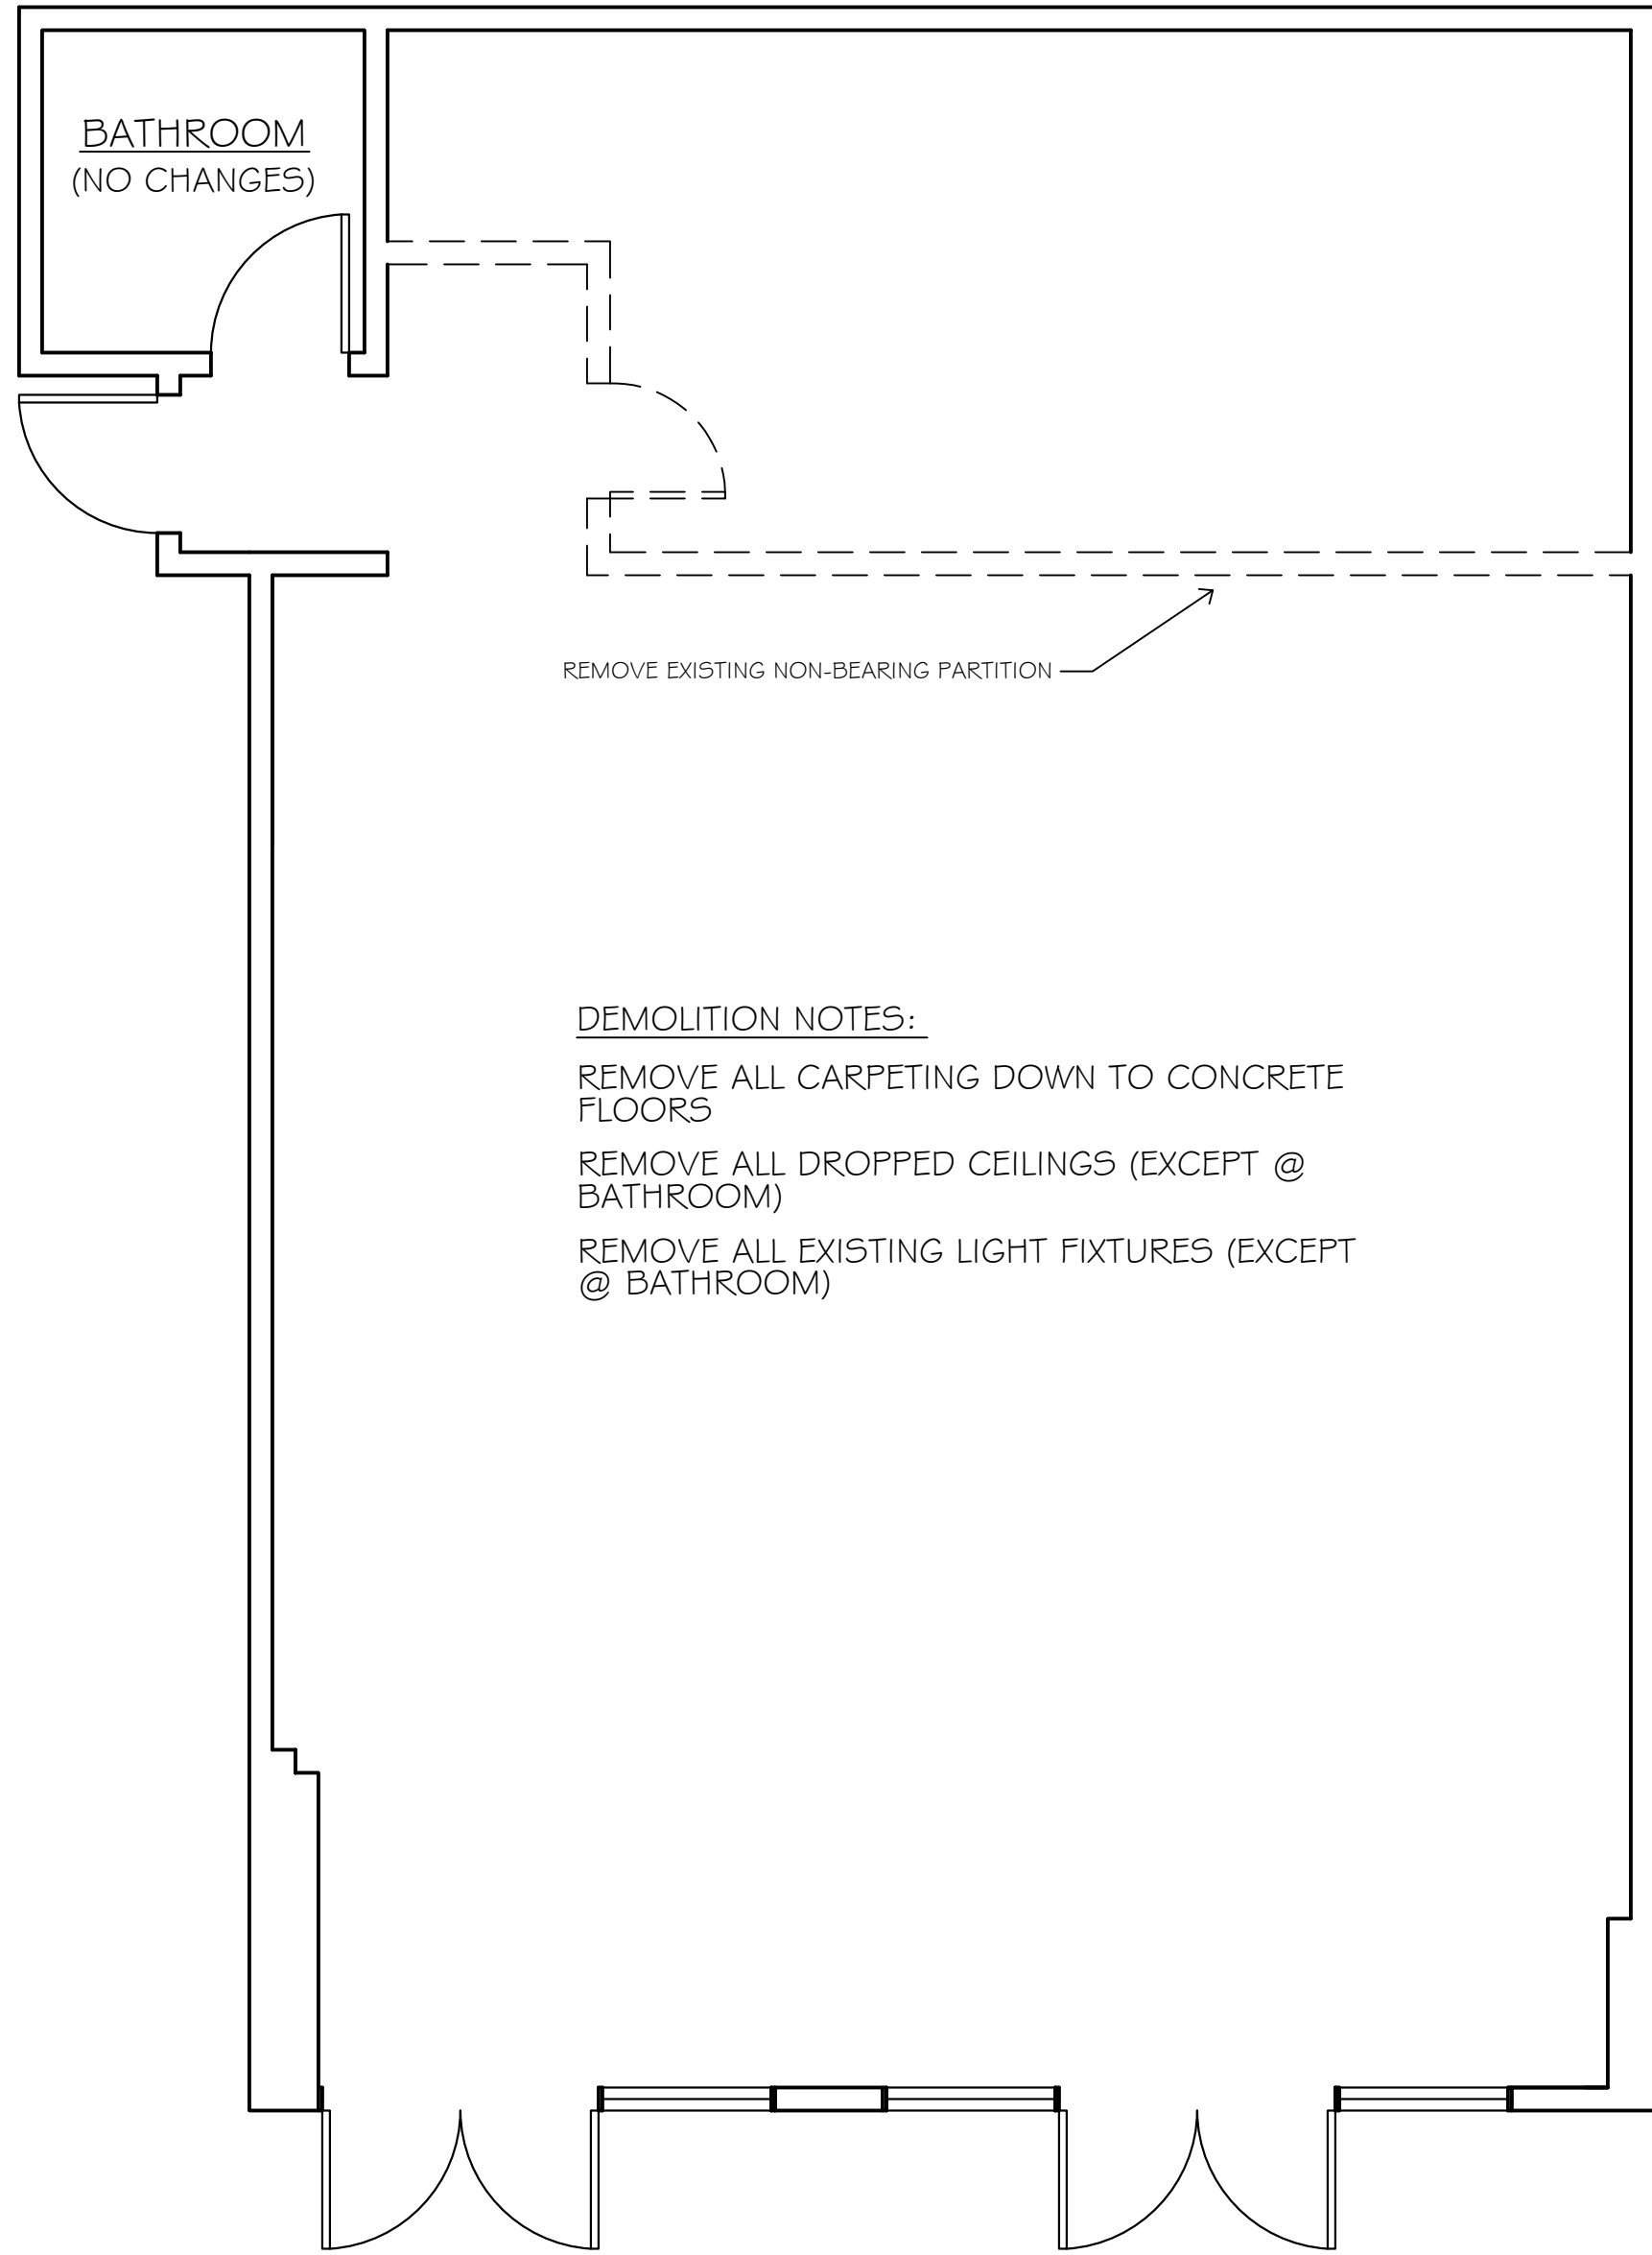

EXISTING FLOOR PLAN
SCALE: 1/4" = 1'-0"

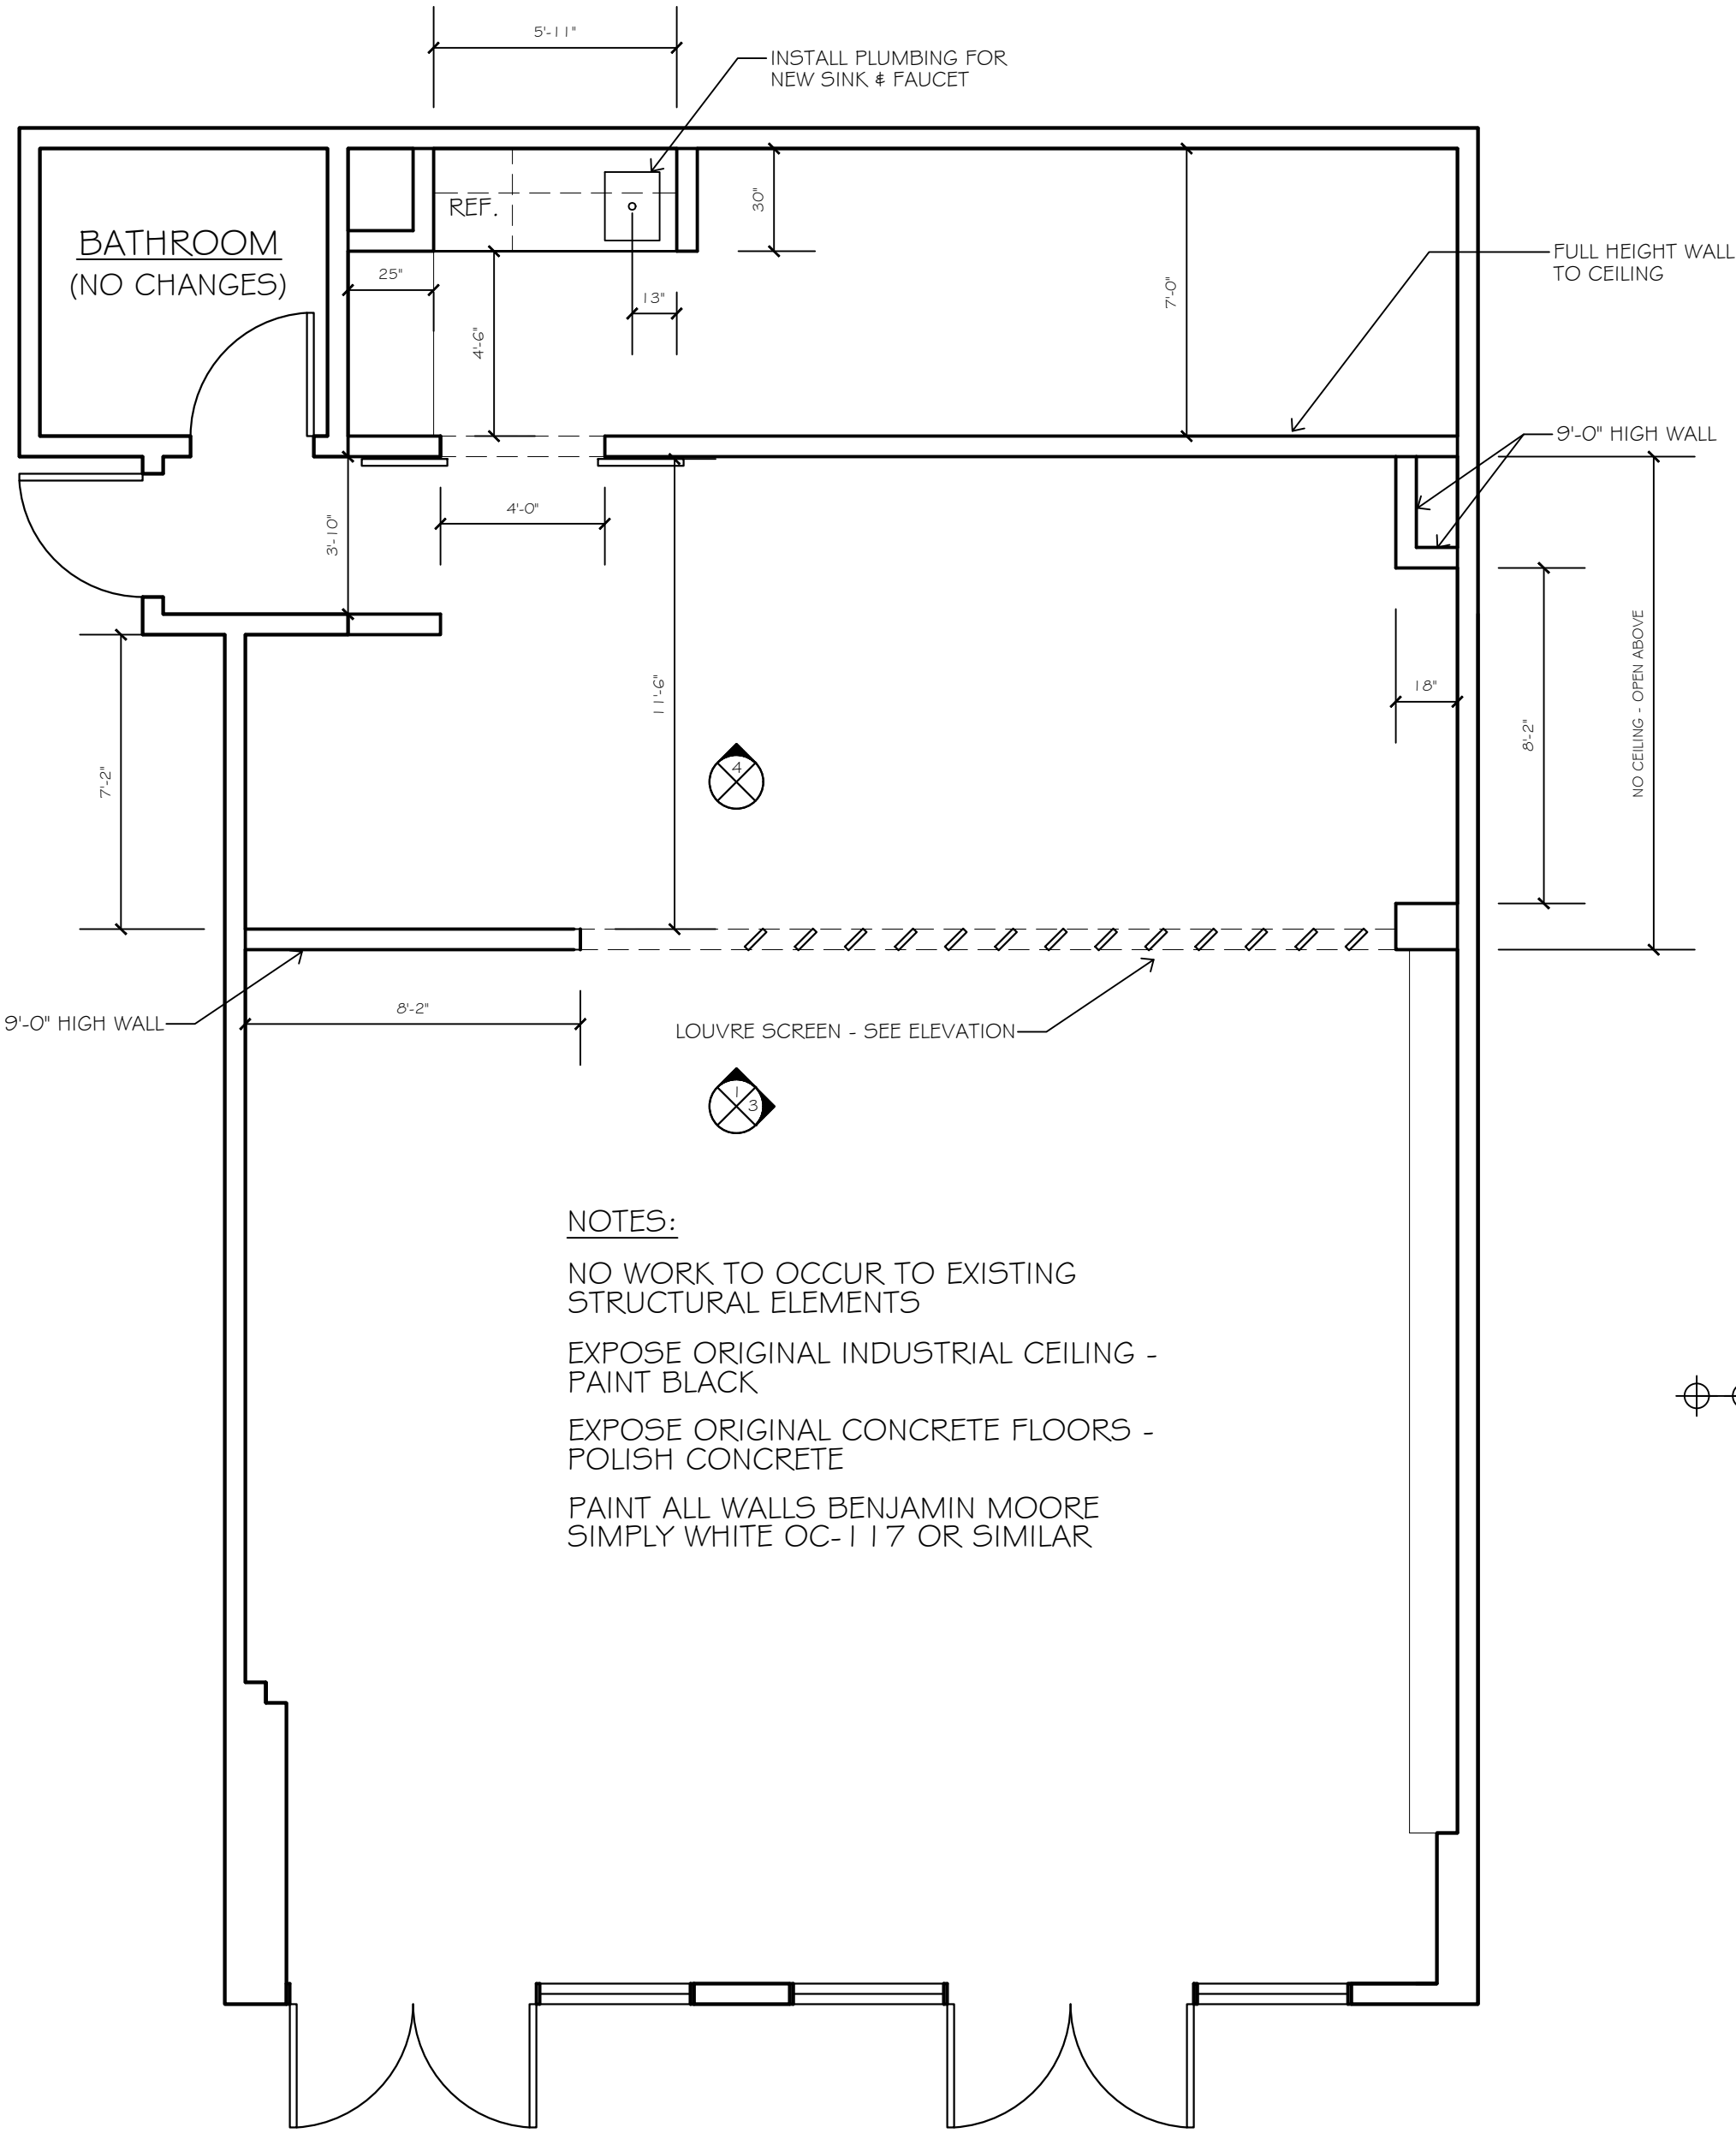

PROPOSED FLOOR PLAN
SCALE: 1/4" = 1'-0"

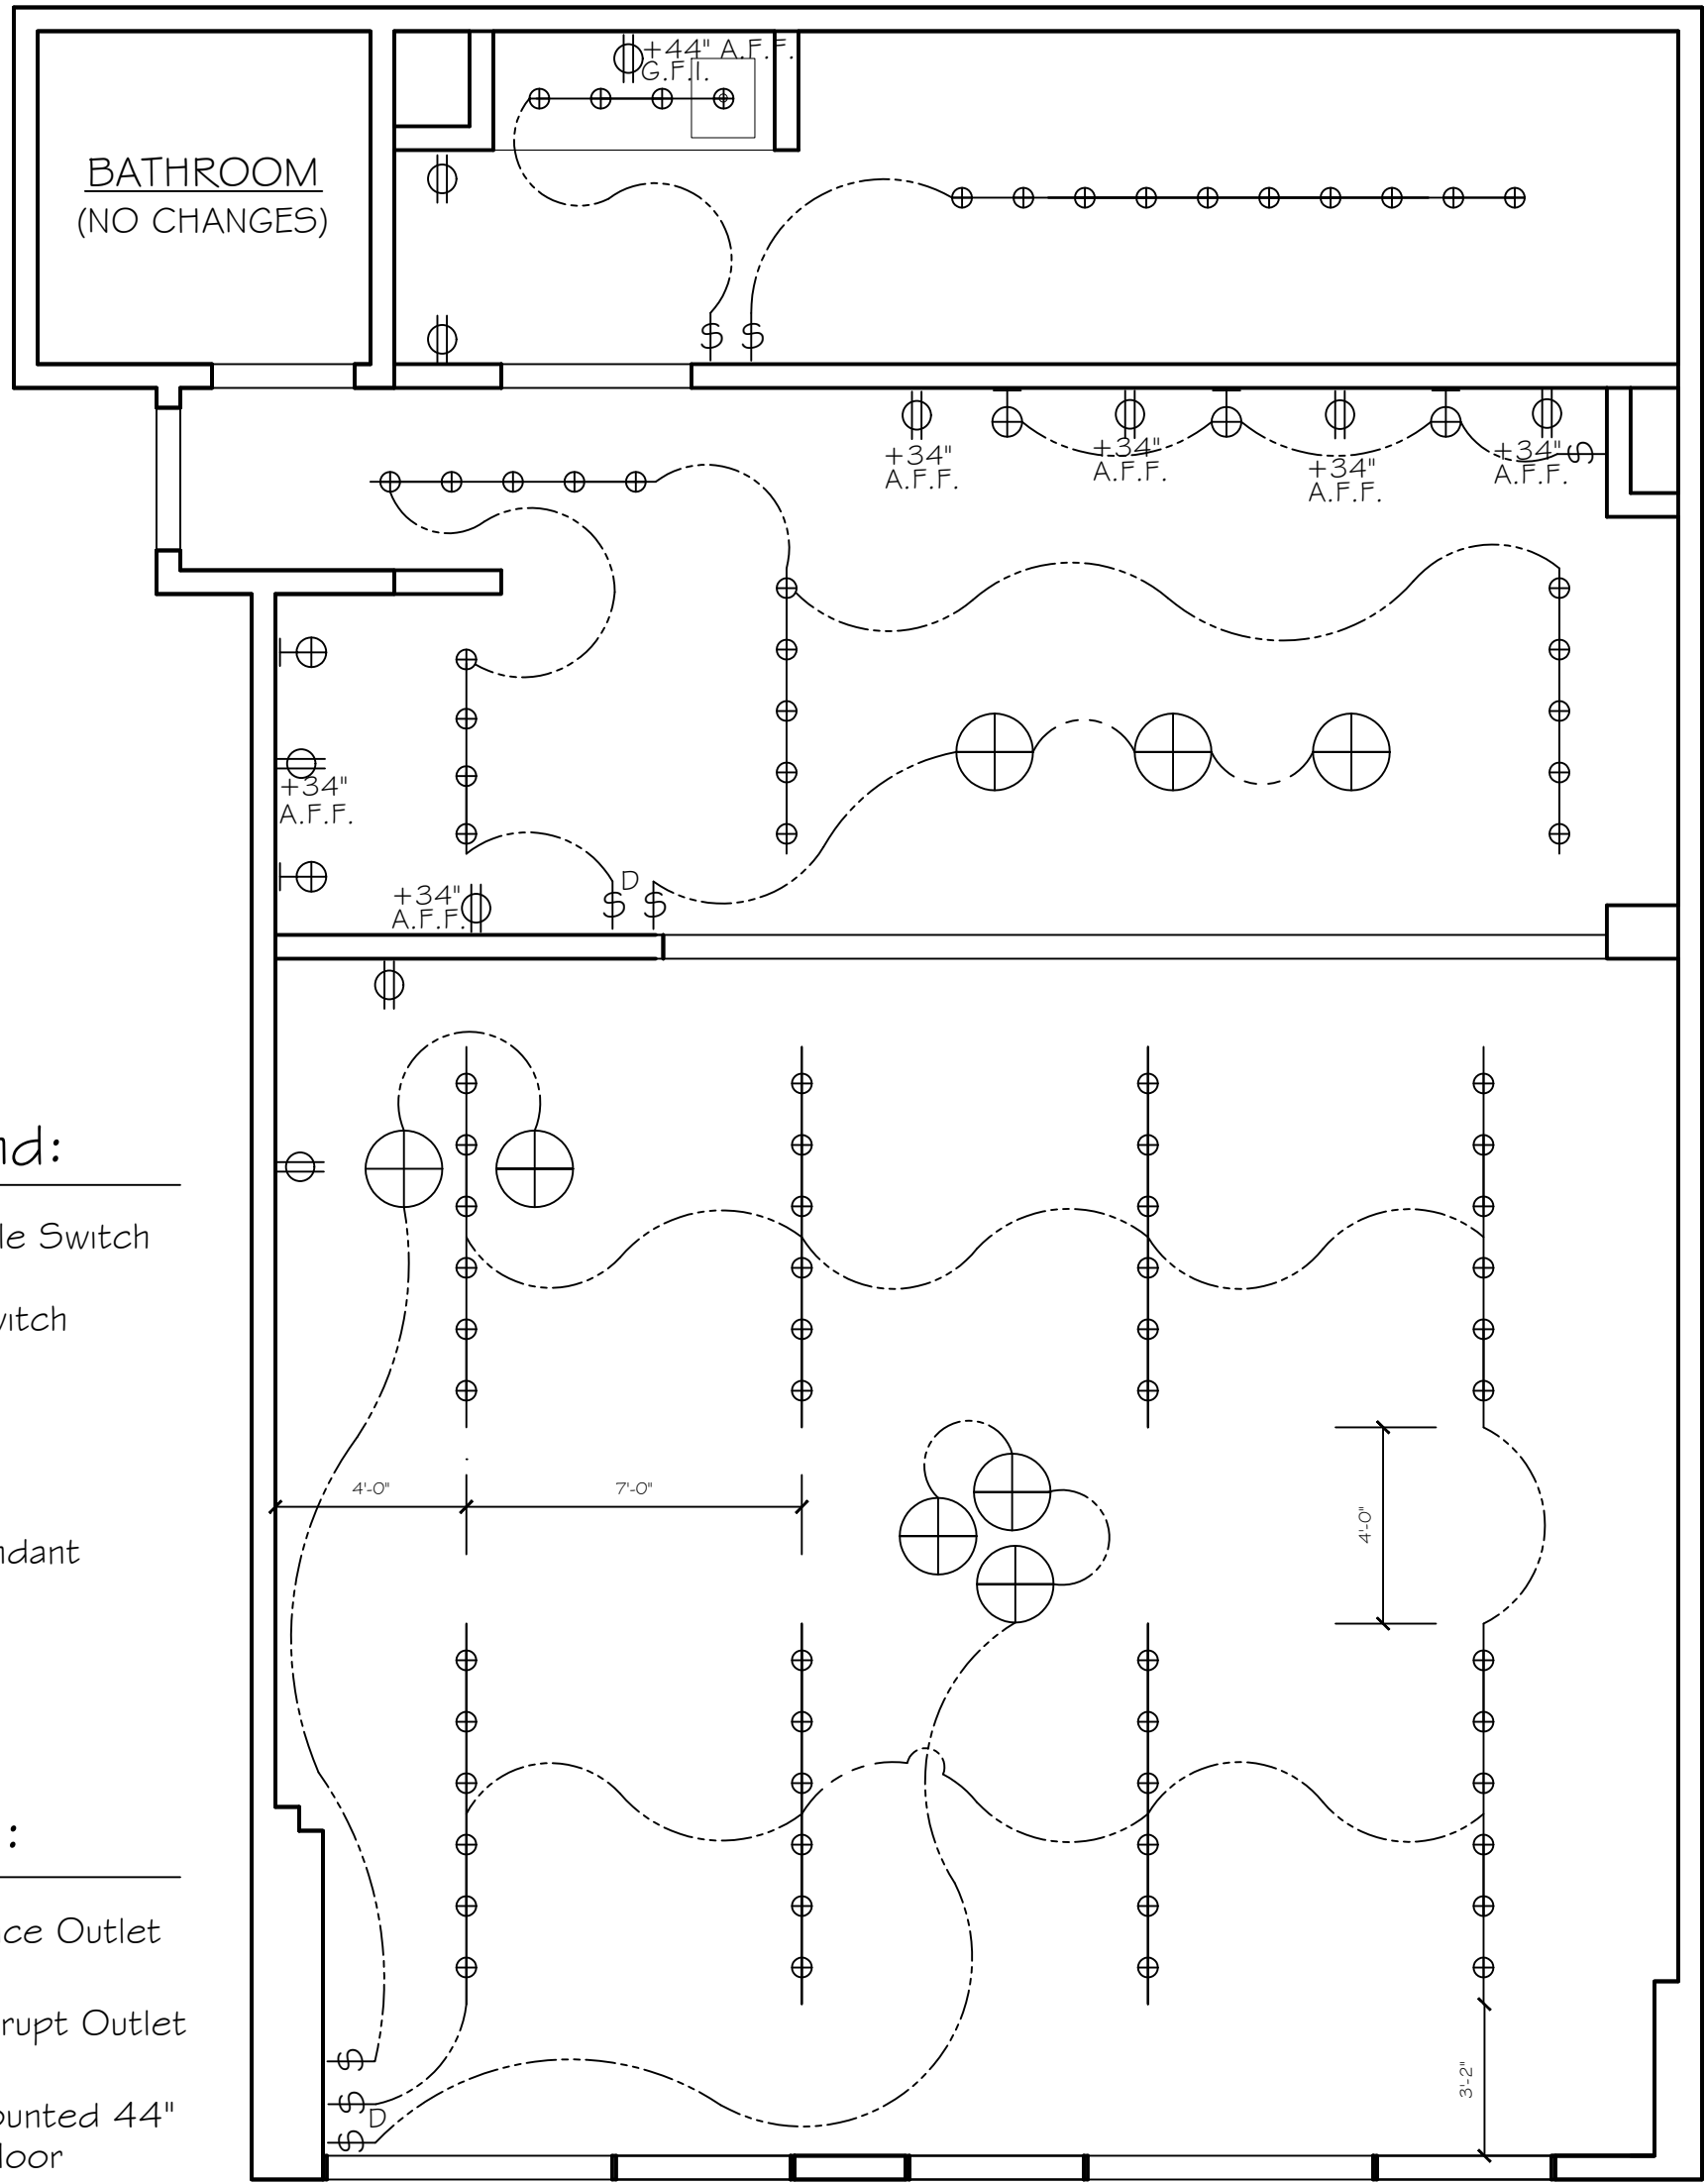

LIGHTING PLAN
SCALE: 1/4" = 1'-0"

- Lighting Legend:
- Single Pole Toggle Switch
 - 3-Way Toggle Switch
 - Dimmer Switch
 - Track Lighting
 - Incandescent Pendant
 - Sconce

- Power Legend:
- Duplex Convenience Outlet
 - G.F.I Ground Fault Interrupt Outlet
 - Duplex Outlet Mounted 44" Above Finished Floor

ARCHITECT:

ELEC,ENGINEER:

DESIGN:

**BUILT
DE
SIGN**

BUILT DESIGN COLLECTIVE OFFICE + SHOP
TENANT IMPROVEMENT MODIFICATIONS
500 MARKET STREET, SUITE 109 , SANTA FE, NM 87501

DATE:

JAN 23, 2020

REVISIONS: DATE:

1 OF 1