


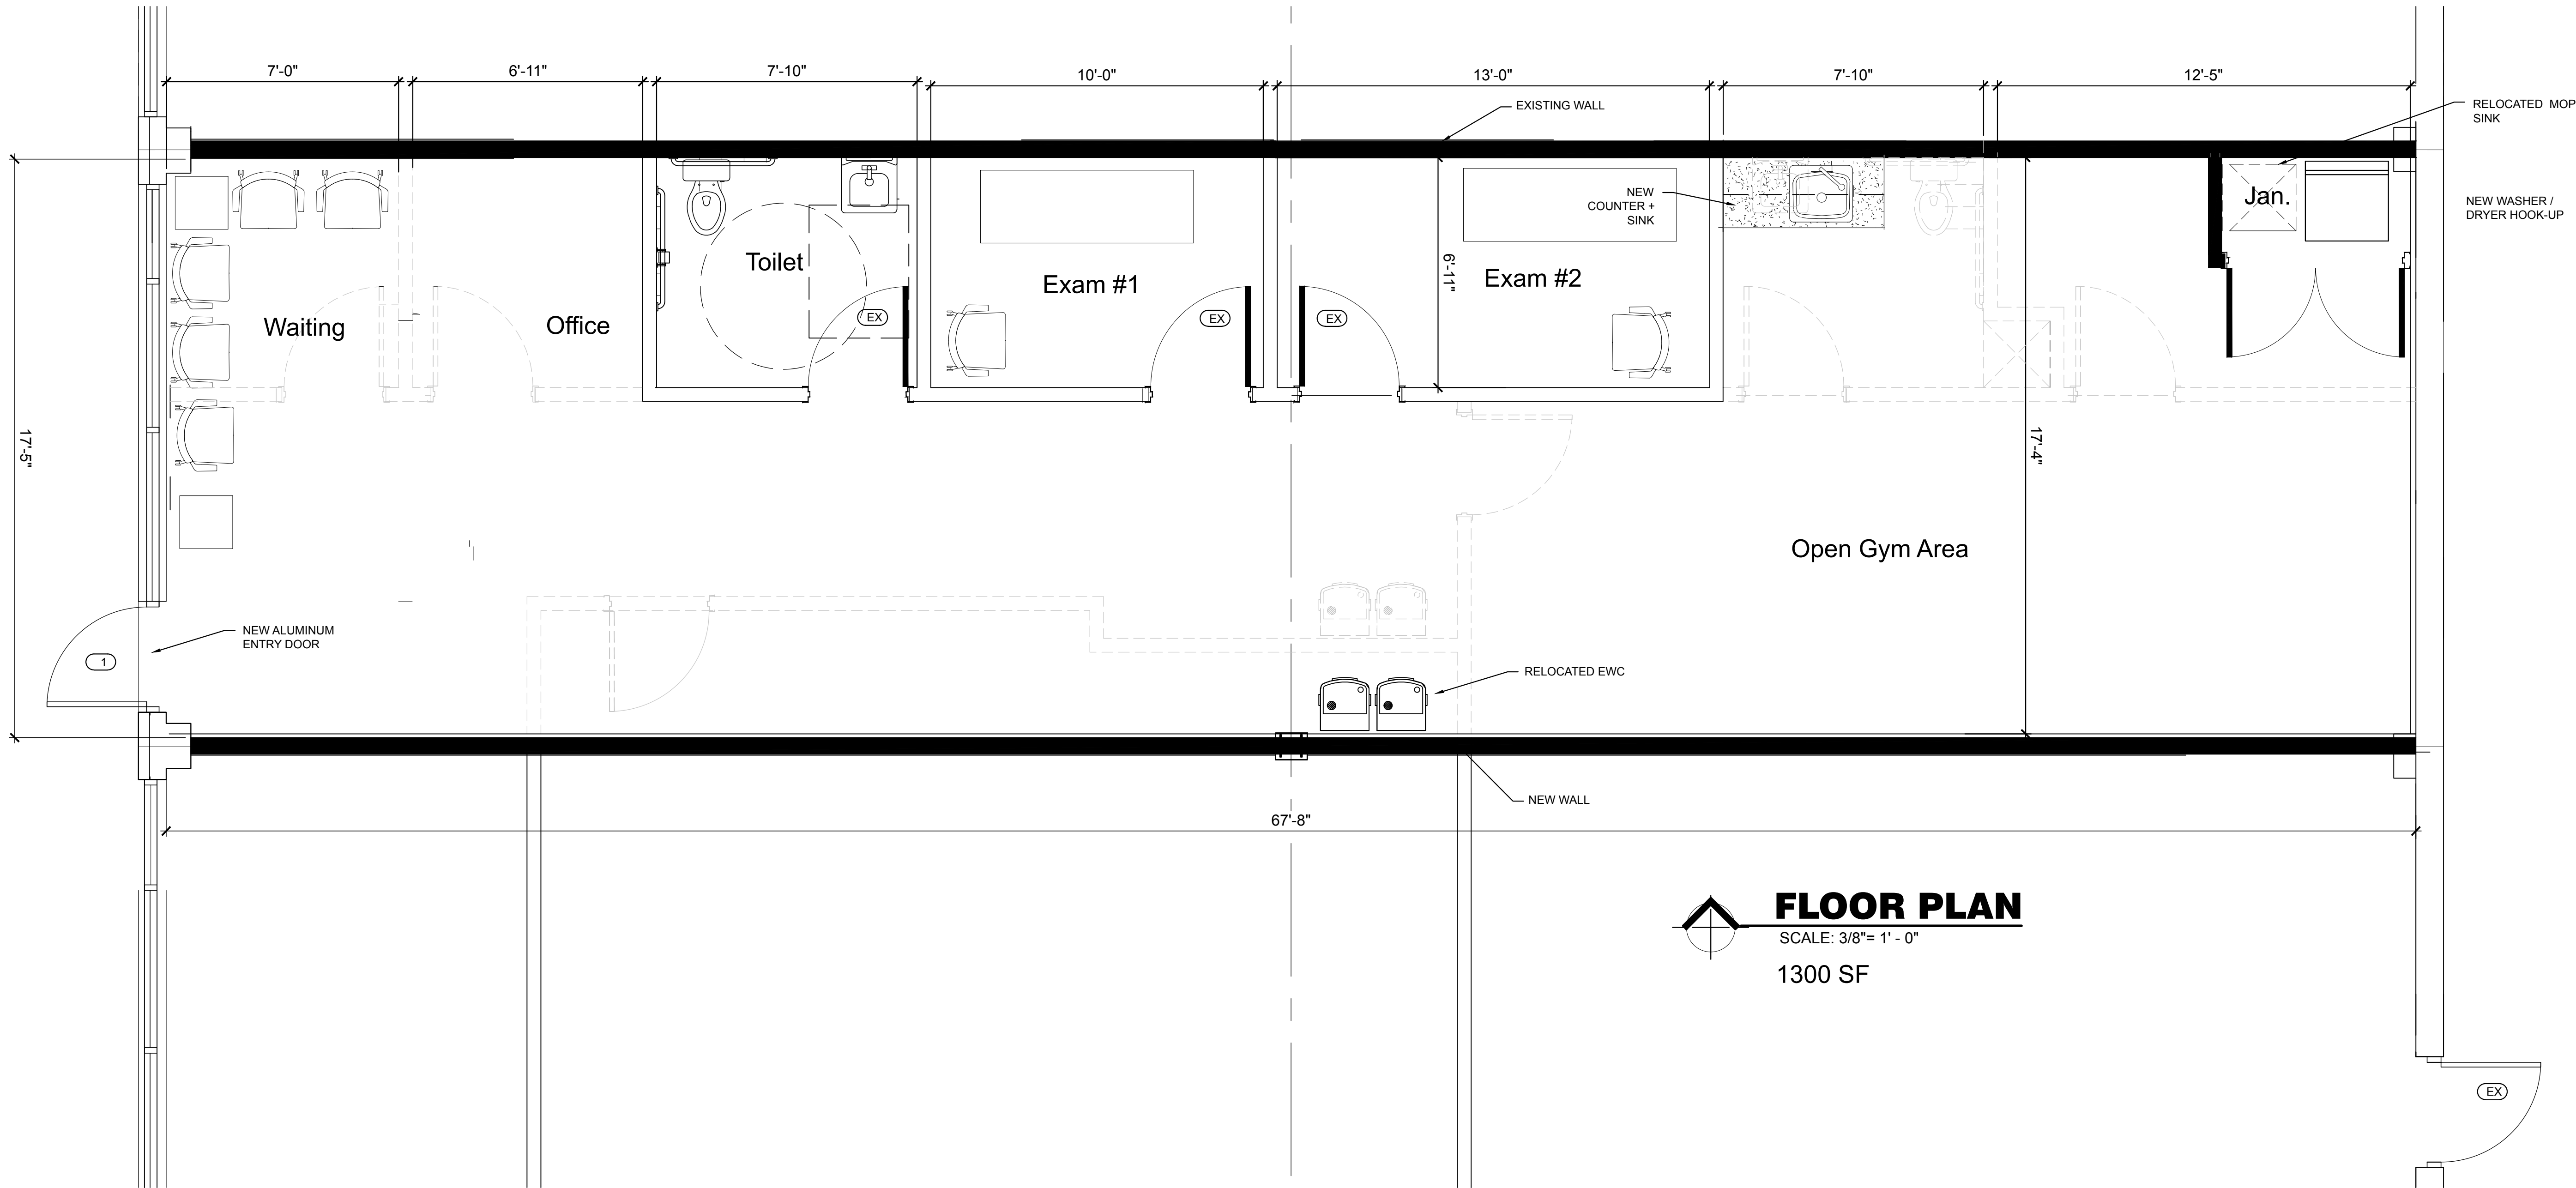

FLOOR PLAN
SCALE: 3/8"= 1' - 0"
1300 SF

PROVIDE ADDITIONAL
EMERGENCY LIGHTING AS
REQUIRED

VERIFY ALL CONDITIONS &
DIMENSIONS IN THE FIELD

DEXTER COMERCE CENTER
PHYSICAL THERAPY
INTERIOR SUITE RENOVATION SUITE #4B
D e x t e r , M i c h i g a n

C O N T A C T

REVISION	7-21-2017
REVISION	6-17-2017
REVISION	6-13-2017
PRICING	5-15-2017

FLOOR PLAN

1
PROJECT NUMBER:
500 - 2017