



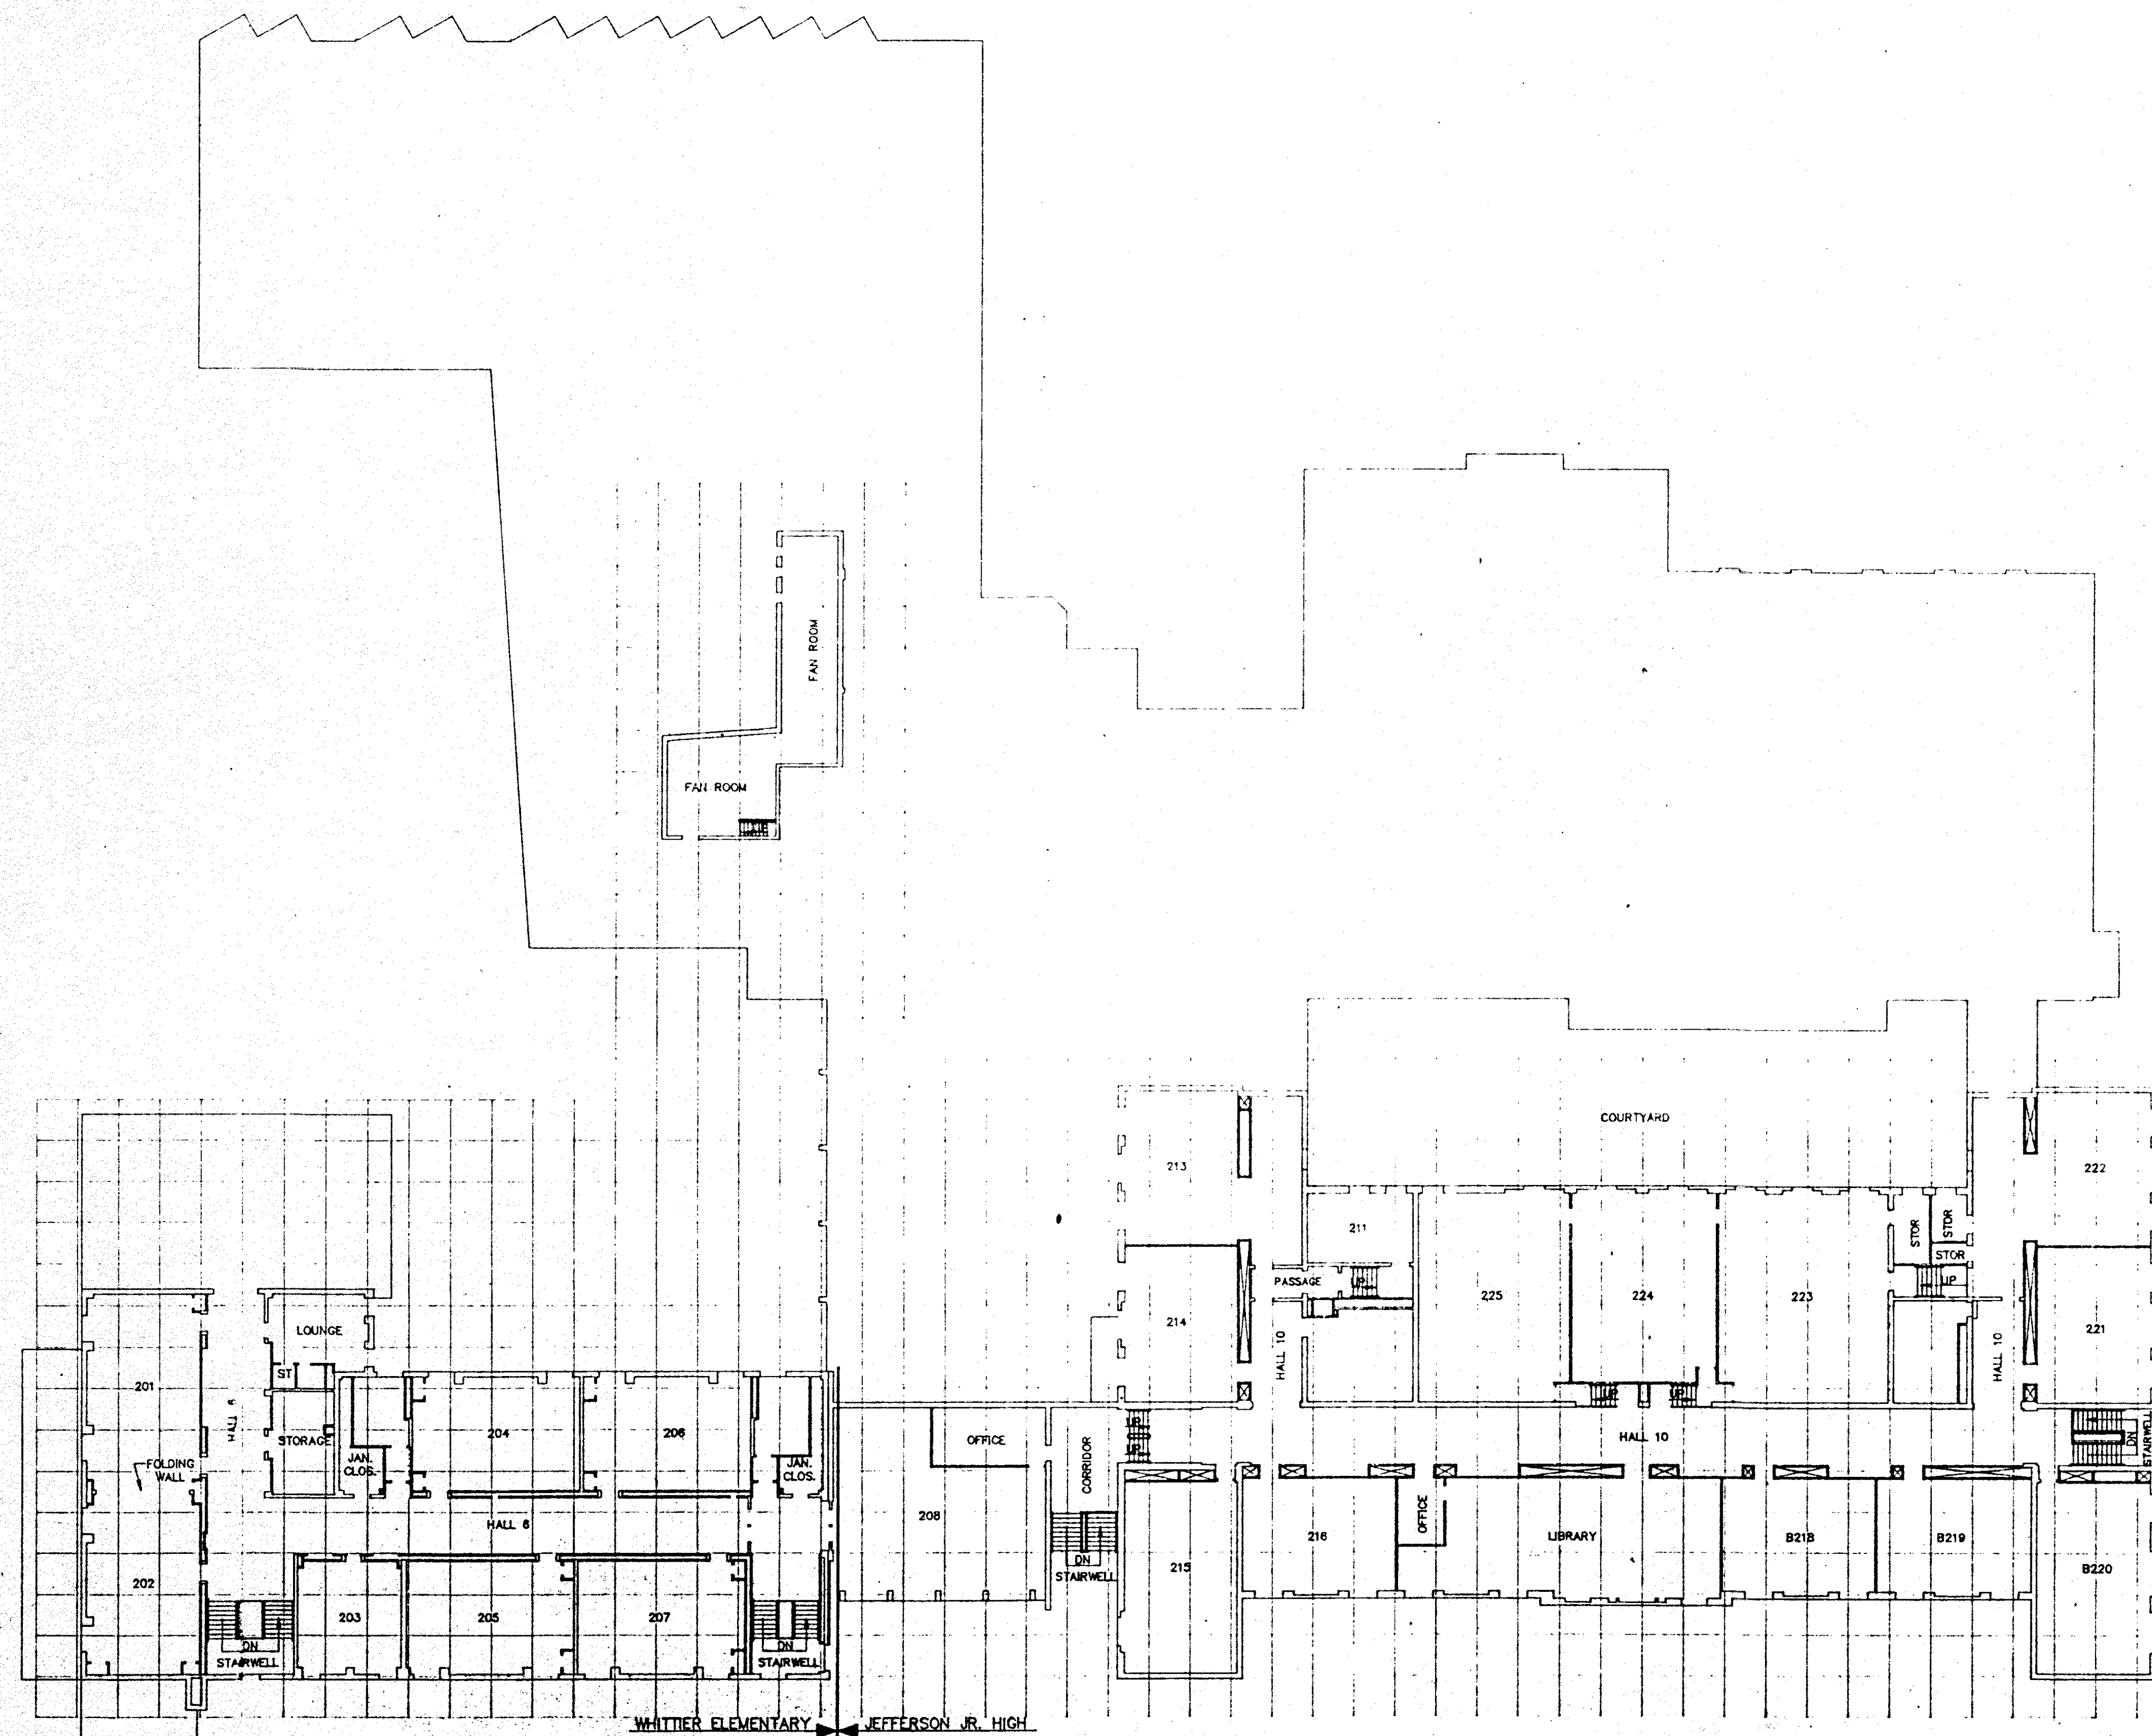

SECOND FLOOR PLAN

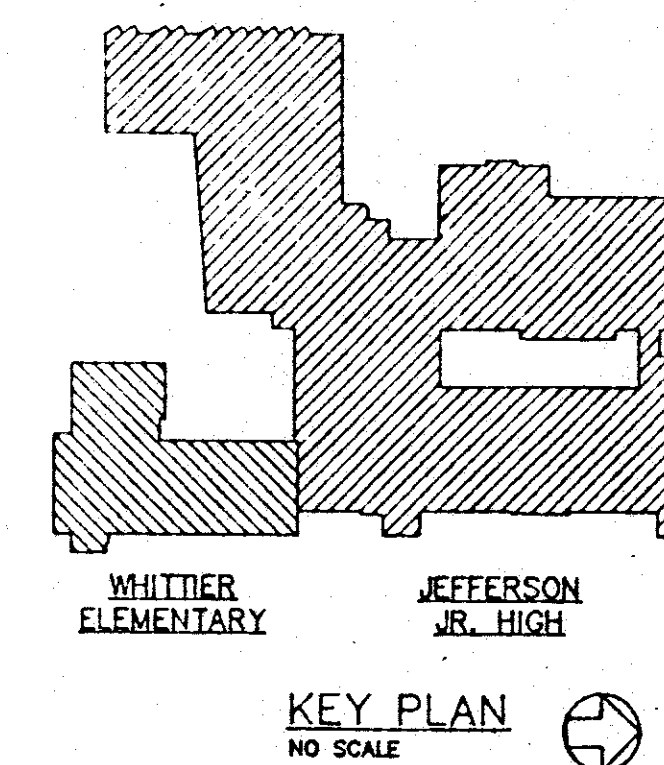

VIRON CORPORATION 210 NW PLATTE VALLEY DR. RIVERVIEW, MD. 21150		ENERGY MANAGEMENT SERVICES DRAWN BY: DATE: SDS: 7/92 CHECKED BY: DATE: E
SCHOOL DIST. CITY OF PONTIAC PONTIAC, MICHIGAN WHITTIER & JEFFERSON SCHOOLS EMS FLOOR PLAN		