

1. COORDINATE SITE PLAN WITH CIVIL PLANS DRAWN BY MILLER-WHERRY, LANDSCAPE ARCHITECTS, ENGINEERS, SURVEYORS AND PLANNERS.
2. COORDINATE LOCATION OF ALL UTILITIES, POLES, BOLLARDS, ETC. WITH MECHANICAL, ELECTRICAL AND PLUMBING DRAWINGS.
3. ARCHITECTURAL FINISHED FLOOR 100'-0" = 443.50'
4. COORDINATE SIDEWALKS, DRIVES, AND PLANTINGS WITH LANDSCAPE PLAN ON SHEET SW-3.


[illegible]

FIRE HYDRANT PLAN APPROVAL

Maximum distance from hydrant

Conditioned pon installation by owner or developer of all fire hydrants and/or height and location requirements shown hereon and in accordance with Jefferson County Fire Hydrant Ordinance. All revisions must be resubmitted.

APPROVED BY: *W. B. Wright*
W. B. Wright
HYDRANT TYPE: Two (2) 4" outlets
Standard
Threads are required

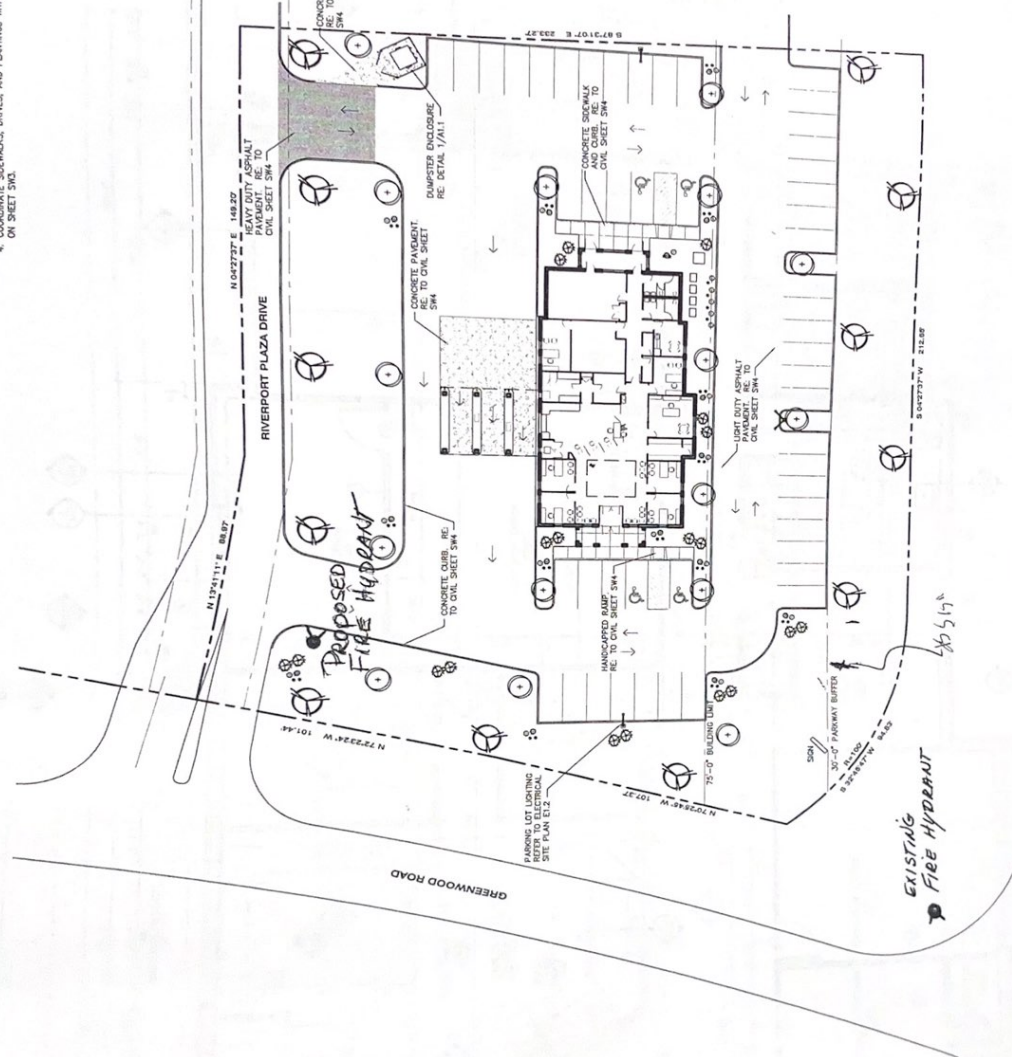

Site Plan
SCALE - 1" = 20'-0"

THIS DRAWING IS PLOTTED
AT HALF THE NOTED SCALE

A1-1
SHEET NUMBER

ONE PAGE

Construction Documents
for
Members First Federal
Credit Union
P. THREE OTHER

Shaun A. Anderson
1010 Mainwale St.
Newport, Kentucky 41071
Architect

[illegible]

