


RE: TO SHEETS A1.1 - A1.3 FOR ENLARGED PLANS

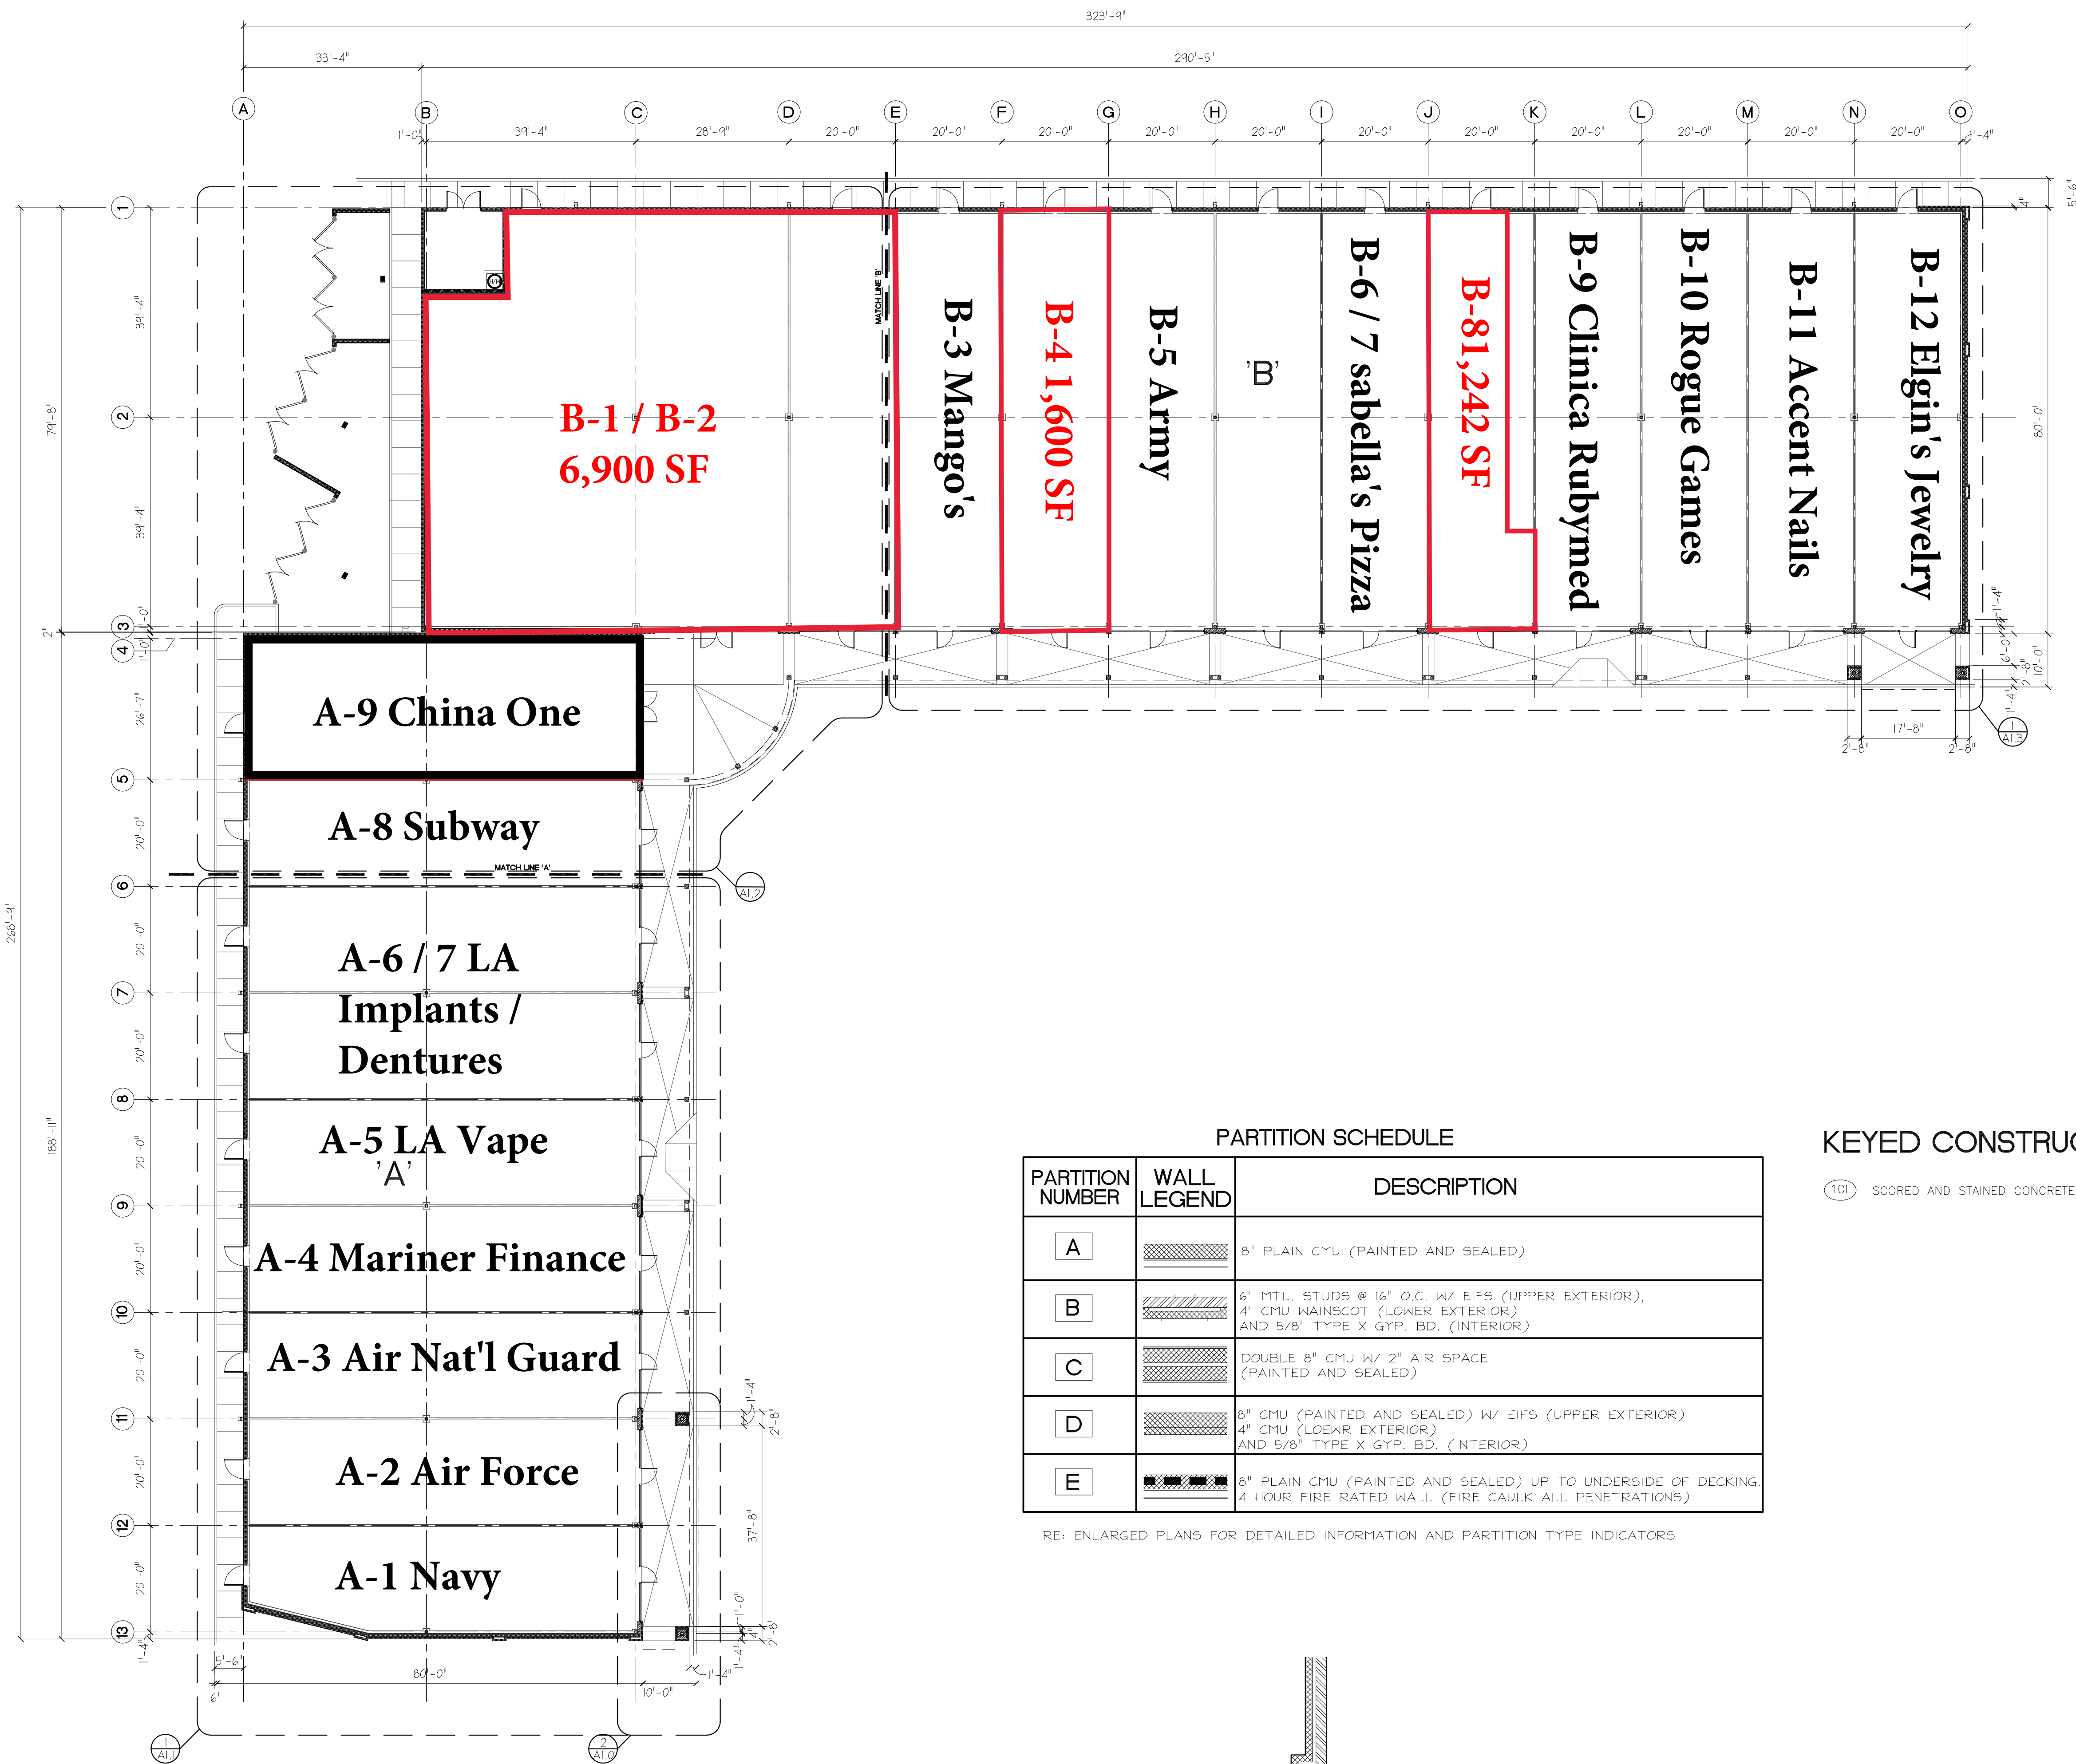

PARTITION SCHEDULE		
PARTITION NUMBER	WALL LEGEND	DESCRIPTION
A		8" PLAIN CMU (PAINTED AND SEALED)
B		6" MTL. STUDS @ 16" O.C. W/ EIFS (UPPER EXTERIOR), 4" CMU WAINSCOT (LOWER EXTERIOR) AND 5/8" TYPE X GYP. BD. (INTERIOR)
C		DOUBLE 8" CMU W/ 2" AIR SPACE (PAINTED AND SEALED)
D		8" CMU (PAINTED AND SEALED) W/ EIFS (UPPER EXTERIOR) 4" CMU (LOEWR EXTERIOR) AND 5/8" TYPE X GYP. BD. (INTERIOR)
E		8" PLAIN CMU (PAINTED AND SEALED) UP TO UNDERSIDE OF DECKING, 4 HOUR FIRE RATED WALL (FIRE CAULK ALL PENETRATIONS)


RE: ENLARGED PLANS FOR DETAILED INFORMATION AND PARTITION TYPE INDICATORS

KEYED CONSTRUCTION NOTES

(10) SCORED AND STAINED CONCRETE SIDEWALK, SEE FINISH SPECS (SHT. A7.0).

STAINED CONCRETE INSTRUCTIONS & SPECIFICATIONS:

- CONCRETE TO BE STAINED SHALL BE MADE SLIP RESISTANT BY LIGHTLY SANDBLASTING OR ACID WASHING.
 - SCORE FLOOR IN PATTERN SHOWN WITH APPROPRIATE CUTTING TOOL APPROXIMATELY 1/8" WIDE X 1/8" DEEP.
 - STAIN FLOOR IN COLORS SHOWN ON PLAN (SEE SHEET A7.0 FOR COLOR DESIGNATIONS) AND SEAL WITH CLEAR SEALER. FLOOR SURFACE SHALL HAVE A SLIP RESISTANCE GREATER THAN OR EQUAL TO THAT REQUIRED BY A.D.A. SUPPLY GRIT FINISH AS NECESSARY IN ACCORDANCE W/ MFR. RECOMMENDED APPLICATION.
- ALL CONCRETE SURFACES DESIGNATED IN THE PLANS AND SPECIFICATIONS AS BEING CHEMICALLY STAINED SHALL RECEIVE TWO APPLICATIONS OF LITHOCHROME CHEMSTAIN IN COLORS DESIGNATED ON THE PLANS AFTER THE CONCRETE HAS CURED A MINIMUM OF 14 DAYS. THE SURFACE SHALL BE PREPARED AND LITHOCHROME CHEMSTAIN SHALL BE APPLIED IN ACCORDANCE WITH THE SCOFIELD TECH-DATA BULLETIN A-414 USING THE RECOMMENDED MINIMUM COVERAGE RATE. ALL CHEMICALLY STAINED SURFACES SHALL BE SEALED WITH TWO COATS OF CEMENTONE CLEAR SEALER IN ACCORDANCE WITH THE SCOFIELD TECH-DATA BULLETIN A-764. CEMENTONE CLEAR SEALER SHALL BE APPLIED FULL STRENGTH. SEALER SHALL HAVE HIGH GLOSS FINISH.
- ALL PRODUCTS SHALL BE MANUFACTURED BY L.M. SCOFIELD COMPANY.

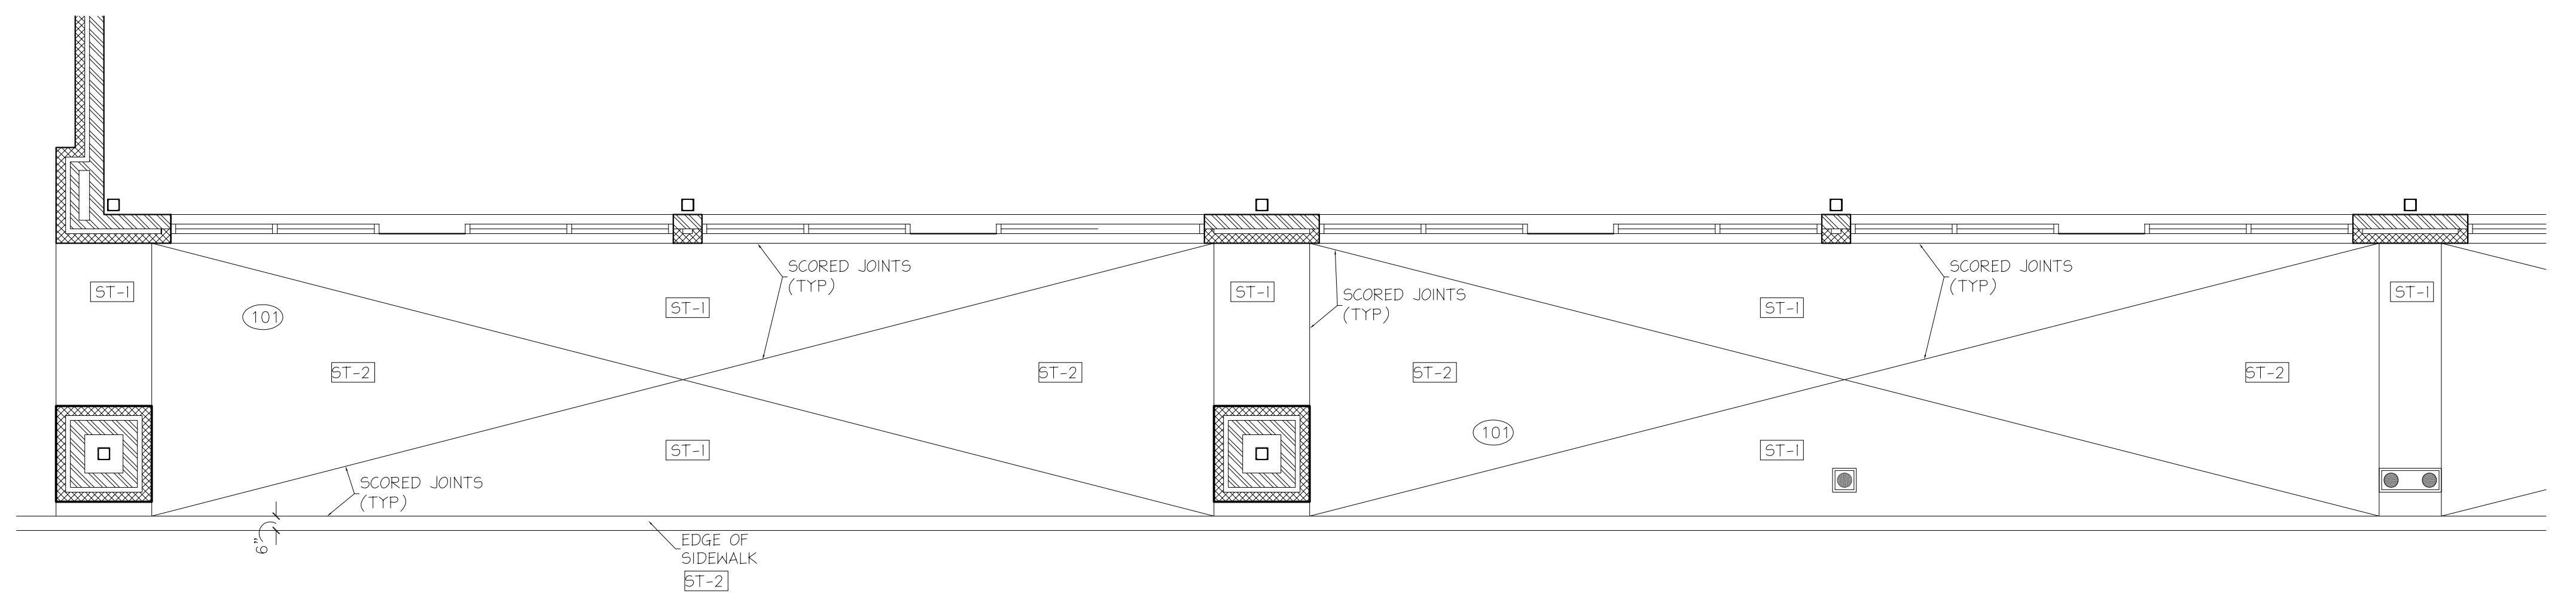

GENERAL DIMENSIONING NOTES:
-OVERALL EXTERIOR DIMENSIONS ARE TO OUTSIDE OF SHEATHING.
-DETAILED EXTERIOR DIMENSIONS ARE TO E.I.F.S. FEATURES.
-INTERIOR DIMENSIONS ARE TO FACE OF WALL UNLESS OTHERWISE NOTED.
-CONTRACTOR TO COORDINATE CRITICAL DIMENSIONS OF PLUMBING FIXTURES, MECHANICAL EQUIPMENT, ELEVATOR AND ANY OTHER APPLICABLE EQUIPMENT THAT REQUIRES EXACT CLEARANCES.

1 DIMENSIONED FLOOR PLAN
A1.0 SCALE: 1/16" = 1'-0"

2 TYPICAL SIDEWALK PLAN
A1.0 SCALE: 1/4" = 1'-0"

Drawings and specifications are instruments of service and shall remain the property of the architect. No part of this drawing shall be reproduced or used for any other project or reference in this project except by agreement in writing and with appropriate compensation to the architect.

MOUTON+LONG
ARCHITECTS
An Architectural Corporation
504-838-8091
601 Poydras Ave. Suite 200, Metairie, LA 70005

BLUEBONNET SQUARE
AT BLUEBONNET BLVD + AIRLINE HWY.
BATON ROUGE, LA

03/06/08 07-758
DATE PROJECT NO.
A1.0

REVISIONS