

REVISIONS	BY

J. B. Easterly III
Designer
 Easterly Drafting Inc.
 (225) 665-0290 ext.
 (225) 665-0299 fax
 jeasterly3@aol.com


LANGLOIS ENGINEERING, INC.
 GERARD W. LANGLOIS, P.E.
 11328 PENNYWOOD AVENUE
 BATON ROUGE, LOUISIANA 70809
 PH 225-293-8730 FAXER 225-377-1453

KELLY TAN
 PROPERTIES
 14 HWY #10
 LIVINGSTON PARISH

DRAWN	
CHECKED	
DATE	04 DEC 14
SCALE	AS SHOWN
JOB NO.	
SHEET	9
OF 9	SHEETS

ELECTRICAL LEGEND


- A - 0 RECESSED CAN FLUORESCENT 100 W. EXTERIOR
- B - 10 SURFACE MTD. FLUORESCENT 100 W. EXTERIOR
- C - 11 WALL PACK FLUORESCENT 150 W.

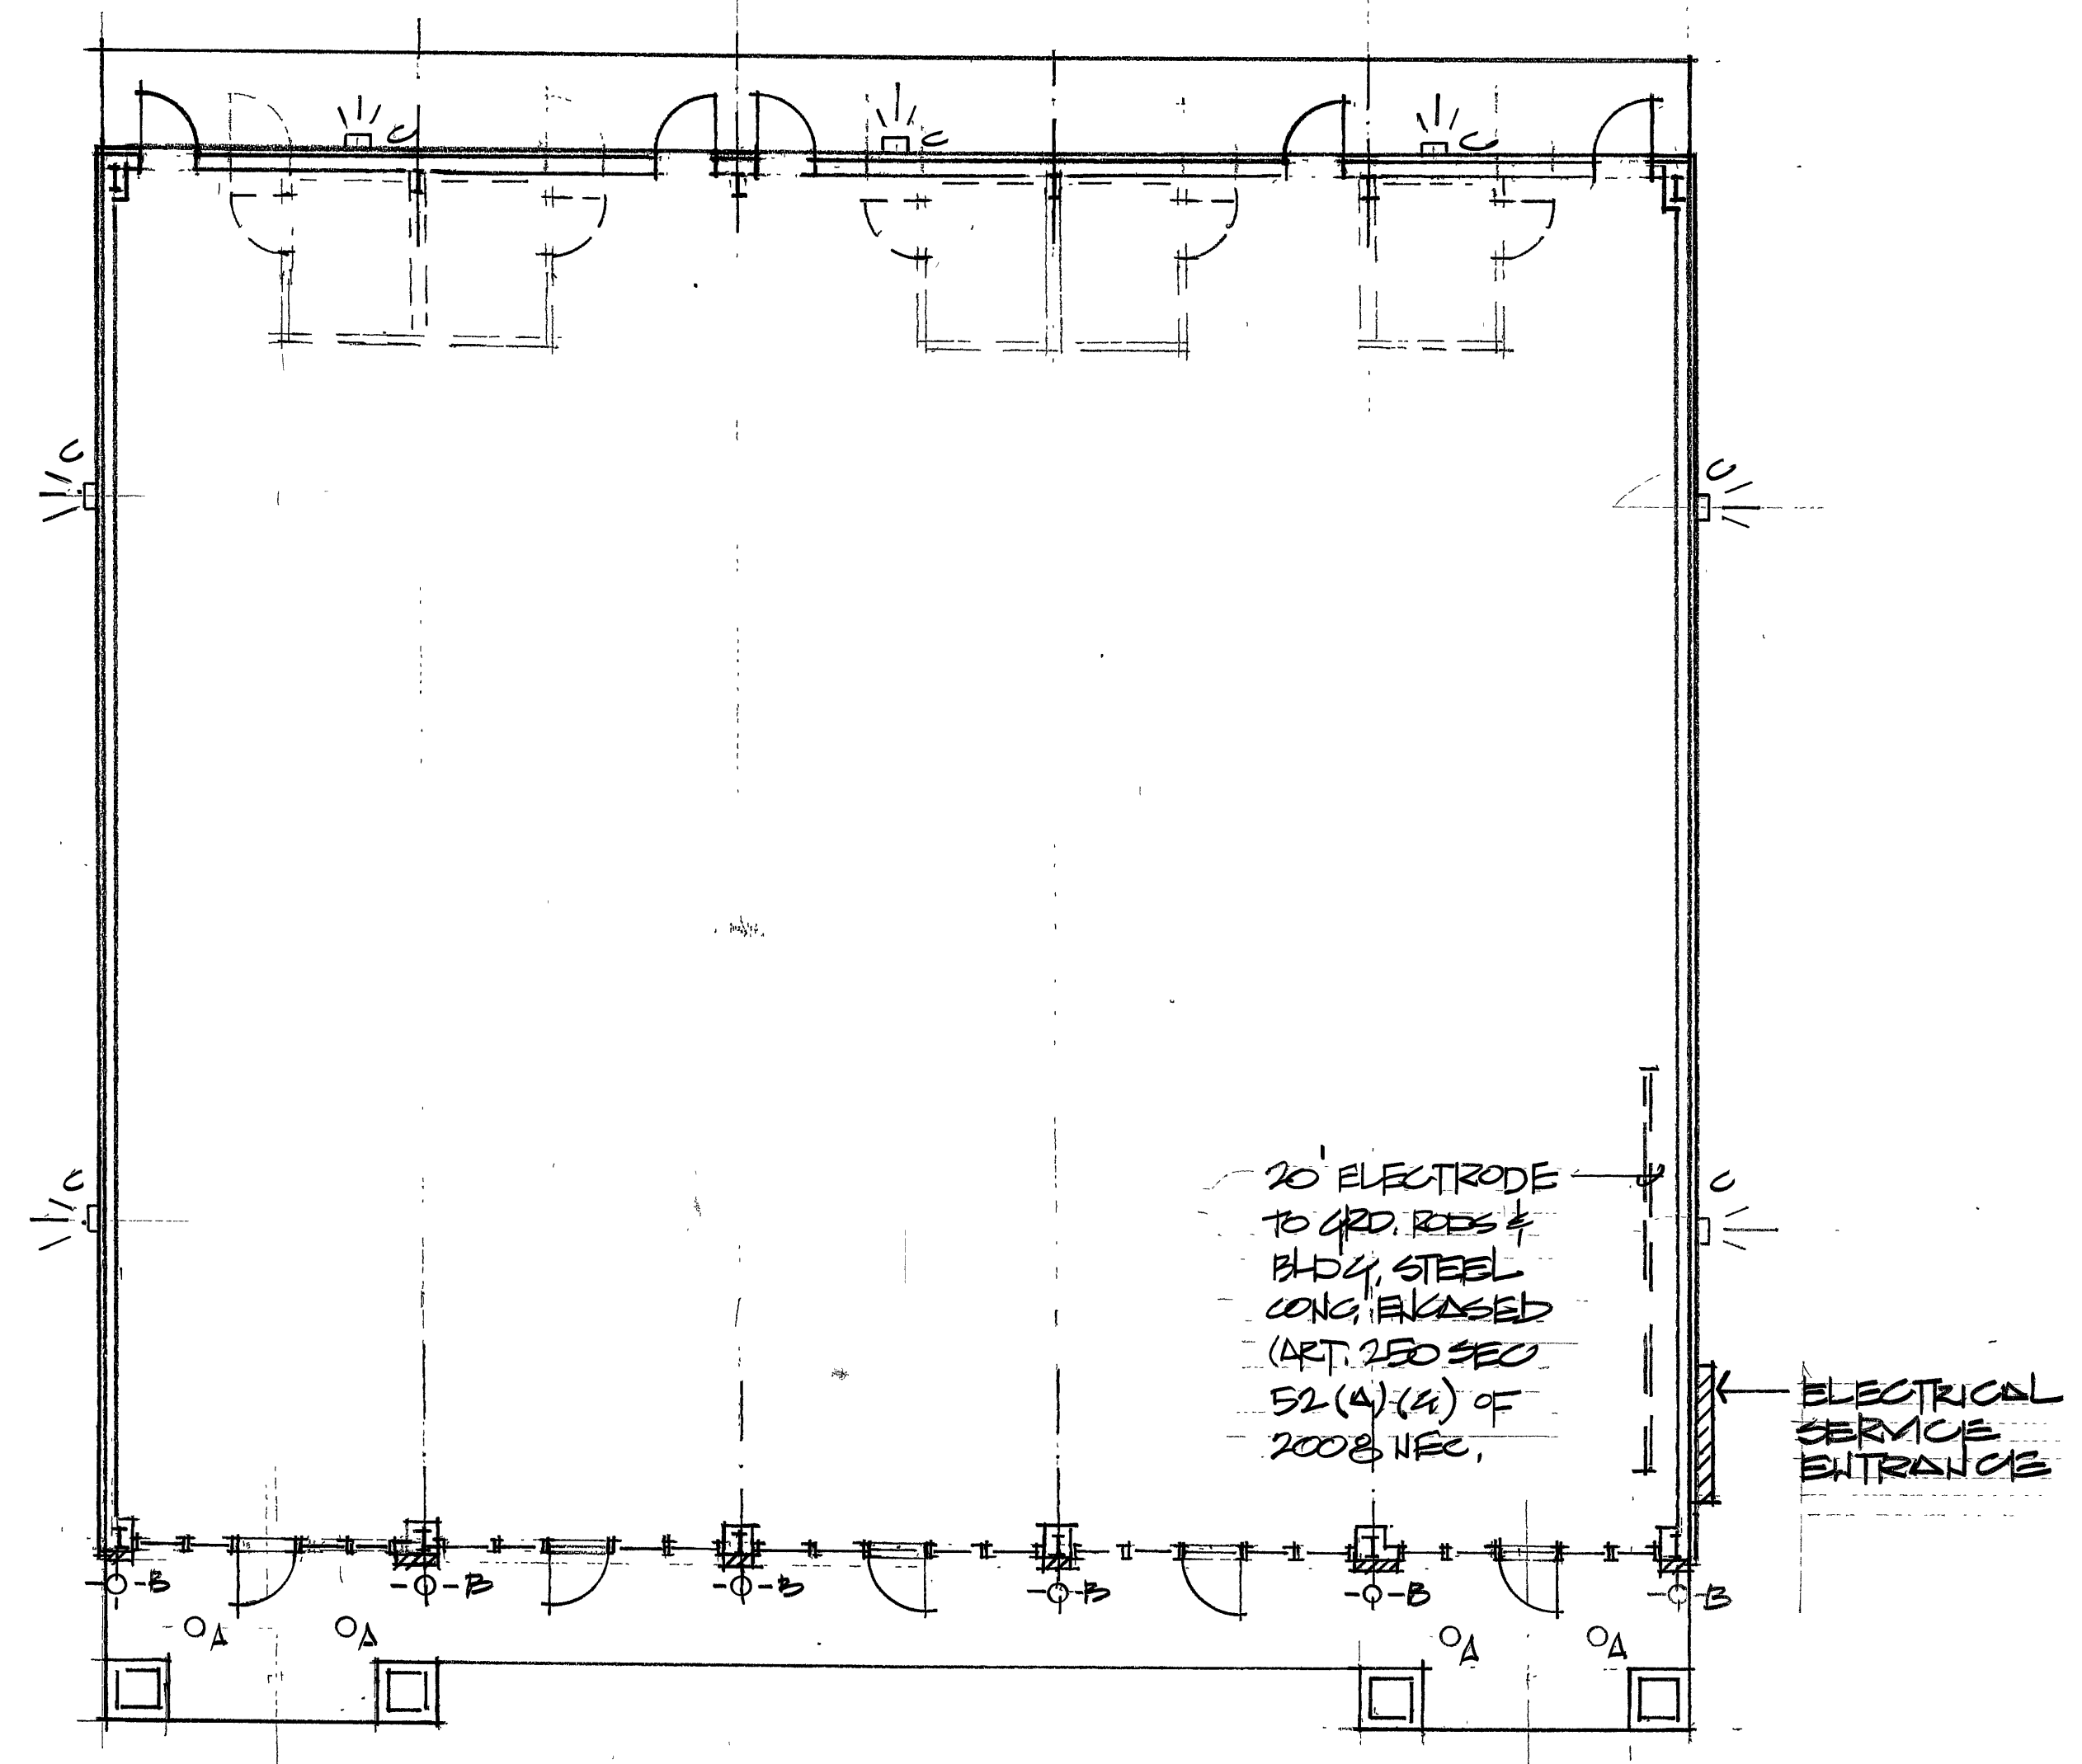

ELECTRICAL PLAN

1/8" = 1'-0"

- ELECTRICAL NOTES**
1. All electrical work shall conform to the latest National Electrical Code, NFPA 70.
 2. Contractors shall comply with utility company policies and local codes.
 3. Contractor to balance loads on panels. (Panel schedule shown gives minimum size of breakers, wire and conduit for electrical equipment. It is not intended to be a strict wiring diagram.)
 4. All conduit to be galvanized E.M.T., R.S. or MC cable as required.
 5. Contractor to verify all service requirements.

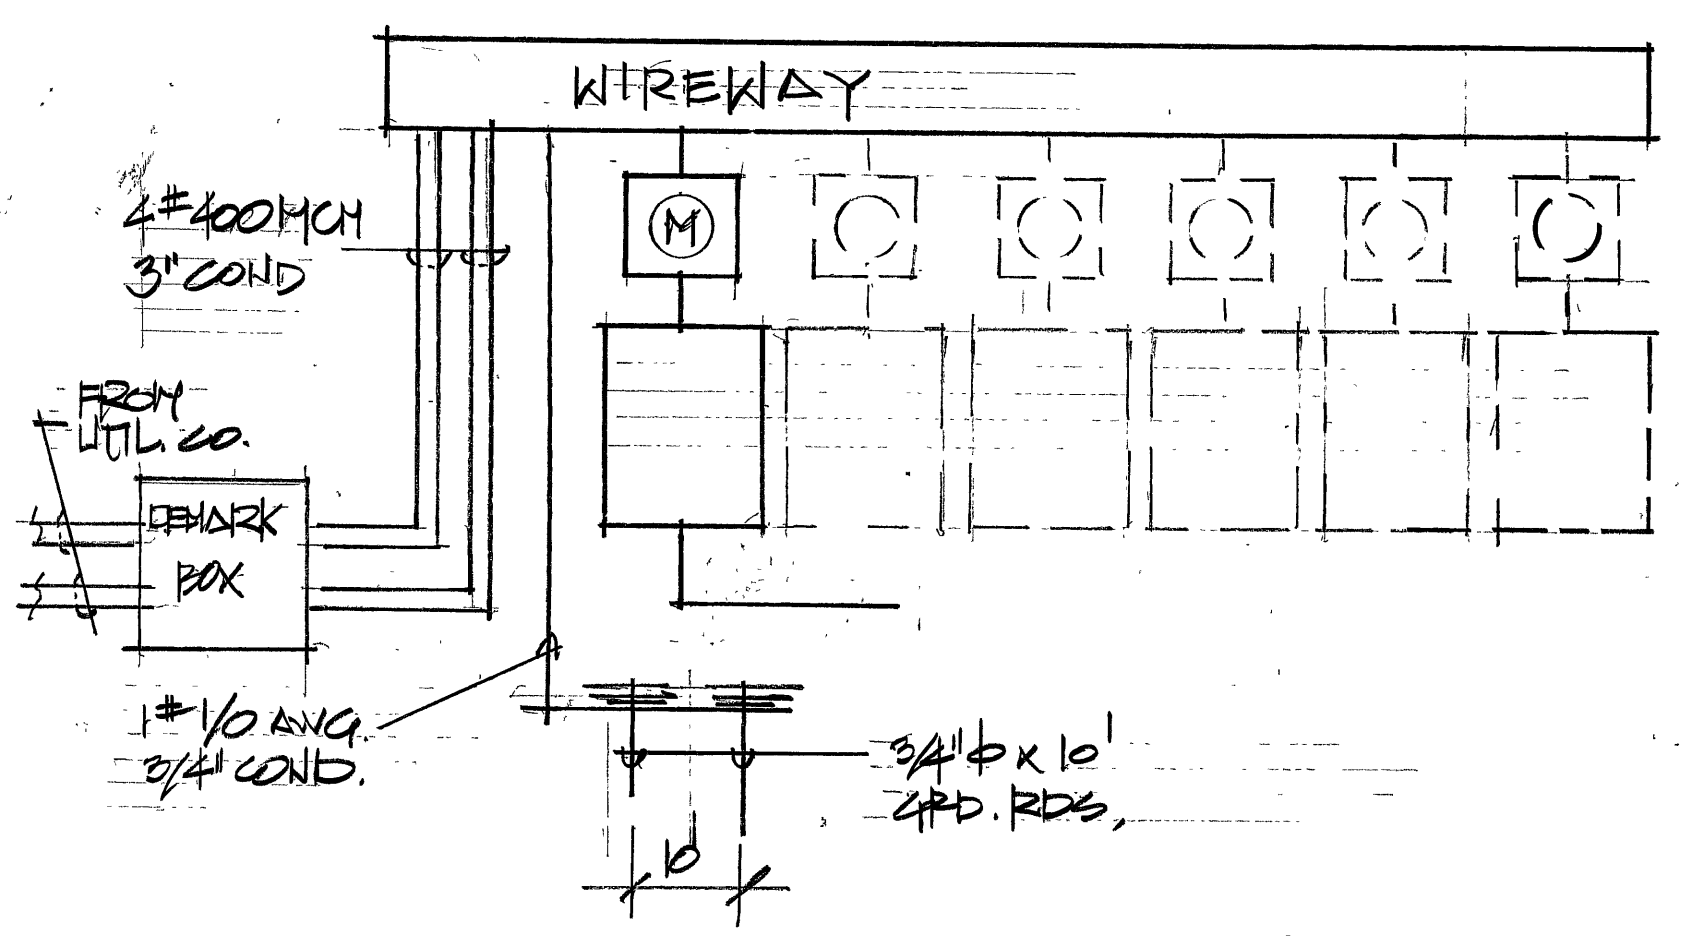

ELECTRICAL RISER DIAG

