


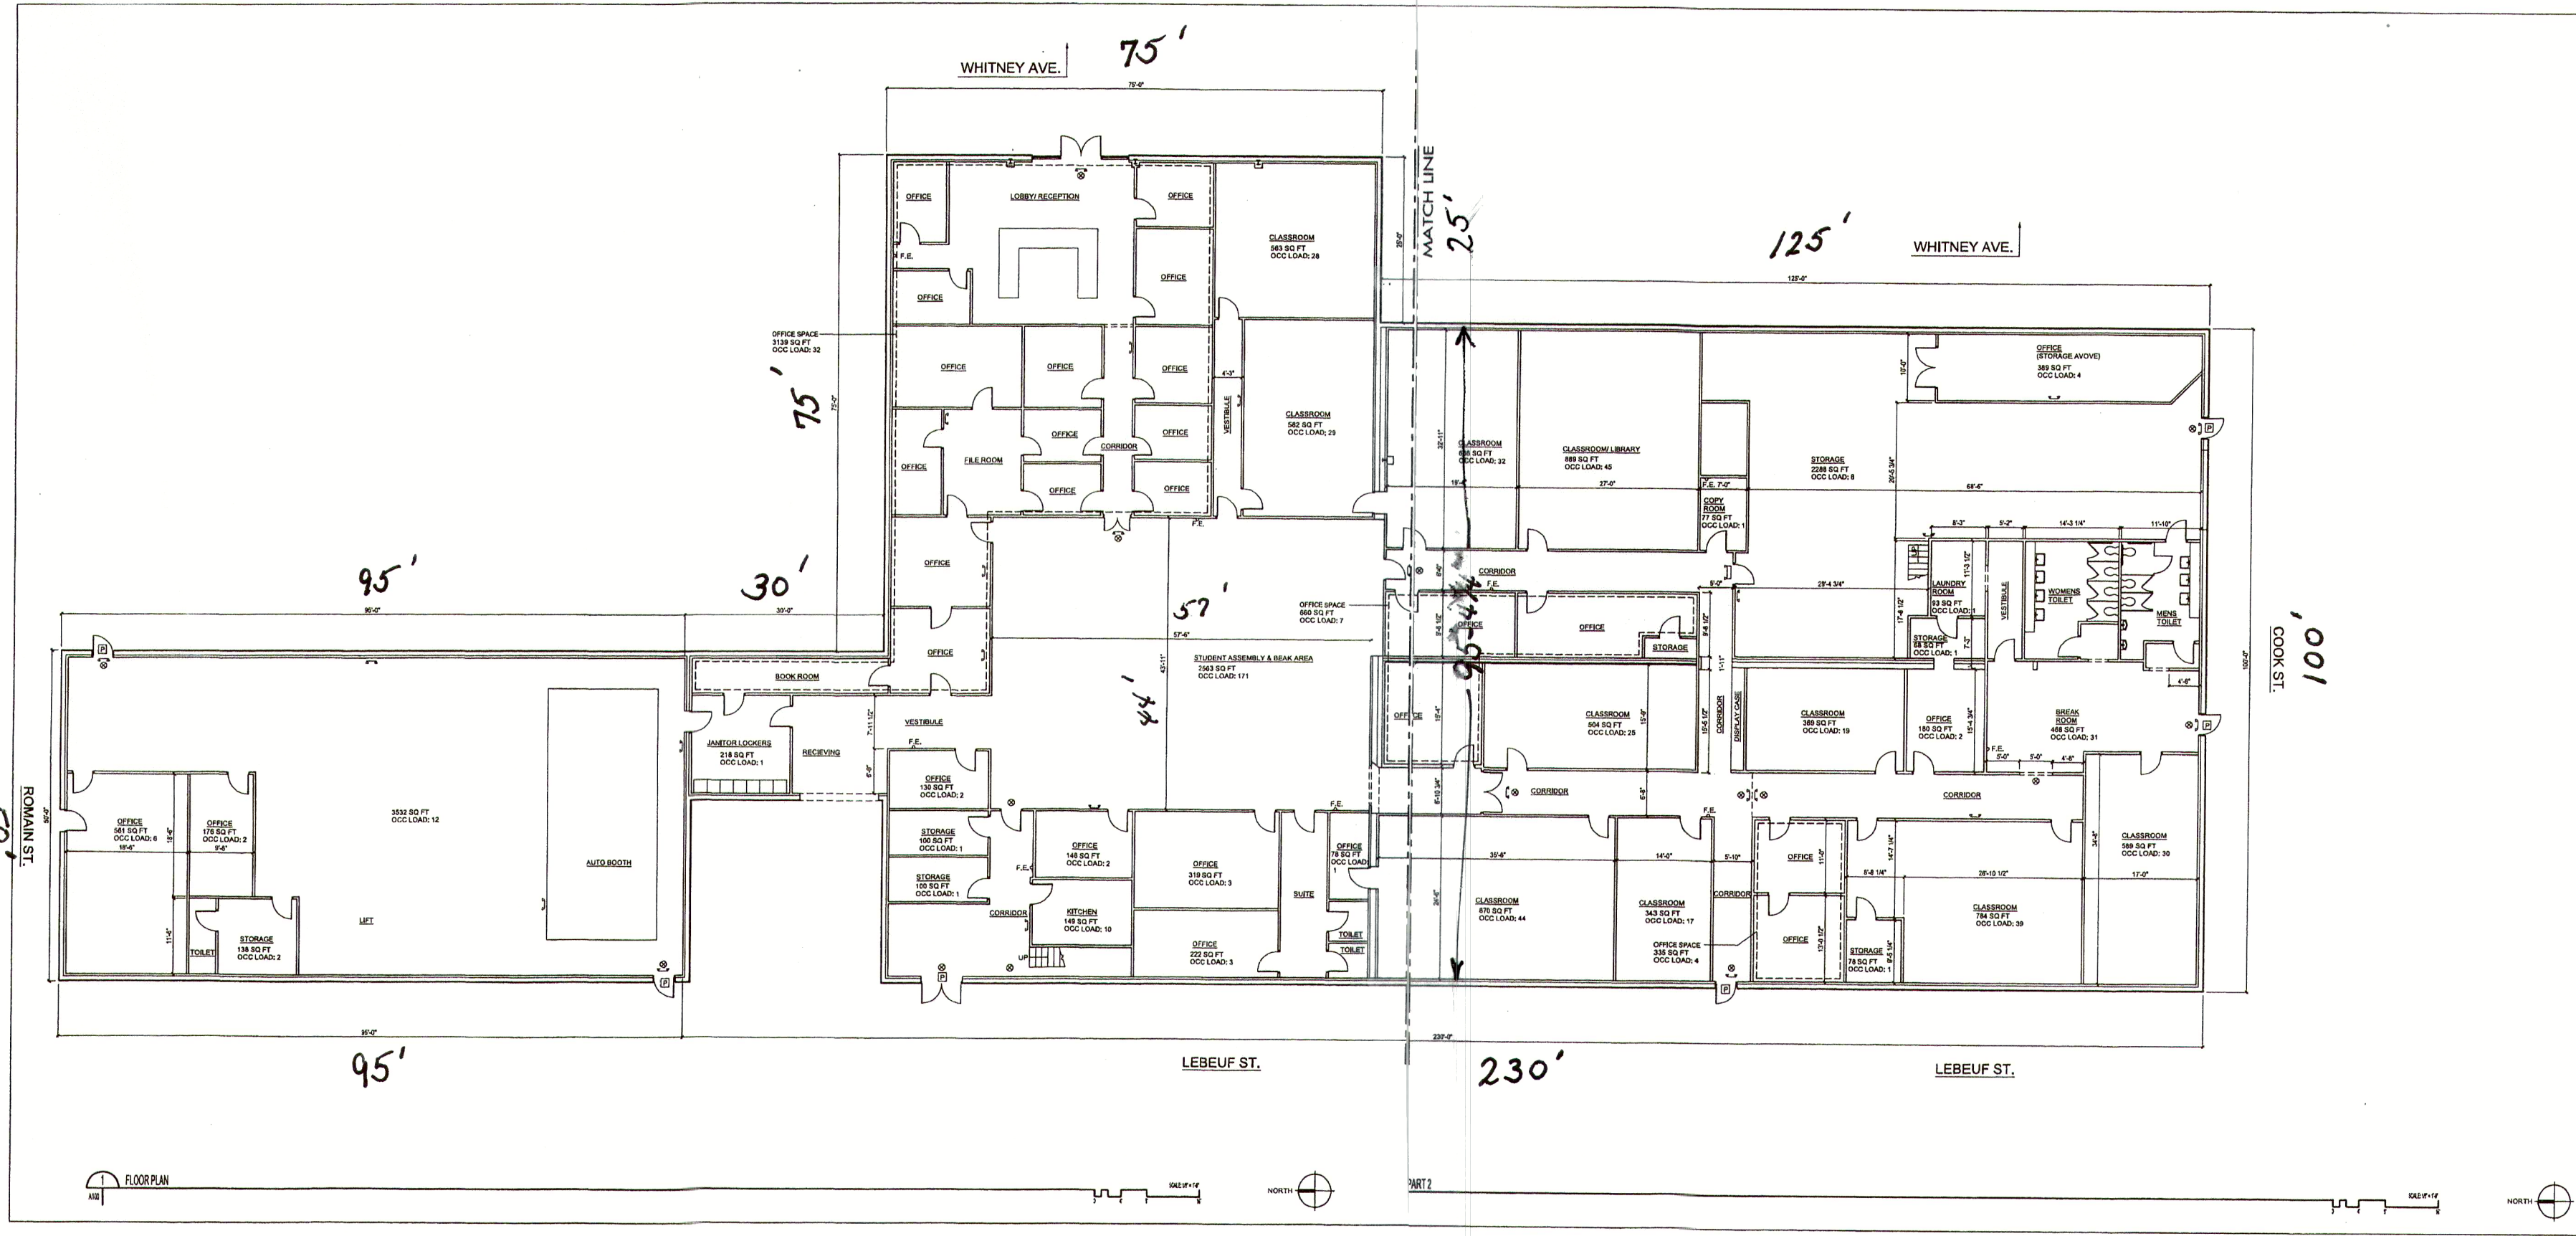

LEGEND

CLASSROOM	ROOM NAME
504 SQ FT	ROOM SQUARE FOOTAGE
OCC LOAD: 25	OCCUPANT LOAD PER NFPA 2008
EXIT SIGN	EXIT SIGN
FIRE EXTINGUISHER - TYPE 2A-10BC-C	FIRE EXTINGUISHER - TYPE 2A-10BC-C
EXISTING DOOR WITH PANIC DEVICE	EXISTING DOOR WITH PANIC DEVICE

ARCHITECT:
CHRISTOPHER J. YOUNG, CSI, NCARB
2215 PINE STREET
NEW ORLEANS, LOUISIANA 70118
T 504-251-5119

GRETNA CAREER COLLEGE
1415 Whitney Avenue
Gretna, LA 70053
504-366-5409

CONSTRUCTION PLAN - KEY NOTES

NO.	SUBMISSION	DATE
1.	CONSTRUCTION DOCUMENTS	03-10-10

CHECKED BY: CHRIS YOUNG
DRAWN BY: SHELLEY ROGERS
PROJECT NO. 10-001
COPYRIGHT TO CHRIS YOUNG 2010

SHEET TITLE
SITE PLAN

SHEET NO.
A 101