

SHEET LIST	
SHEET NO.	SHEET NAME
A-0	TITLE SHEET
A-1.1	SITE PLAN
A-2.2	FIRST FLOOR PLAN
A-2.4	SCHEDULES # OPENING TYPES
A-2.6	FIRST # SECOND FLOOR REFLECTED CEILING # ROOF PLANS
A-3.1	BUILDING ELEVATIONS
A-3.2	BUILDING SECTIONS



AREA SUMMARY

GROSS AREA	
1ST FLOOR	2524 SF
	2524 SF


CODE DATA

CODE SUMMARY (WITH AMENDMENTS AS PER THE LOUISIANA STATE UNIFORM CONSTRUCTION CODE)

- 1 INTERNATIONAL BUILDING CODE 2015
- 2 NATIONAL ELECTRICAL CODE 2014
- 3 INTERNATIONAL PLUMBING CODE 2015
- 4 INTERNATIONAL MECHANICAL CODE 2015
- 5 NFPA 101 - LIFE SAFETY CODE 2015
- 6 AMERICANS WITH DISABILITIES ACT STANDARDS FOR ACCESSIBLE DESIGN
- 7 ASHRAE 90.1 ENERGY STANDARD 2007

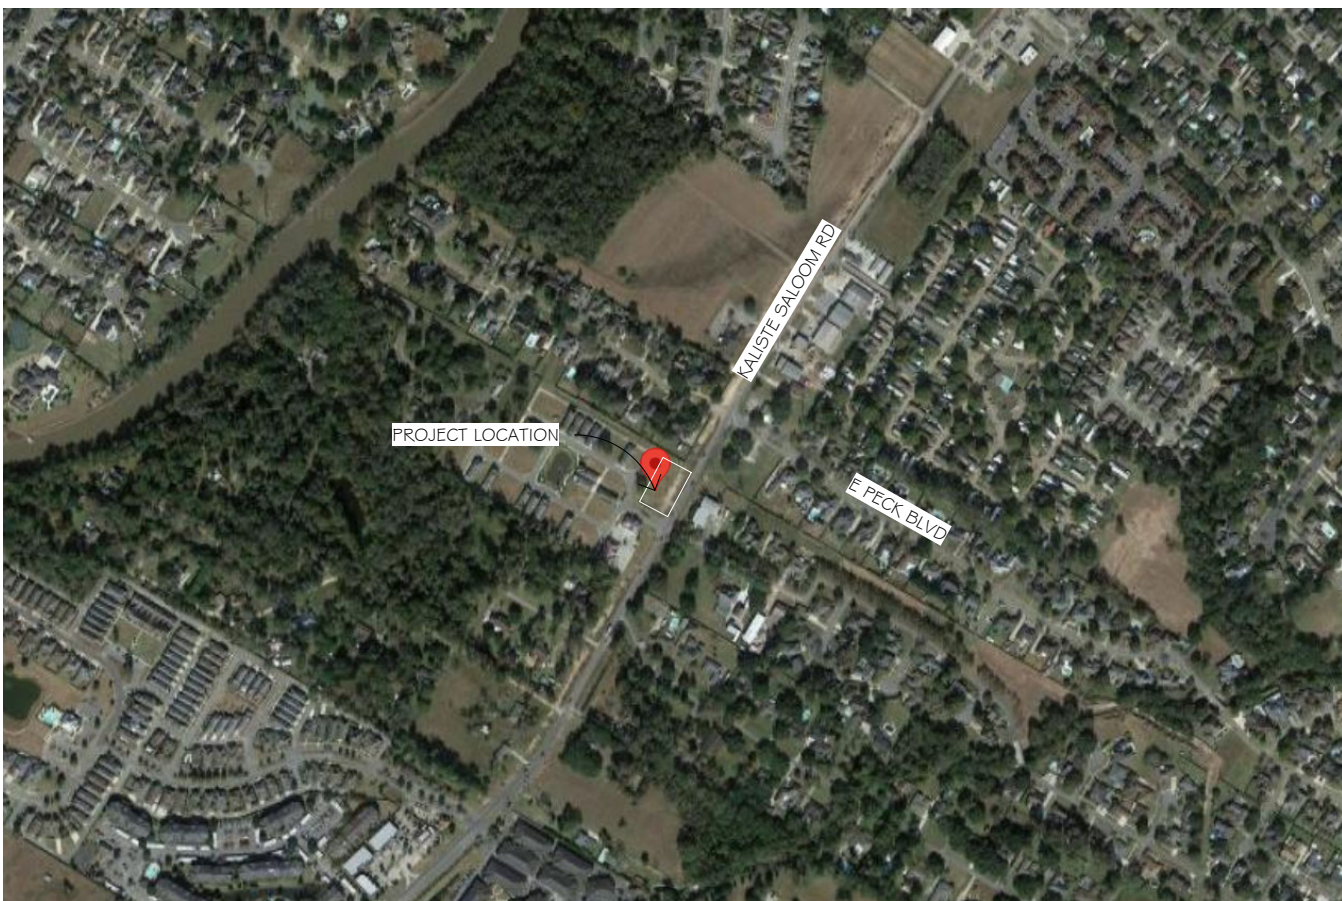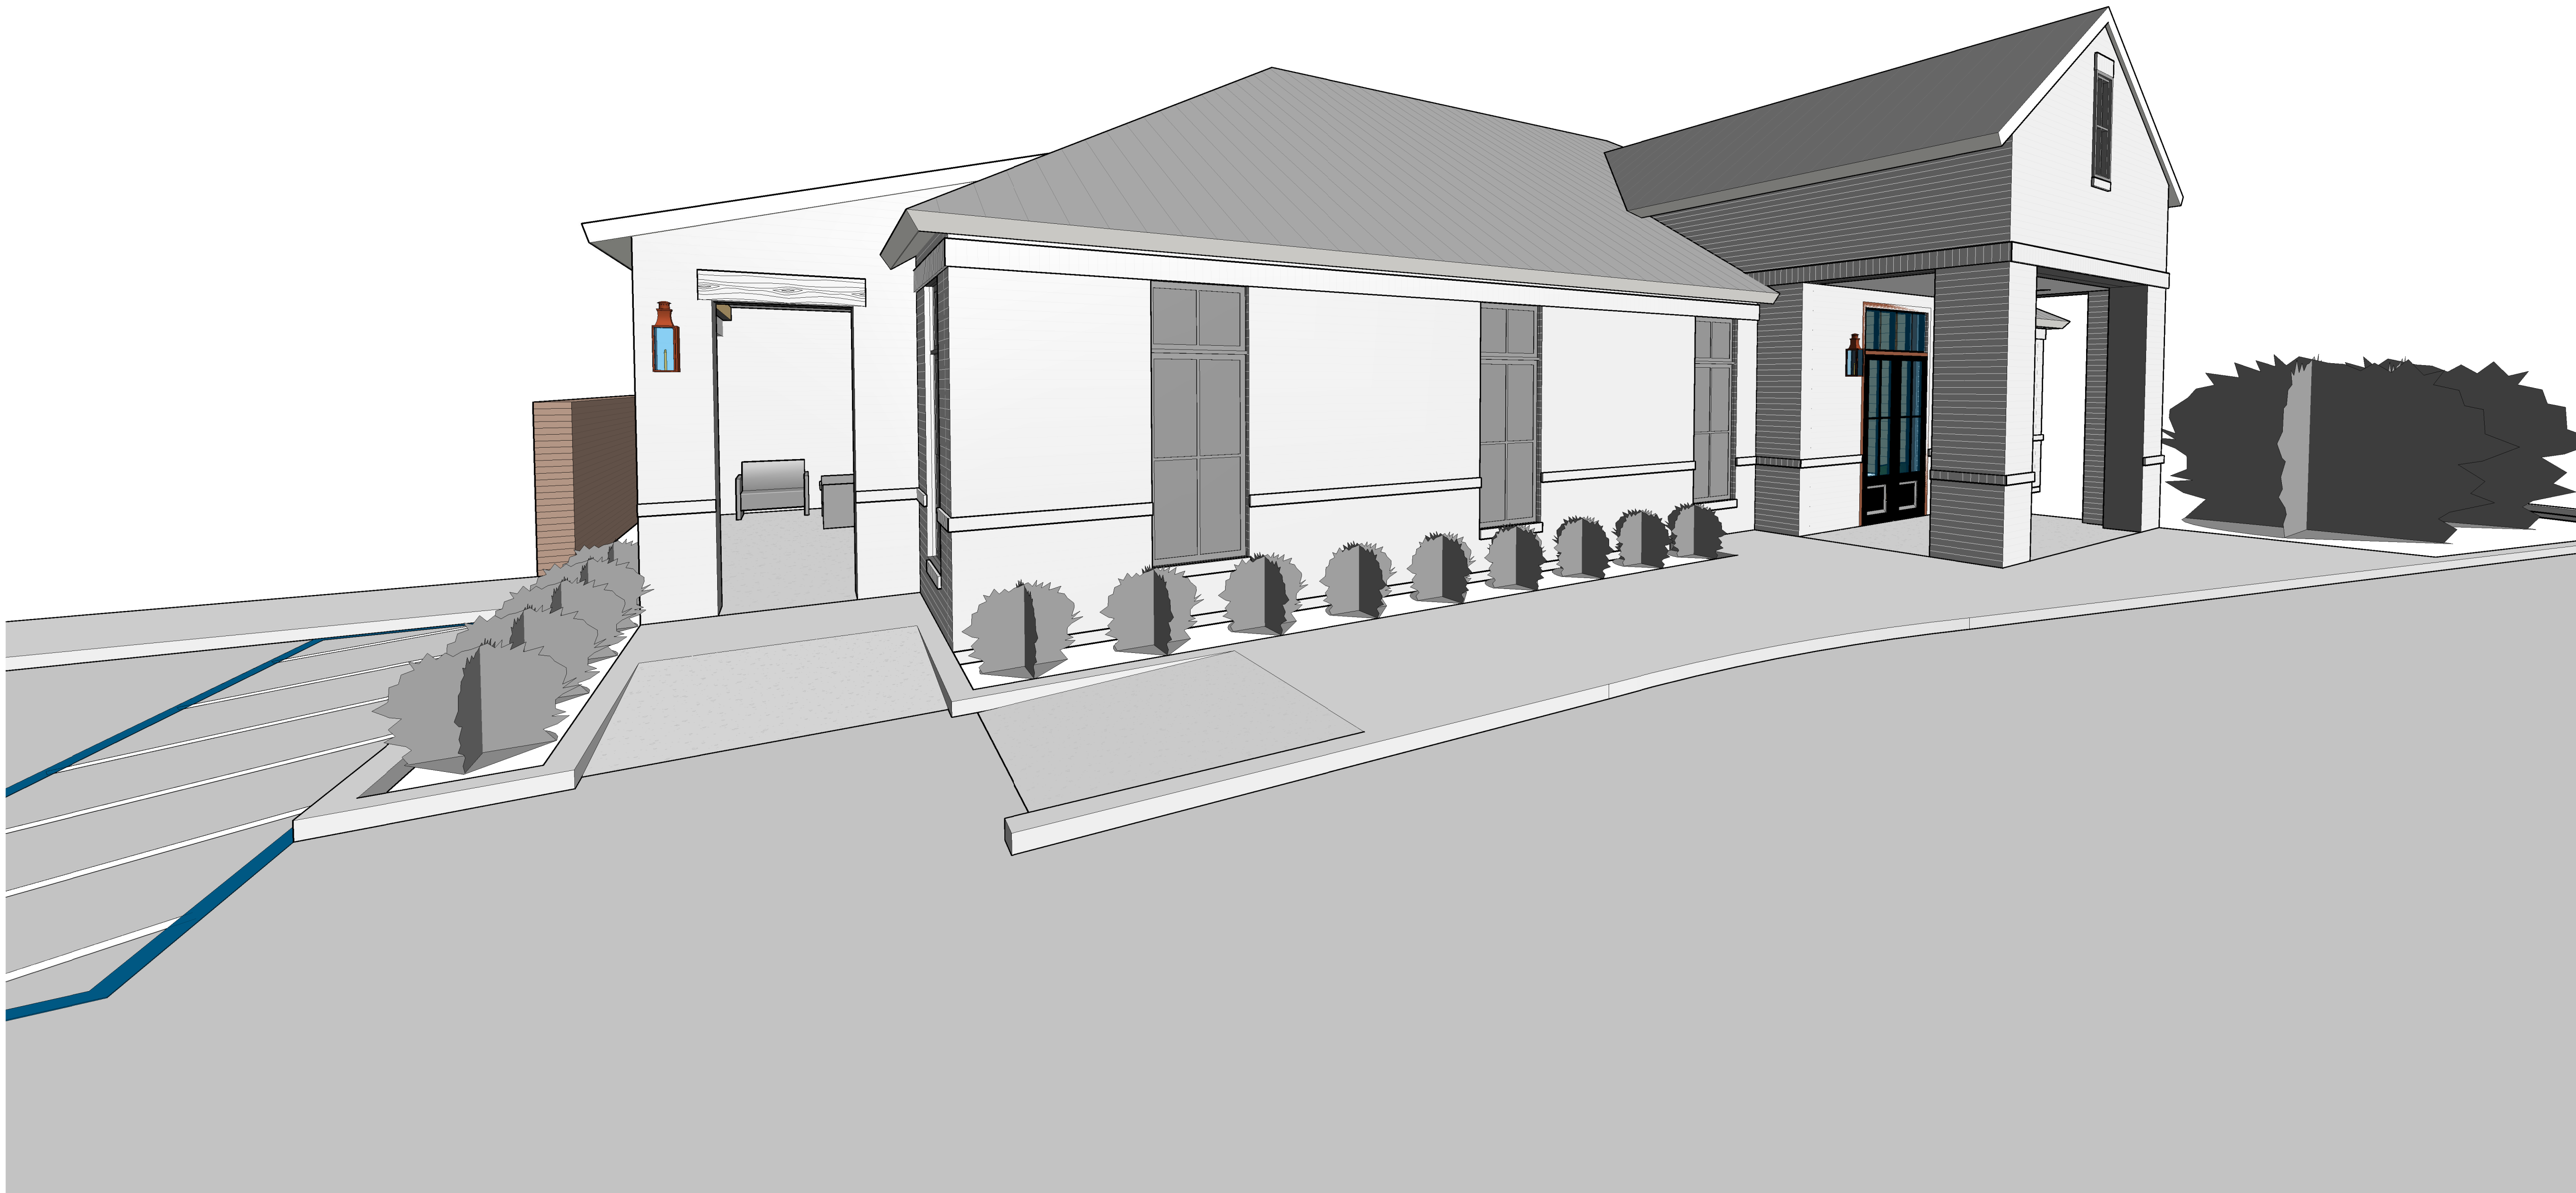

VICINITY MAP

 

A NEW OFFICE FOR:

CAL CHLOR

3304 KALISTE SALOOM RD.
LAFAYETTE PARISH, LA 70508
INSIDE CITY LIMITS

PROJECT TEAM:

ARCHITECT :
MANUEL COMMERCIAL
A DESIGN-BUILD FIRM
CONTACT: CHRIS LEGER
EMAIL: CHRIS.LEGER@MANUELCOMMERCIAL.COM
337.252.3042

MECHANICAL, ELECTRICAL, & PLUMBING ENGINEER:
FIRM NAME _____
MECH CONTACT: _____
EMAIL _____
ELEC CONTACT: _____
EMAIL _____
PHONE _____

CIVIL ENGINEER:
FIRM NAME
CONTACT: _____
EMAIL
PHONE

STRUCTURAL ENGINEER:
FIRM NAME
CONTACT: _____
EMAIL
PHONE

UTILITY CONTACTS:

SEWER : _____

WATER: _____

ELECTRIC: _____

NATURAL GAS: _____

TELECOMMUNICATIONS: _____

ALL RIGHTS RESERVED

ANY UNAUTHORIZED COPY
AND/OR REPRODUCTION
STRICTLY PROHIBITED & MAY
CONSTITUTE A VIOLATION OF
COPYRIGHT LAWS OF THE U.S.
STATES FOUND IN TITLE 17 OF
UNITED STATES CODE. VIOLA-
TION OF THESE LAWS MAY RESULT
IN CIVIL FINES AND PENALTIES UNDER
THE LAW

© 2022
MANUEL COMMERCIAL, L.P.

 **AIA**

The American Institute of Architects

MANUEL
COMMERCIAL
ARCHITECTURE + CONSTRUCTION

337.427.6100
Broussard, LA 70518

manuelcommercial.com
104 Darry Lane

A NEW OFFICE FOR: for:

CAL CHLOR

3304 KALISTE SALOOM RD.
LAFAYETTE PARISH, LA 70508
INSIDE CITY LIMITS

SCHEMATIC


REVISION SCHEDULE		
NO.	DESCRIPTION	DATE


DATE: 12-14-2022

TITLE SHEET

SHEET
A-0

PRINTED: 12/14/2022 5:35:11 PM

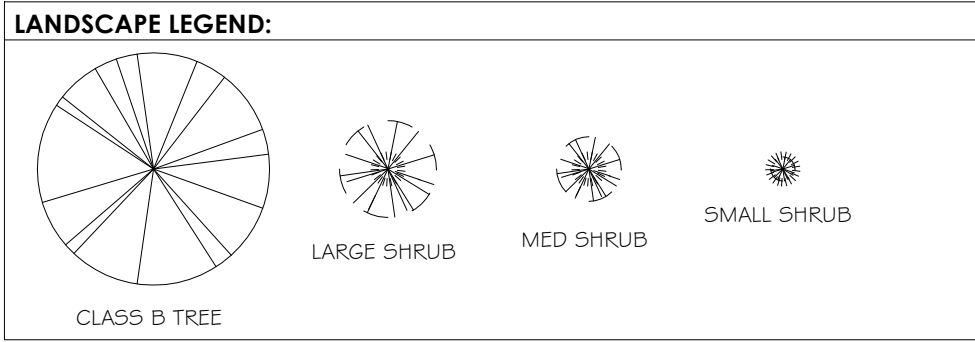

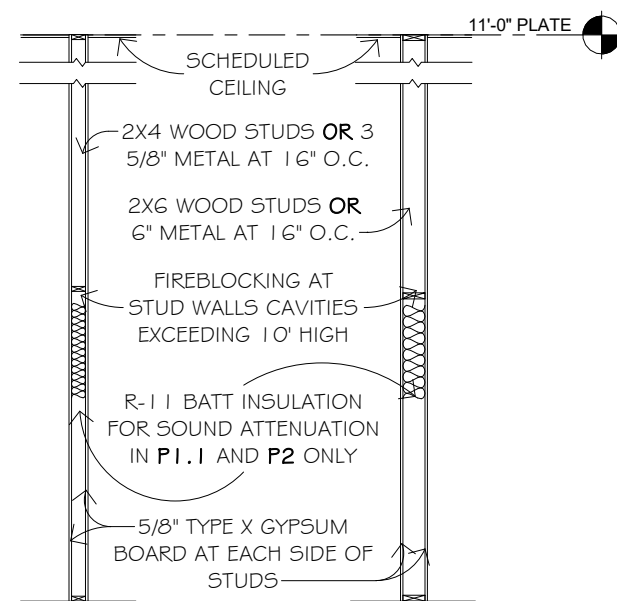

P1
P1.1

P2


3 PARTITION TYPES

SCALE: 0' = 1/4" = 1'-0" 9'

WALL LEGEND:	
	1 HR. BARRIER
	DRAFTSTOP


FLOOR PLAN - GENERAL NOTES

**NOTE: COORDINATE BLOCKING FOR OWNER-PROVIDED EQUIPMENT. VERIFY ON JOB.

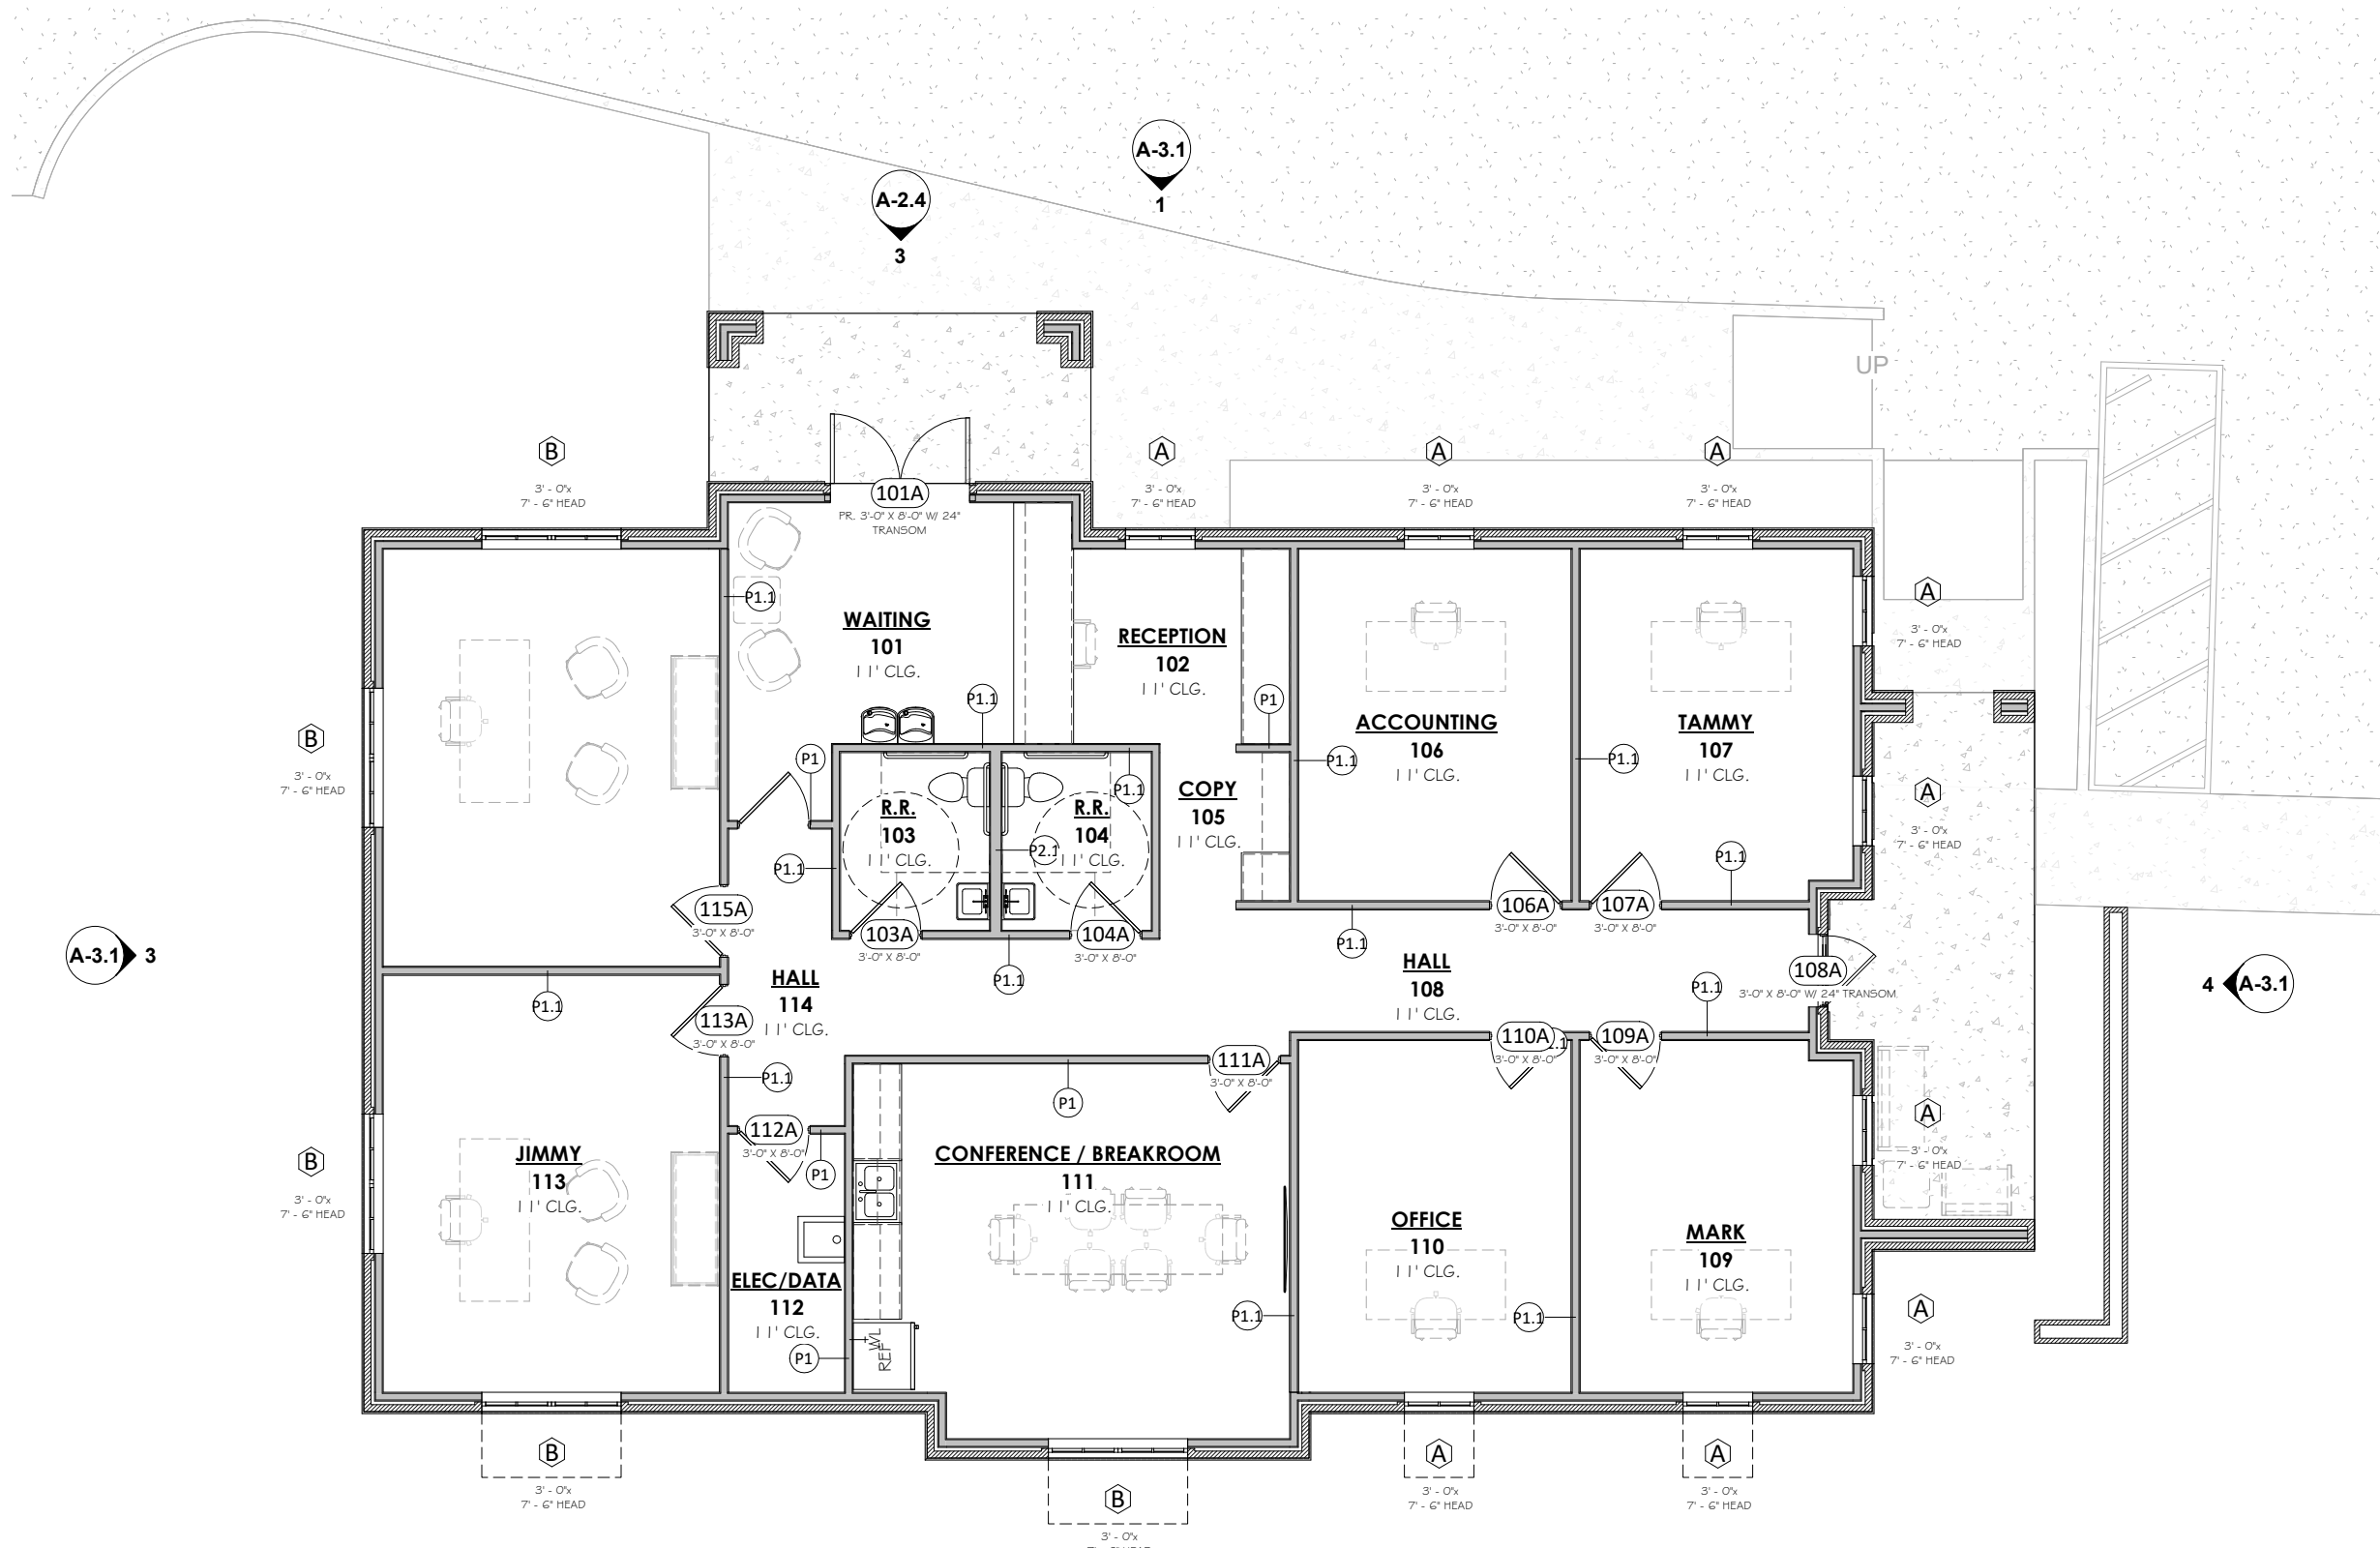

2 1ST FLOOR PLAN

SCALE: 0' = 1/8" = 1'-0" 9'

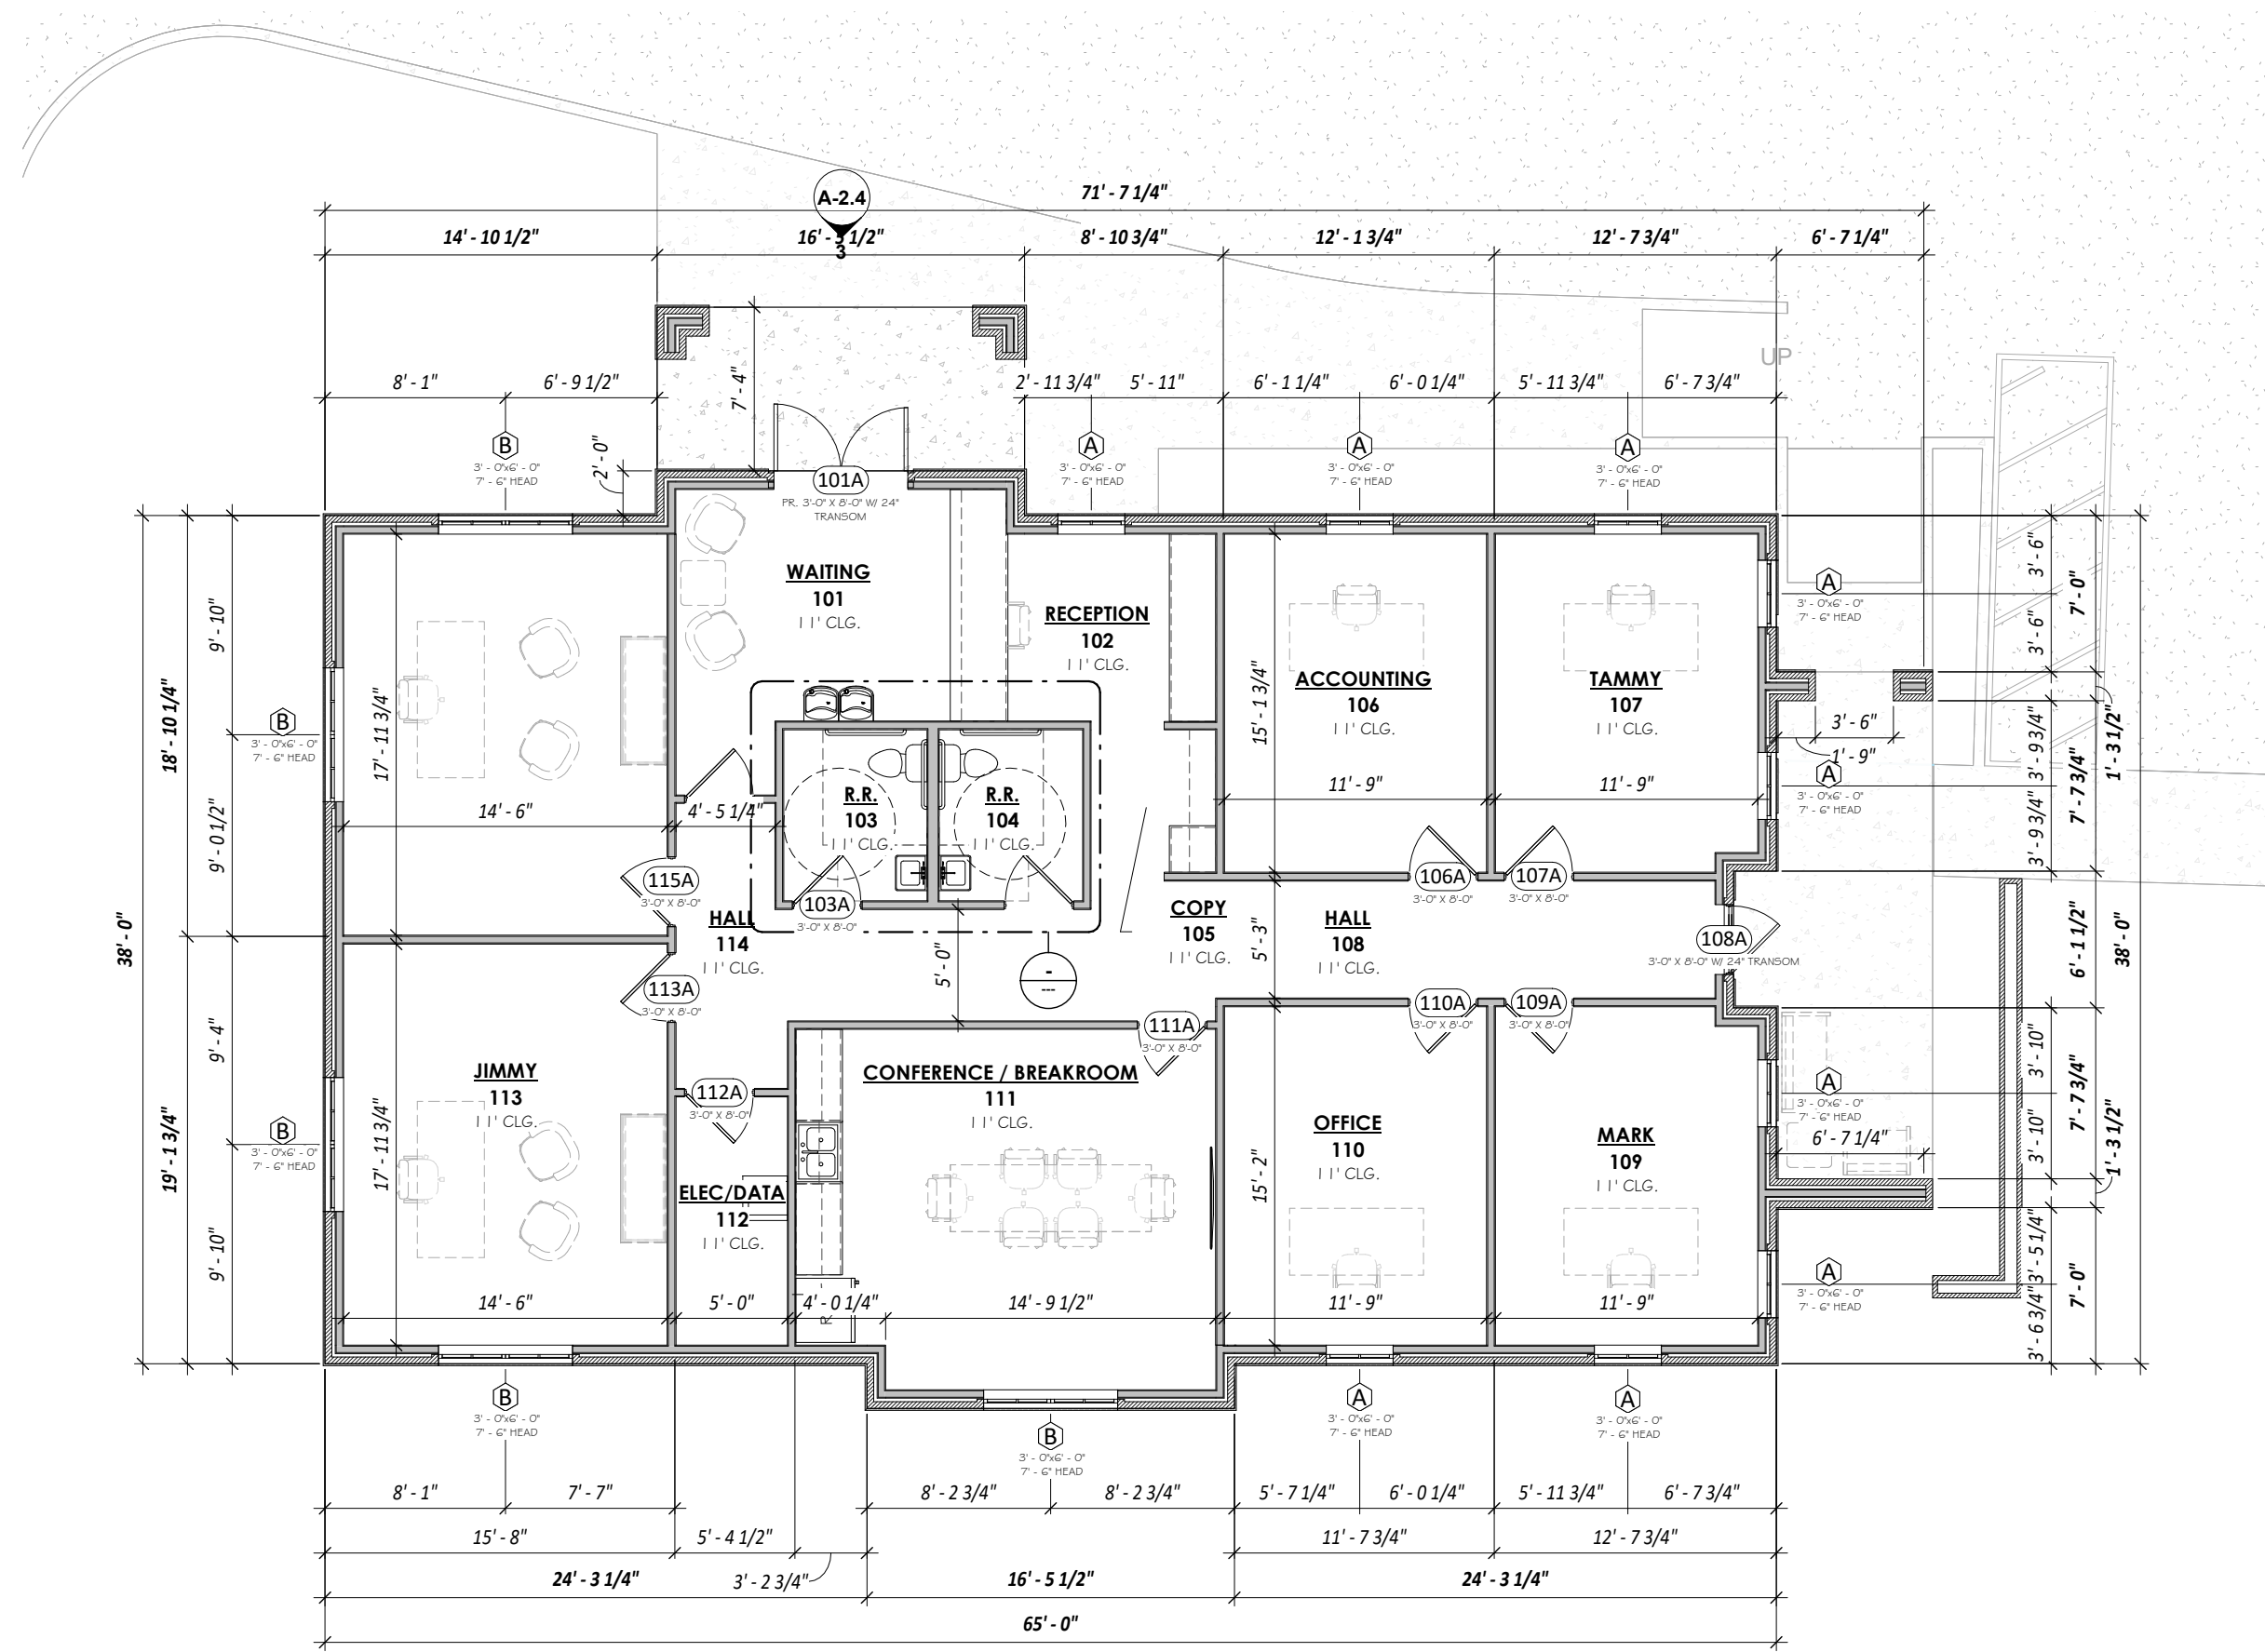

1 1ST FLOOR DIMENSION PLAN

SCALE: 0' = 1/8" = 1'-0" 9'

ALL RIGHTS RESERVED

ANY UNAUTHORIZED COPYING AND/OR REPRODUCTION IS STRICTLY PROHIBITED & MAY CONSTITUTE A VIOLATION OF THE COPYRIGHT LAWS OF THE UNITED STATES FOUND IN TITLE 17 OF THE UNITED STATES CODE. VIOLATION OF THOSE LAWS MAY RESULT IN CIVIL FINES AND PENALTIES UNDER THE LAW.

© 2022
MANUEL COMMERCIAL, LLC

AIA
The American Institute of Architects

MANUEL COMMERCIAL
ARCHITECTURE + CONSTRUCTION
manuelcommercial.com
104 Darry Lane
Broussard, LA 70018
337.427.6100

A NEW OFFICE FOR:
CAL CHLOR

3304 KAUSTE SALOOM RD.
LAKEVIEW PARISH, LA 70068
INSIDE CITY LIMITS

SCHEMATIC

REVISION SCHEDULE
NO. DESCRIPTION DATE

DATE: 12-14-2022

FIRST FLOOR PLAN

SHEET
A-2.2

PRINTED: 12/14/2022 5:35:25 PM


ROOM FINISH SCHEDULE							
ROOM NO.	ROOM NAME	FLOOR FINISH	BASE FINISH	WALL FINISH	CEILING FINISH	CEILING HEIGHT	REMARKS
101	WAITING	VP-1	WB-1	PNT-1	PNT-1	11' CLG.	
102	RECEPTION	CPT-1	WB-1	PNT-1	PNT-1	11' CLG.	
103	R.R.	CT-1	WB-1	PNT-1	PNT-1	11' CLG.	
104	R.R.	CT-1	WB-1	PNT-1	PNT-1	11' CLG.	
105	COPY	CPT-1	WB-1	PNT-1	PNT-1	11' CLG.	
106	ACCOUNTING	CPT-1	WB-1	PNT-1	PNT-1	11' CLG.	
107	TAMMY	CPT-1	WB-1	PNT-1	PNT-1	11' CLG.	
108	HALL	CPT-1	WB-1	PNT-1	PNT-1	11' CLG.	
109	MARK	CPT-1	WB-1	PNT-1	PNT-1	11' CLG.	
110	OFFICE	CPT-1	WB-1	PNT-1	PNT-1	11' CLG.	
111	CONFERENCE / BREAKROOM	CPT-1	WB-1	PNT-1	PNT-1	11' CLG.	
112	ELEG/DATA	C-1	WB-1	PNT-1	PNT-1	11' CLG.	
113	JIMMY	CPT-1	WB-1	PNT-1	PNT-1	11' CLG.	
114	HALL	CPT-1	WB-1	PNT-1	PNT-1	11' CLG.	
115	TODD	CPT-1	WB-1	PNT-1	PNT-1	11' CLG.	

DOOR SCHEDULE									
MARK	SIZE	DESCRIPTION	FIRE RATING	DOOR MATERIAL	FRAME MATERIAL	TRIM MATERIAL	TYPE	HARDWARE	COMMENTS
101A	PR. 3'-0" X 8'-0" W/ 24" TRANSOM	EXT. DOUBLE SWING DOOR - 3/4 GLASS, 4 LT TRANSOM		FIBERGLASS, INSUL., 4 LT OVER 1 PANEL			01		CLOSER
103A	3'-0" X 8'-0"	INT. SINGLE SWING DOOR		METAL, FLUSH PANEL			04		
104A	3'-0" X 8'-0"	INT. SINGLE SWING DOOR		METAL, FLUSH PANEL			04		
106A	3'-0" X 8'-0"	INT. SINGLE SWING DOOR		WOOD - FULL GLASS -4 LT			03		
107A	3'-0" X 8'-0"	INT. SINGLE SWING DOOR		WOOD - FULL GLASS -4 LT			03		
108A	3'-0" X 8'-0" W/ 24" TRANSOM	EXT. SINGLE SWING DOOR - 3/4 GLASS, 4 LT TRANSOM		FIBERGLASS, INSUL., 4 LT OVER 1 PANEL			02		CLOSER
109A	3'-0" X 8'-0"	INT. SINGLE SWING DOOR		WOOD - FULL GLASS -4 LT			03		
110A	3'-0" X 8'-0"	INT. SINGLE SWING DOOR		WOOD - FULL GLASS -4 LT			03		
111A	3'-0" X 8'-0"	INT. SINGLE SWING DOOR		WOOD - FULL GLASS -4 LT			03		
112A	3'-0" X 8'-0"	INT. SINGLE SWING DOOR		WOOD - FULL GLASS -4 LT			03		
113A	3'-0" X 8'-0"	INT. SINGLE SWING DOOR		WOOD - FULL GLASS -4 LT			03		
115A	3'-0" X 8'-0"	INT. SINGLE SWING DOOR		WOOD - FULL GLASS -4 LT			03		

DOOR HARDWARE
ALL DOOR HARDWARE SHALL BE ADA COMPLIANT - LEVER TYPE, MOUNTED NO HIGHER THAN 48" A.F.F.

WINDOW SCHEDULE									
MARK	OVERALL WIDTH	OVERALL HEIGHT	DESCRIPTION	COMPONENT SIZES	FRAME/ LT PATTERN	TRIM MATERIAL	GLAZING MATERIAL	COMMENTS	COUNT
A	3' - 0"	8' - 0"	VINYL, FIXED W/ TRANSOM		4LT/2LT 24" TRANSOM		1" INSULATED		9
B	6' - 0"	8' - 0"	VINYL, FIXED W/ TRANSOM		DBL 4LT/2LT 24" TRANSOM		1" INSULATED		5
C	1' - 9"	4' - 3"	VINYL, FIXED, INSULATED		4LT		1" INSULATED		2

* SEE SCHEDULE FOR SIZES

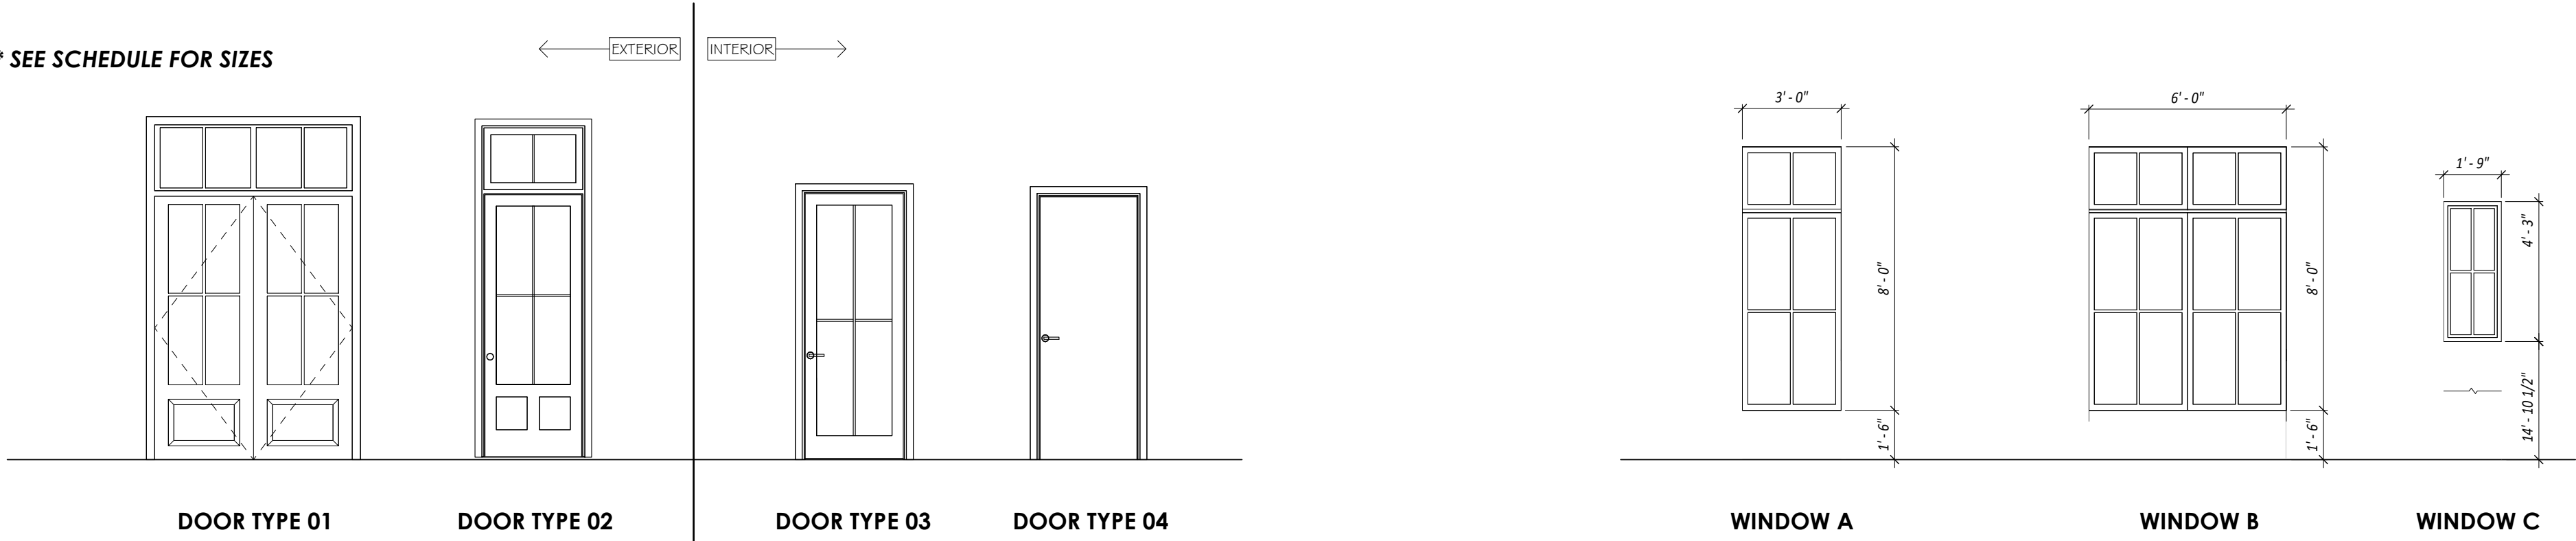


 GYP BOARD CLG. 1X6 T&G V-GROOVE PINE CLG.

ELEVATIONS ARE TAKEN FROM FINISH FLOOR
IMMEDIATELY BELOW ANY GIVEN CEILING

****NOTE:** COORDINATE ACCESS PANELS AT ALL
HARD CEILINGS TO CONCEALED SPACES.
VERIFY ON JOB.


****NOTE:** PLEASE RUN RIDGE VENT THROUGHOUT FOR AESTHETICS, BUT ONLY CUT PLYWOOD AND FELT AT LOCATIONS MEASURED TO ACHIEVE BALANCED VENTILATION; SEE VENTILATION SCHEDULE THIS SHEET**

ROOF FRAMING NOTES

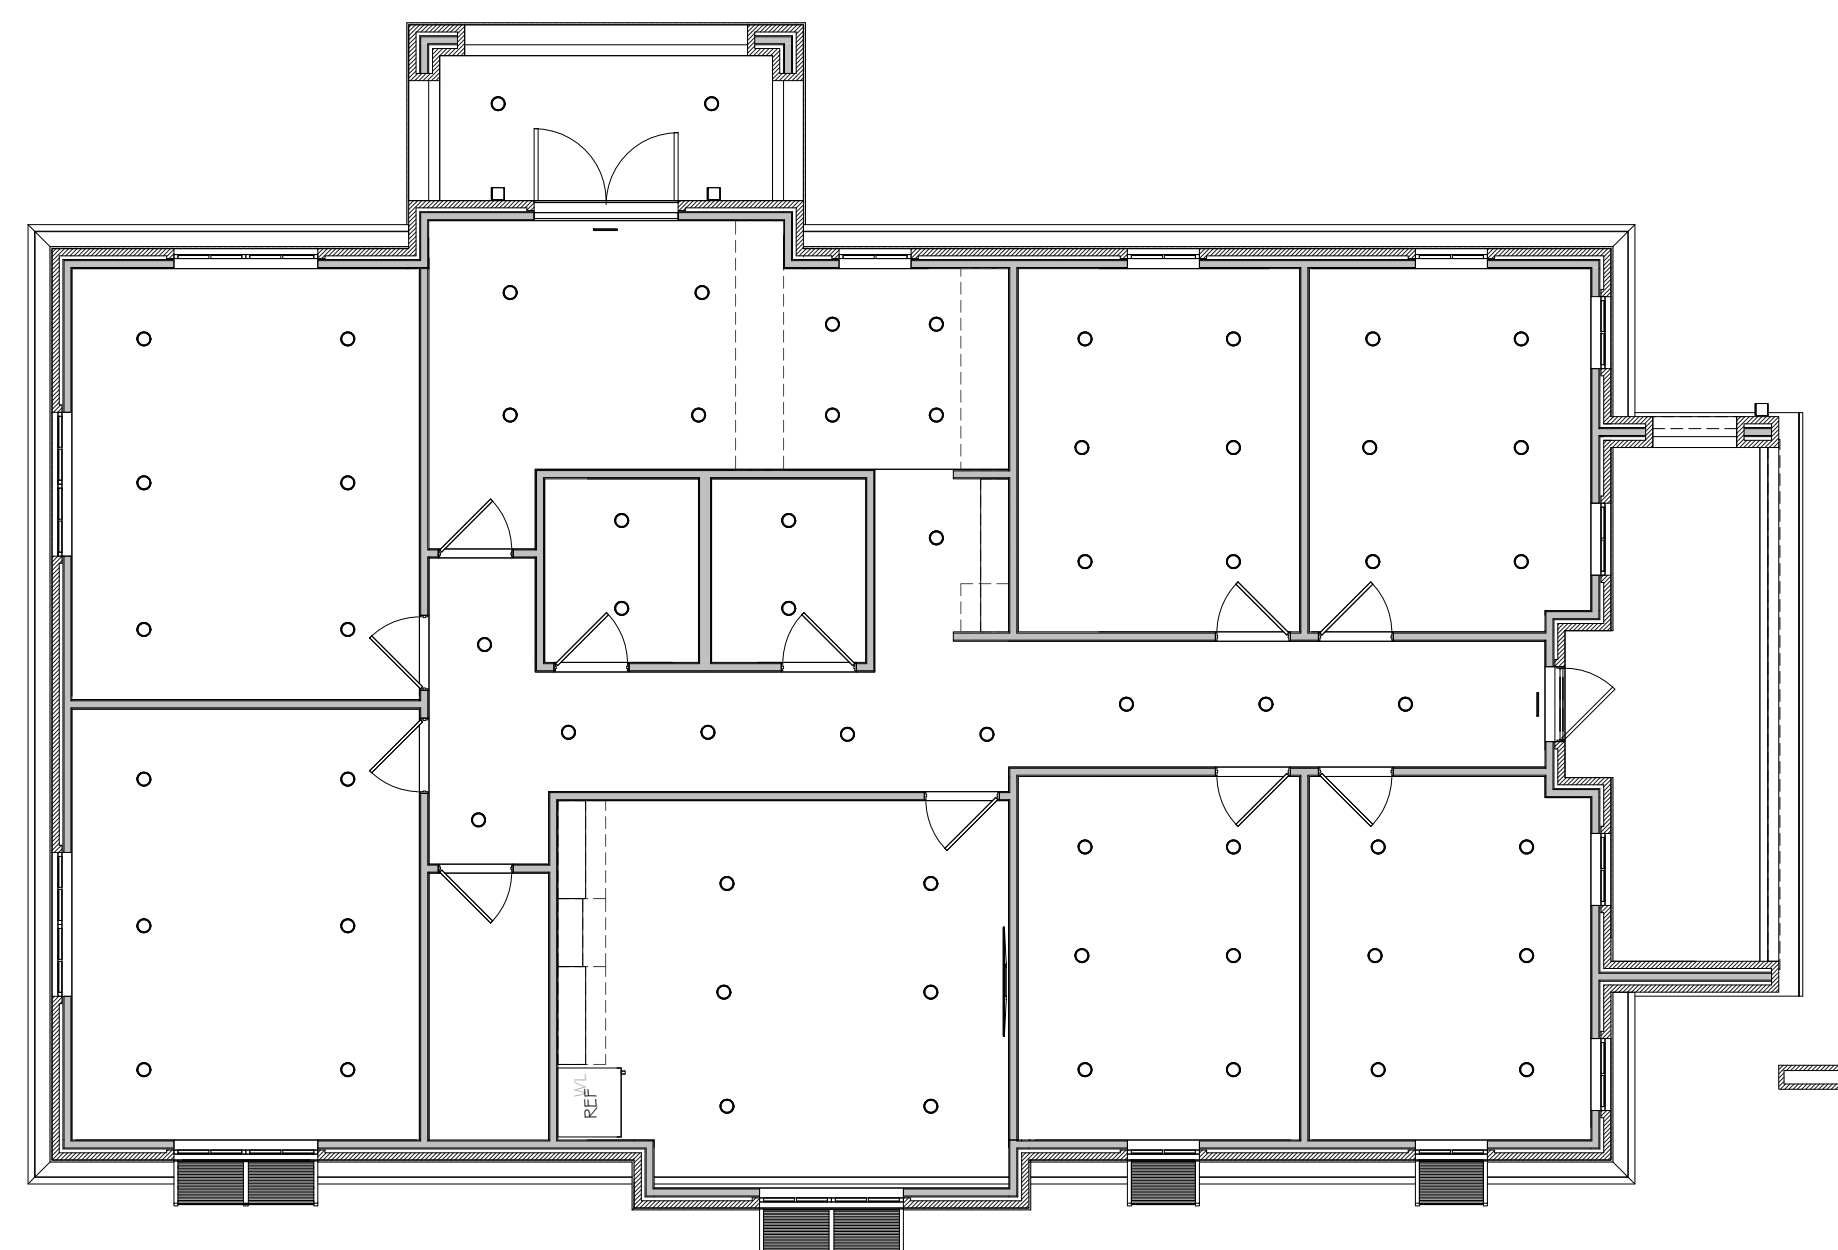

1 1ST FLOOR REFLECTED CEILING PLAN

SCALE: 0" = 1'-0" 8'

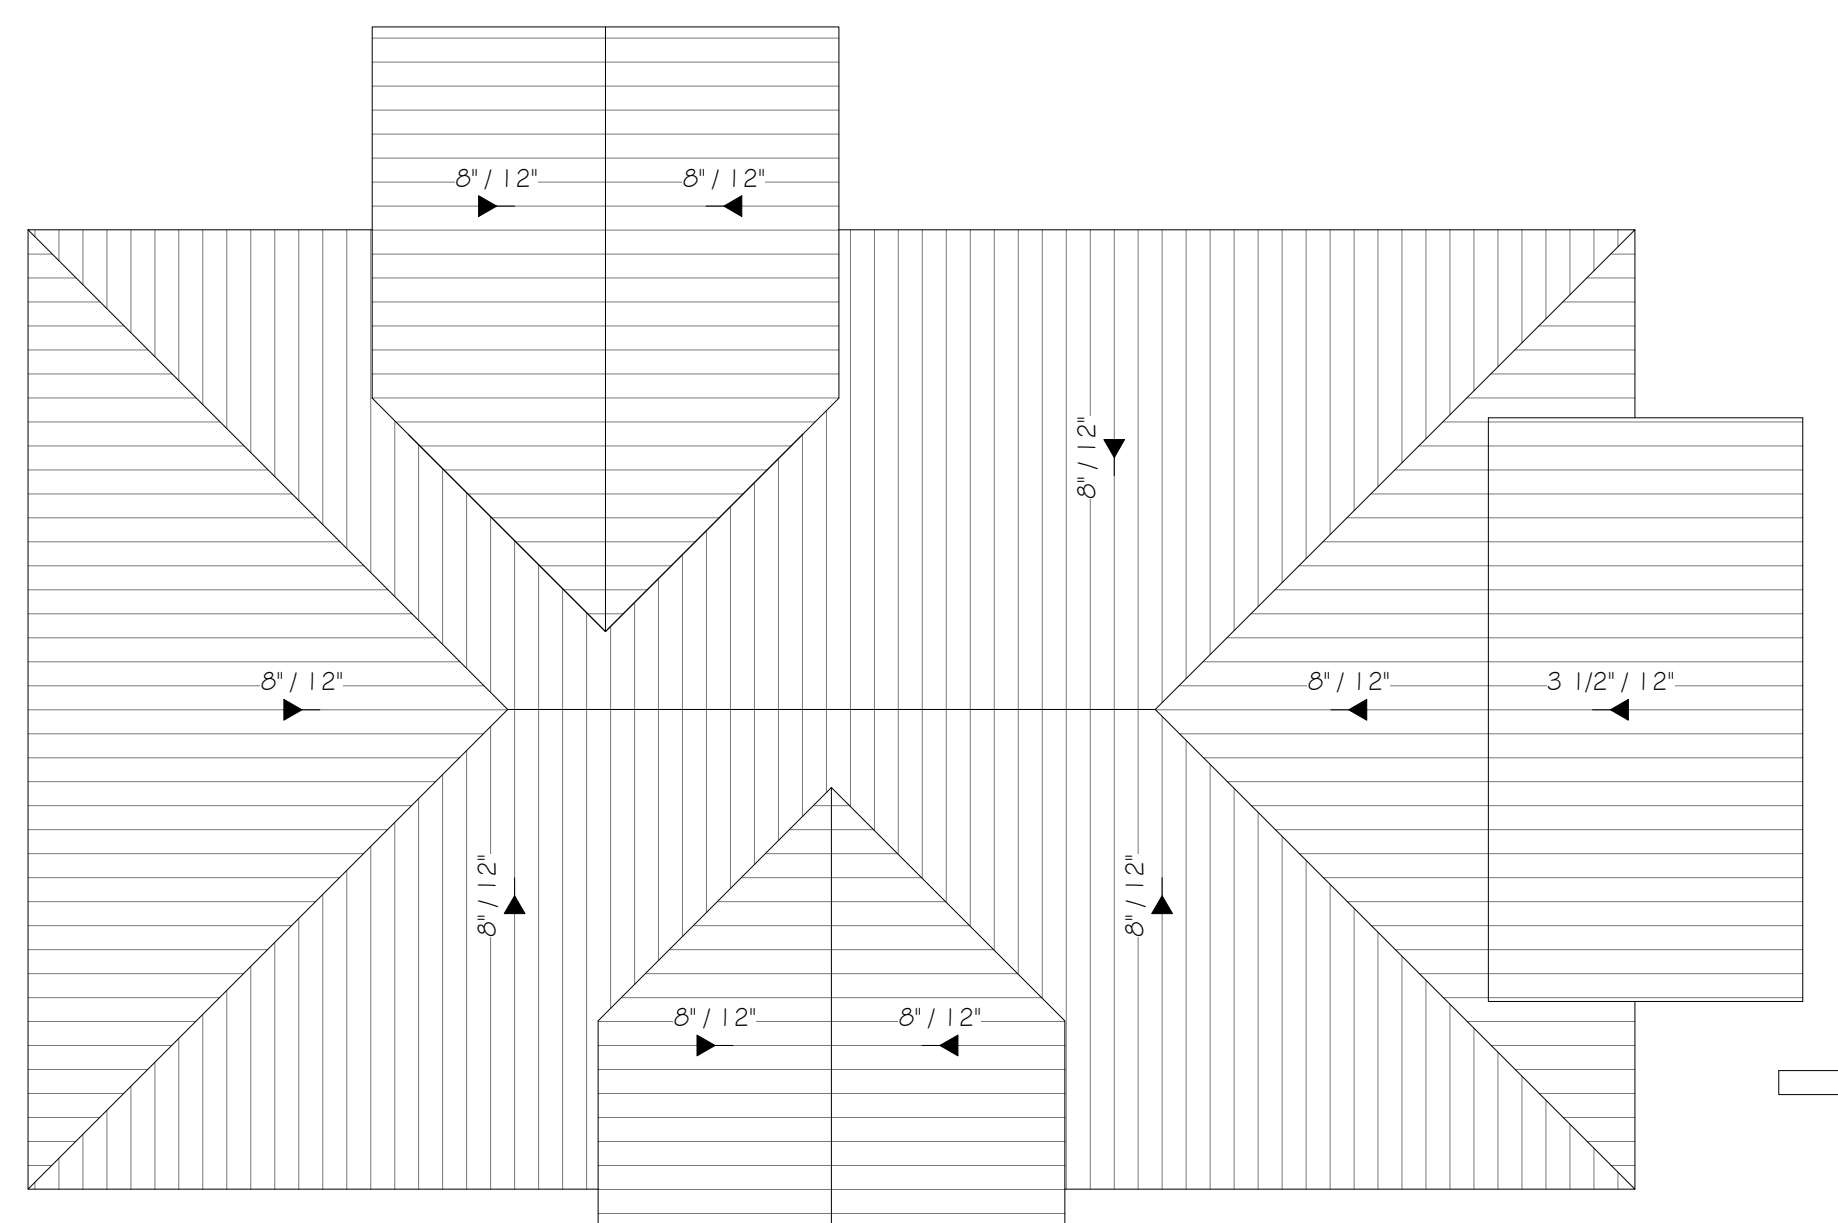

2 ROOF PLAN
1/8" = 1'-0"
SCALE: 0'

ALL RIGHTS RESERVED

ANY UNAUTHORIZED COPYING
AND/OR REPRODUCTION IS
STRICTLY PROHIBITED & MAY
CONSTITUTE A VIOLATION OF THE
COPYRIGHT LAWS OF THE UNITED
STATES FOUND IN TITLE 17 OF
THE UNITED STATES CODE. VIOLATION
OF THOSE LAWS MAY RESULT IN
CIVIL FINES AND PENALTIES UNDER
THE LAW

© 2022
MANUEL COMMERCIAL, LLC



MANUEL
COMMERCIAL
ARCHITECTURE + CONSTRUCTION

MANUEL COMMERCIAL
337.427.6100
manuelcommercial.com

A NEW OFFICE FOR:

A NEW OFFICE CAL CHLOR

33304 KALISTE SALOOM RD.
LA FAYETTE PARISH, LA 70508
INSIDE CITY LIMITS

SCHEMATIC


REVISION SCHEDULE		
NO.	DESCRIPTION	DATE

DATE: 12-14-2022


FIRST & SECOND FLOOR
REFLECTED CEILING &
ROOF PLANS

SHEET
A-2.6


PRINTED: 12/14/2022 5:35:33 PM

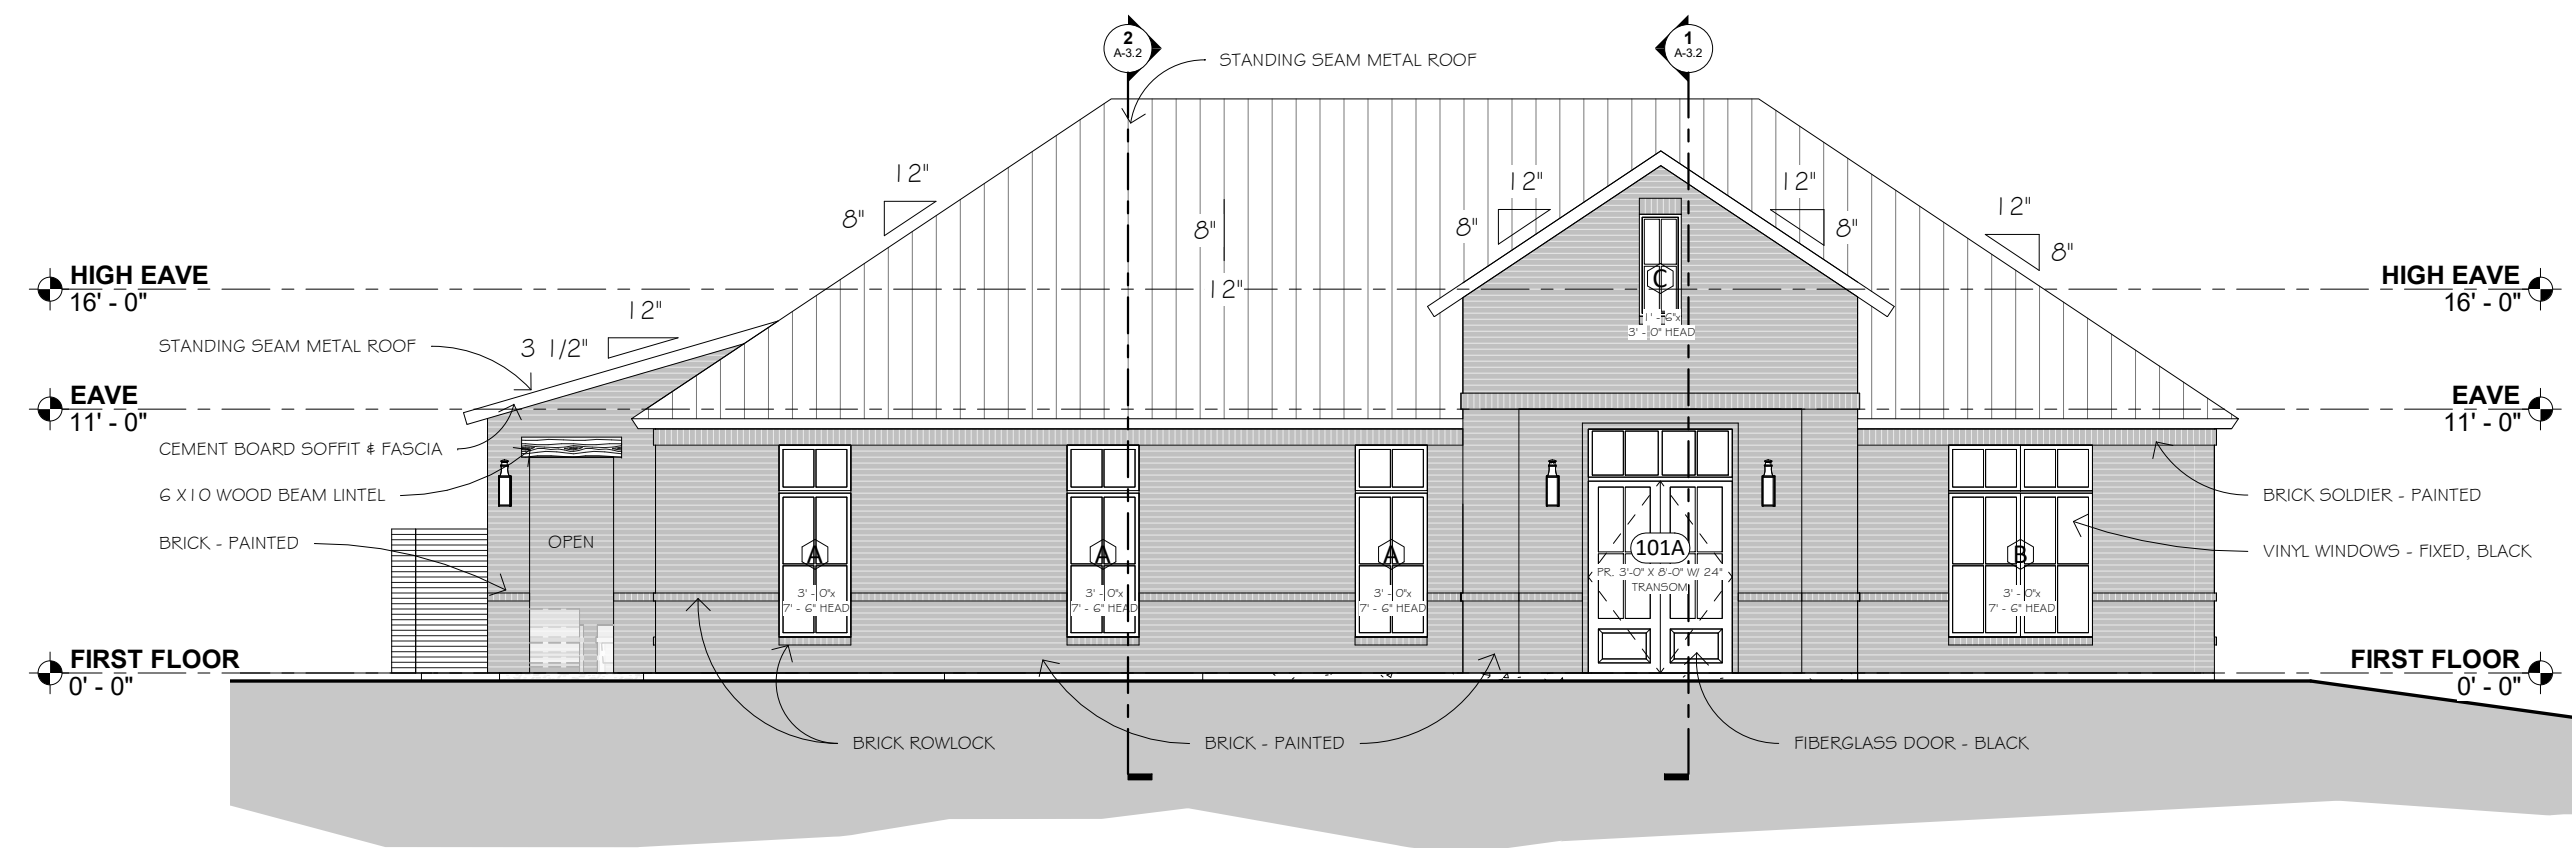


1 FRONT ELEVATION
SCALE: 1/8" = 1'-0"

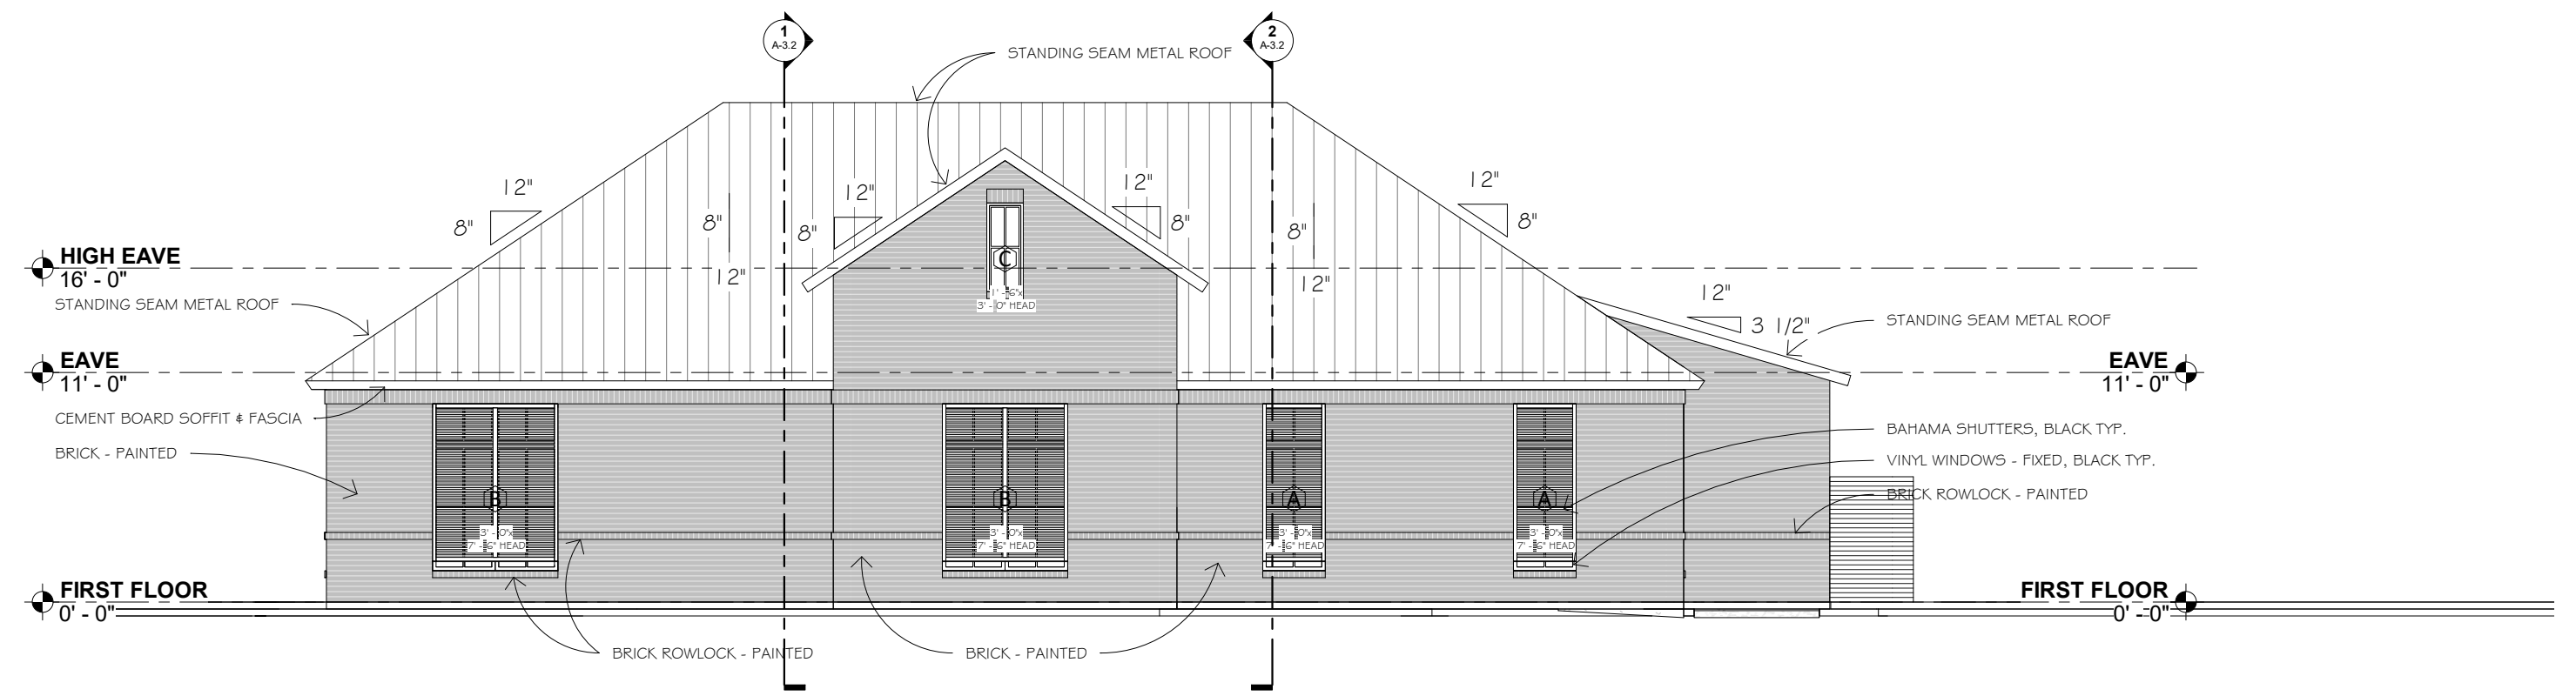


2 REAR ELEVATION
SCALE: 1/8" = 1'-0"

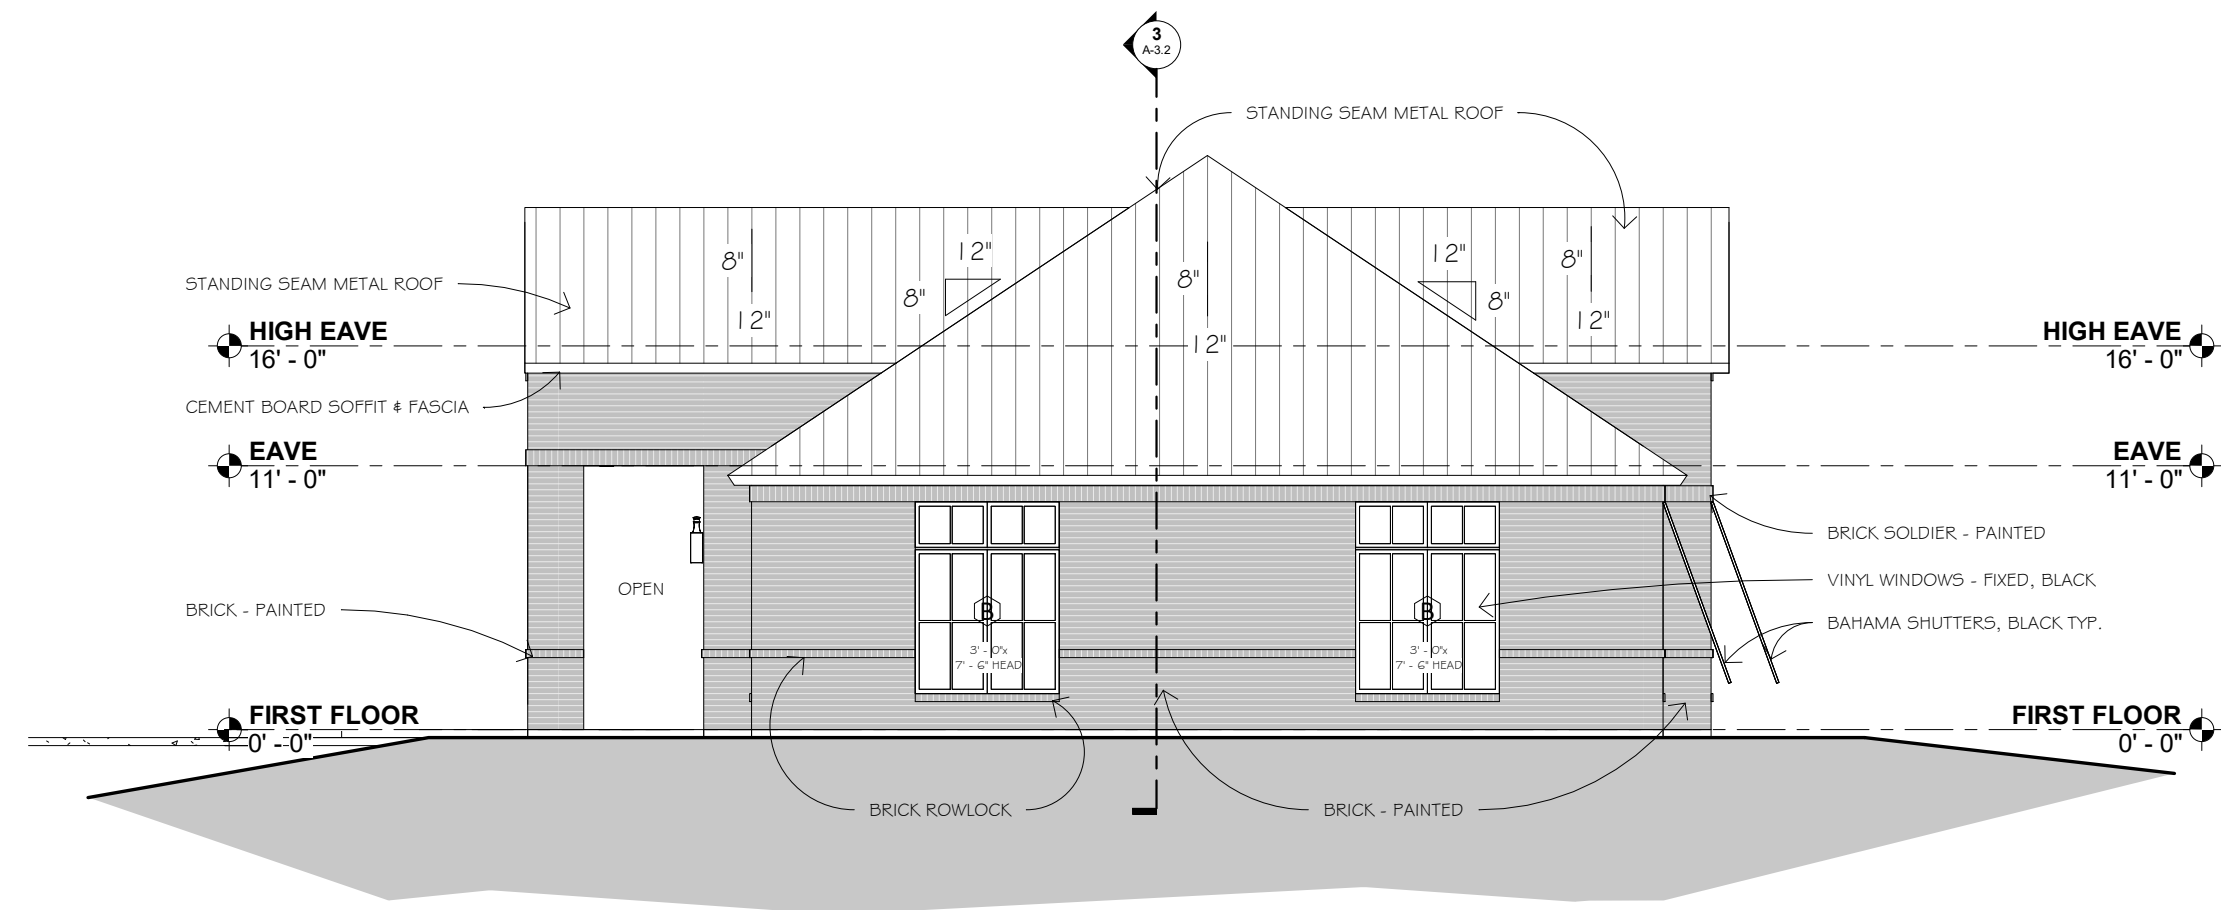

3 RIGHT ELEVATION
SCALE: 1/8" = 1'-0"

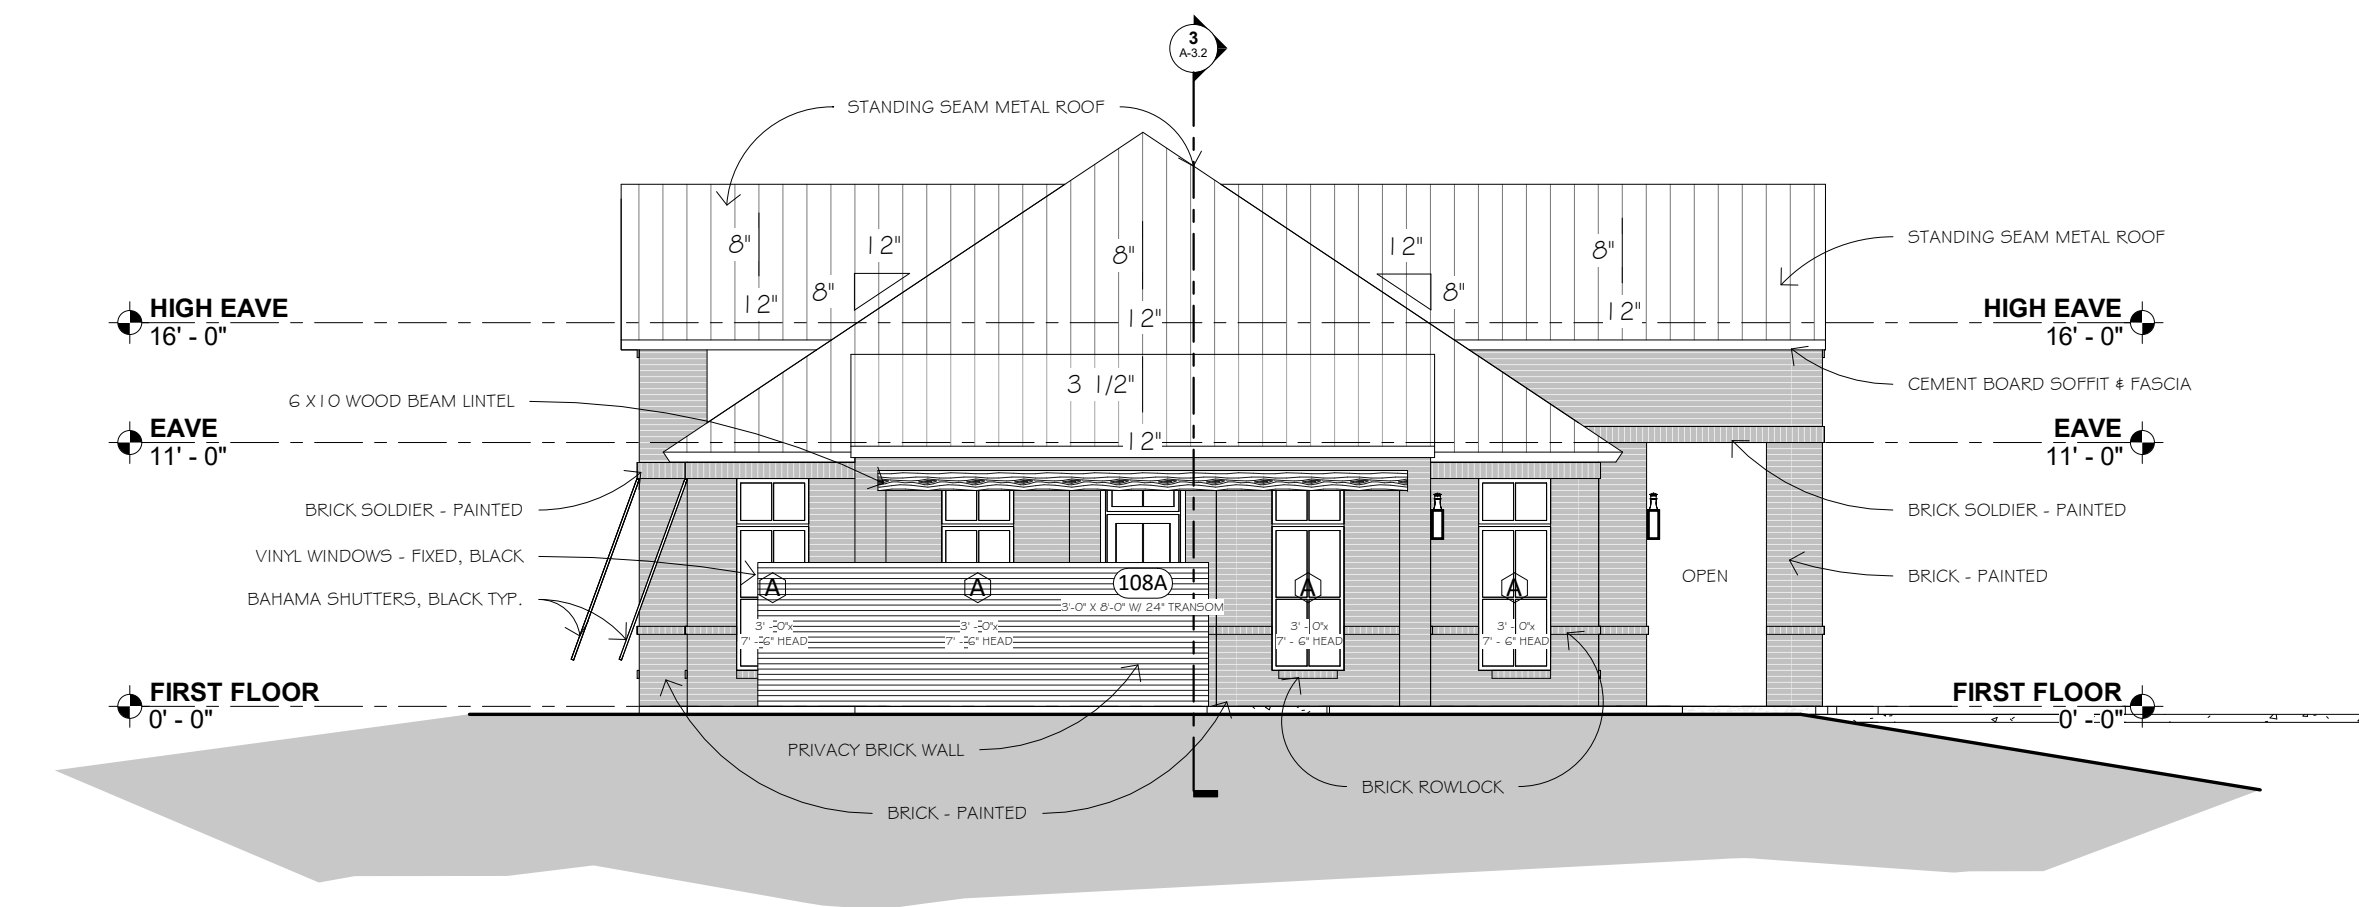


4 LEFT ELEVATION
SCALE: 1/8" = 1'-0"

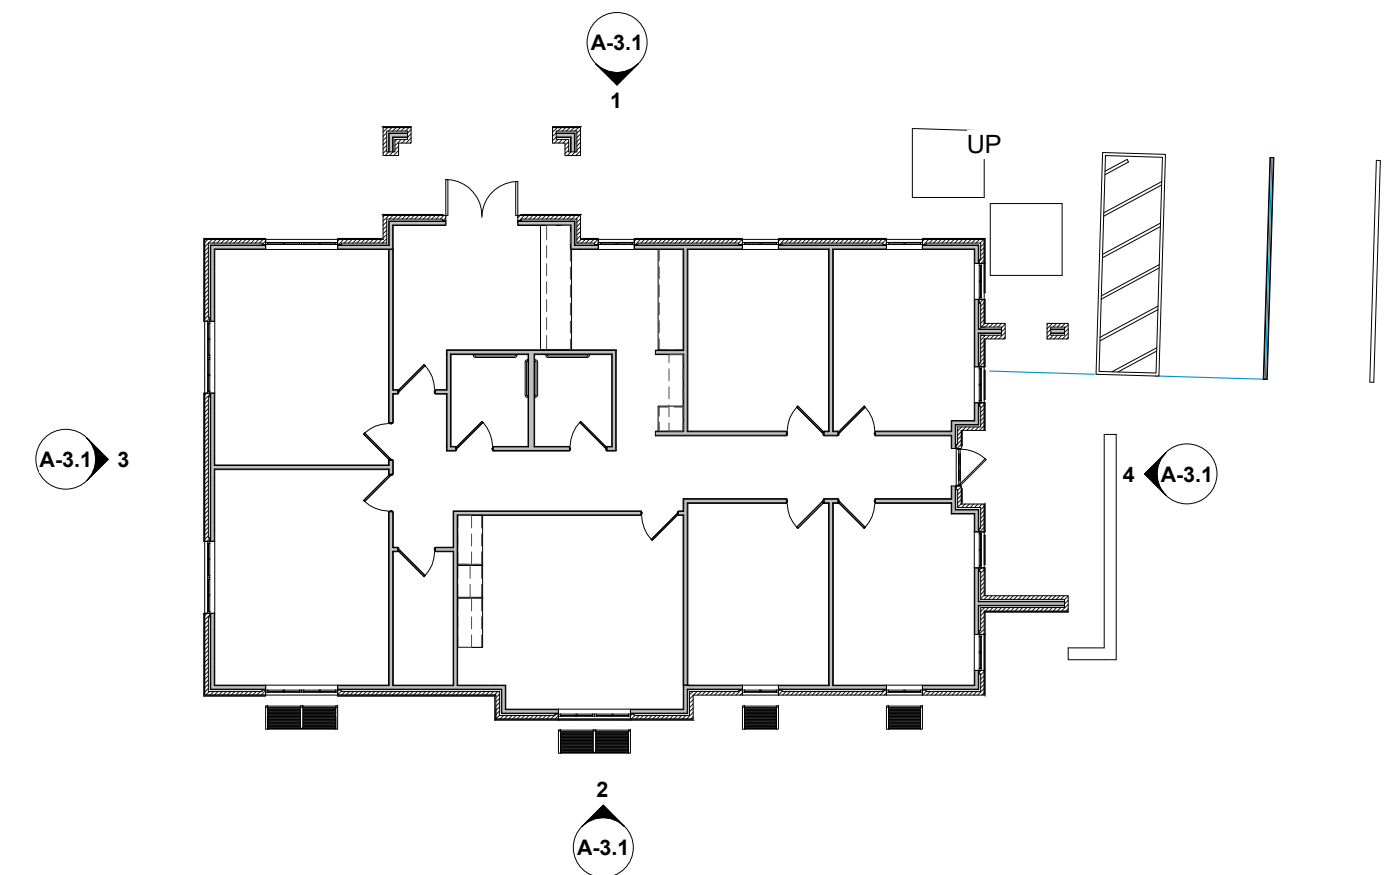




1 LONGITUDINAL BUILDING SECTION
SCALE: 0" = 1/8" = 1'-0"

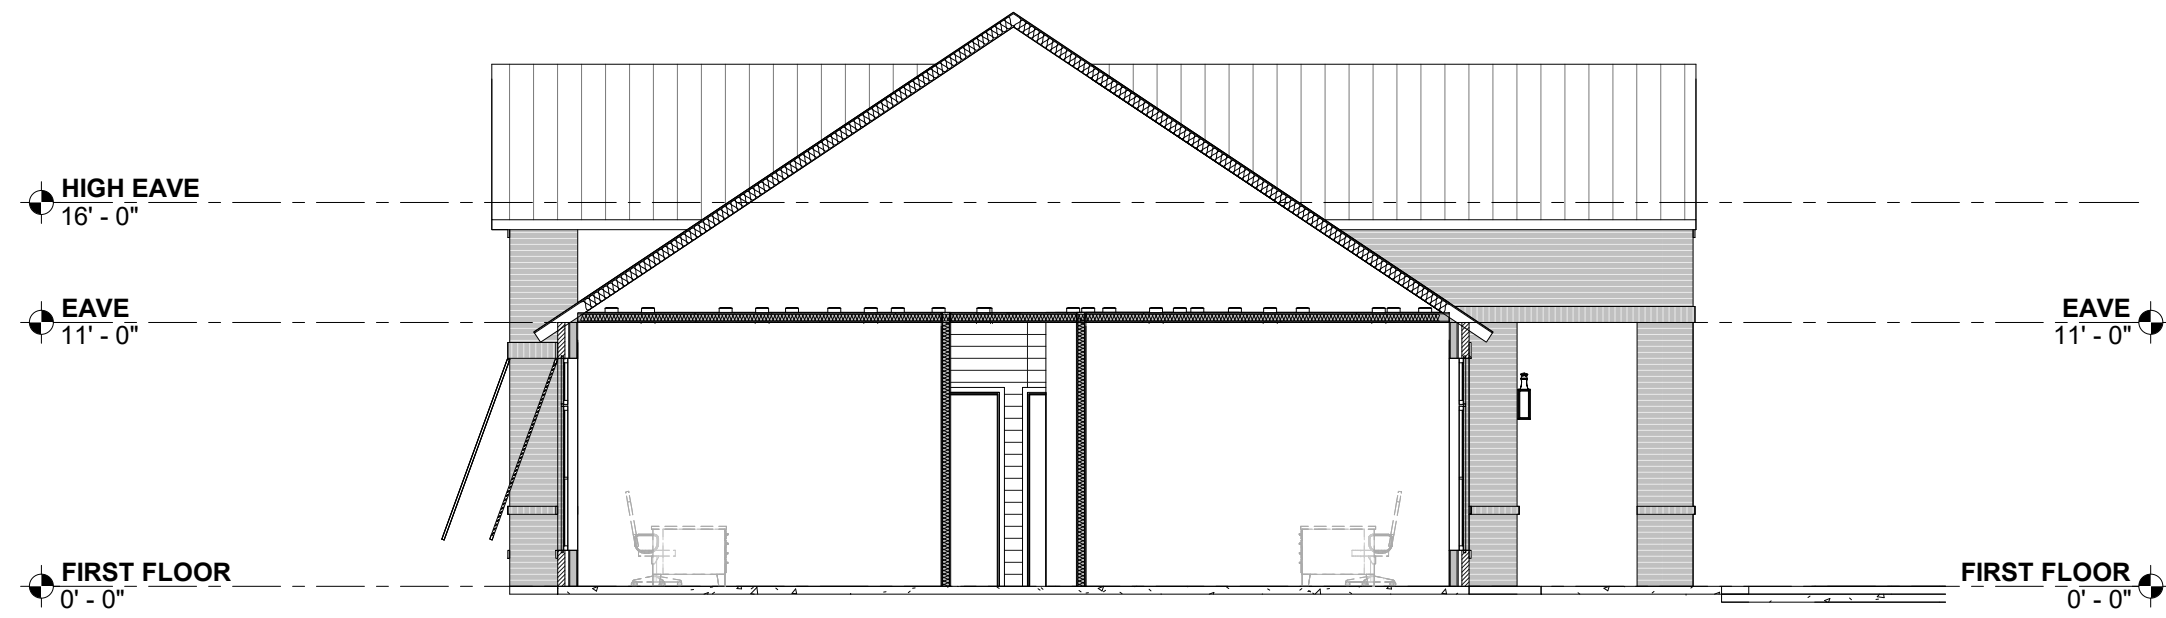

2 LONGITUDINAL BUILDING SECTION1
SCALE: 0" = 1/8" = 1'-0"

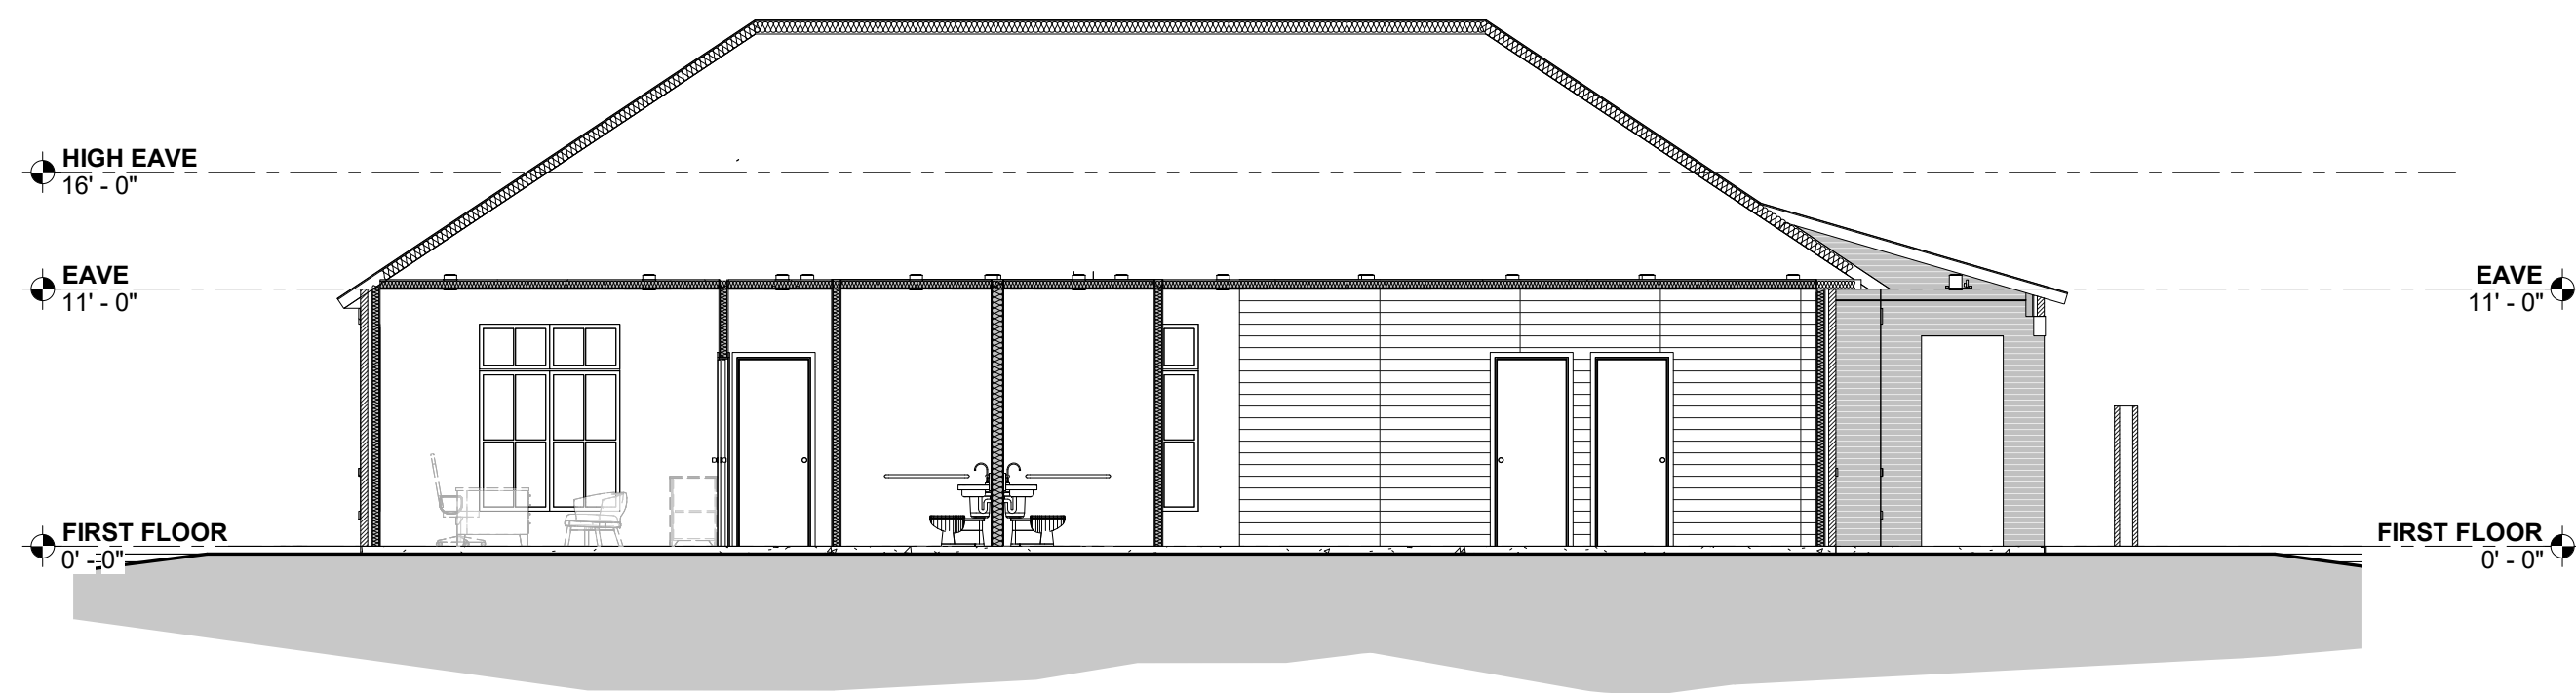

3 TRANSVERSE BUILDING SECTION
SCALE: 0" = 1/8" = 1'-0"

