



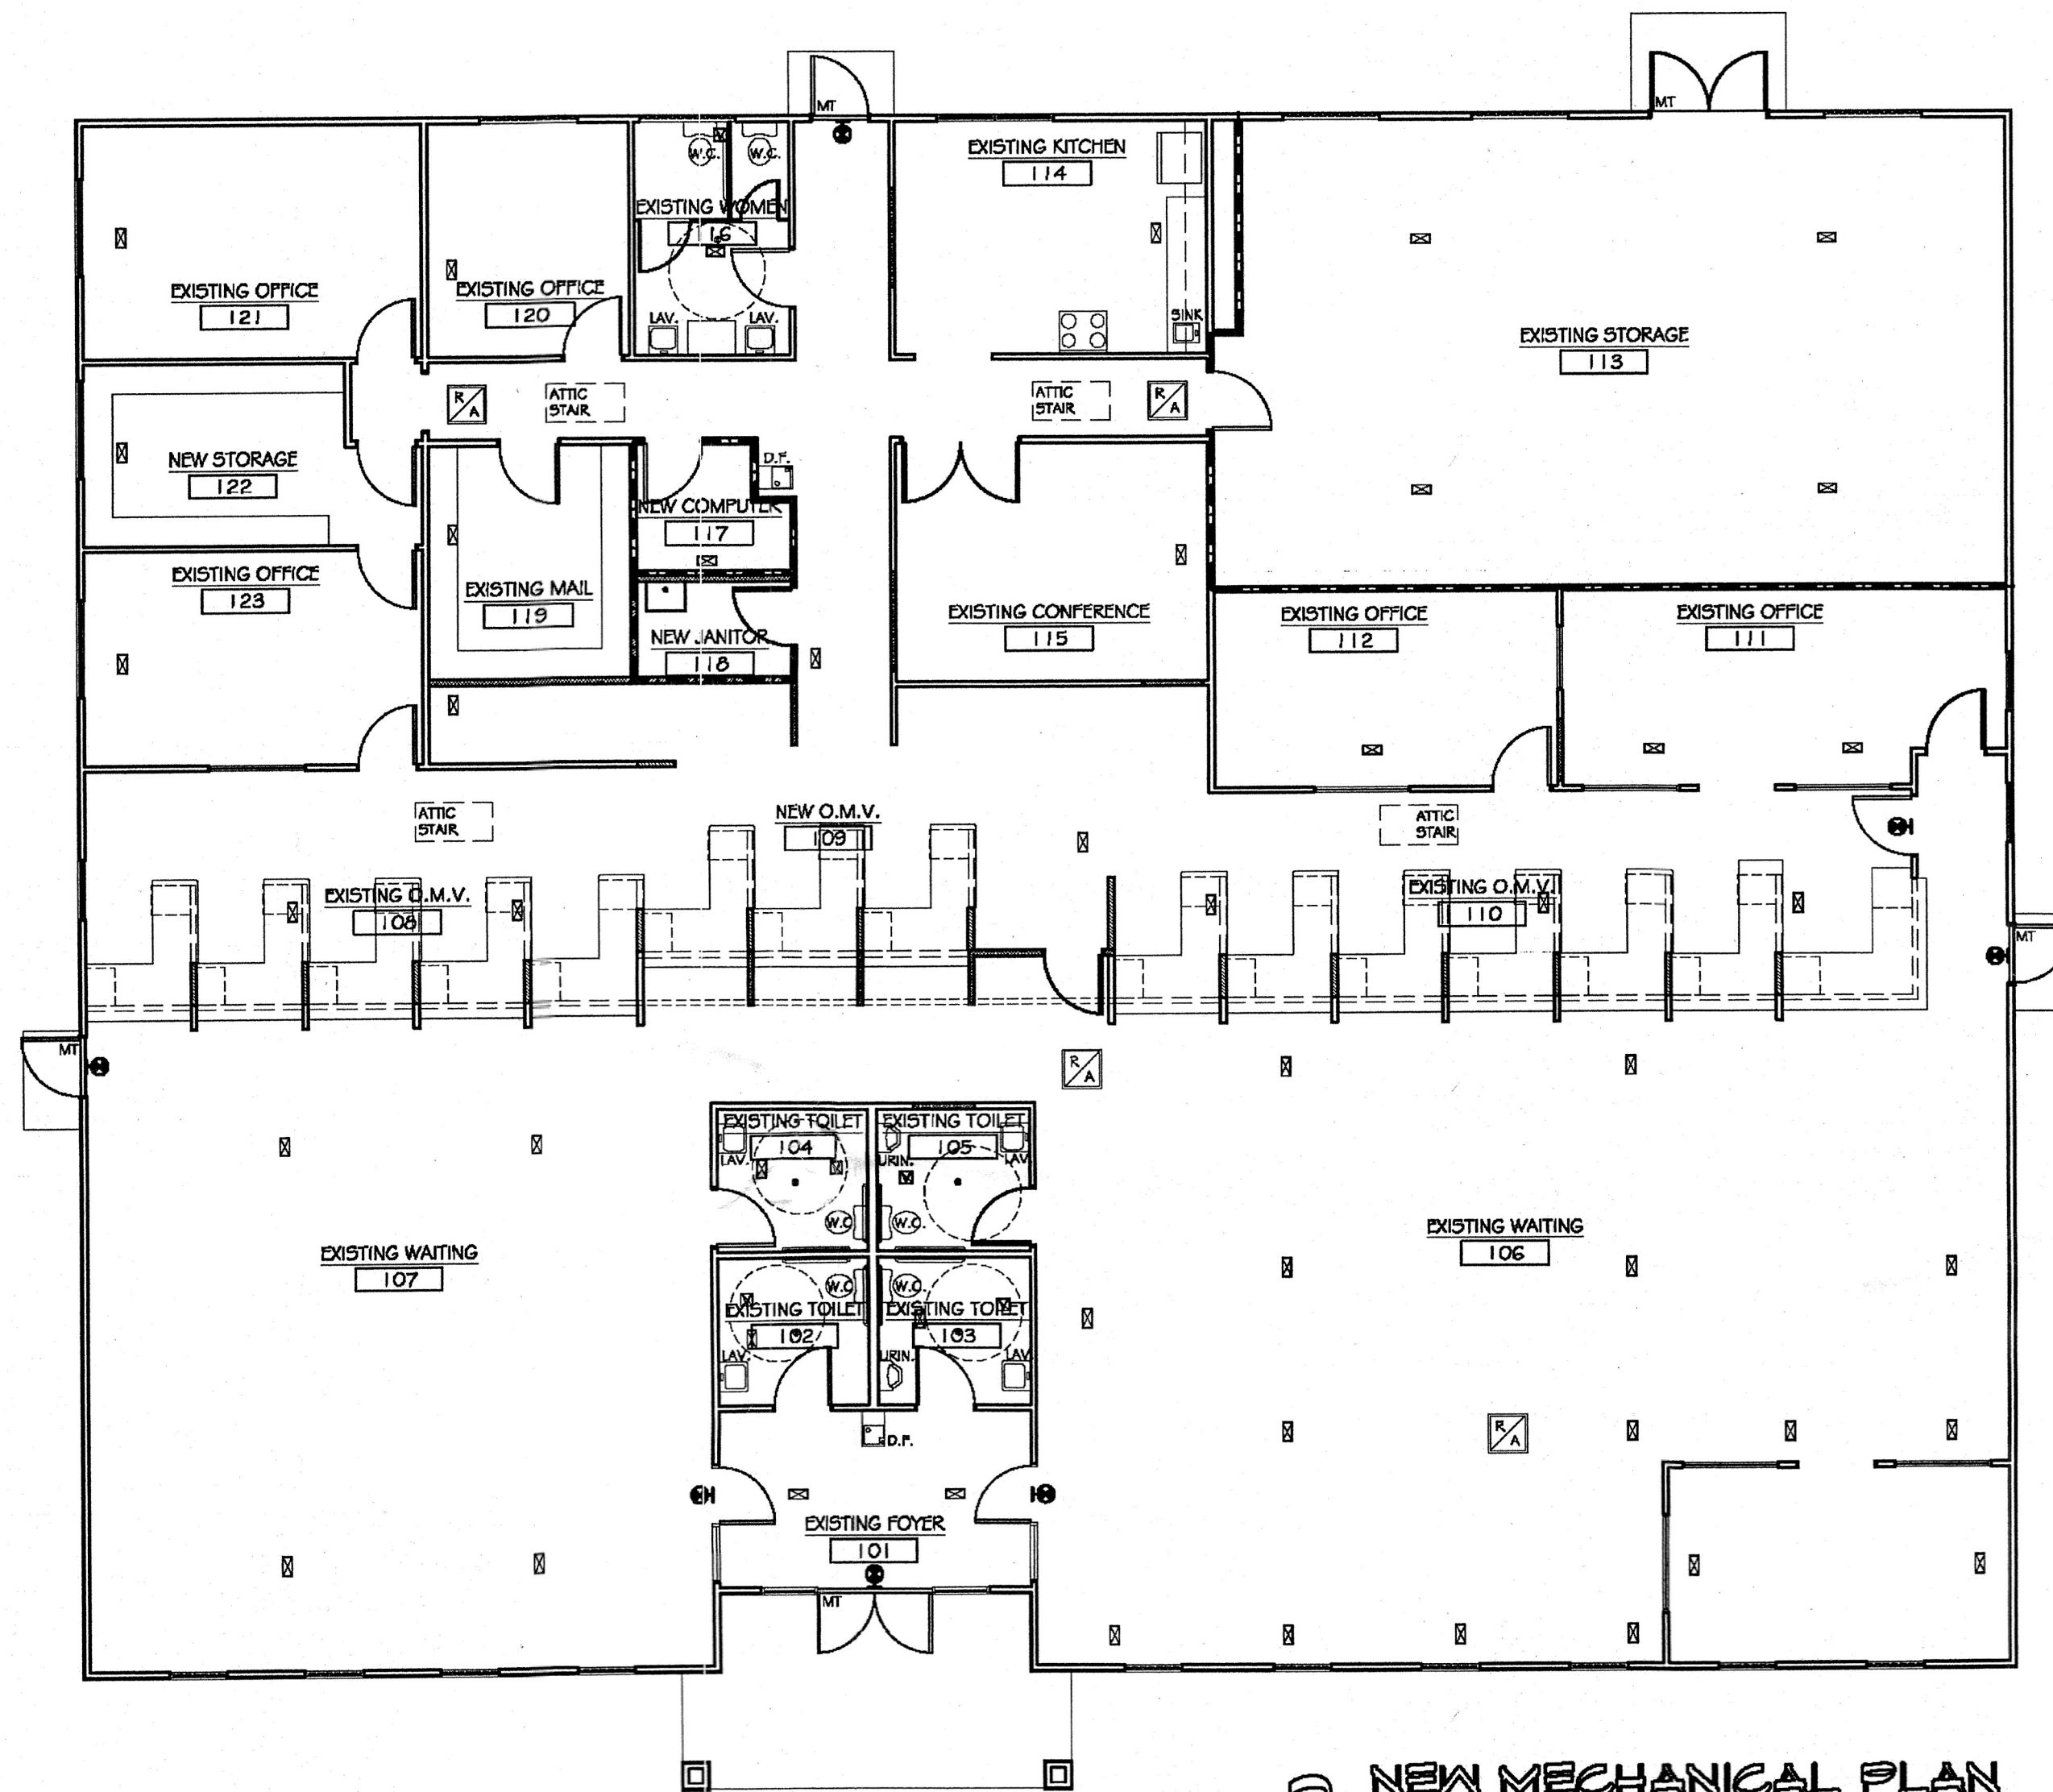

2. NEW MECHANICAL PLAN
SCALE: 1/8" = 1'-0"


NO WORK REQUIRED FOR HVAC SYSTEM

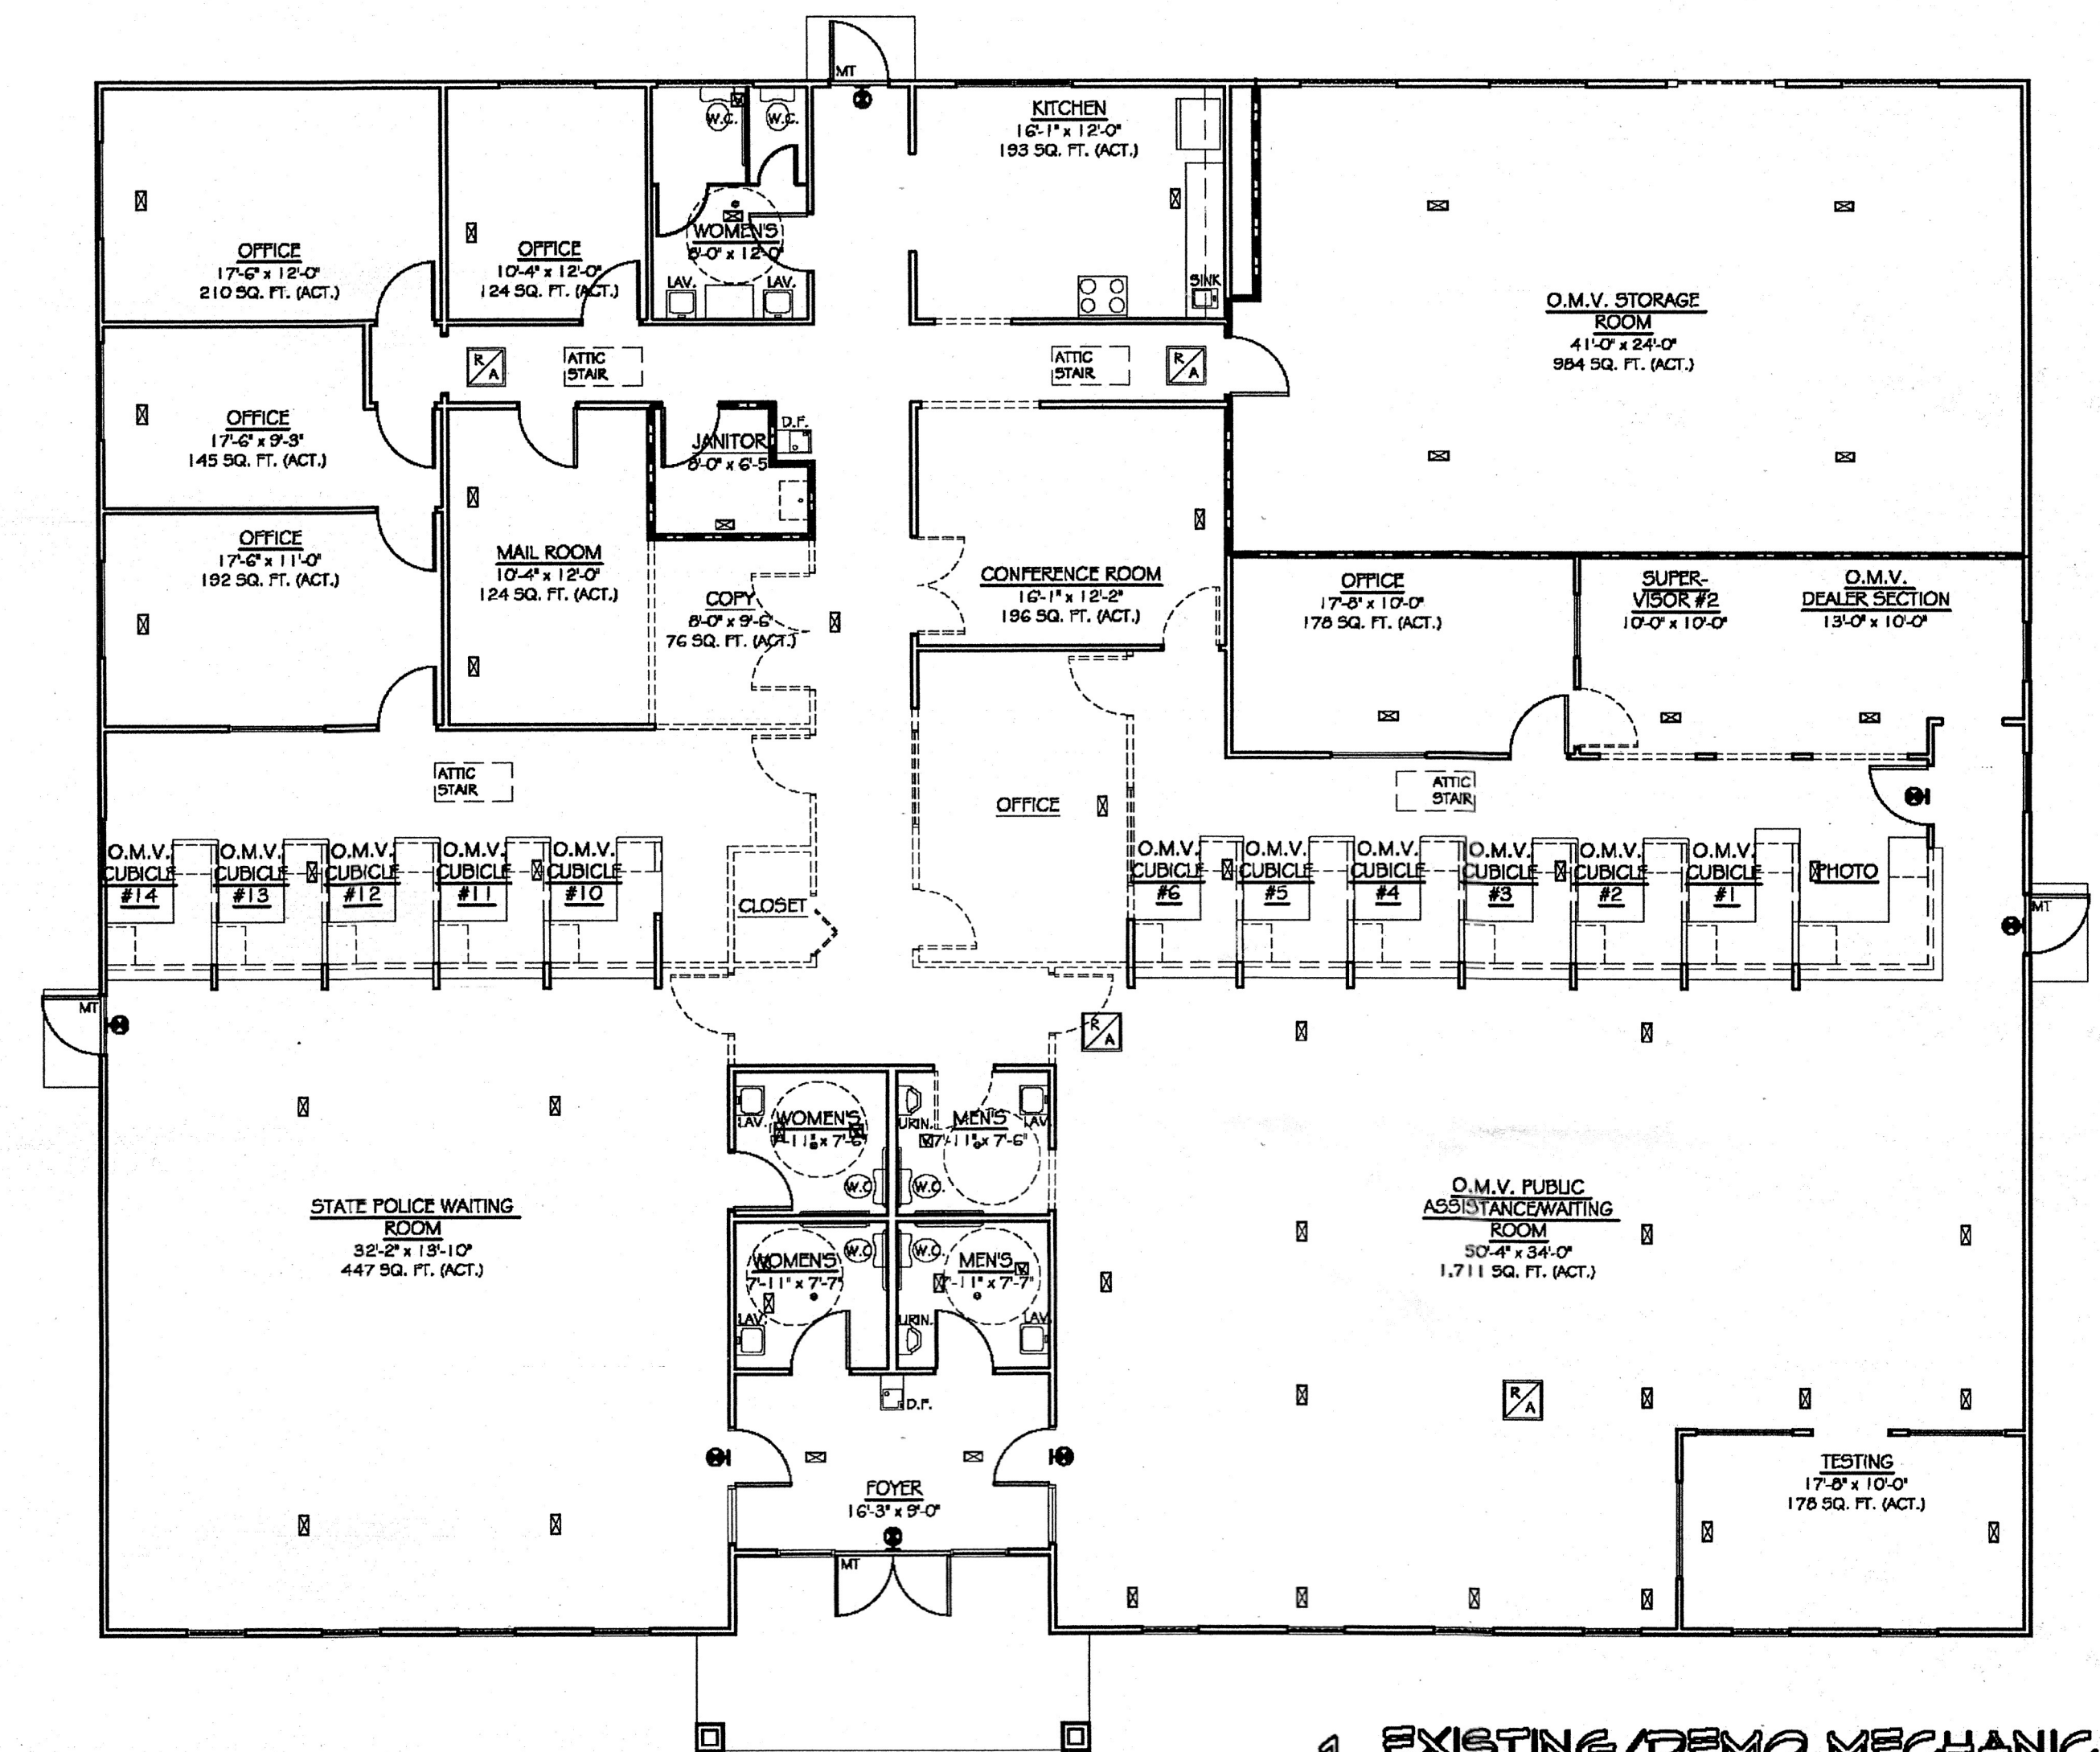

1. EXISTING/DEMO MECHANICAL PLAN
SCALE: 1/8" = 1'-0"

"FOR STATE LEASE USE"
SEE SHEET A1.2 FOR FULL NOTES

project 8307
date 8/15/08
revisions

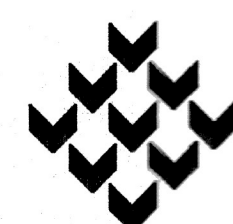

Piazza Architecture • Planning
Mandeville Louisiana



P.A.P. © 2008

RENOVATIONS FOR
OFFICE OF MOTOR VEHICLES
SOLICITATION RL-744-A
1514 LINDBERG
SLIDELL • LOUISIANA

sheet

M2.1

of