


M & E CONSULTING, INC. (337) 234-7474 DATE: DEC 05, 2003 TIME: 9:13 AM

MECHANICAL SITE PLAN
SCALE: 1" = 20'-0"

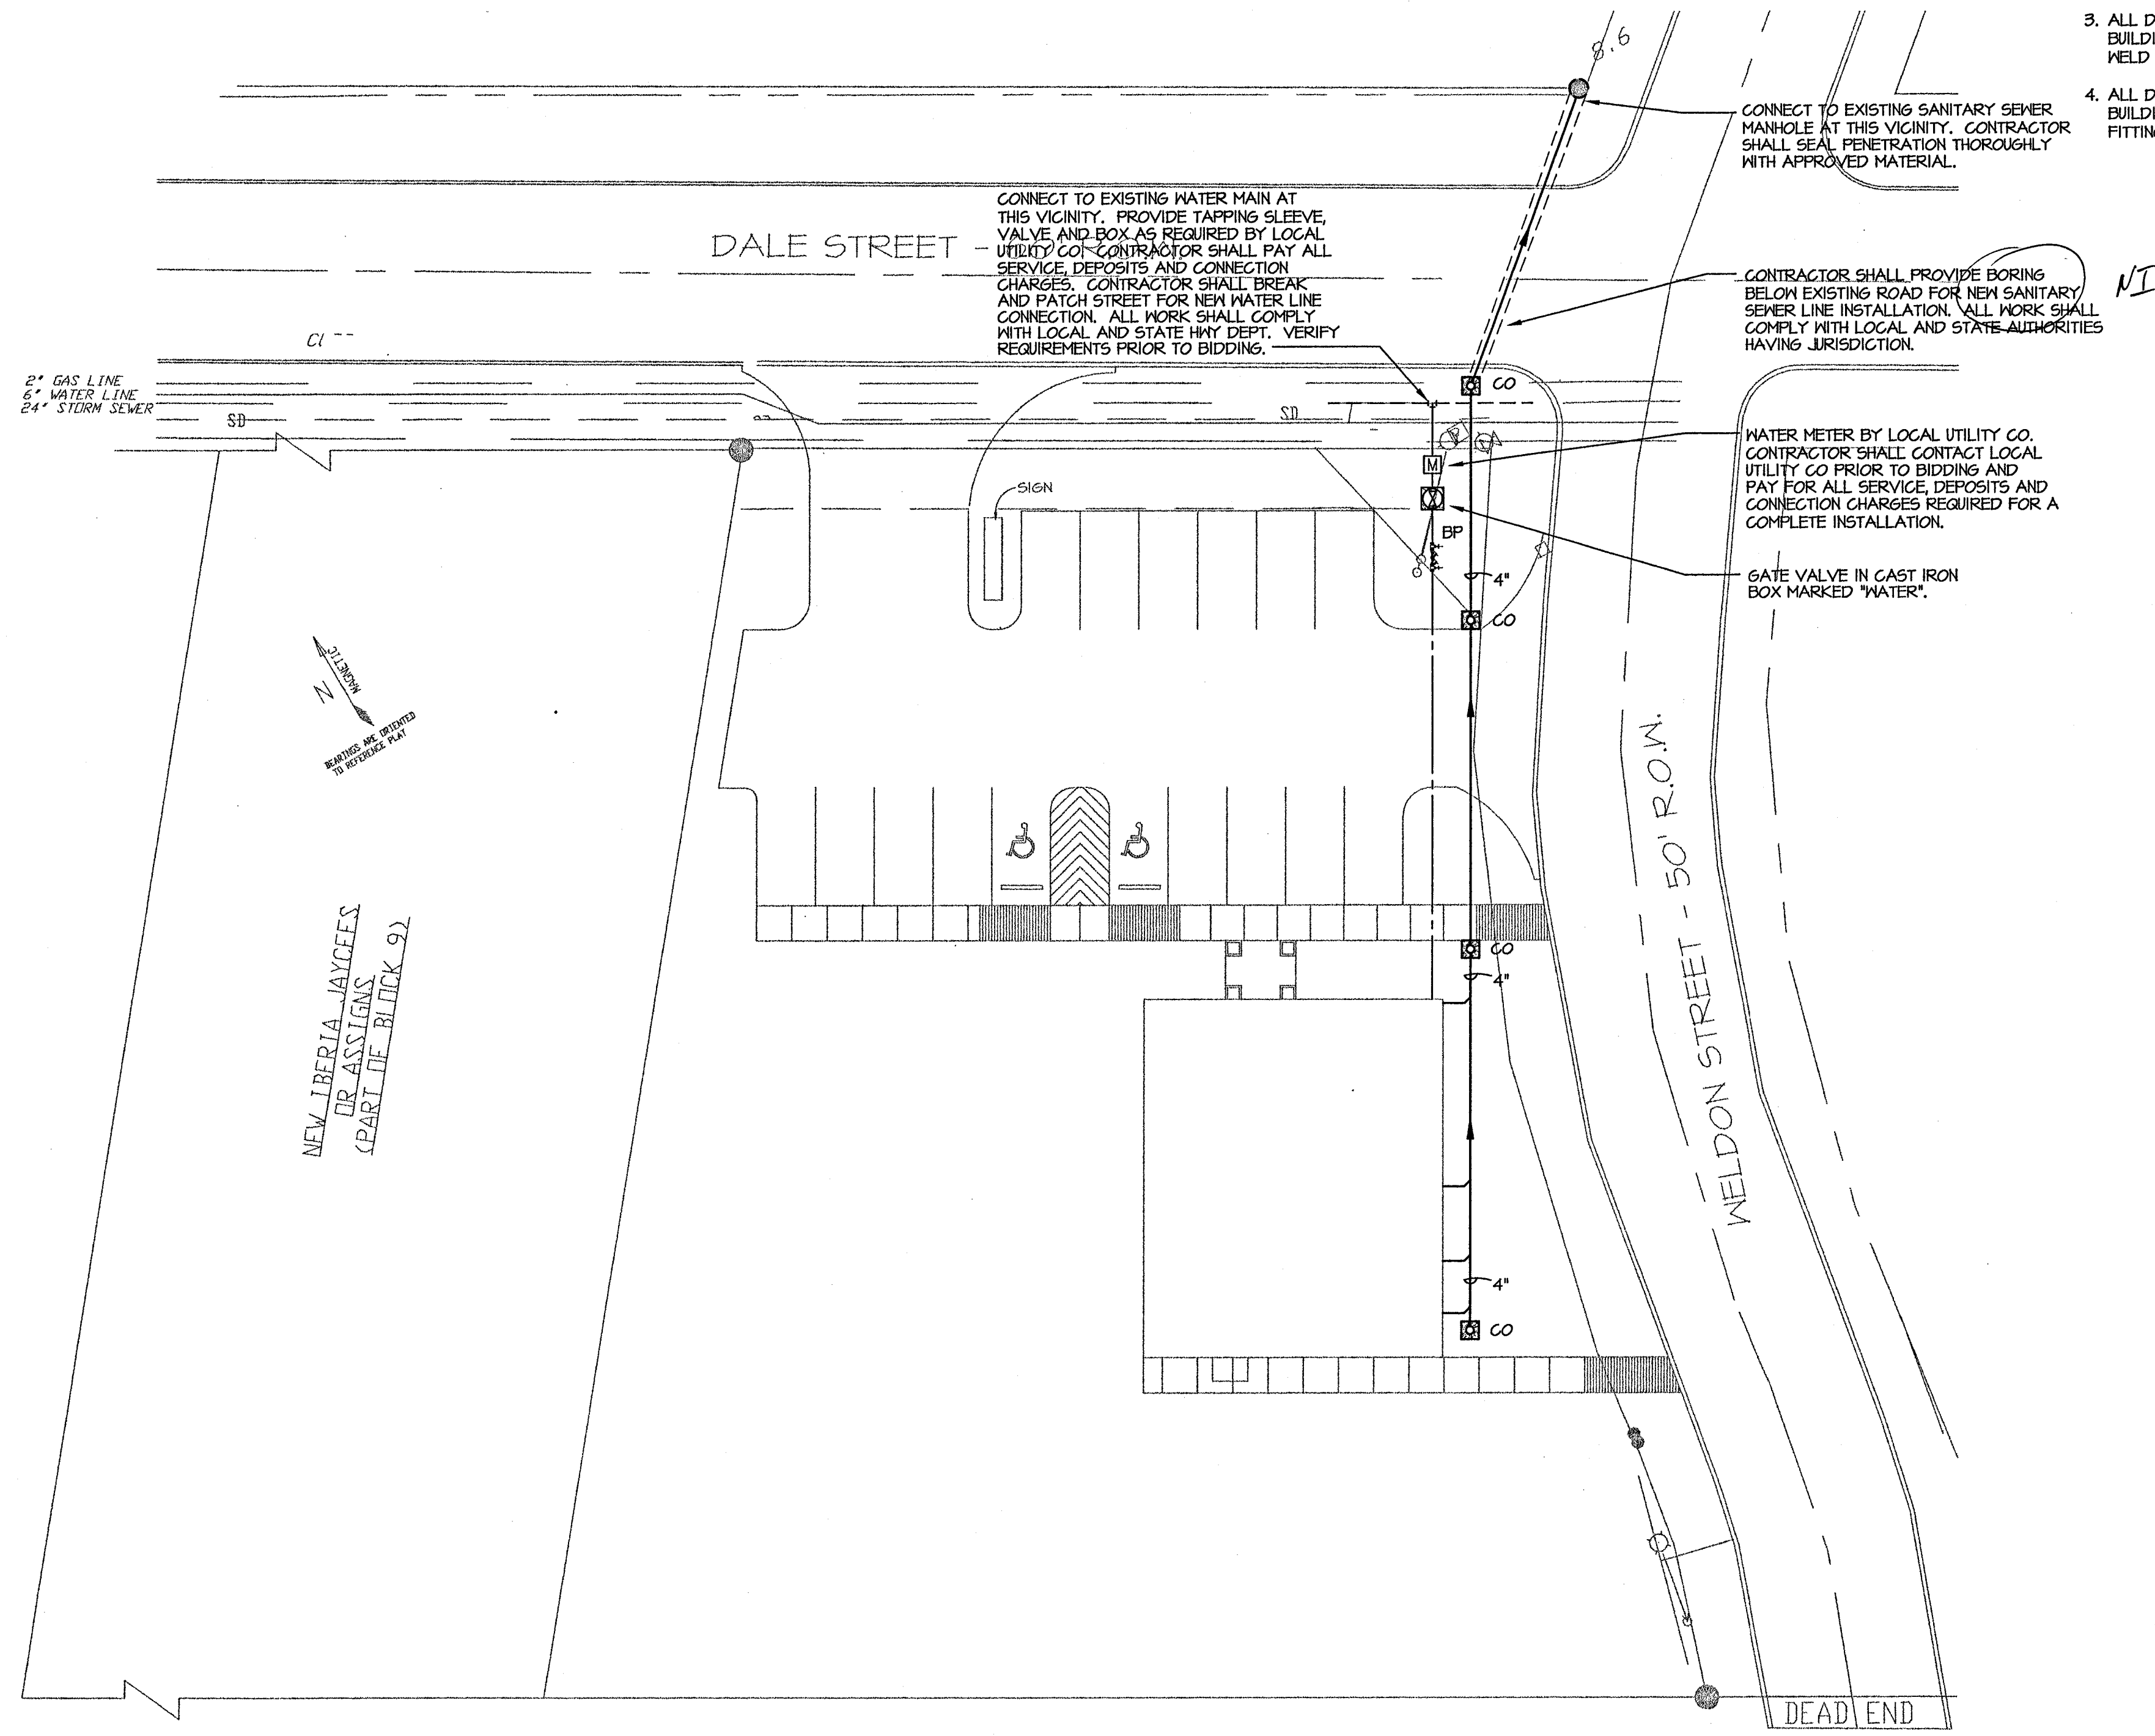

SITE NOTES:

1. CONTRACTOR SHALL VERIFY EXISTING SEWER AND WATER CONNECTION PRIOR TO ANY INSTALLATION. VERIFY ALL SEWER INVERTS PRIOR TO ROUGH-IN.
2. ALL SANITARY SEWER PIPE AND FITTINGS ON THE EXTERIOR OF THE BUILDING SHALL BE SCHEDULE 40 PVC-DWV WITH SOLVENT WELD JOINTS.
3. ALL DOMESTIC WATER PIPING AND FITTINGS ON THE EXTERIOR OF THE BUILDING BELOW GRADE SHALL BE SCHEDULE 40 PVC WITH SOLVENT WELD JOINTS.
4. ALL DOMESTIC WATER PIPING AND FITTINGS ON THE EXTERIOR OF THE BUILDING ABOVE GRADE SHALL BE TYPE 'L' HARD COPPER PIPE AND FITTINGS WITH SILVER SOLDER JOINTS.

M & E CONSULTING, INC.
A PROFESSIONAL ENGINEERING CORP.
1904 BERTRAND DRIVE SUITE A8
LAFAYETTE, LOUISIANA 70508
(337)234-7474 FAX (337)234-7774
PROJECT No.: 03055.00

DATE
12/14/2003

03343
JOB NO.

A NEW RETAIL FACILITY
FOR
ARMENTOR JEWELERS
CORNER OF WELDON ST. & DALE ST. NEW IBERIA, LOUISIANA

A.O. architect
205 VALLEY VIEW DRIVE
LAFAYETTE, LA. 70501
337 237-3300

SHEET
M-1

7
15