
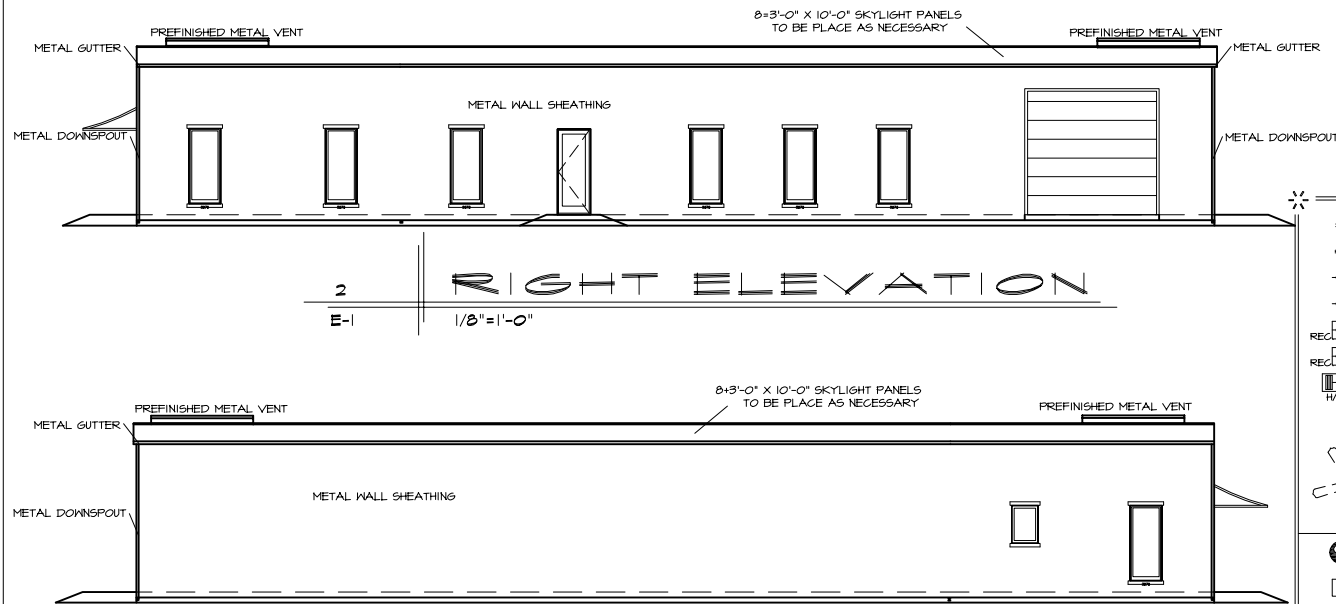


ELECT. SYMBOLS LEGEND	
	SINGLE POLE SWITCH
	THREE WAY SWITCH
	FOUR WAY SWITCH
	PHONE JACK
	INTERNET JACK
	HOSE BIB
	FUEL GAS
	EMERGENCY LIGHTING
	FLORESCENT LIGHTING
	STROBE
	EXIT EXIT SIGN

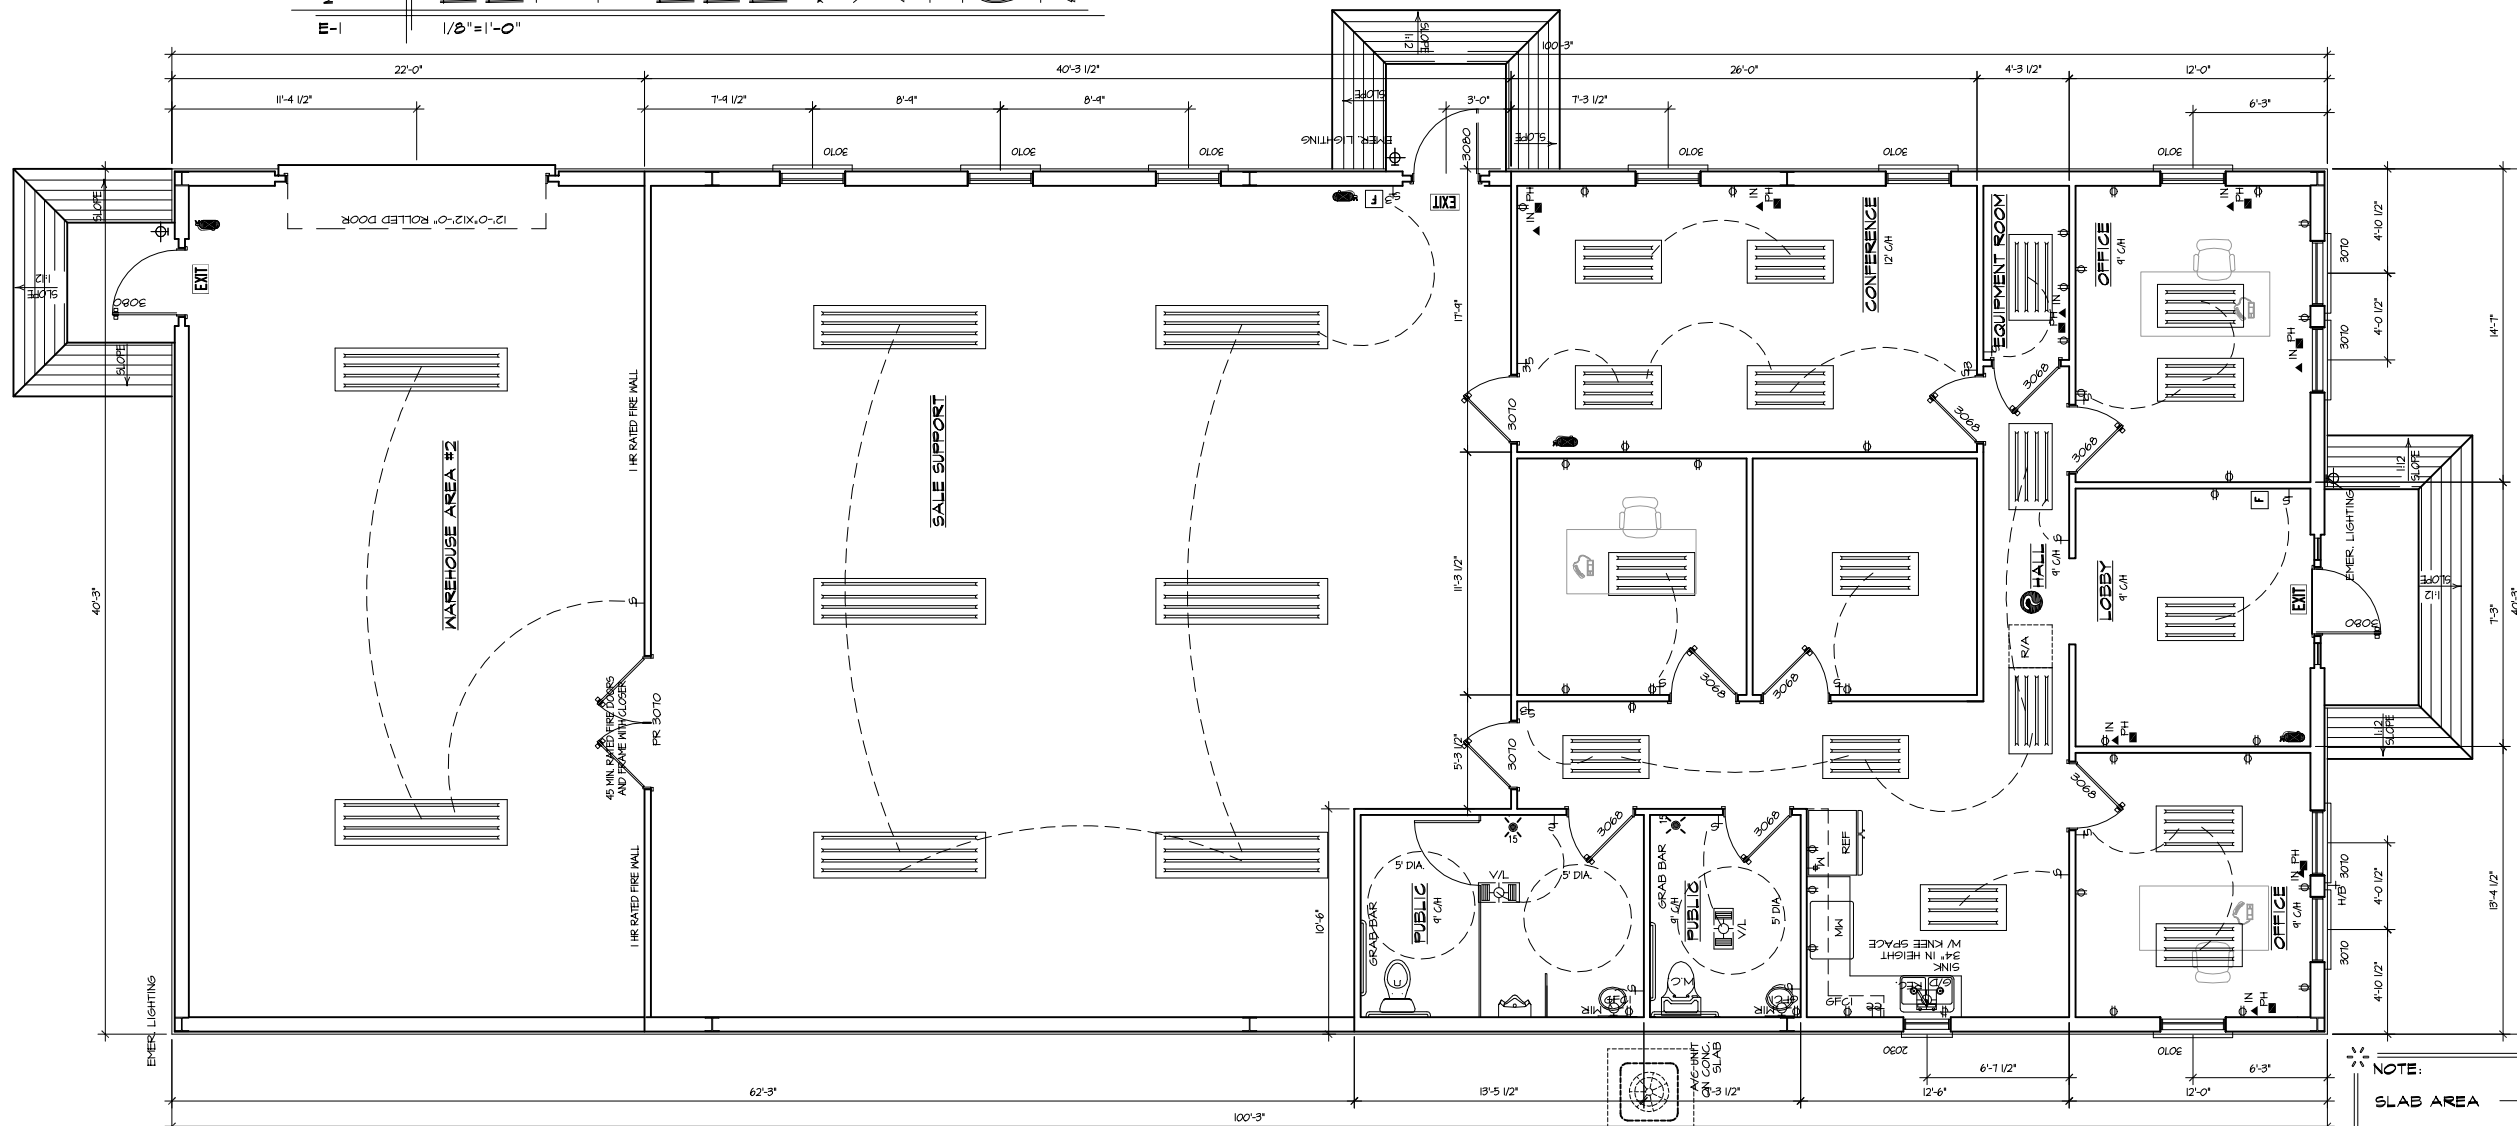

NOTE:	
SLAB AREA	4035
OFFICE AREA	1605
SALES SUPPORT	1545
WAREHOUSE AREA	885

Revisions:

Revised By:



FLOOR PLAN & ELEVATIONS
Randy Lolley
228 JARED DRIVE
BROUSSARD, LA

PROJECT



THIS DRAWING AND/OR ANY OTHER DRAWING, IN WHOLE OR IN PART, REMAINS THE SOLE PROPERTY OF C.A.D. Unlimited, Inc. ANY MEANS OF REPRODUCTION, WHETHER MECHANICAL OR OTHERWISE IS PROHIBITED, AND ANY VIOLATORS WILL BE PROSECUTED TO THE FULLEST EXTENT OF THE LAW. NO PART OF THIS DRAWING IS TO BE REPRODUCED OR TRANSMITTED IN ANY FORM OR BY ANY MEANS, ELECTRONIC OR MECHANICAL, INCLUDING PHOTOCOPYING, RECORDING, OR BY ANY INFORMATION STORAGE AND RETRIEVAL SYSTEM, WITHOUT THE WRITTEN PERMISSION OF C.A.D. Unlimited, Inc. AUTHORIZED COPYING OR DRAWING IN WHOLE OR IN PART, MAY ONLY BE DONE BY WRITTEN AUTHORIZATION FROM THE OWNER/DESIGNER OF C.A.D. Unlimited, Inc.



100 CANYON RIDGE
LAFAYETTE, LA. 70506
(337) 984-3382
GADDRAFTING1@GDX.NET

NO.:312026FEA

DATE : 1/26/12
SCALE: 1/4"=1'
JOB : DRoger
SHEET : 1 OF 1

