
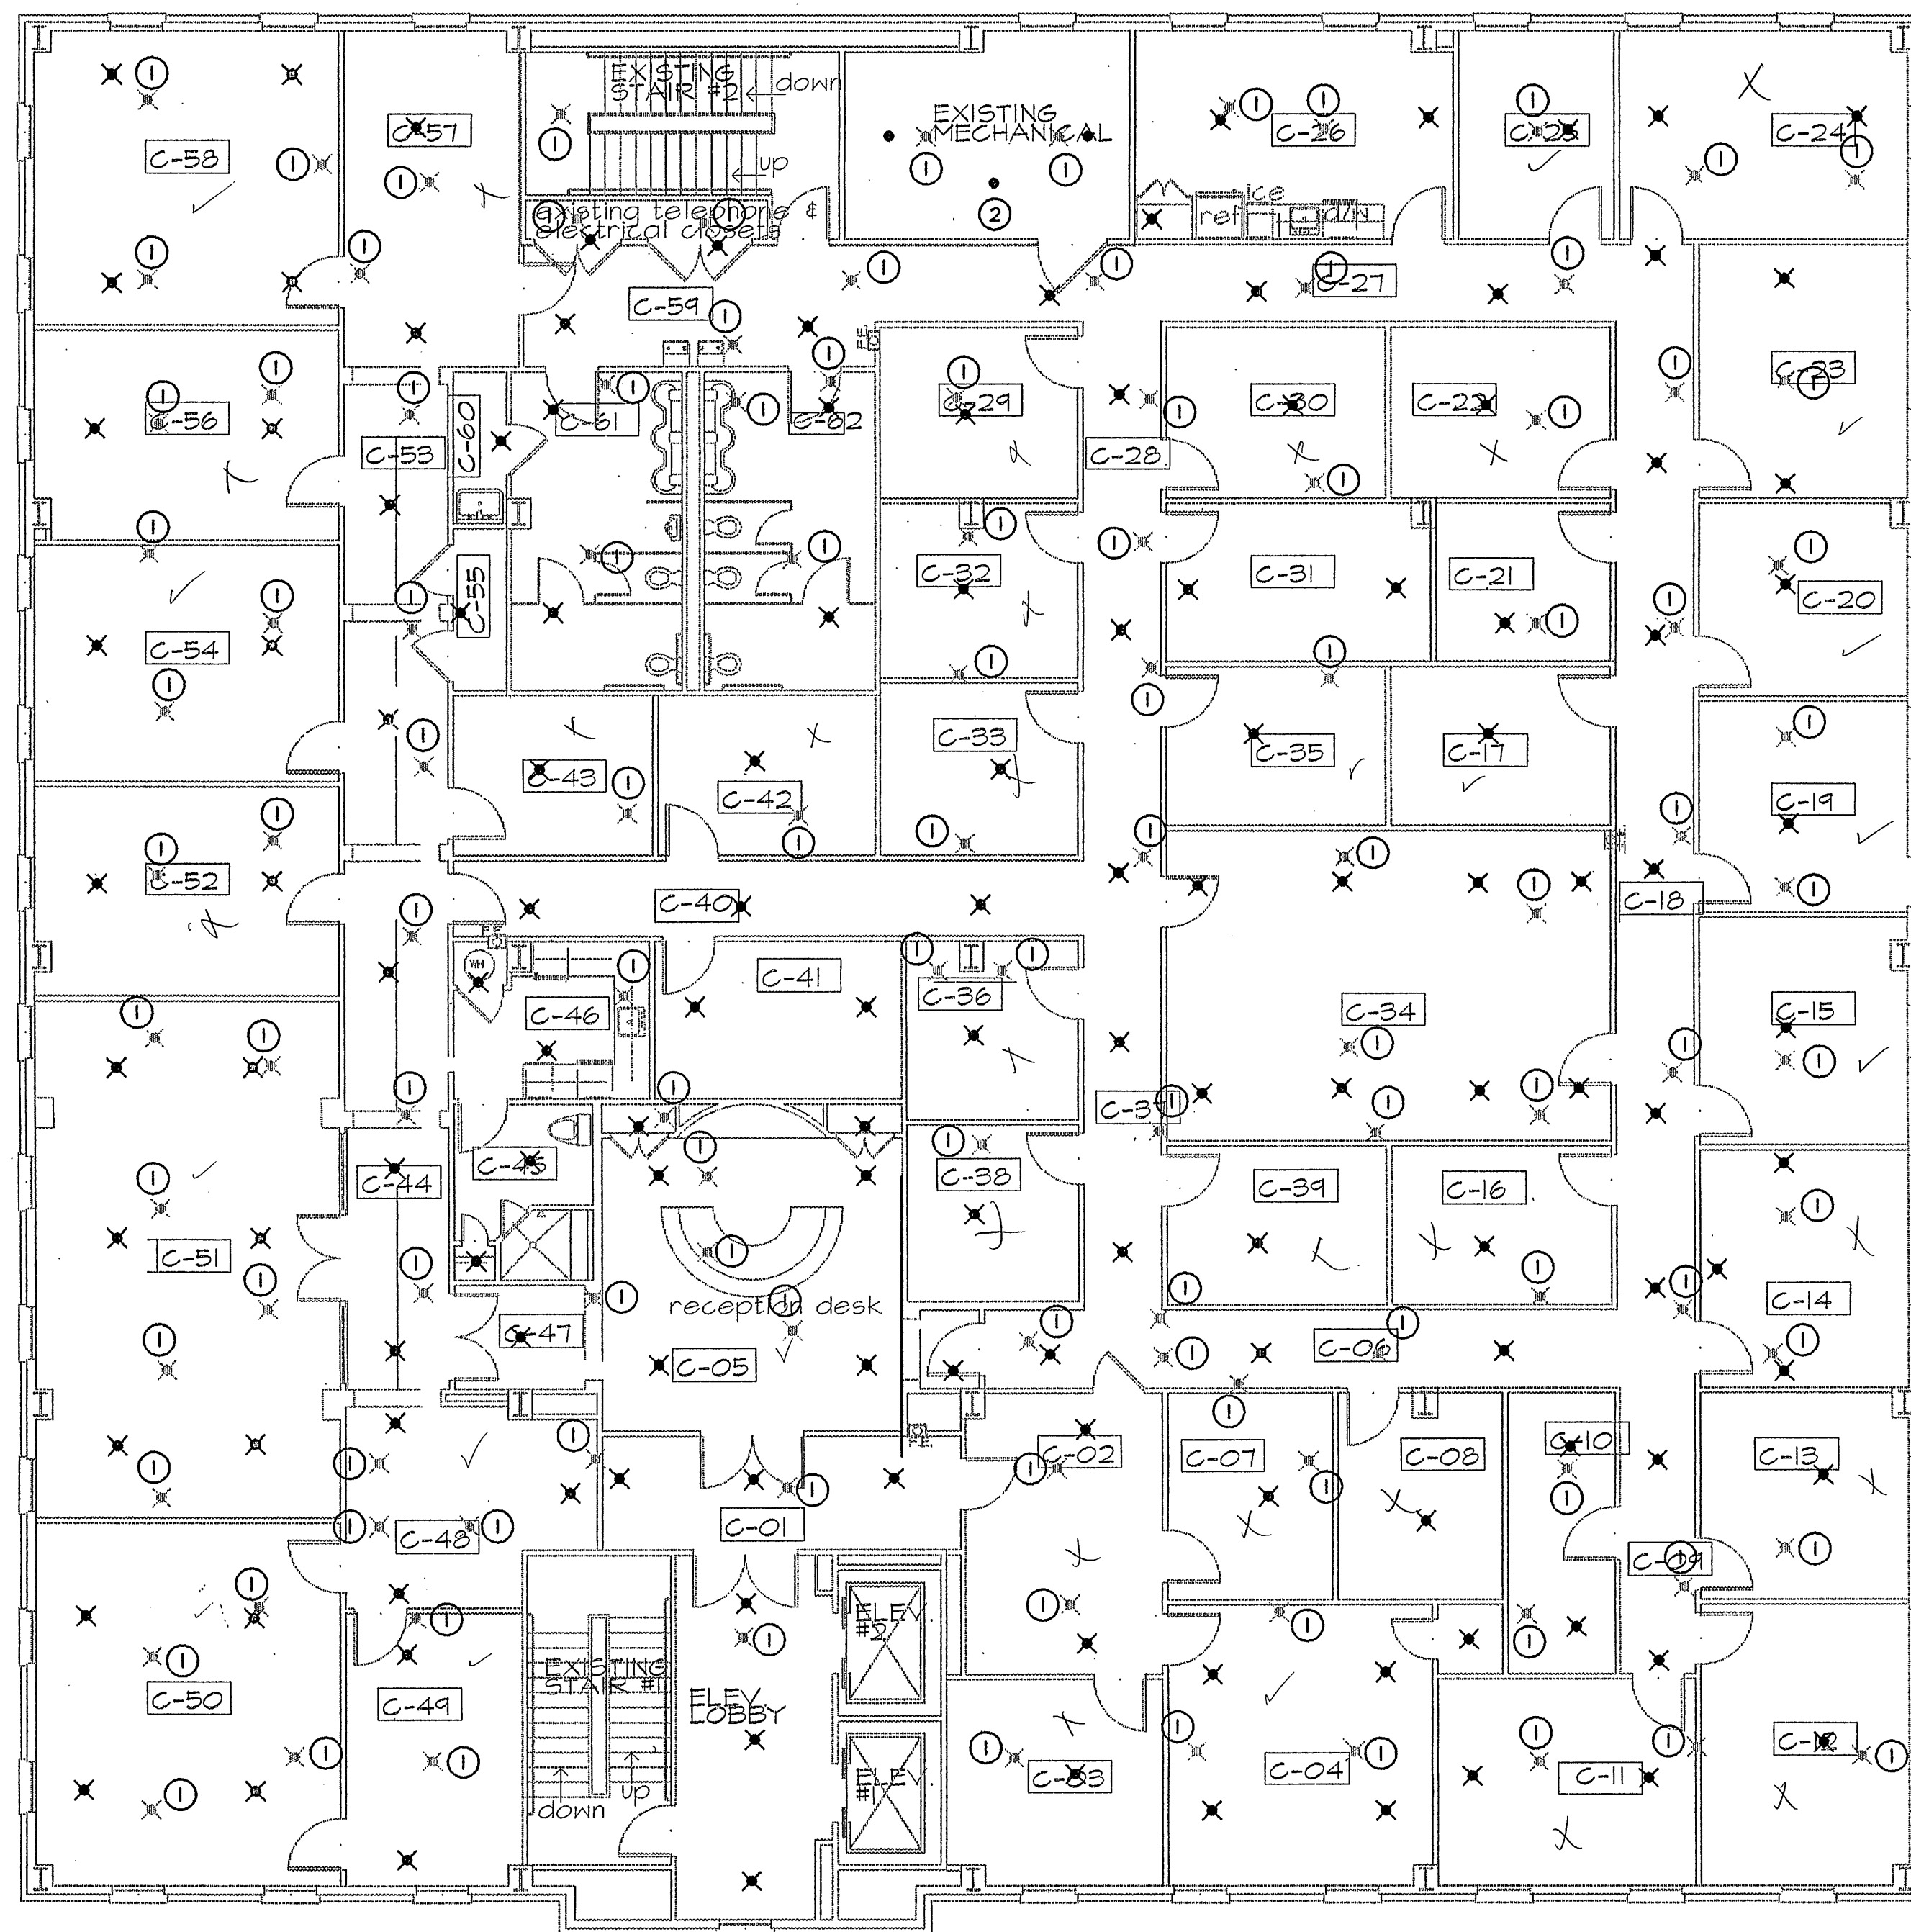


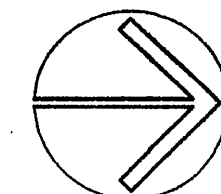

 Sprinkler
3rd Floor Plan - Tenant Improvement
Scale 1/8" = 1'-0"
Plan North

GENERAL SPRINKLER SYSTEM NOTES


- 1) CONTRACTOR SHALL MODIFY EXISTING SPRINKLER SYSTEM TO REFLECT THE TENANT IMPROVEMENTS INCLUDED IN THIS PROJECT.
- 2) CONTRACTOR SHALL UTILIZE LISTED QUICK RESPONSE HEADS THROUGHOUT THIS FLOOR. REPLACE EXISTING HEADS WITH NEW QUICK RESPONSE CONCEALED HEADS.
- 3) PROVIDE AND INSTALL NEW SPRINKLER PIPING AS REQUIRED TO COMPLY WITH THE REQUIREMENTS OF NFPA 13 AND 101 AND TO ACCOMMODATE THE INSTALLATION OF NEW SPRINKLER HEADS.
- 4) CONTRACTOR SHALL PAY ALL FEES AND SHALL PROVIDE SHOP DRAWINGS AND HYDRAULIC CALCULATIONS AS REQUIRED BY AUTHORITIES HAVING JURISDICTION THROUGH FINAL INSPECTION AND ACCEPTANCE.
- 5) ALL NEW SPRINKLER PIPING LESS THAN 1 1/2 INCHES IN DIAMETER SHALL BE SCHEDULE 40 BLACK STEEL PIPE WITH SCREW JOINTS AND FITTINGS. PIPE SIZES 1 1/2 INCHES AND LARGER SHALL BE SCHEDULE 10 PIPE WITH ROLLED GROOVES AND FITTINGS.
- 6) CONTRACTOR SHALL TAG SPRINKLER SYSTEM IN ACCORDANCE WITH REQUIREMENTS OF THE STATE FIRE MARSHAL'S OFFICE.
- 7) RETURN ALL SALVAGED SPRINKLER HEADS TO OWNER IN BOX FOR SAFE KEEPING.

SPECIFIC SPRINKLER SYSTEM NOTES

1	EXISTING SPRINKLER HEAD LOCATION BASED ON SHOP DRAWINGS PREPARED JUNE, 1984 BY FIRE SECURITY SYSTEMS INC. SHT. 3 OF 4.
2	PROVIDE SPRINKLER HEADS WITH WIRE GUARDS BENEATH ALL DUCTWORK 48 INCHES OR MORE IN WIDTH OR WHERE REQUIRED. BY NFPA 13: 4-6.5.2 OR 4-6.5.3

SPECIFIC KEY PLAN

X	LISTED QUICK RESPONSE CONCEALED PENDANT SPRINKLER HEAD, COLOR BY ARCHITECT.
•	LISTED UPRIGHT QUICK RESPONSE HEAD, CHROME.

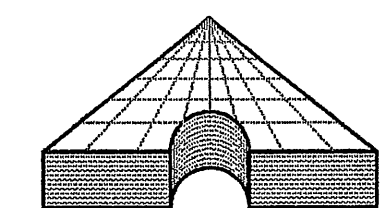

ASSOCIATED DESIGN GROUP, INC.
TERRY GAUDET & ASSOCIATES
CONSULTING ENGINEERS

114 Toledo Drive
Lafayette, Louisiana
(318) 234-5710
300 E. McNeese Street
Suite 5A
Lake Charles, LA 70605
(318) 478-3759

Project # 98199

drawn by: TLB

date: JUNE 24, 1998

GOSSEN ARCHITECTS
A PROFESSIONAL CORPORATION

project number
98-COMMCORP

OF