


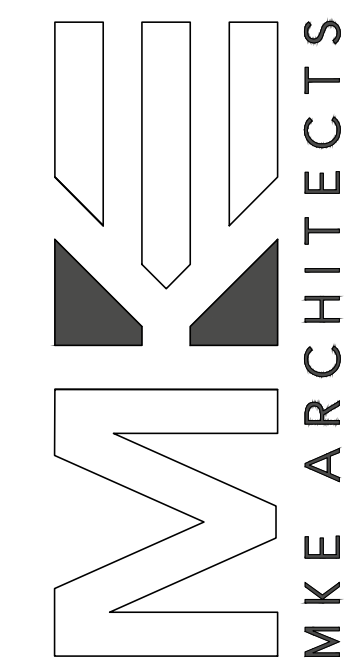

Office Information:
Main Office: 225.412.0048
Fax: 225.412.0049
MKE Architects.com
9800 Airline Hwy.
Suite 217
Baton Rouge, La 70816

Consultants Information:

Project Notes:

Project Title:

ST. FRANCIS
URGENT CARE

Project Location:

Sheet Revisions:

[illegible]

Sheet Name:

FLOOR PLAN

Seal

Project Number:

21-24

Date: _____

JANUARY 13, 2022


Document Phase:

CONCEPTUAL DESIGN

Sheet Number:

A2.01

Copyright 2022 by MKE Architects, LLC

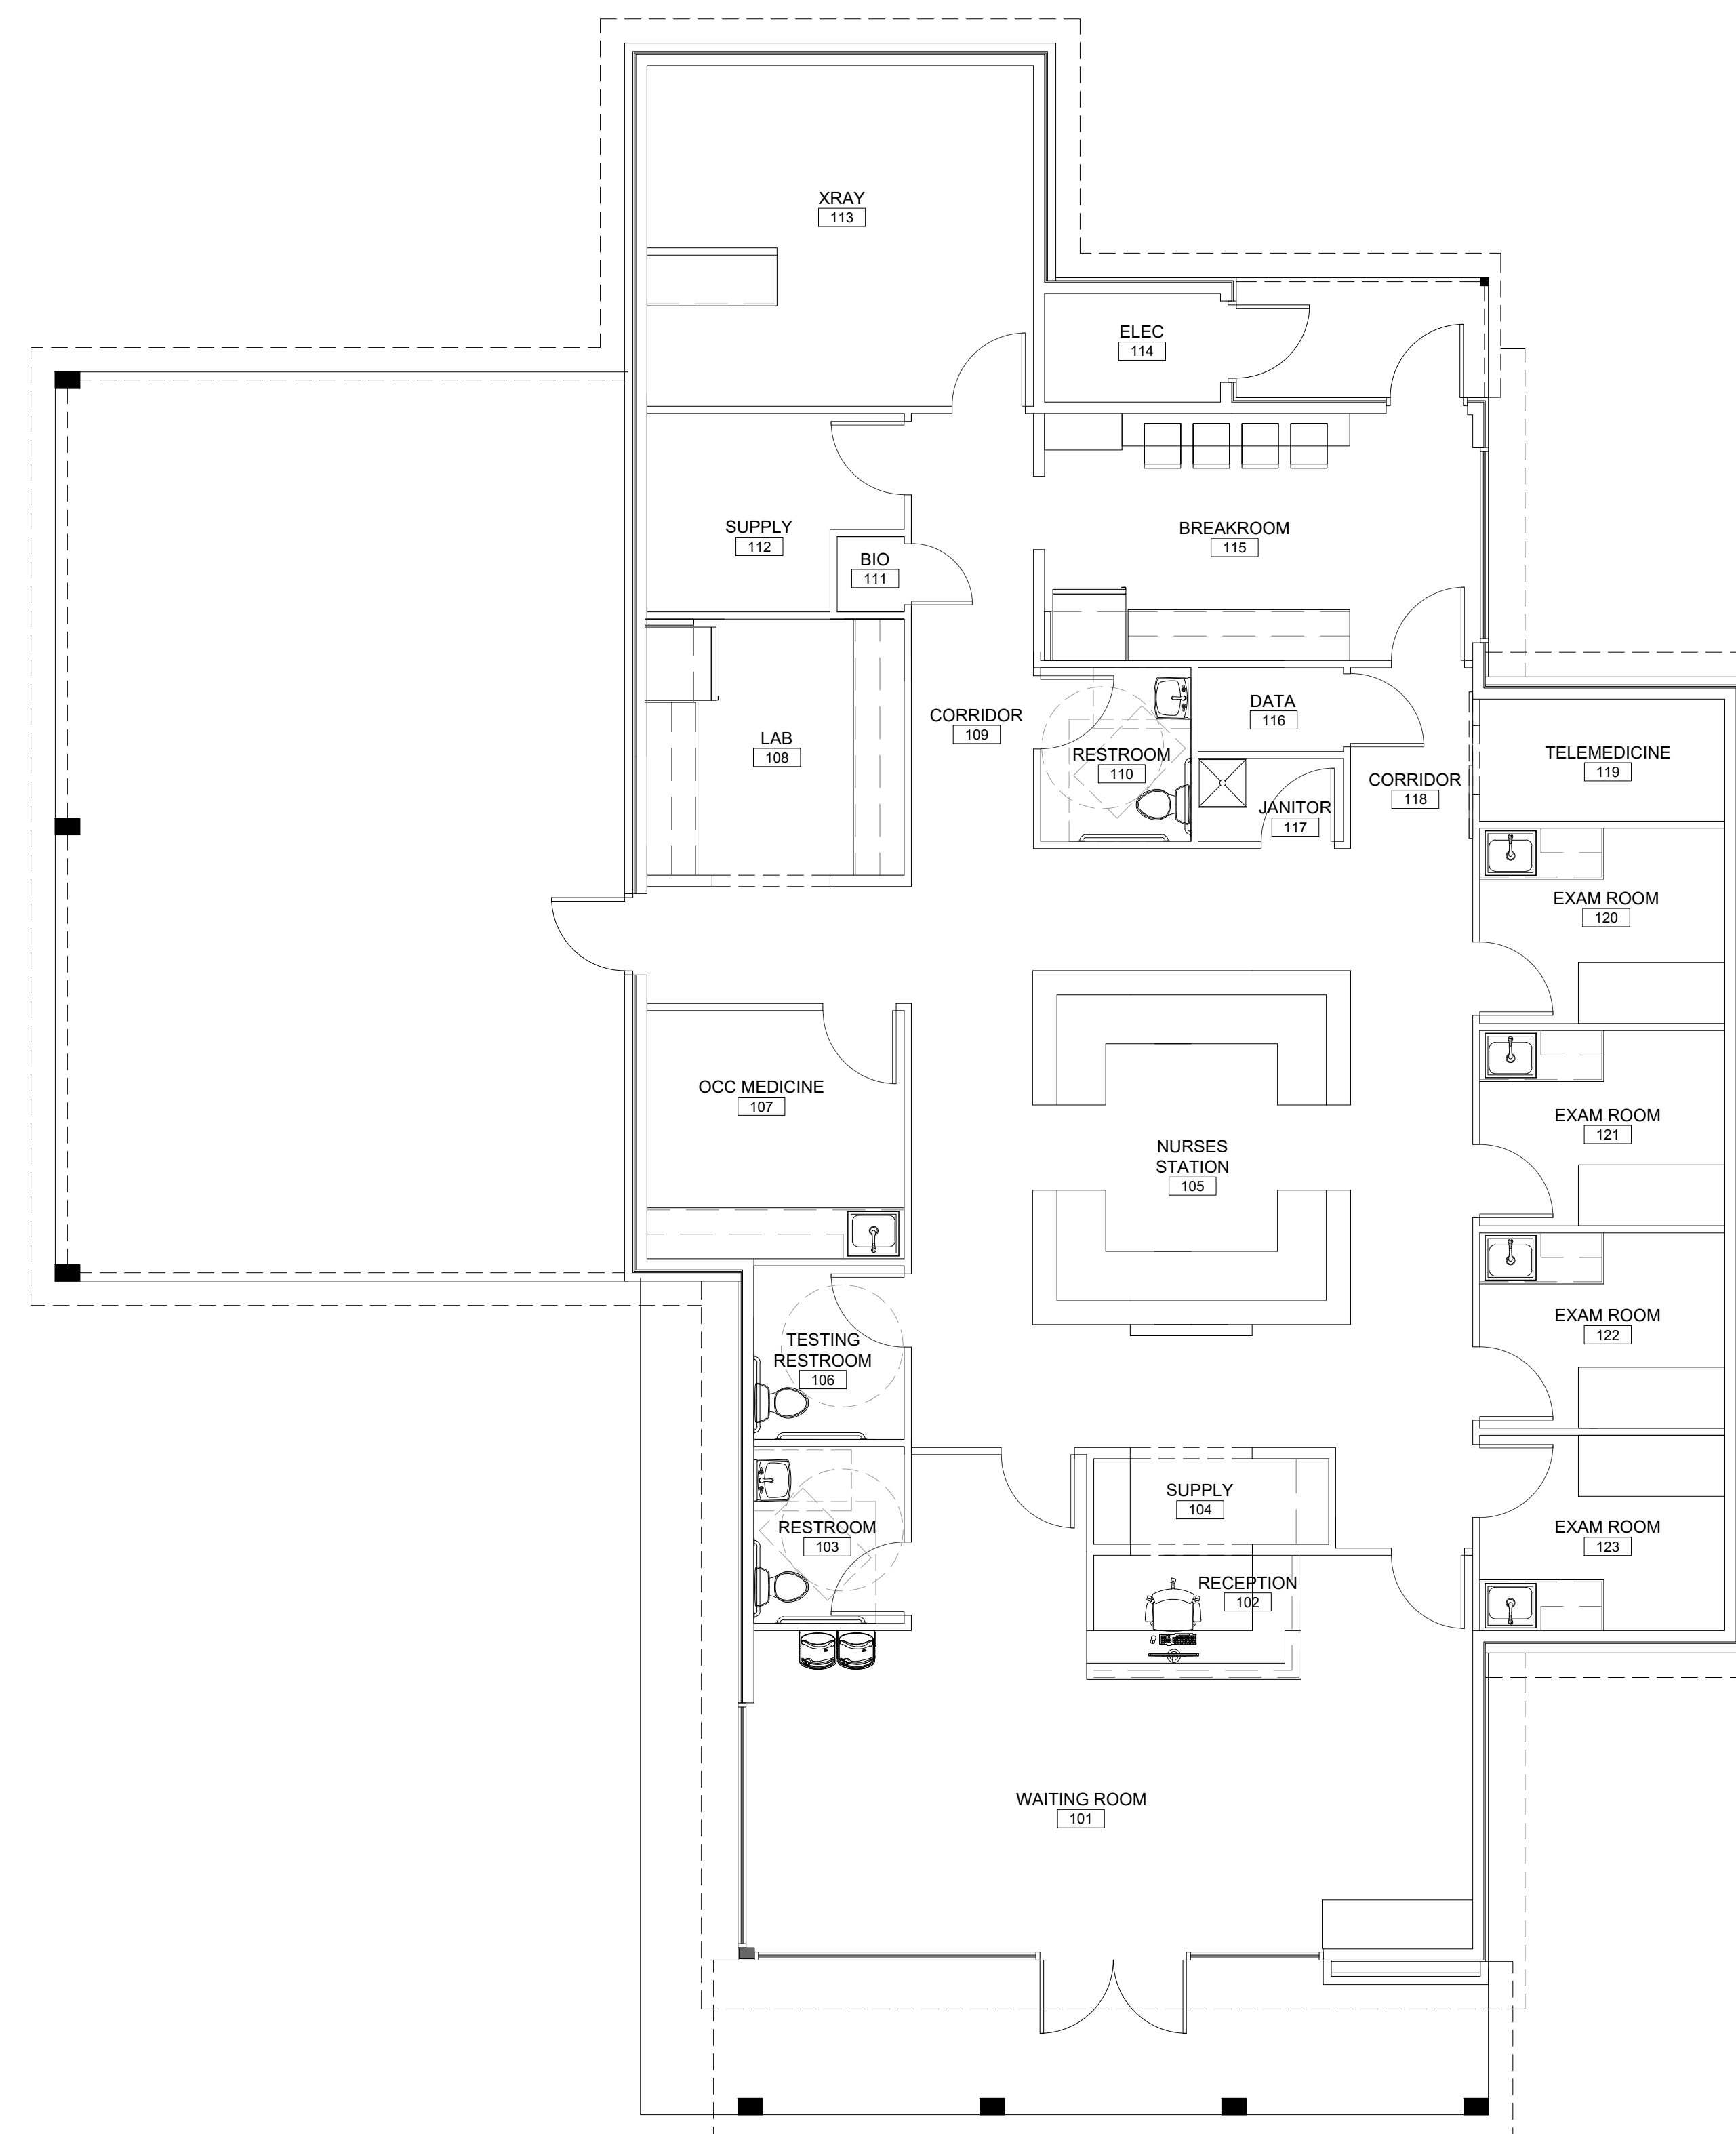

FLOOR PLAN - 2,855 SQ FT

	3/16"=1'-0"
--	-------------

(