


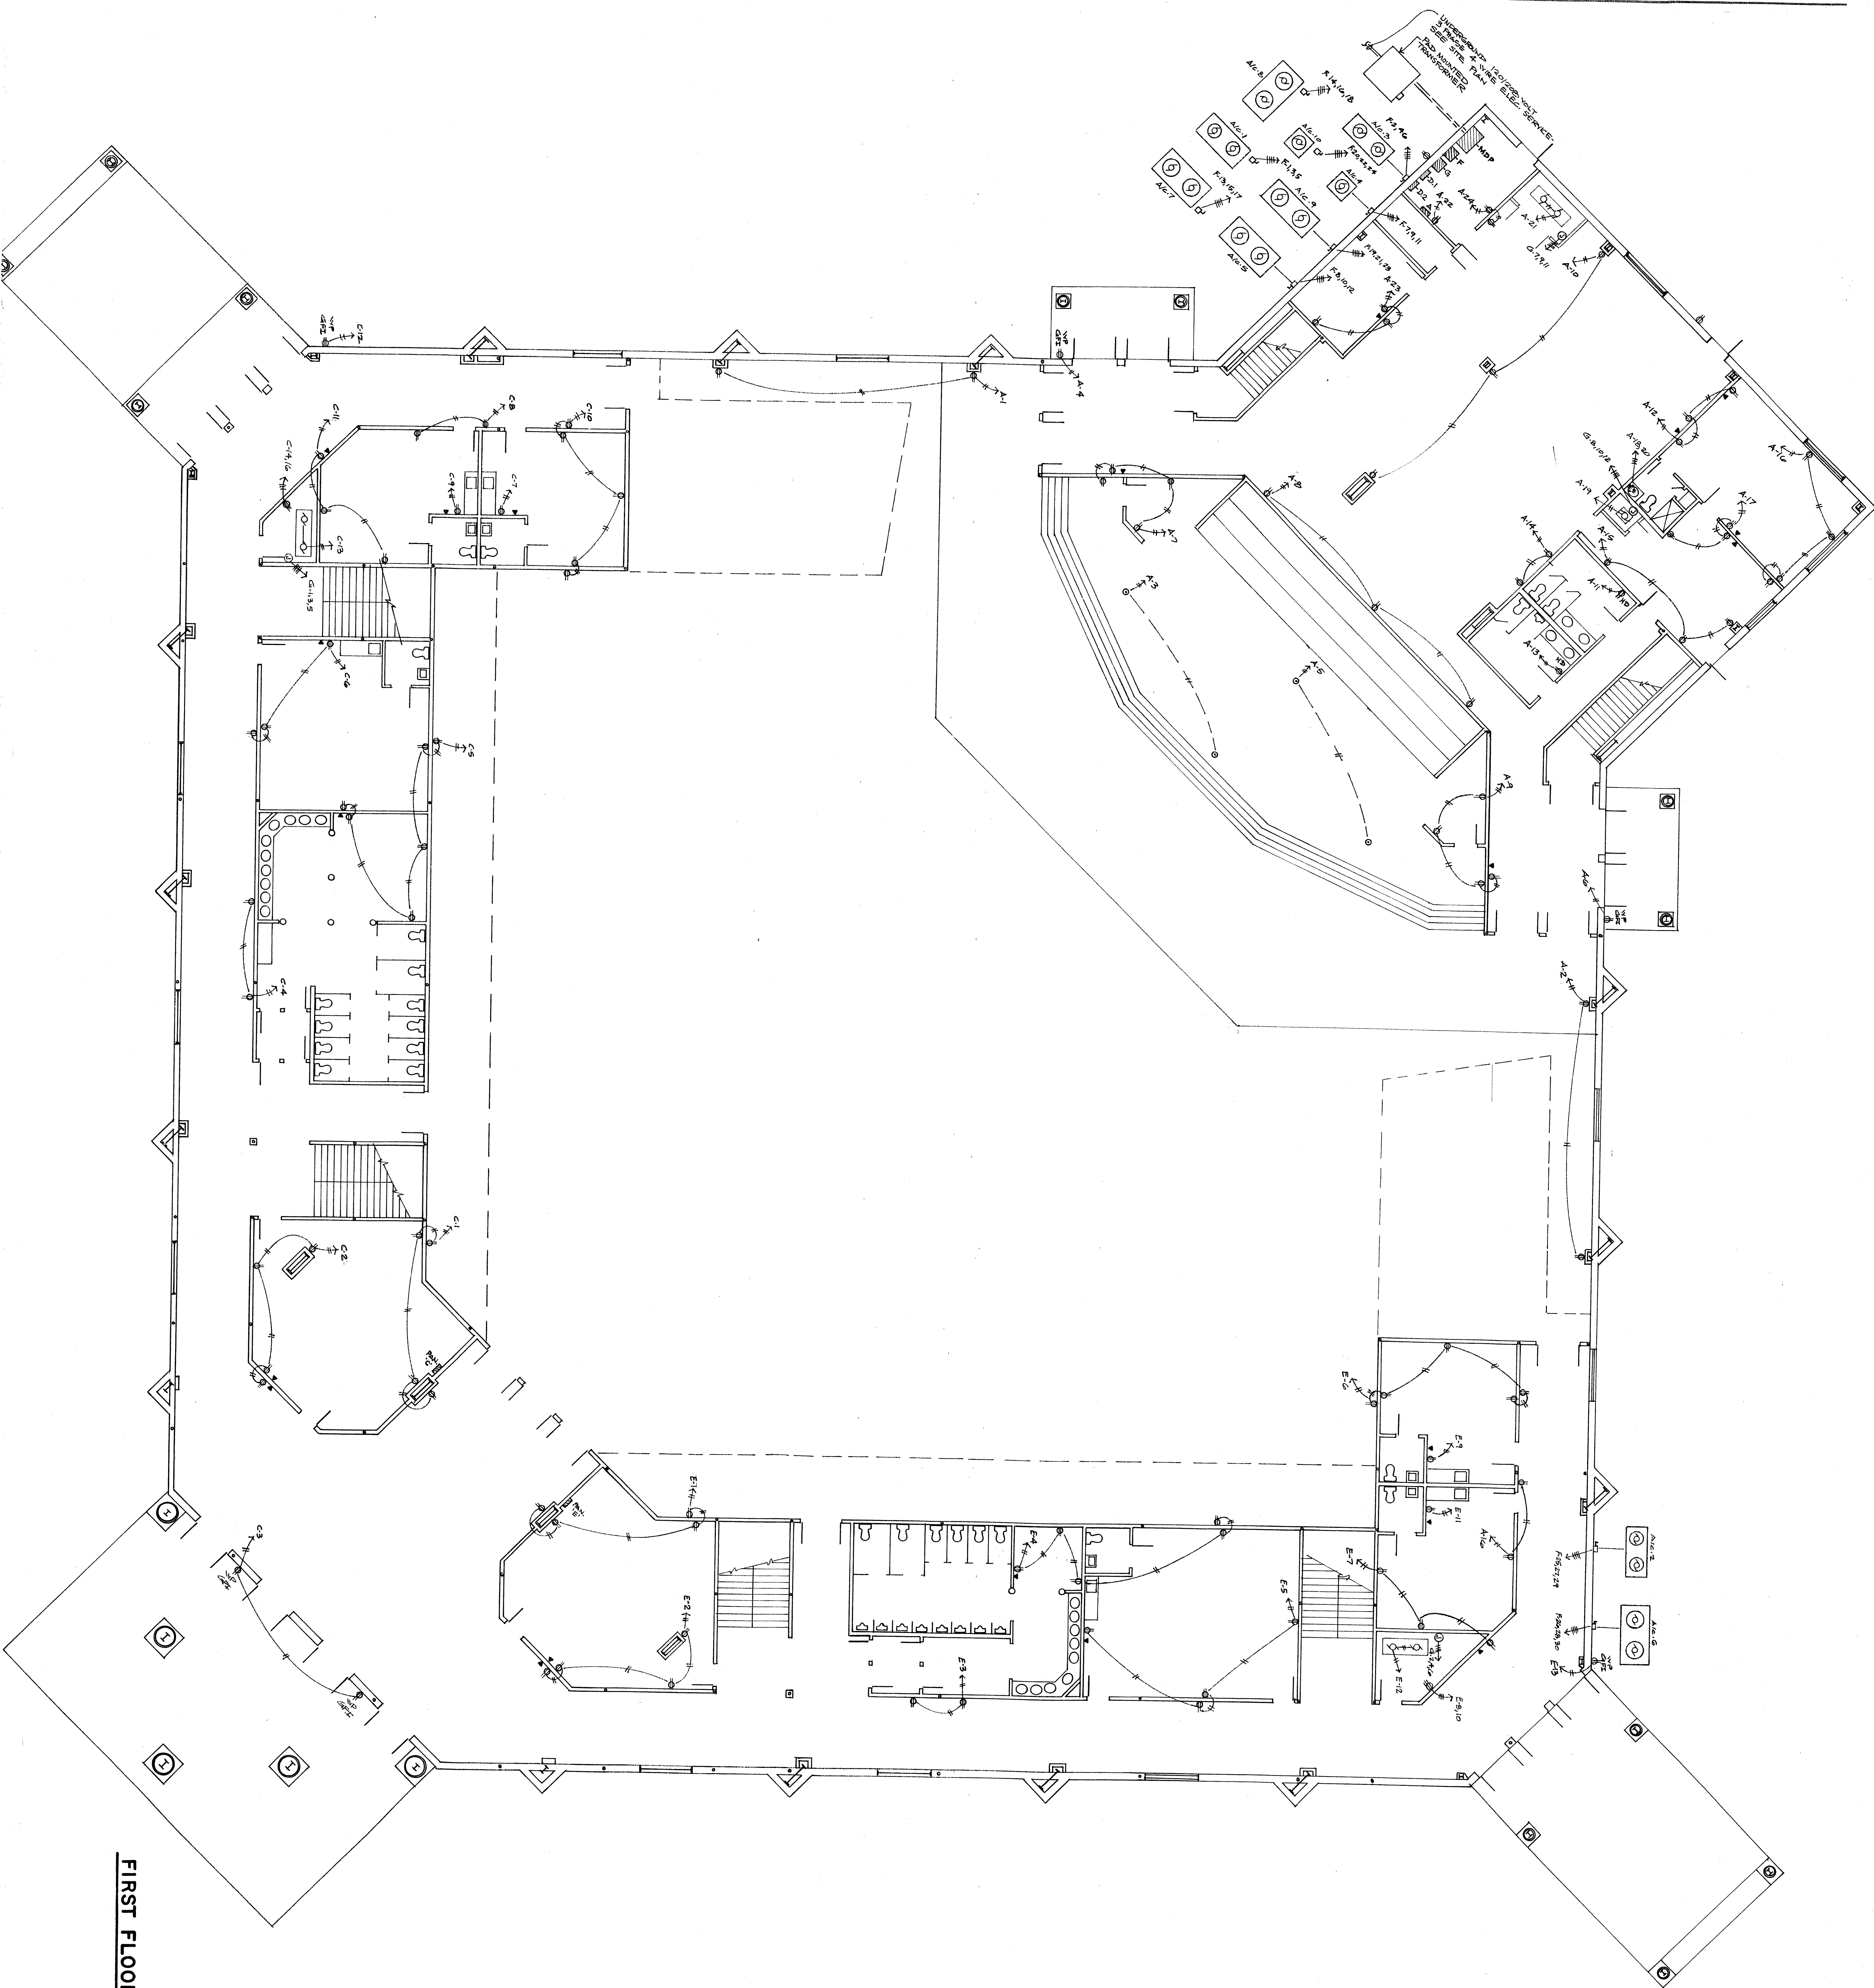


FIRST FLOOR ELEC. POWER PLAN


1/8" = 1'-0"


SHEET NO. 26 OF 30
E-1

HARVEST WORLD OUTREACH
INTERSTATE 12 SERVICE ROAD AT YOKUM ROAD
HAMMOND, LOUISIANA

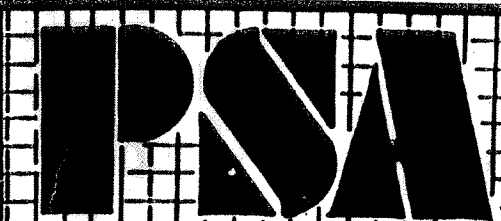

PAUL F. STEWART ARCHITECT LTD.
ROBERT P. HOLTZCLAW PROJECT ARCHITECT
1804 STUBBS AV.
MONROE, LA. 71201
PROJECT NUMBER 00150
DATE 11-3-00

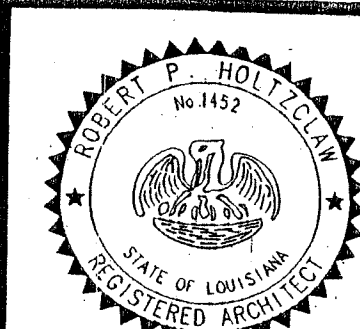

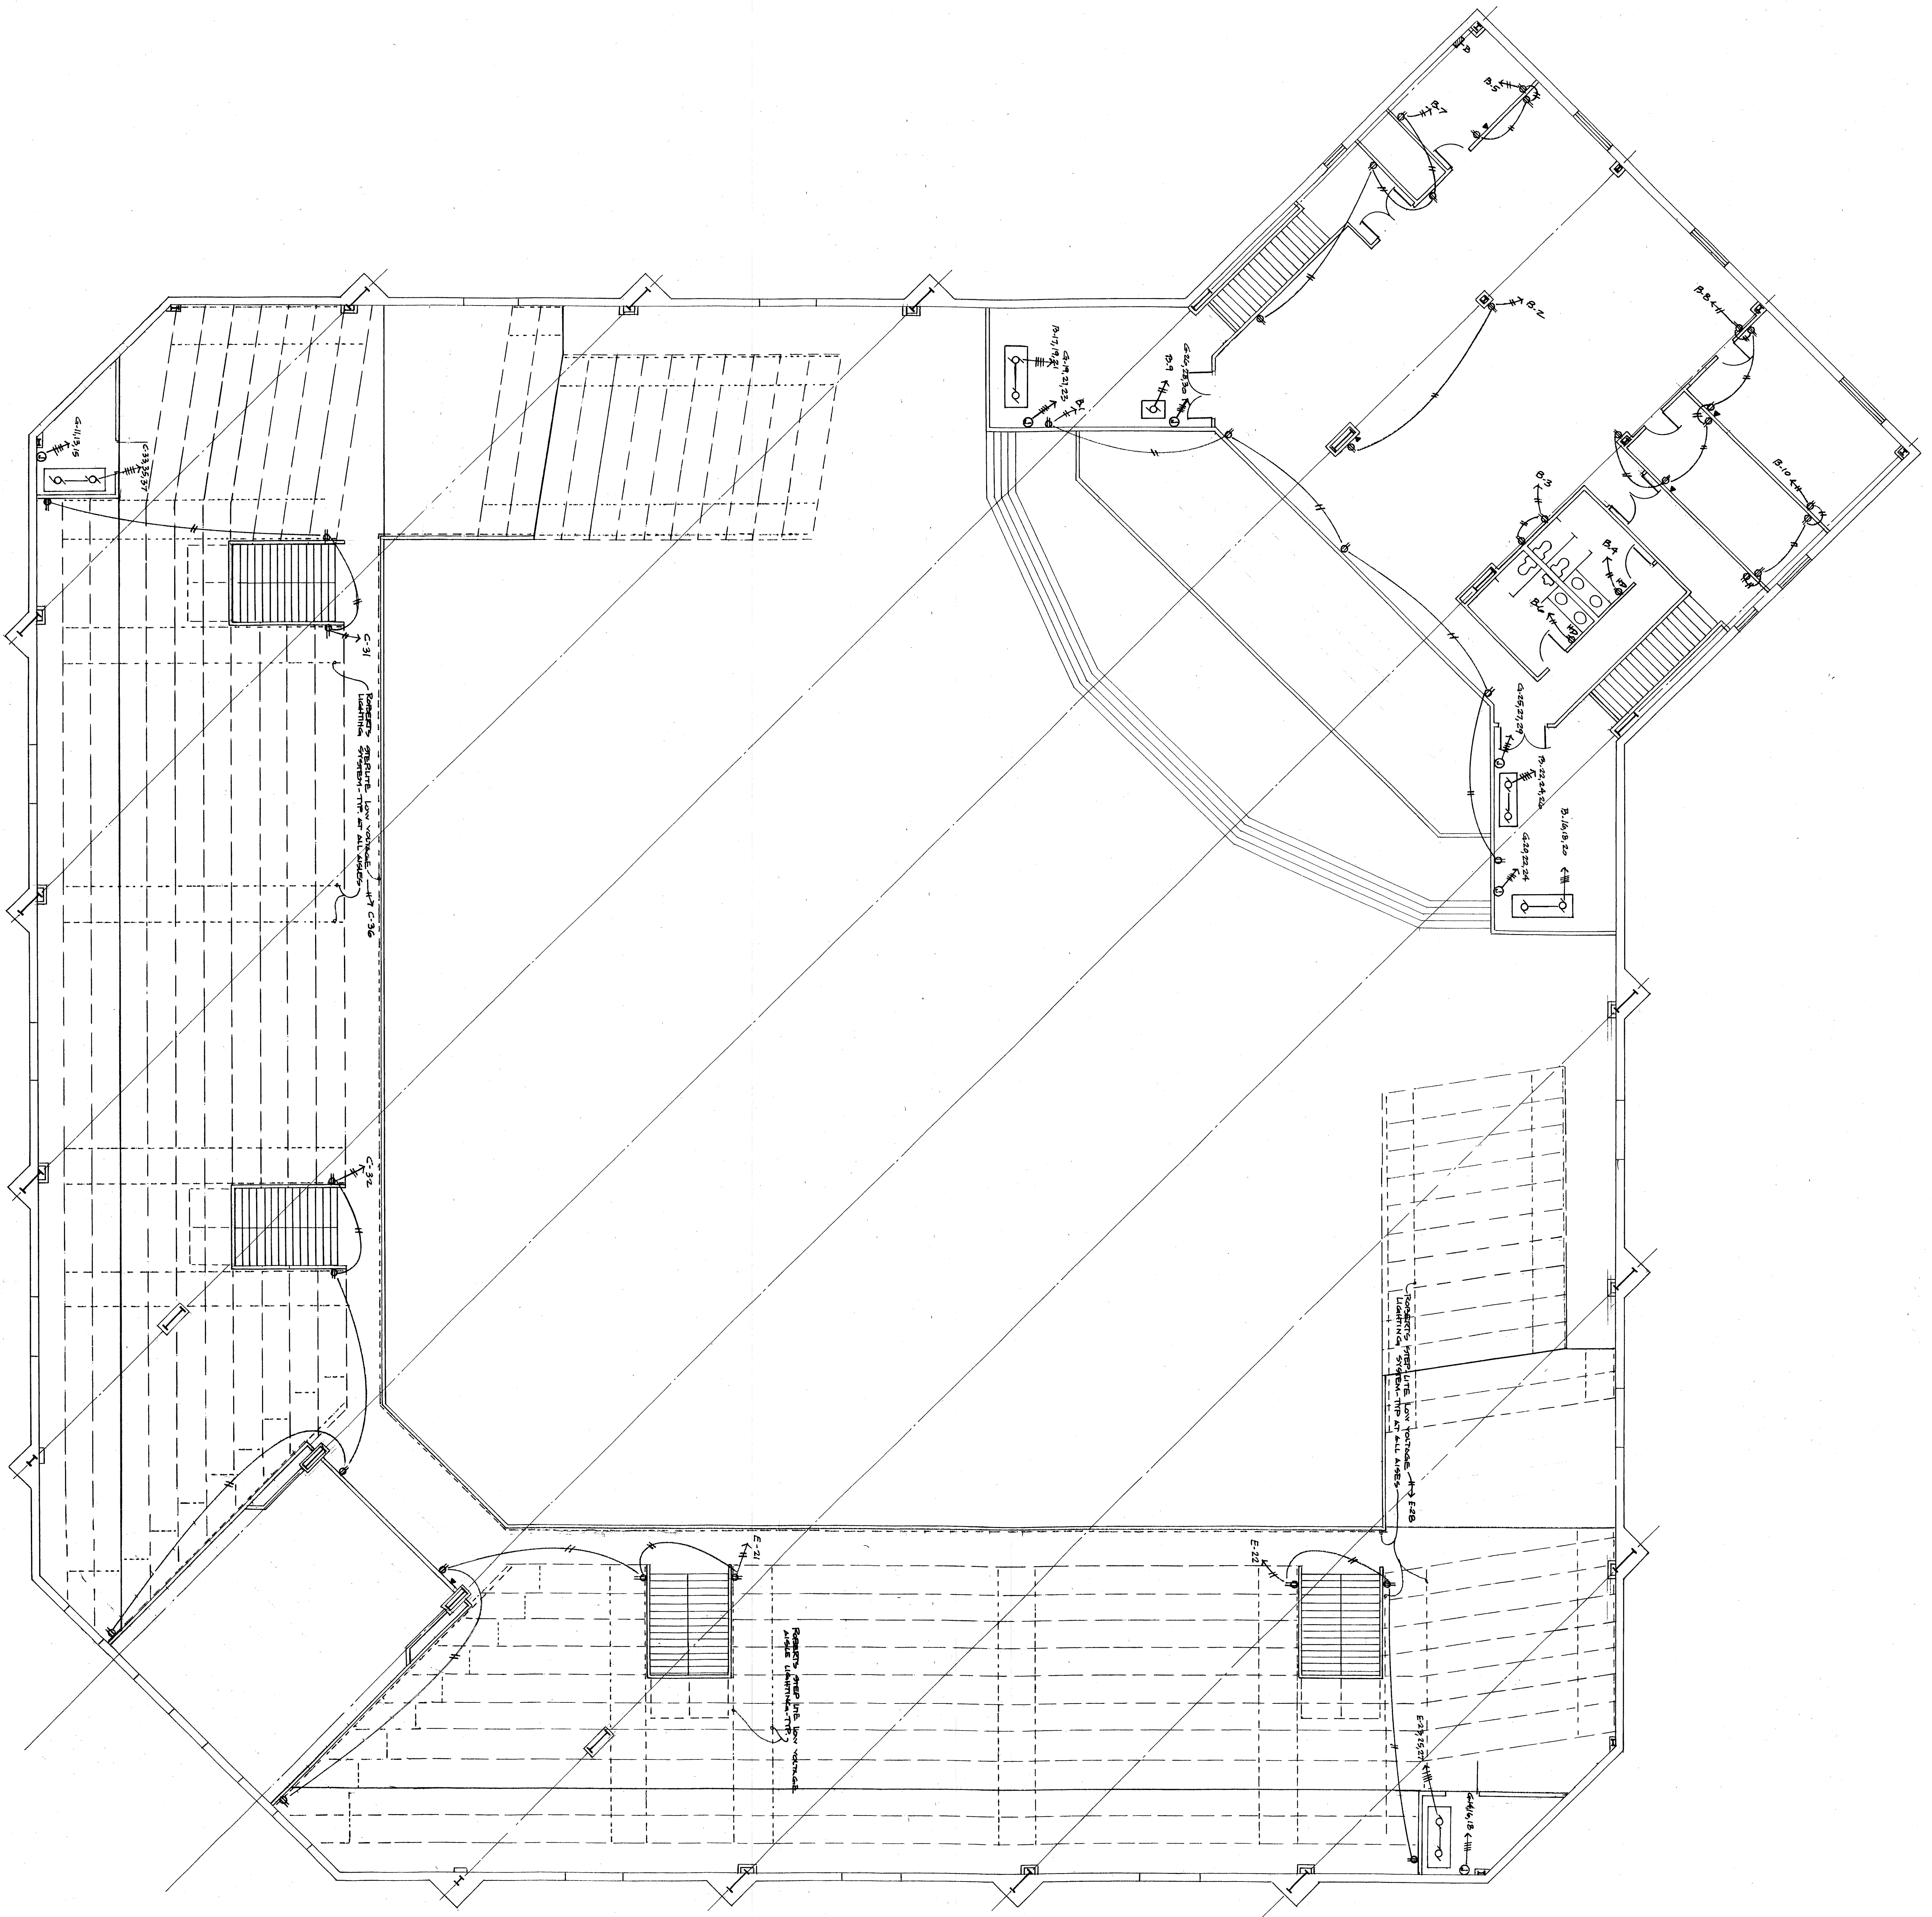

ELEC. POWER
SECOND FLOOR PLAN
1/8" = 1'-0"


E-2
27-00-00

PROJECT NO.
DATE
BY
CHECKED BY


HARVEST WORLD OUTREACH
INTERSTATE 12 SERVICE ROAD AT YOKUM ROAD
HAMMOND, LOUISIANA

PSA

PAUL F. STEWART ARCHITECT LTD.
ROBERT P. HOLTZCLAW PROJECT ARCHITECT
1804 STUBBS AV.
MONROE, LA. 71201
PROJECT NUMBER 00150

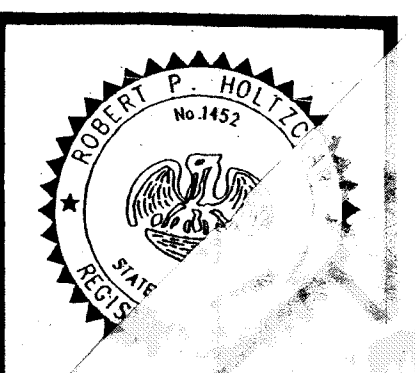

DATE 11-3-00

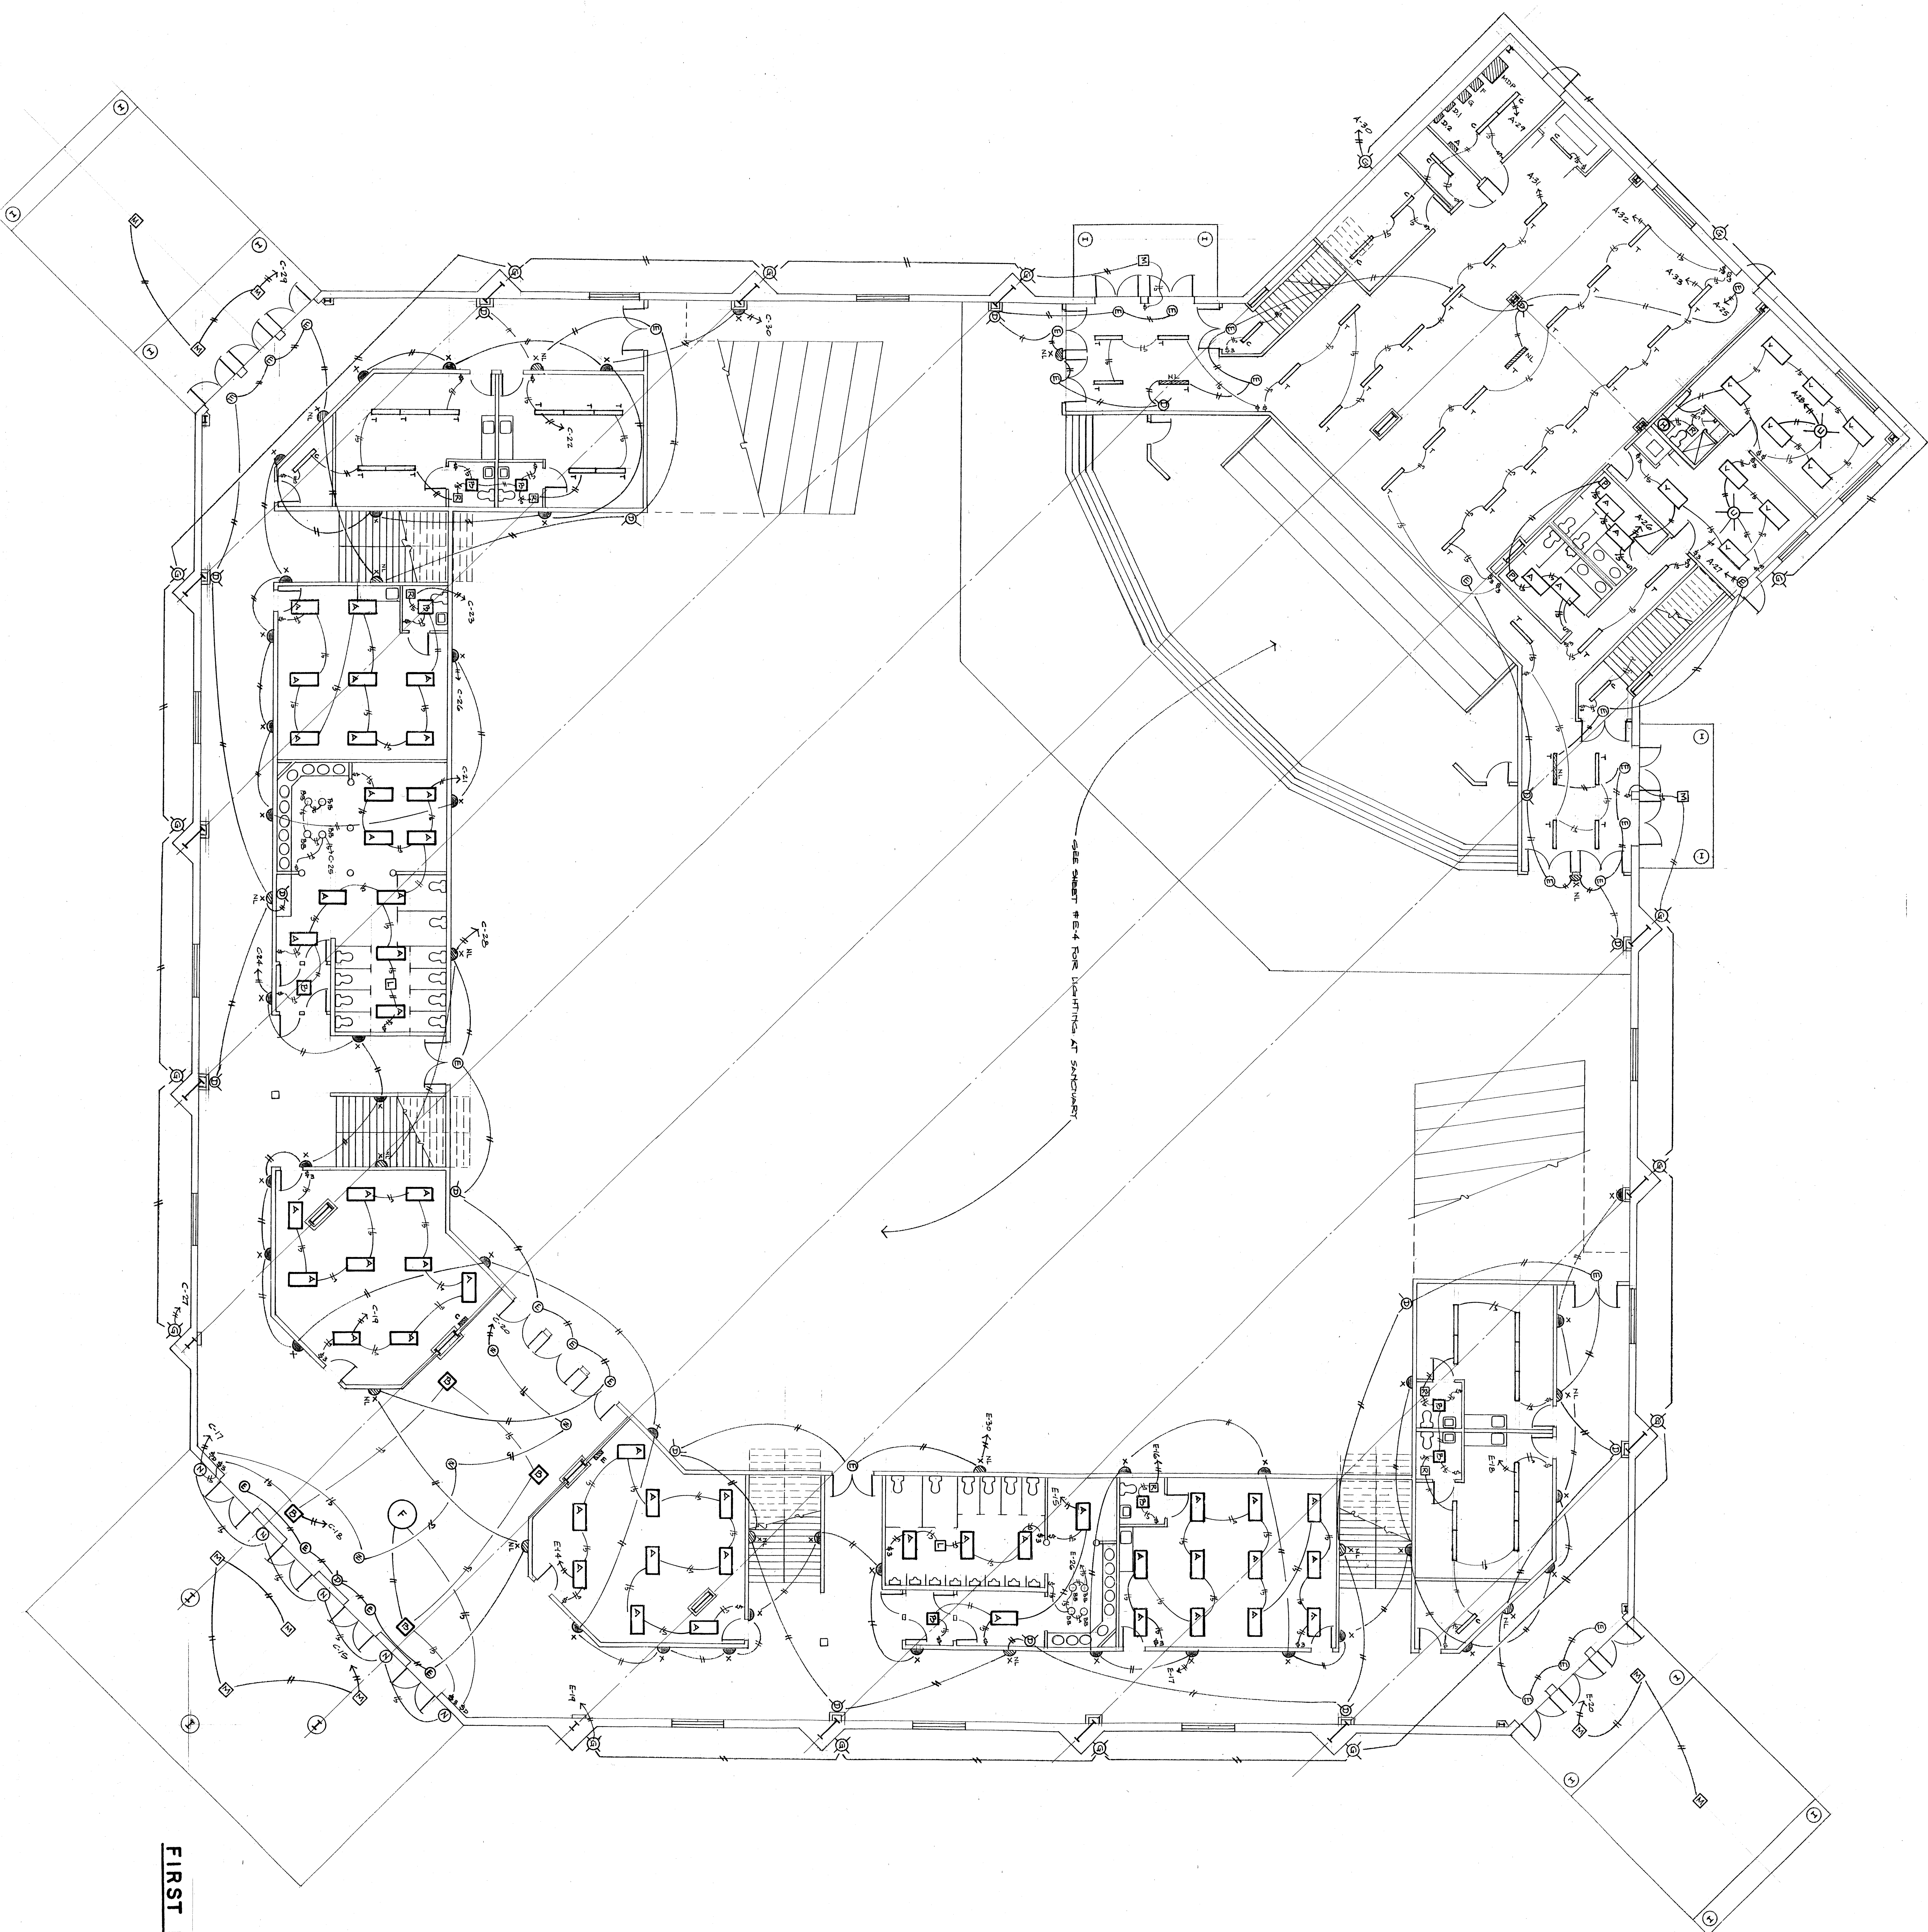


FIRST FLOOR LIGHTING PLAN

SHEET NO. E.3
28 OF 30

ACTIVE FILE	INACTIVE FILE
1	1
2	2
3	3
100	100

 
HARVEST WORLD OUTREACH
INTERSTATE 12 SERVICE ROAD AT YOKUM ROAD
HAMMOND, LOUISIANA





PAUL F. STEWART ARCHITECT LTD.
ROBERT P. HOLTZCLAW PROJECT ARCHITECT
1904 STUBBS AV. MONROE, LA. 71201

PROJECT NUMBER 00150

DATE 11-3-00

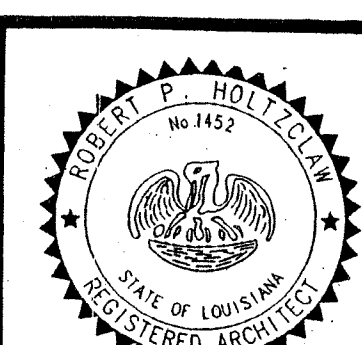

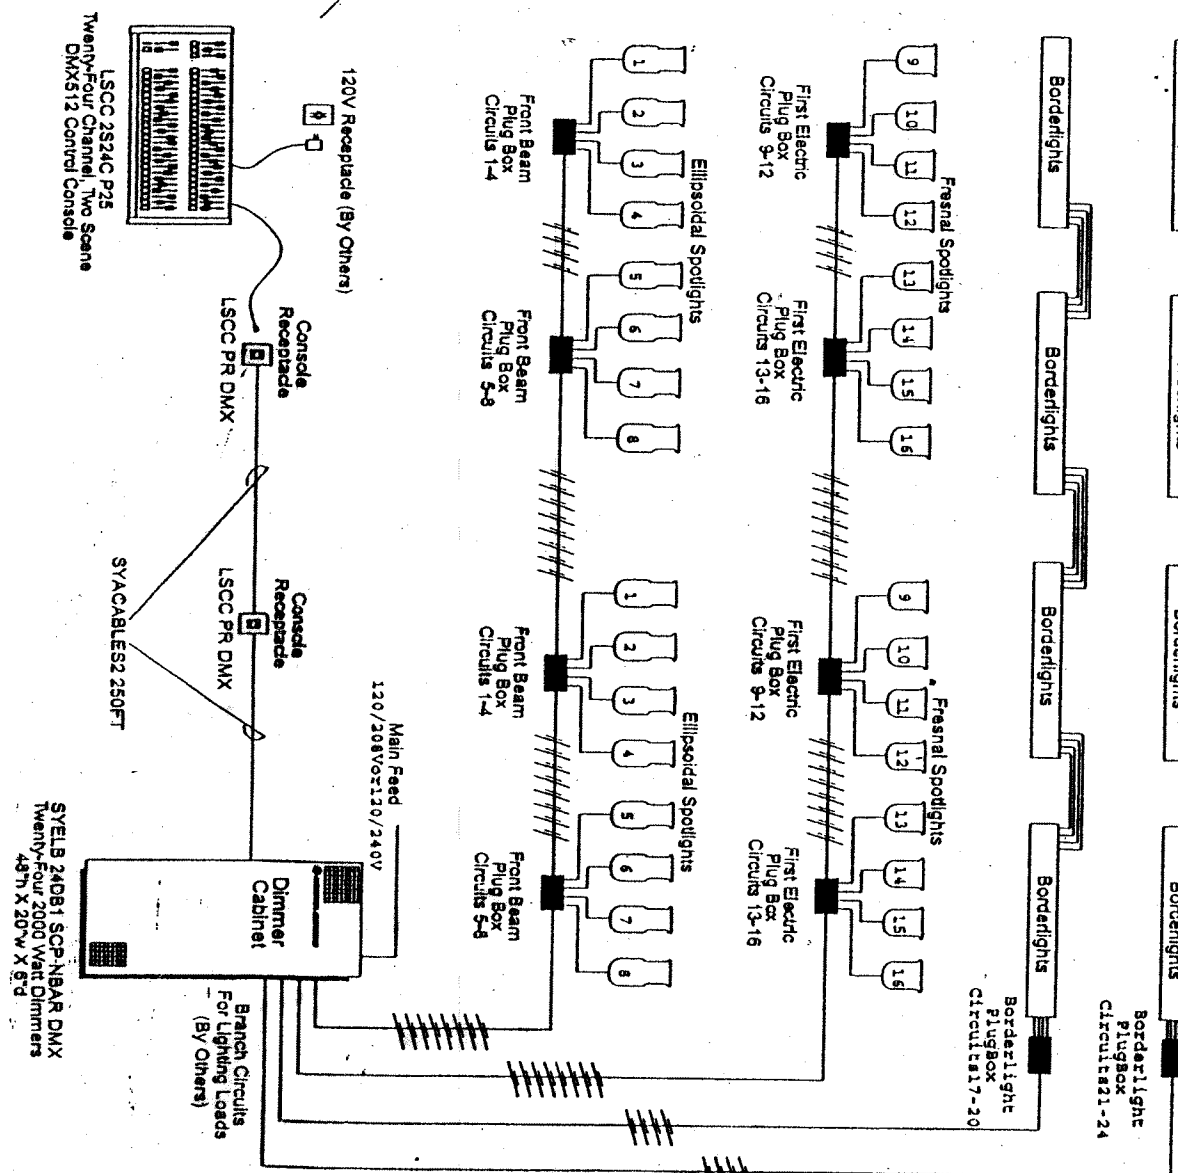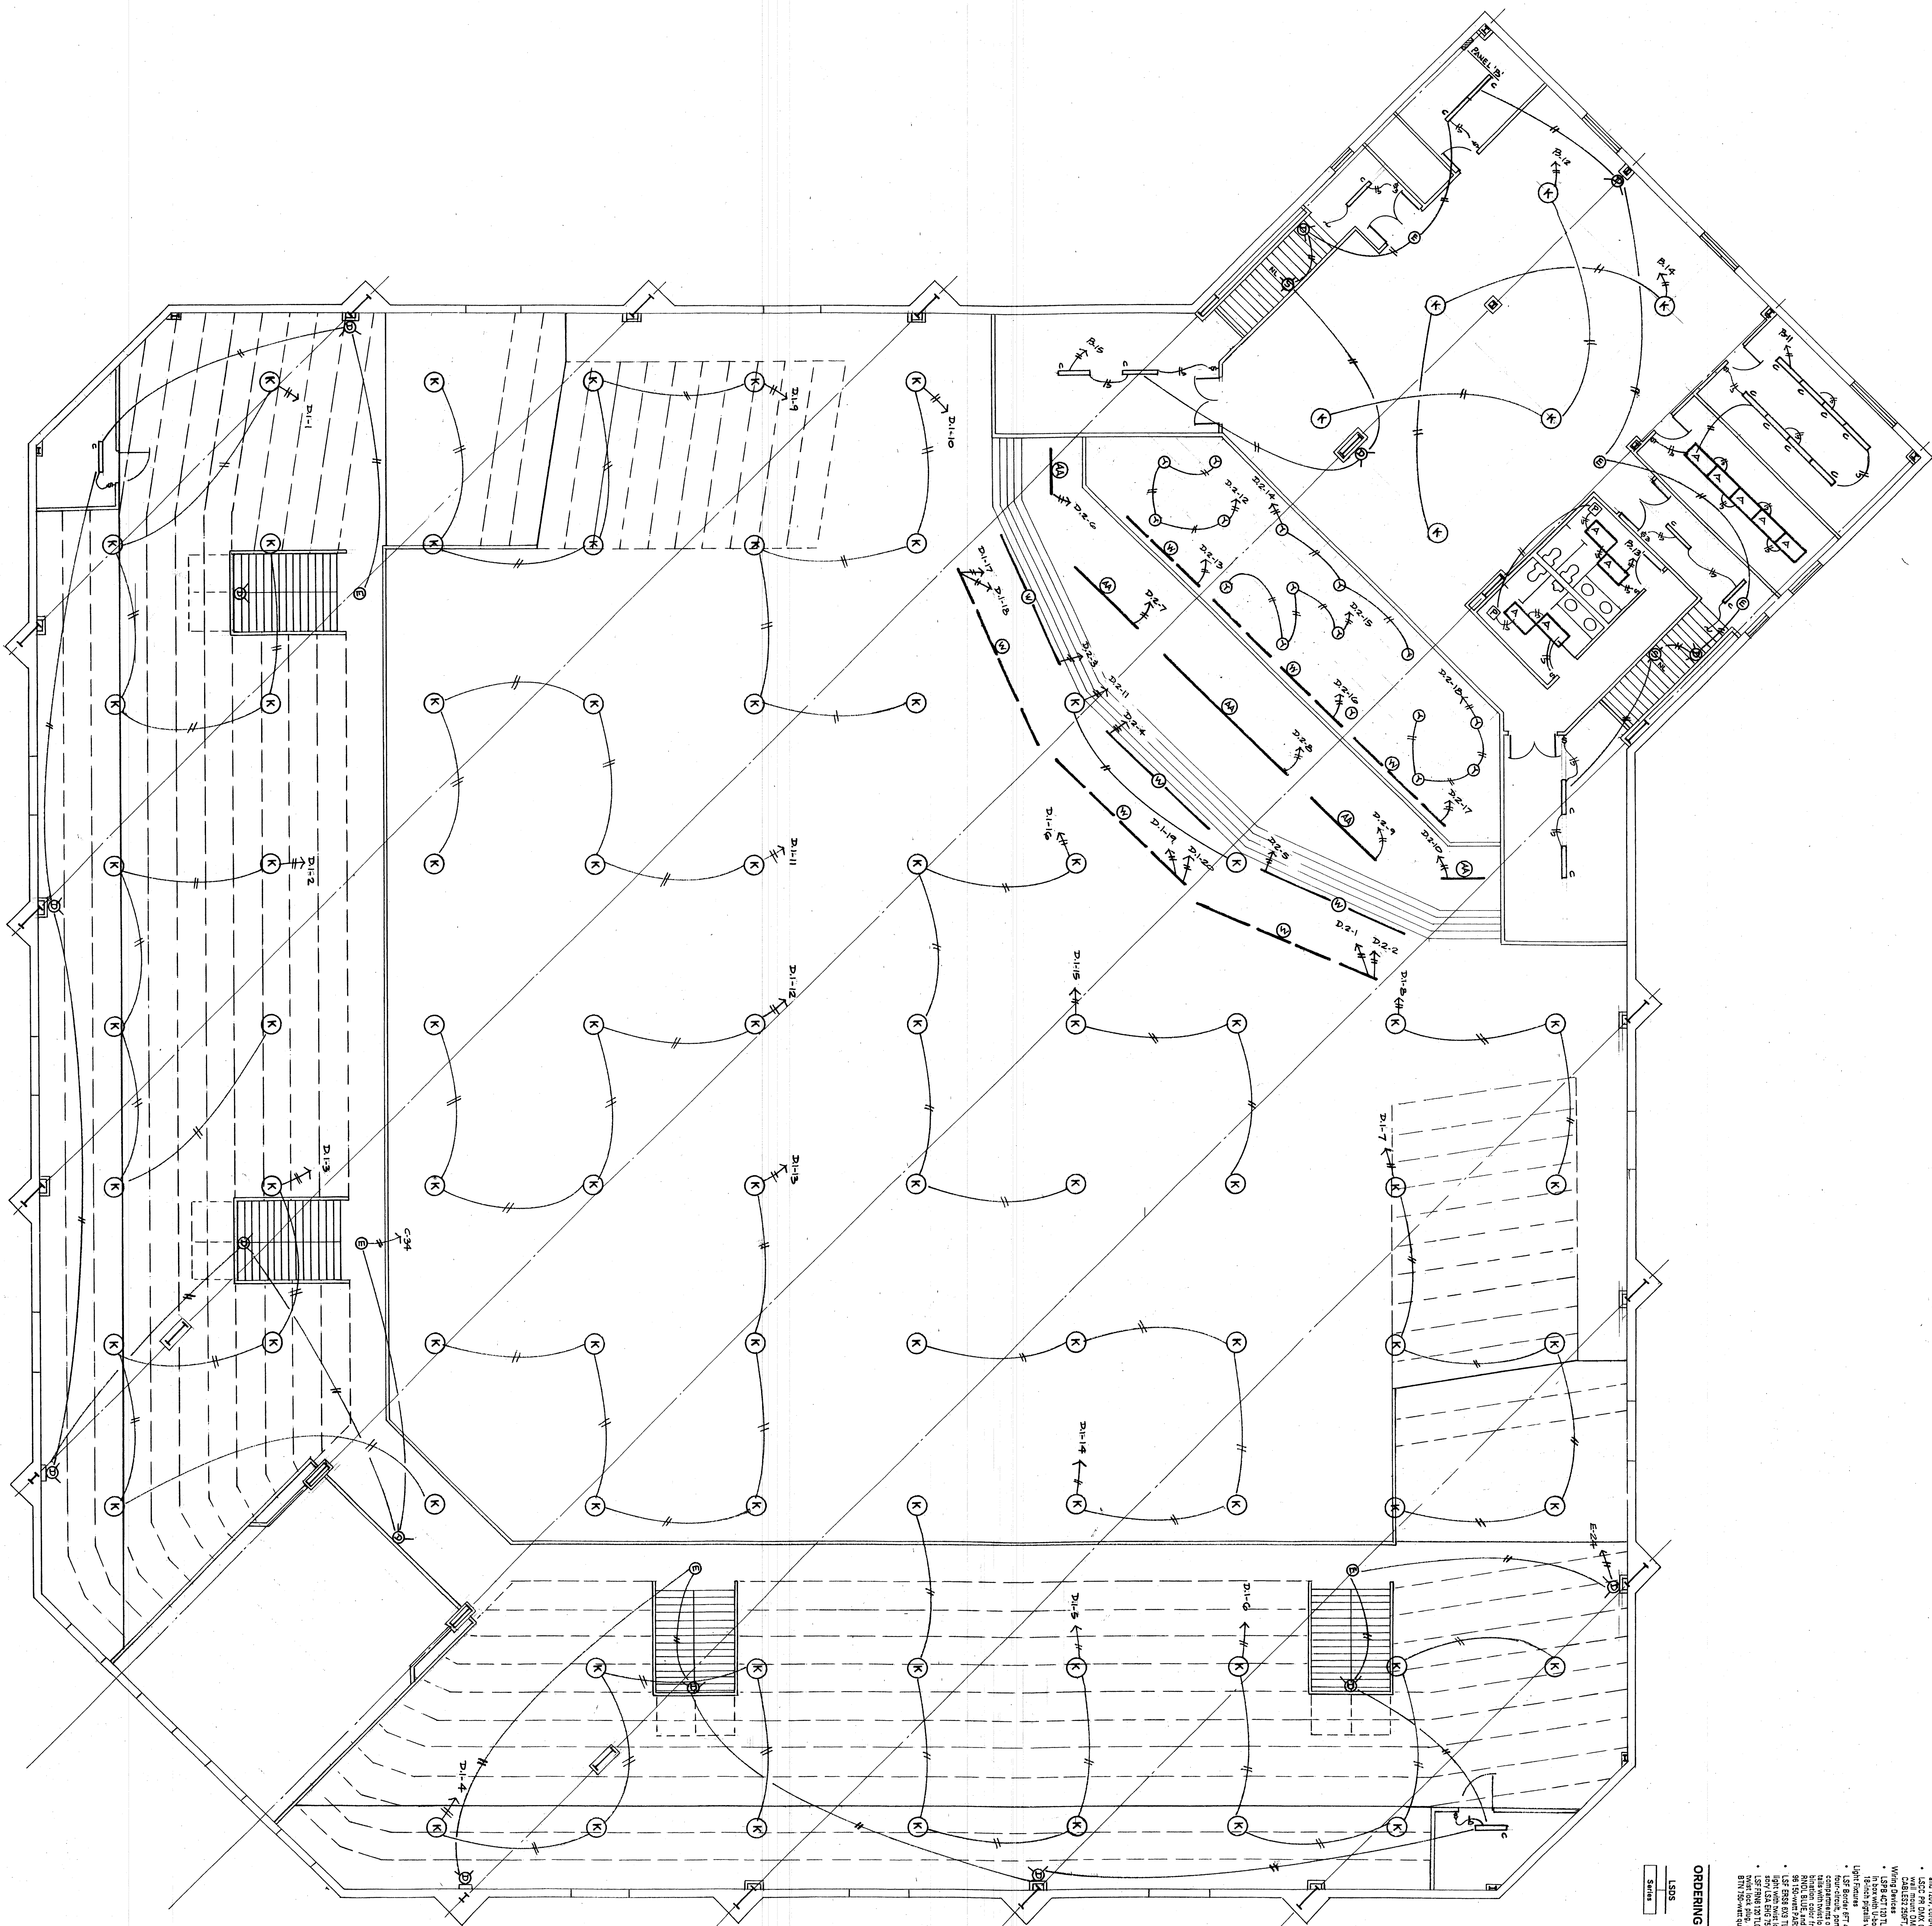

ORDERING INFORMATION

Series	24C	40 EXT
MC	Channels	Fixture Quantity
24	24 Channels	40EXT 40 fixtures per package

[illegible]

**Stage Lighting and Controls
Expanded Small Stage Packages
LSDS
24 Channels, 40 Fixtures**

LIGHTING
SECOND FLOOR PLAN
 $1/8" = 1'-0"$



PAUL F. STEWART ARCHITECT LTD.
ROBERT P. HOLTZCLAW PROJECT ARCHITECT
 1904 STUBBS AV. MONROE, LA. 71201
 PROJECT NUMBER 00150 DATE 11-3-00

HARVEST WORLD OUTREACH
INTERSTATE 12 SERVICE ROAD AT YOKUM ROAD
HAMMOND, LOUISIANA

ACTIVE FILE	INACTIVE FILE

SHEET NO.

E-4

29 OF 30