


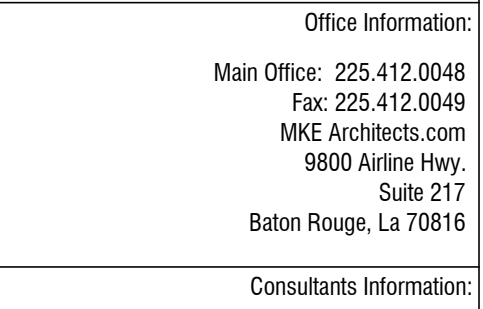

in Office: 225.412.0048
Fax: 225.412.0049
MKE Architects.com
9800 Airline Hwy.
Suite 217
Baton Rouge, La 70816

Consultants Information:

Project Title:
Pecue Place
-Test Fit

Project Location:
Pecue Place
Baton Rouge, La

Sheet Revisions:

[illegible]

Sheet Name:

ARCHITECTURAL
SITE PLAN

Seal

Project Number:

XX-XX


May 15, 2023

Document Phase:

Test Fit

A1.01.1

Copyright 2023 by MKE Architects, LLC

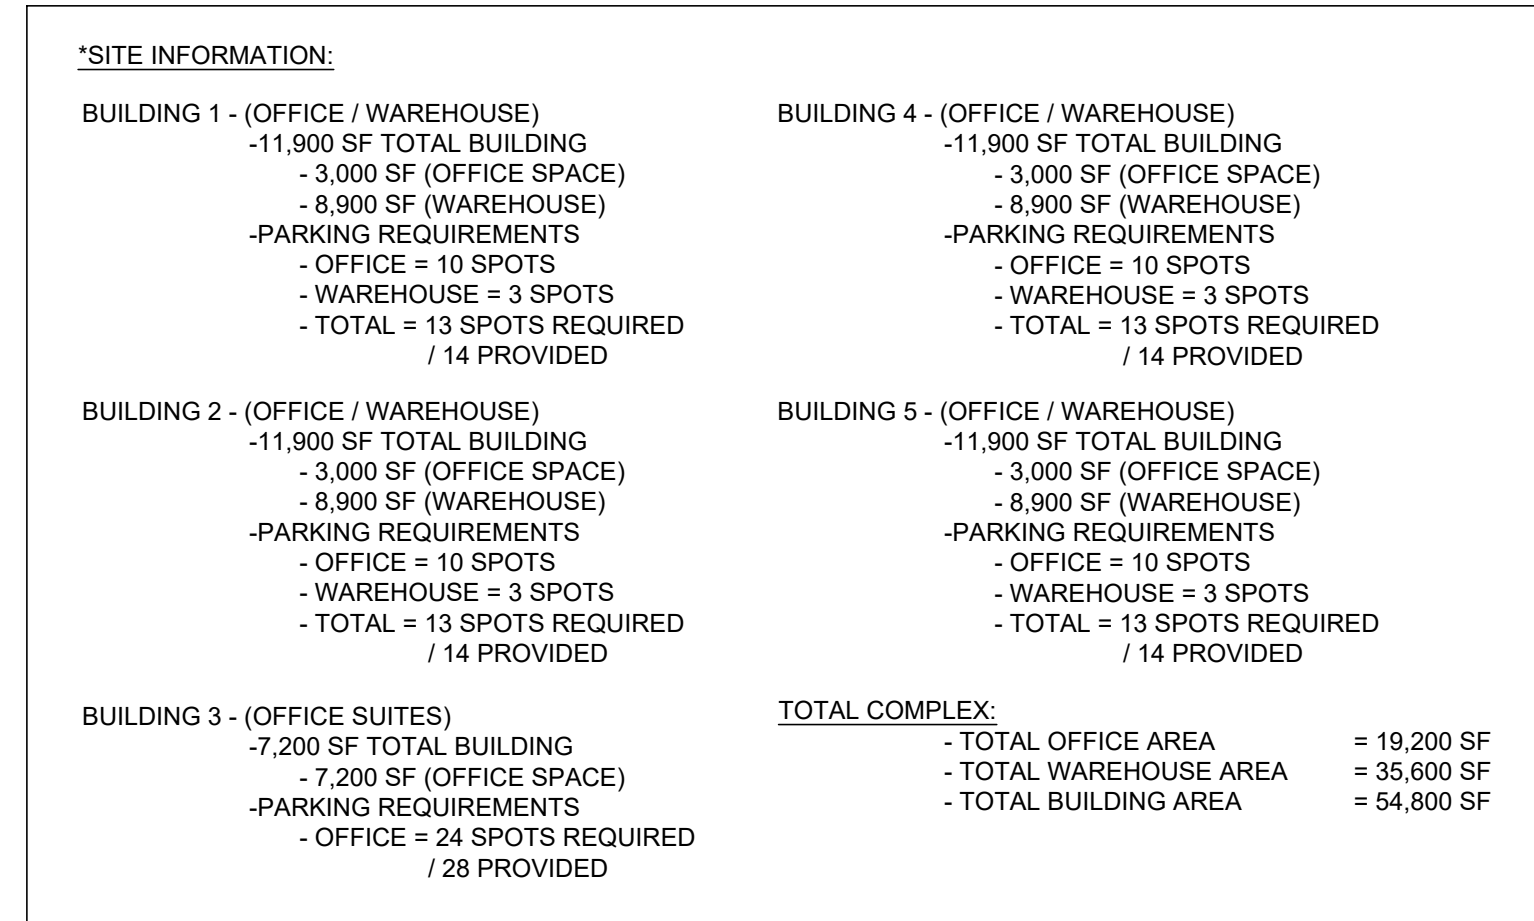

1/32"=1'-0"	1
-------------	---