


RCP LEGEND

- Diagram illustrating the layout of a room with various lighting and ventilation fixtures. The room is a rectangle with a door on the left wall and a window on the right wall. The fixtures are labeled as follows:


 - 2x4 RECESSED FLUORESCENT**: Located near the top right corner, adjacent to the door.
 - RECESSED CAN**: Located near the top center of the room.
 - DIFFUSER**: Located near the top left corner.
 - EXHAUST FAN**: Located on the left wall, below the diffuser.
 - EXIT LIGHT**: Located on the left wall, below the exhaust fan.
 - EMERGENCY LIGHT**: Located on the bottom left wall.
 - RETURN AIR**: Located near the top right corner, adjacent to the door, indicated by a square with 'R' and 'A'.
 - SPRINKLER HEAD**: Located in the center of the room, indicated by a solid black circle.
 - GYPSUM BOARD**: Located on the bottom right wall.
 - LAY IN CEILING AND GRID**: Located on the bottom left wall.

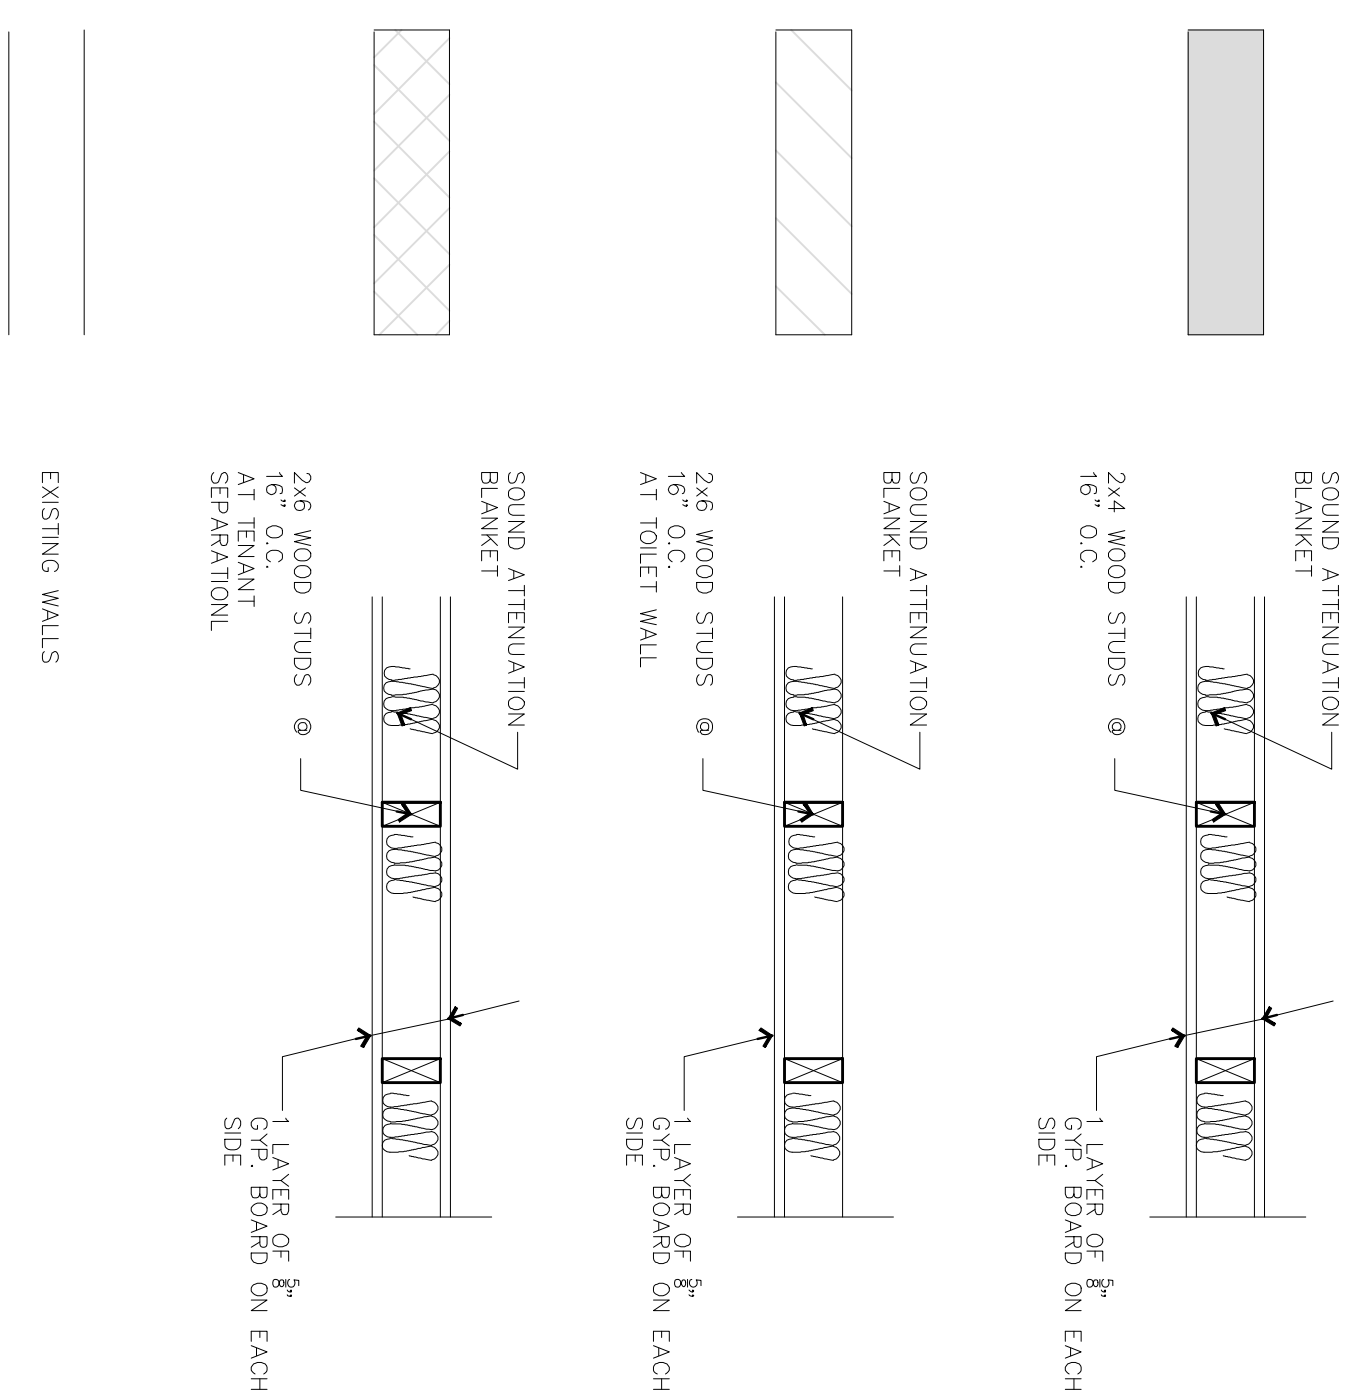

3 WALL TYPES


SCALE: 1" = 1'-0"

-
- PAINTED HOLLOW METAL
DOOR FRAME CASED
OPENING
AT BREAK ROOM
- 3'-0"
- 7'-0"
- PAINTED HOLLOW METAL
DOOR FRAME AND PAINTED
SOLID CORE WOOD DOOR
ALL DOORS EXCEPT TANNING,
- 3'-0"
- 7'-0"
- PAINTED HOLLOW METAL
DOOR FRAME AND PAINTED
SOLID CORE WOOD FRENCH
DOOR
AT TANNING AND HYDRATION
- 4'-0"
- 7'-0"

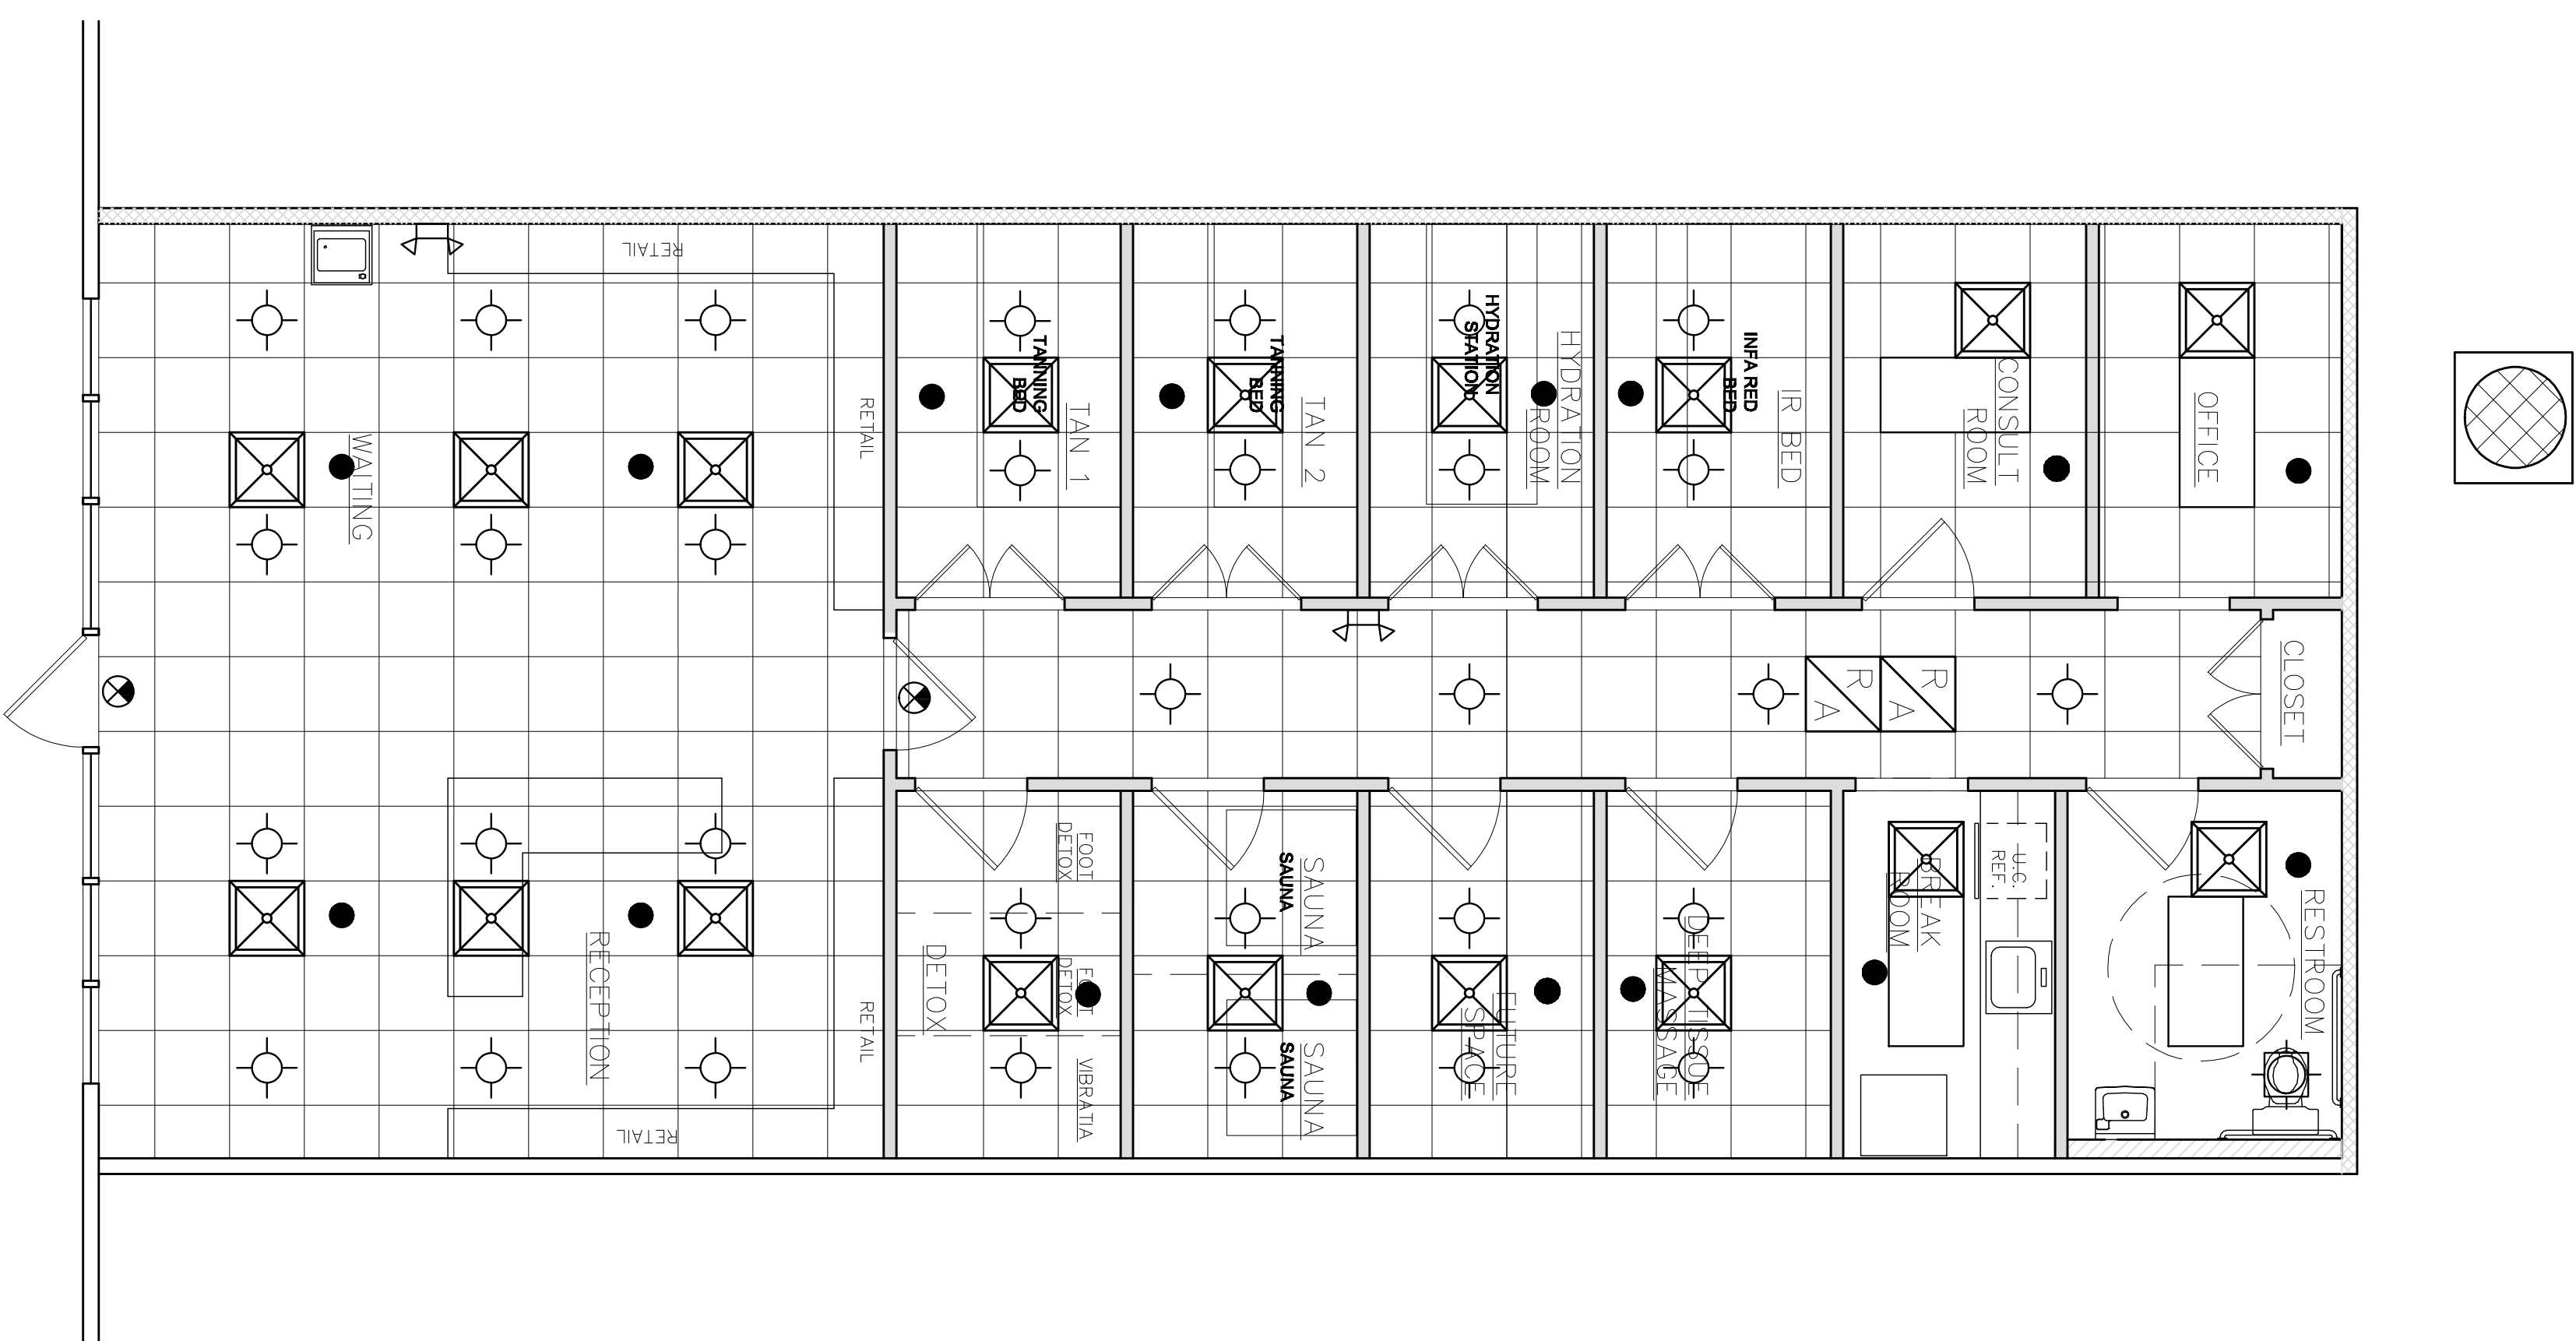

1 FLOOR PLAN

SCALE: 1/4" = 1'-0"

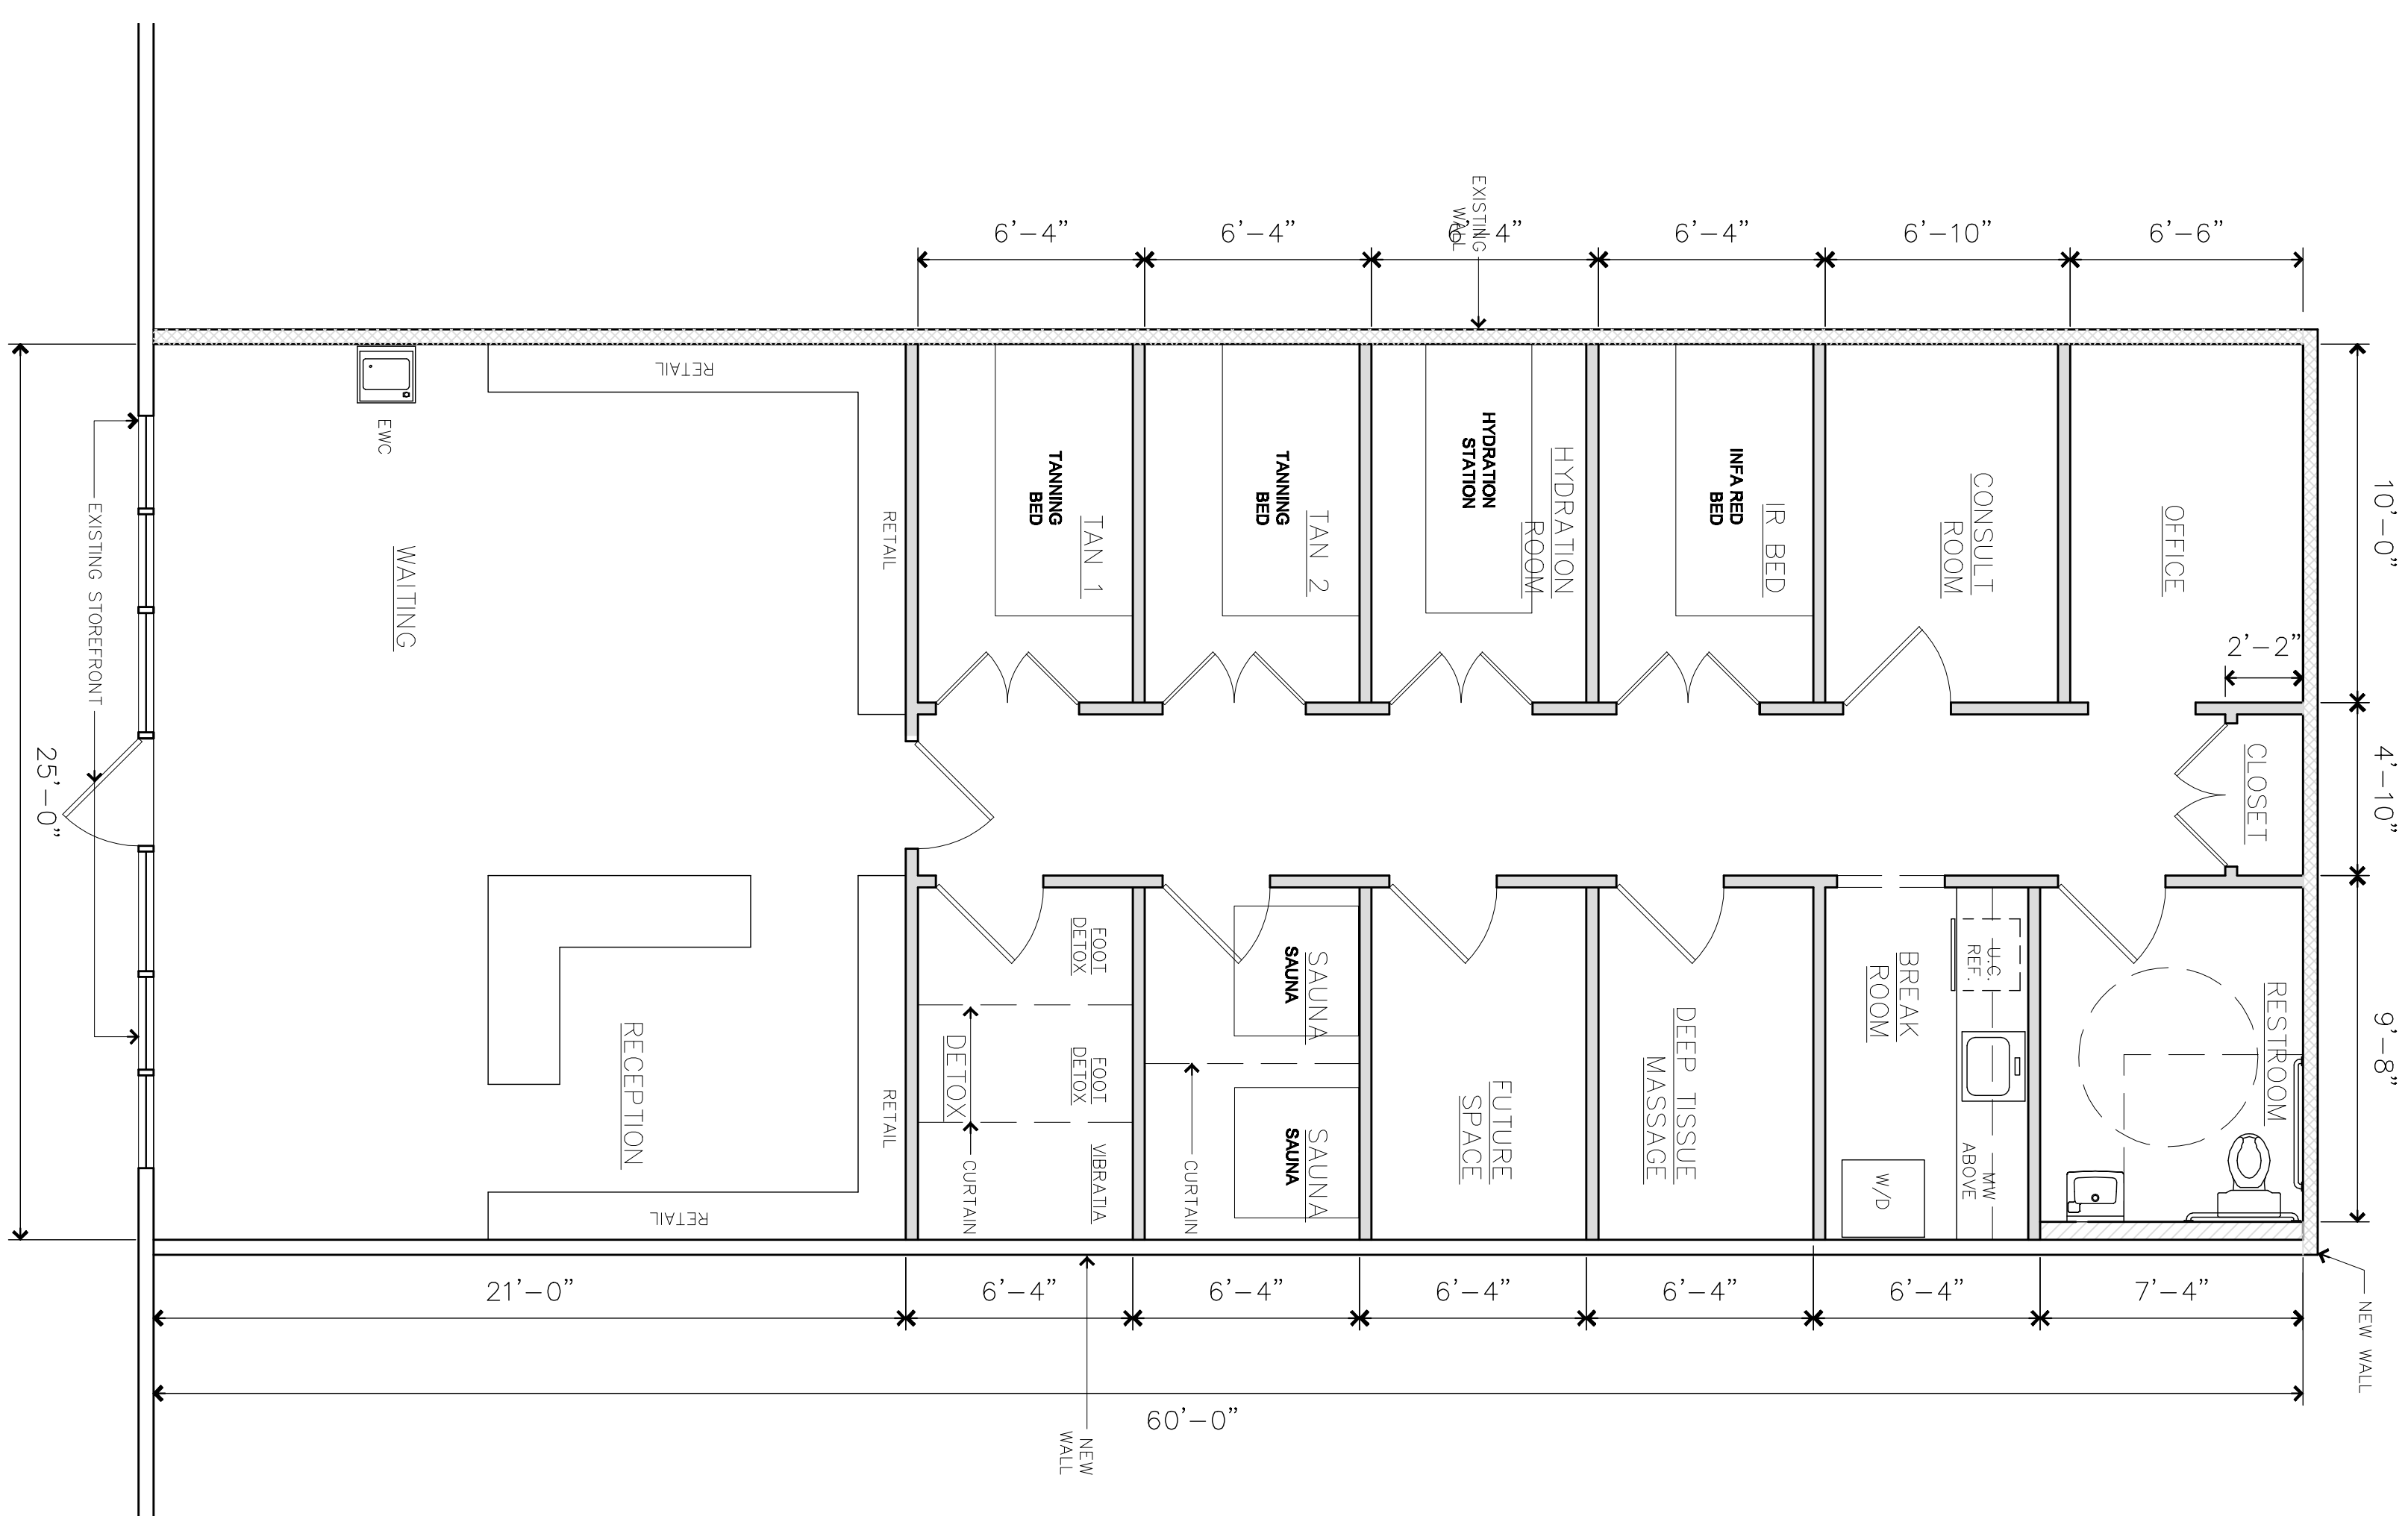

2 REFLECTED CEILING PLAN

SCALE: 1/4" = 1'-0"

